



DANGER

Danger of electrical shock, burns or death. Always remove all power sources before attempting any repair, service or diagnostic work. Power can be present from shore power, generator, inverter or battery. All power sources must be disabled and secured before performing any service.








CAUTION

If you lack the skills, tools or equipment to perform diagnostic or repair work leave such work to an authorized Winnebago Industries dealer or other qualified shop.

DRAWING NO.	MODEL	SHEETS
174974-01	224V	1,2,3,4,11
174974-02	226Q	5,6,7,12
174974-03	231C	1,2,3,4,8,11
174974-04	231J	1,2,3,4,9,11
174974-05	231N	1,2,3,4,10,11

RELEASE	REV DATE	174974
REV ZONE	REVISION RECORD	DATE

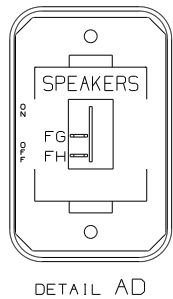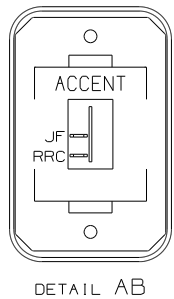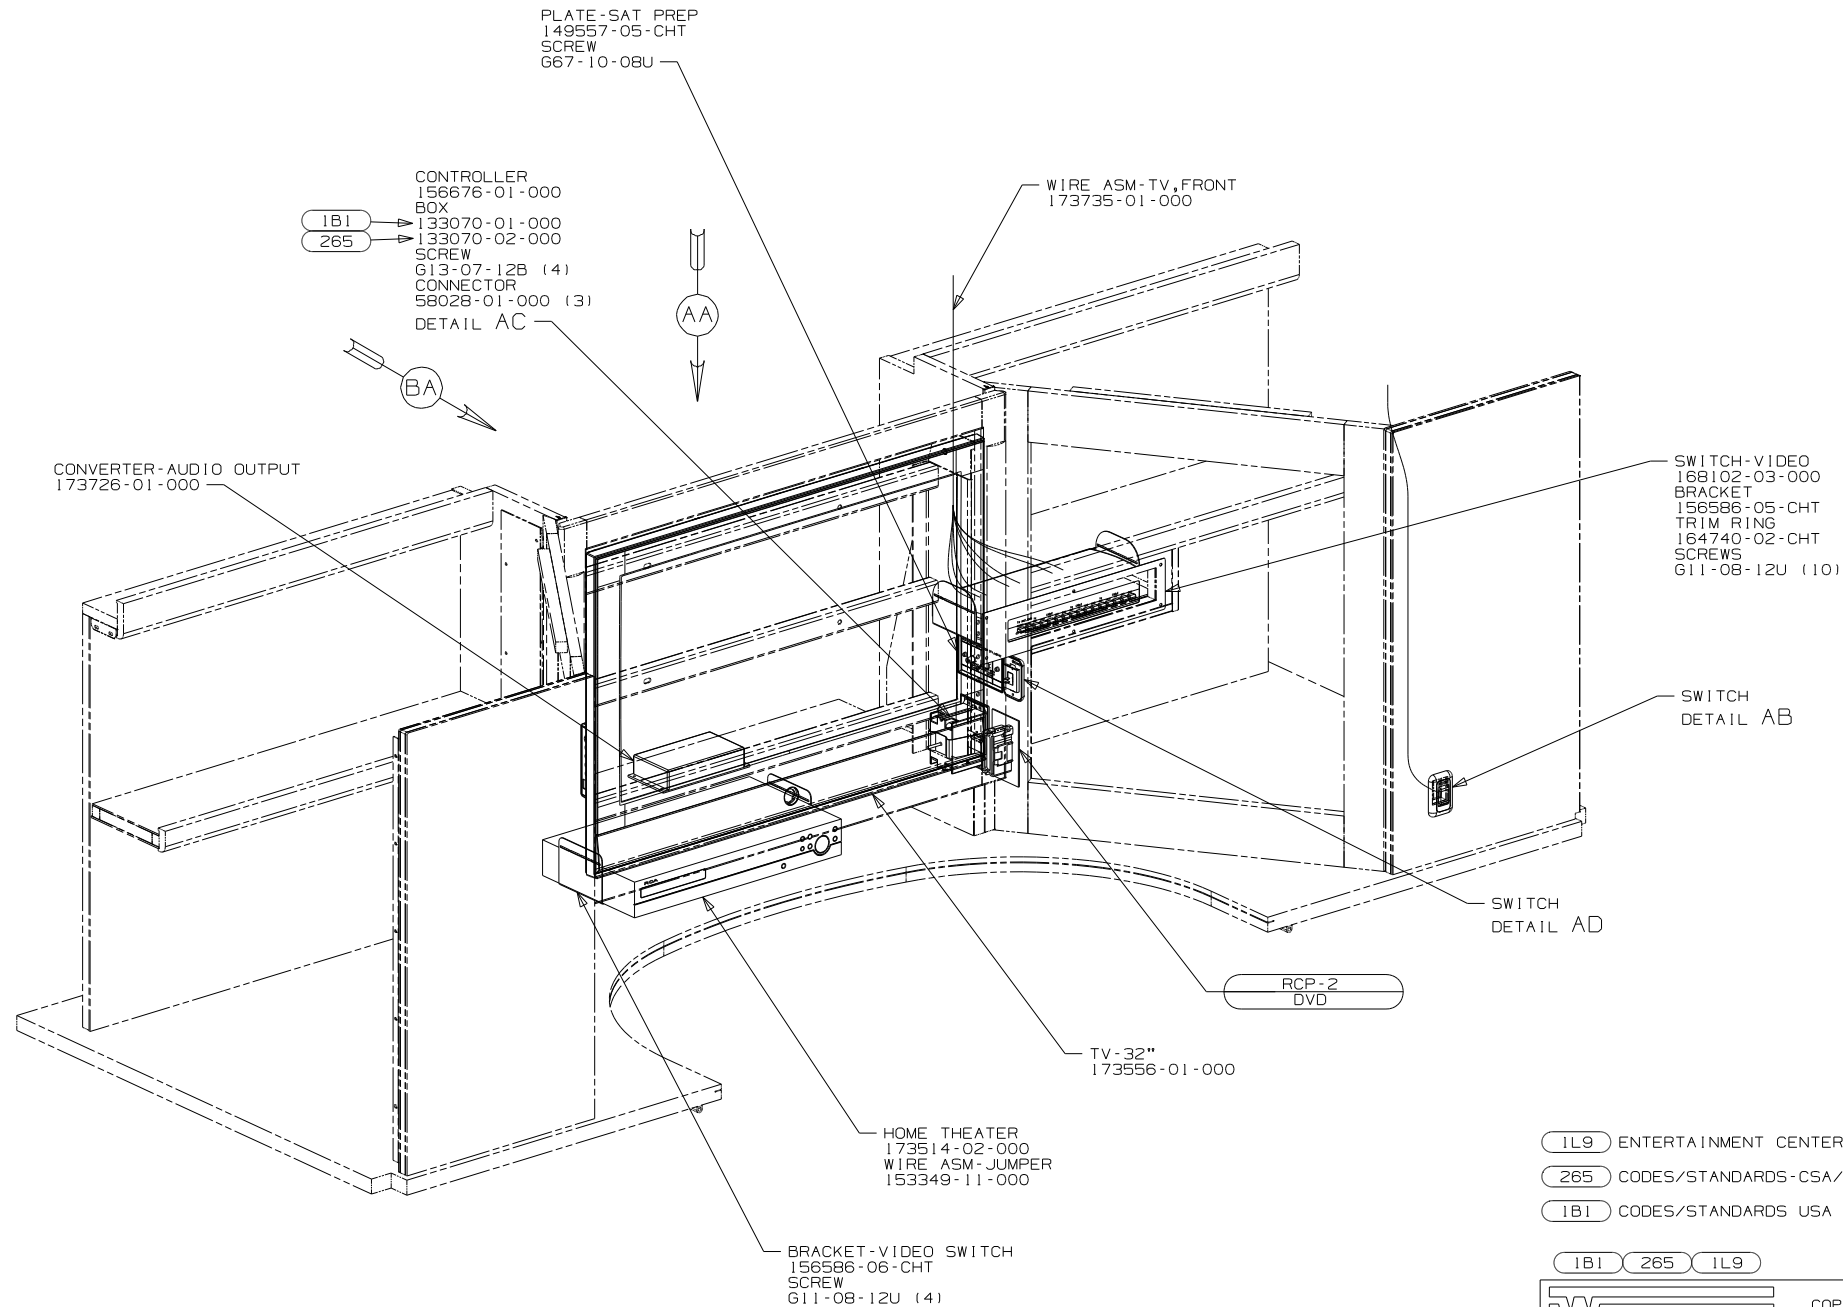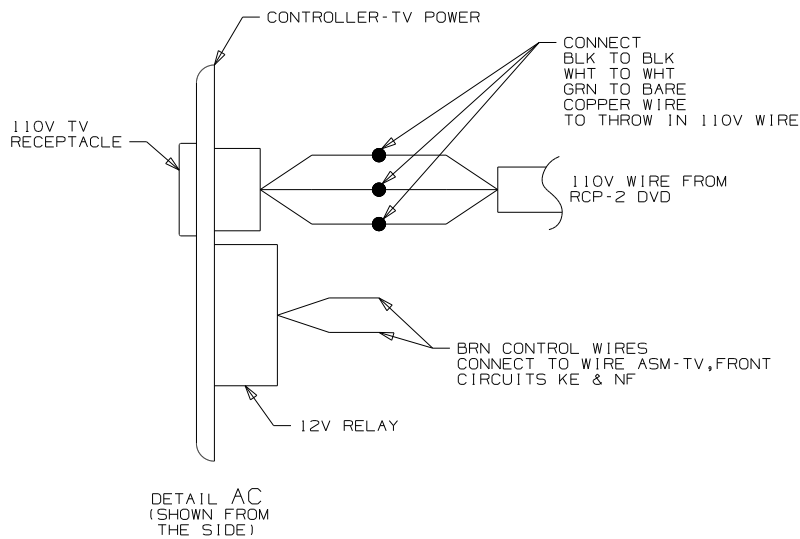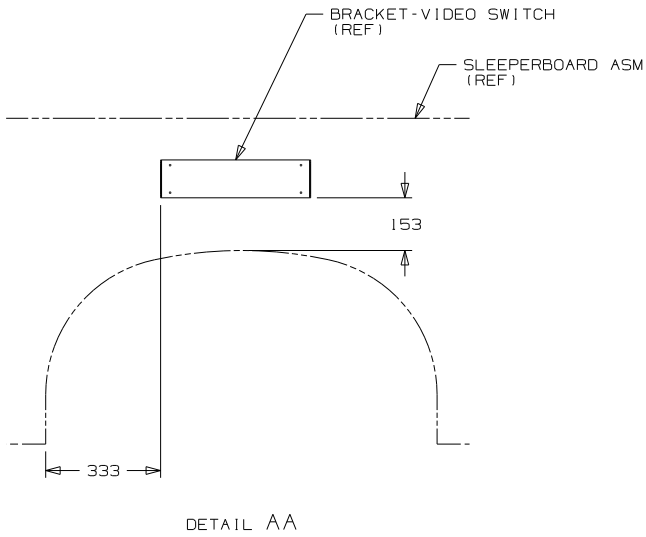

2. ALL WIRES TO BE SECURED WITH CLAMP 10495-01-000 OR CLIP 80734-01-000 EVERY 600MM. USE SCREW 667-10-12B UNLESS OTHERWISE SPECIFIED.
1. 110V WIRE TO BE CLAMPED WITH CLAMP 10497-05-000 WITHIN 200MM OF OUTLET BOXES. USE SCREW 667-10-12B.

NOTES:

FOR ELECTRICAL TORQUE SPECIFICATIONS SEE DWG NO. 128783-01-000


FOR ELECTRICAL CALLOUTS SEE DWG NO. 121339-01-000

- IL9 ENTERTAINMENT CENTER-CABOVER
- 265 CODES/STANDARDS-CSA/CMVSS
- 1B1 CODES/STANDARDS USA

WINNEBAGO	COPYRIGHT 2010 WINNEBAGO INDUSTRIES, INC.
0 0 0 0 0 0 0 0 0 0	
DFTR	ORIG. DATE
CHKR	ALL DIMENSIONS ARE IN MILLIMETERS
P.E.	
M.E.	FIRST USED
DSNR	11 200-SERIES
UNSPECIFIED TOLERANCES ARE:	MATERIAL:
WHOLE DIM (X)	: 3
ONE-PLACE (X,X)	: 1.5
TWO-PLACE (X,XX)	: 0.50
ANGLE	: 1°
THIRD ANGLE PROJECTION	

DO NOT SCALE DRAWING

TITLE:	WIRING INSTL-TV/DVD
SHEET 1 OF 12	PART NO 174974
REF:	12/22/2010

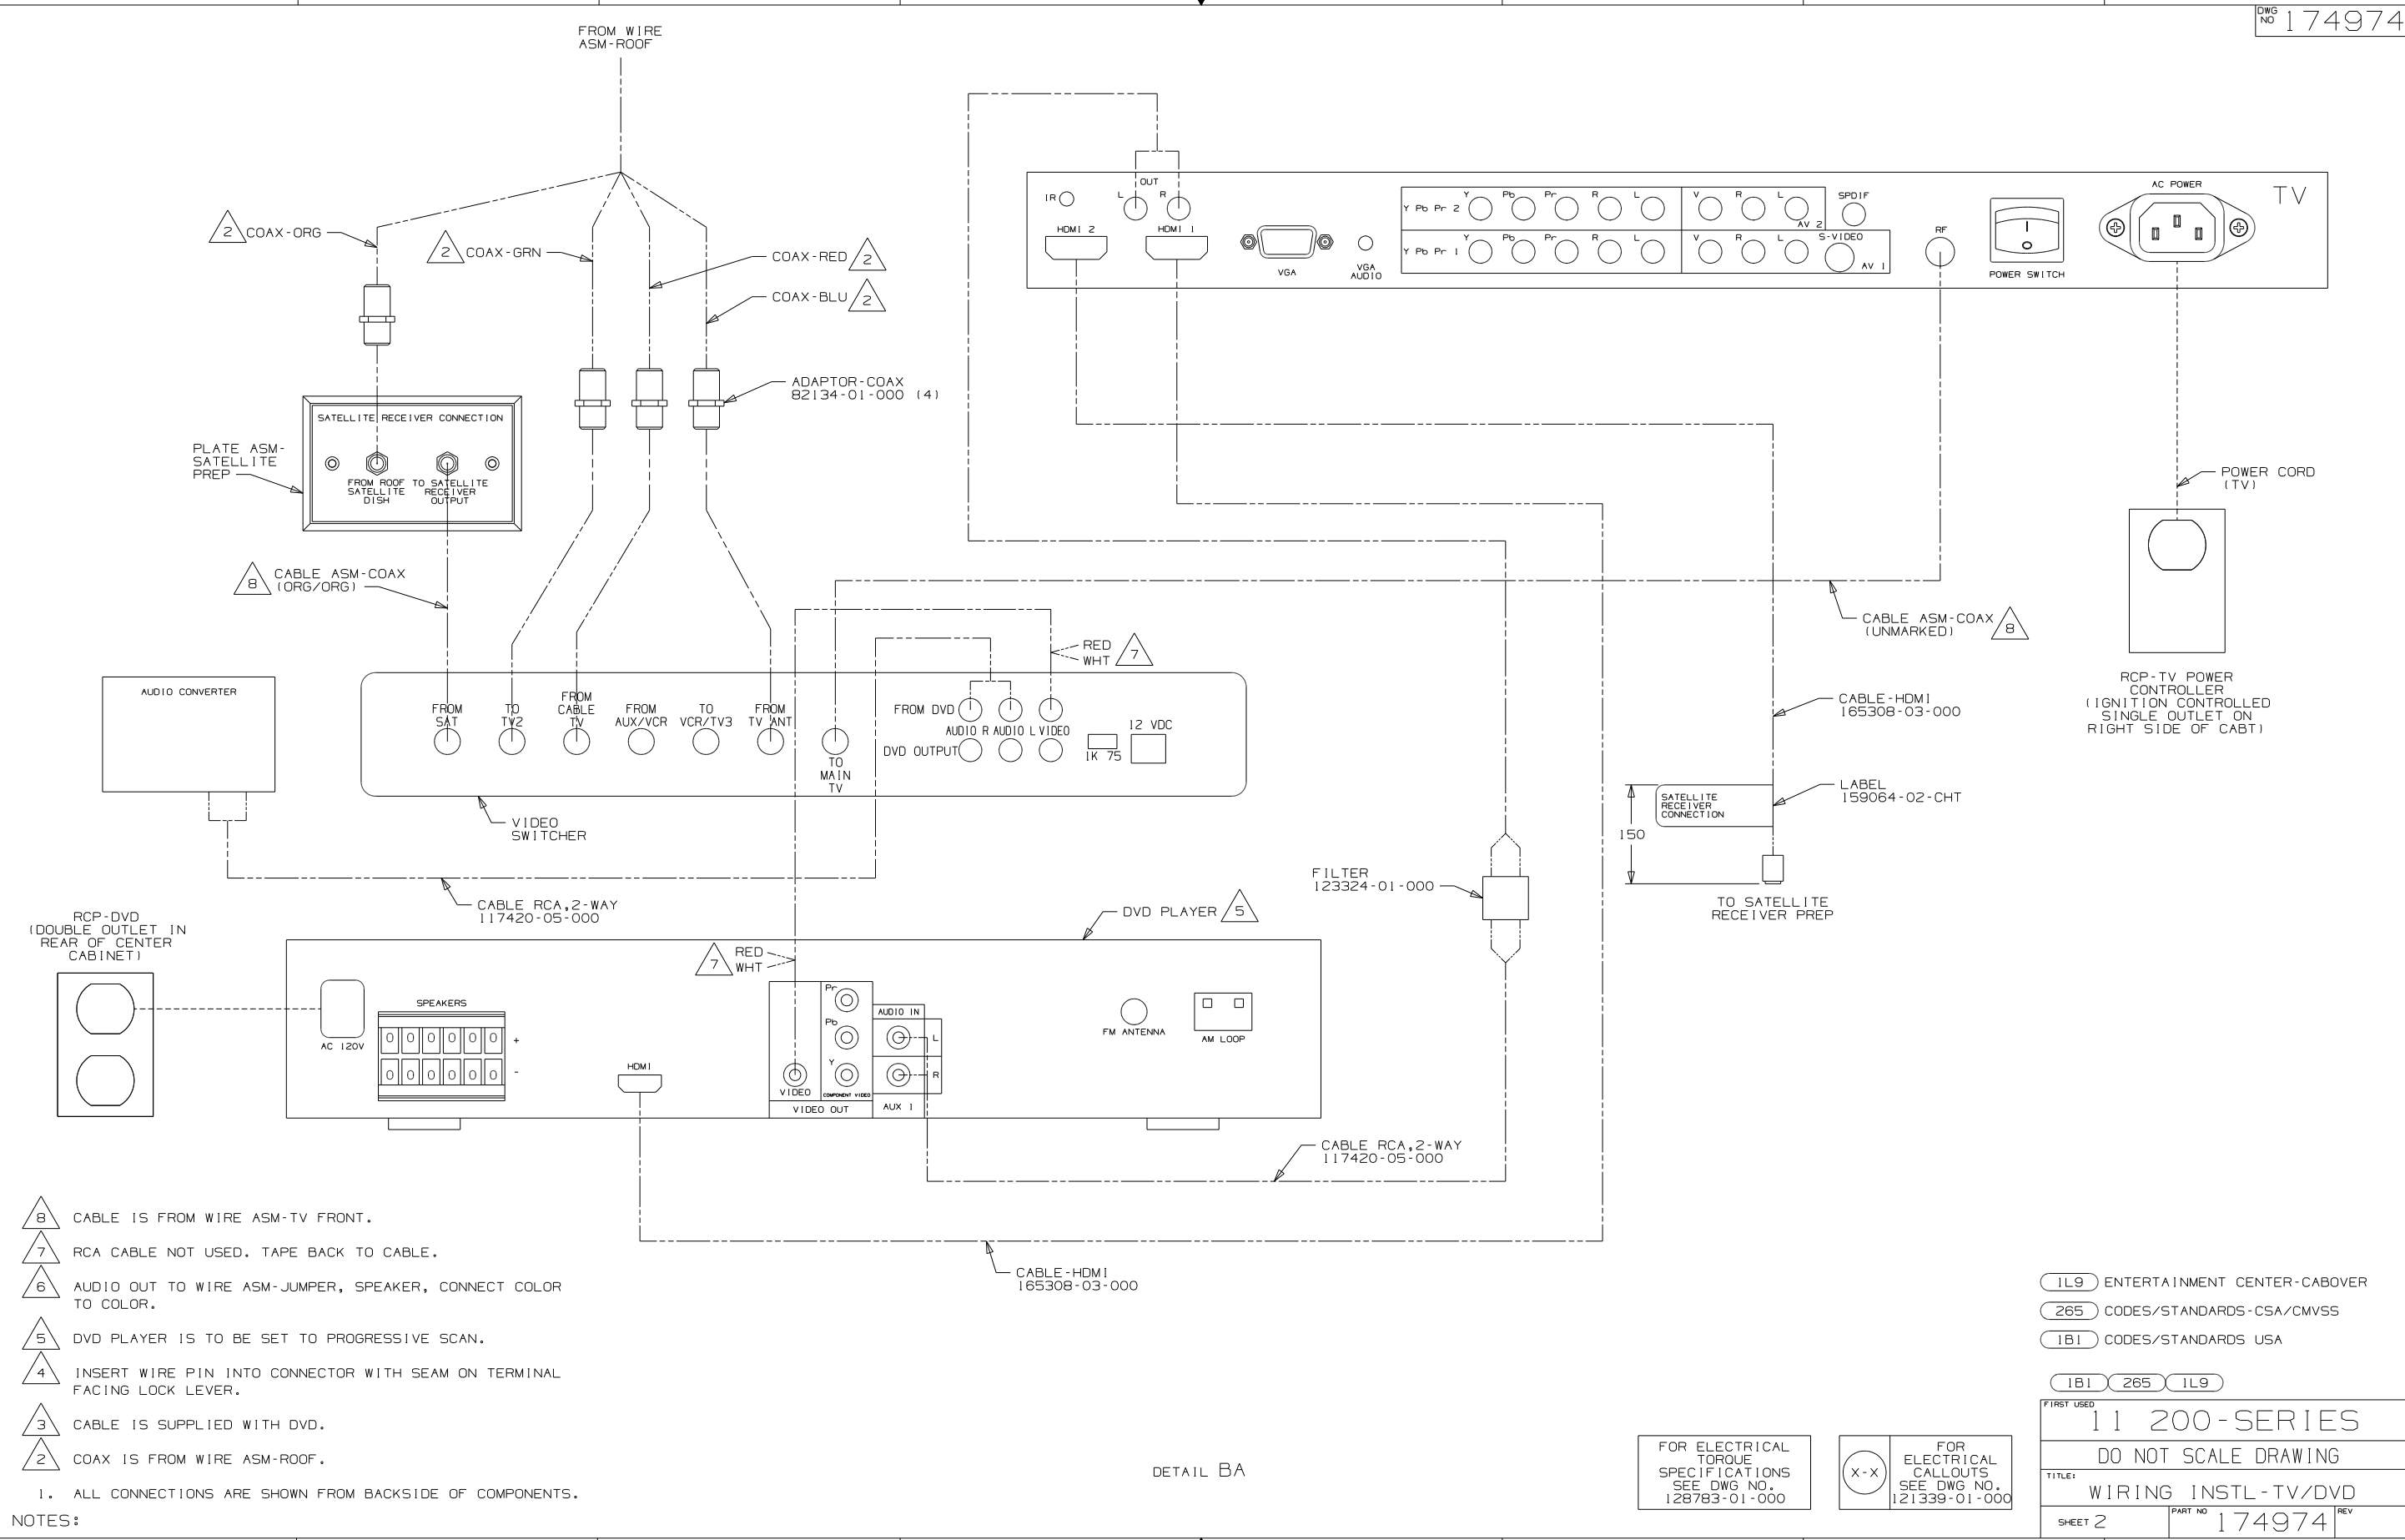

- 8 CABLE IS FROM WIRE ASM-TV FRONT.
- 7 RCA CABLE NOT USED. TAPE BACK TO CABLE.
- 6 AUDIO OUT TO WIRE ASM-JUMPER, SPEAKER, CONNECT COLOR TO COLOR.
- 5 DVD PLAYER IS TO BE SET TO PROGRESSIVE SCAN.
- 4 INSERT WIRE PIN INTO CONNECTOR WITH SEAM ON TERMINAL FACING LOCK LEVER.
- 3 CABLE IS SUPPLIED WITH DVD.
- 2 COAX IS FROM WIRE ASM-ROOF.

1. ALL CONNECTIONS ARE SHOWN FROM BACKSIDE OF COMPONENTS.

NOTES:


DETAIL BA

FOR ELECTRICAL
TORQUE
SPECIFICATIONS
SEE DWG NO.
128783-01-000



FOR
ELECTRICAL
CALLOUTS
SEE DWG NO.
121339-01-000

1L9 ENTERTAINMENT CENTER-CABOVER
265 CODES/STANDARDS-CSA/CMVSS
1B1 CODES/STANDARDS USA

1B1 265 1L9
11 200-SERIES
DO NOT SCALE DRAWING
TITLE: WIRING INSTL-TV/DVD
SHEET 2 PART NO 174974 REV
12/22/2010

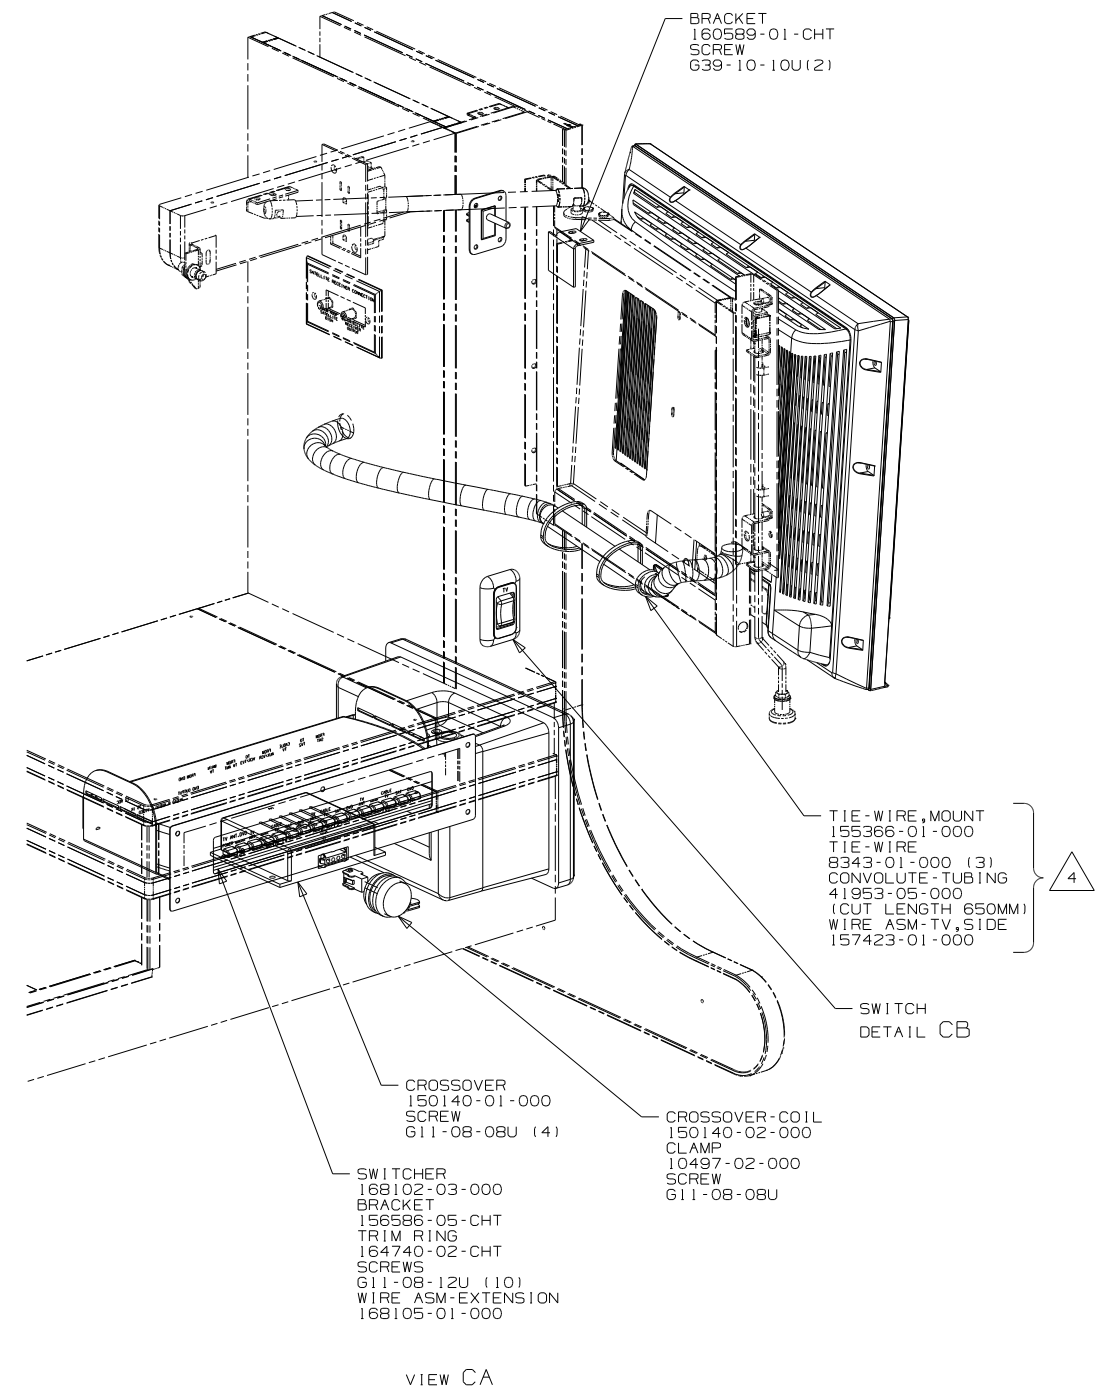

VIEW CA

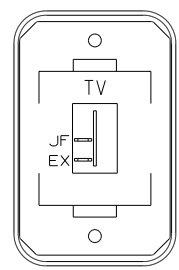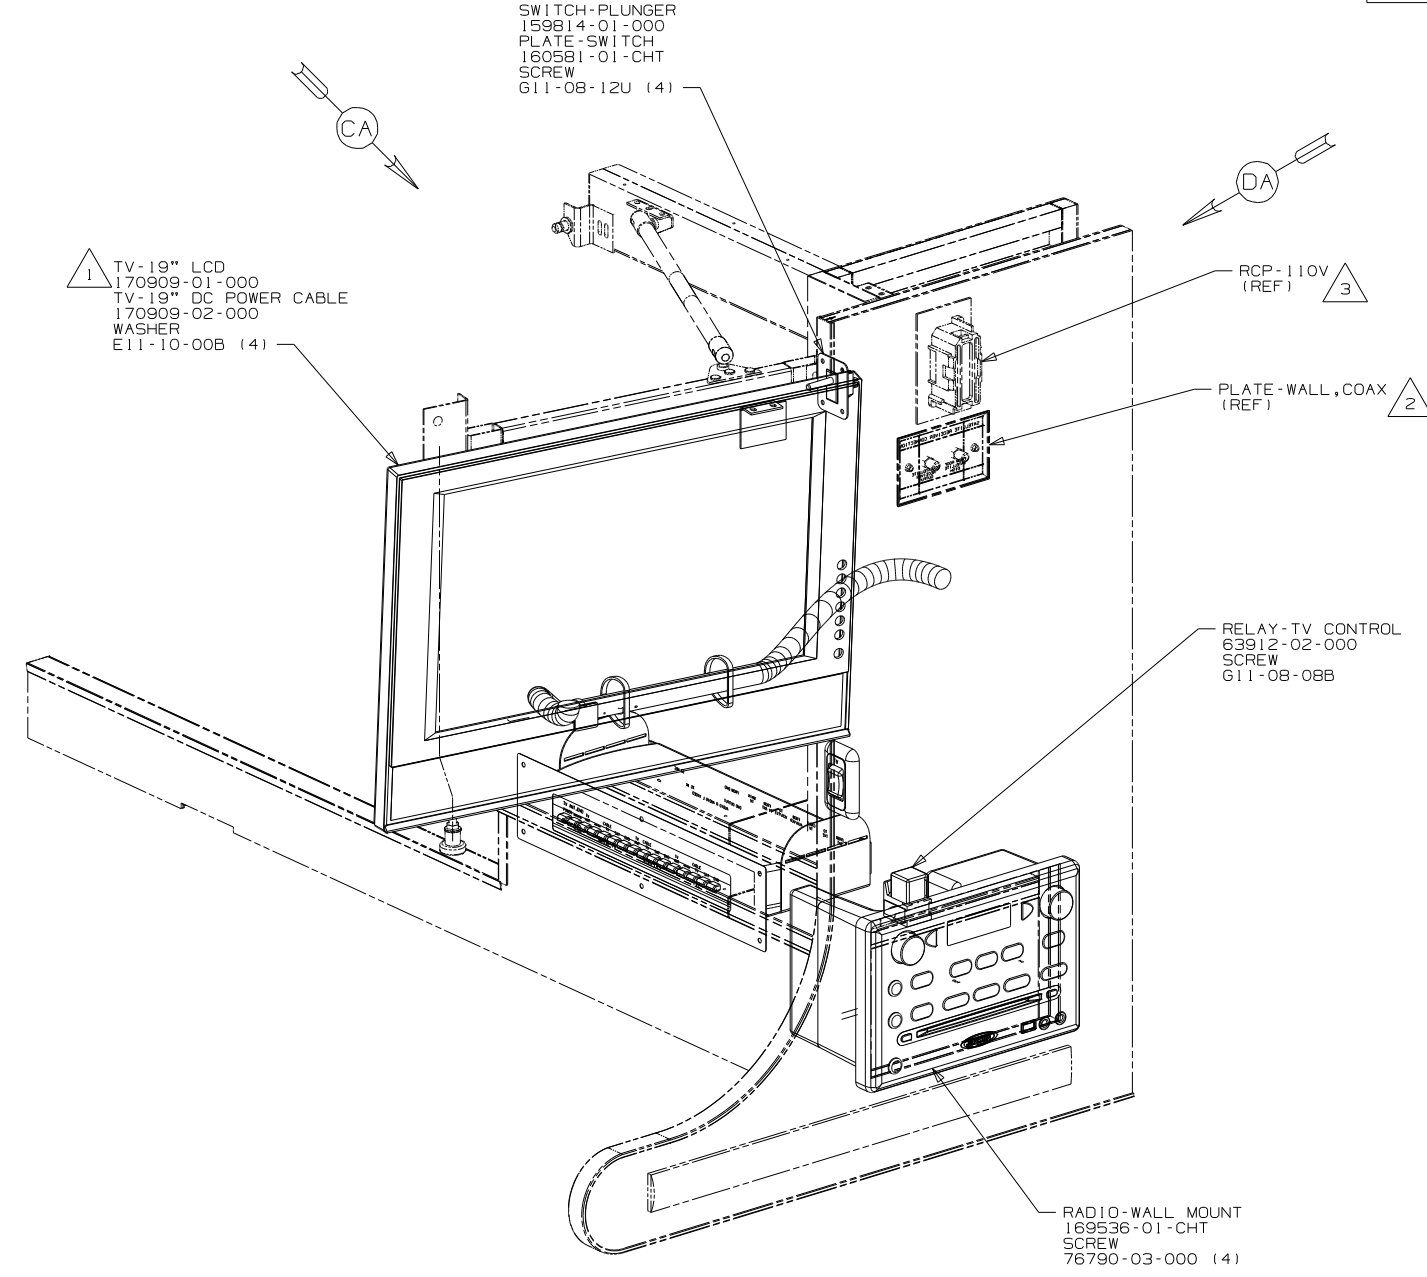

DETAIL CB

SWITCH-ROCKER
135740-01-CHT
SWITCH-BASE
135741-01-CHT
SWITCH-BEZEL
135742-45-CHT
SCREW
G11-08-08U (2)


- NOTES:
- 4 COVER WIRES, COAX, AND RCA-CABLES THAT ARE ROUTED TO THE TV WITH CONVOLUTE-TUBING AND SECURE TO TV-SUPPORT WITH TIE-WIRE.
 - 3 SEE WIRING INSTL-BODY, 110V FOR ADDITIONAL INFORMATION.
 - 2 SEE WIRING INSTL-BODY, 12V FOR ADDITIONAL INFORMATION.
 - 1 USE SCREWS SUPPLIED WITH TV.

FOR ELECTRICAL
TORQUE
SPECIFICATIONS
SEE DWG NO.
128783-01-000

FOR ELECTRICAL
CALLOUTS
SEE DWG NO.
121339-01-000

IMK TV-19"DC, STEREO SYS, VDEO SEL
265 CODES/STANDARDS-CSA/CMVSS
1B1 CODES/STANDARDS USA

FIRST USED	
11 200-SERIES	
DO NOT SCALE DRAWING	
TITLE: WIRING INSTL-TV/DVD	
SHEET 3	PART NO 174974 REV

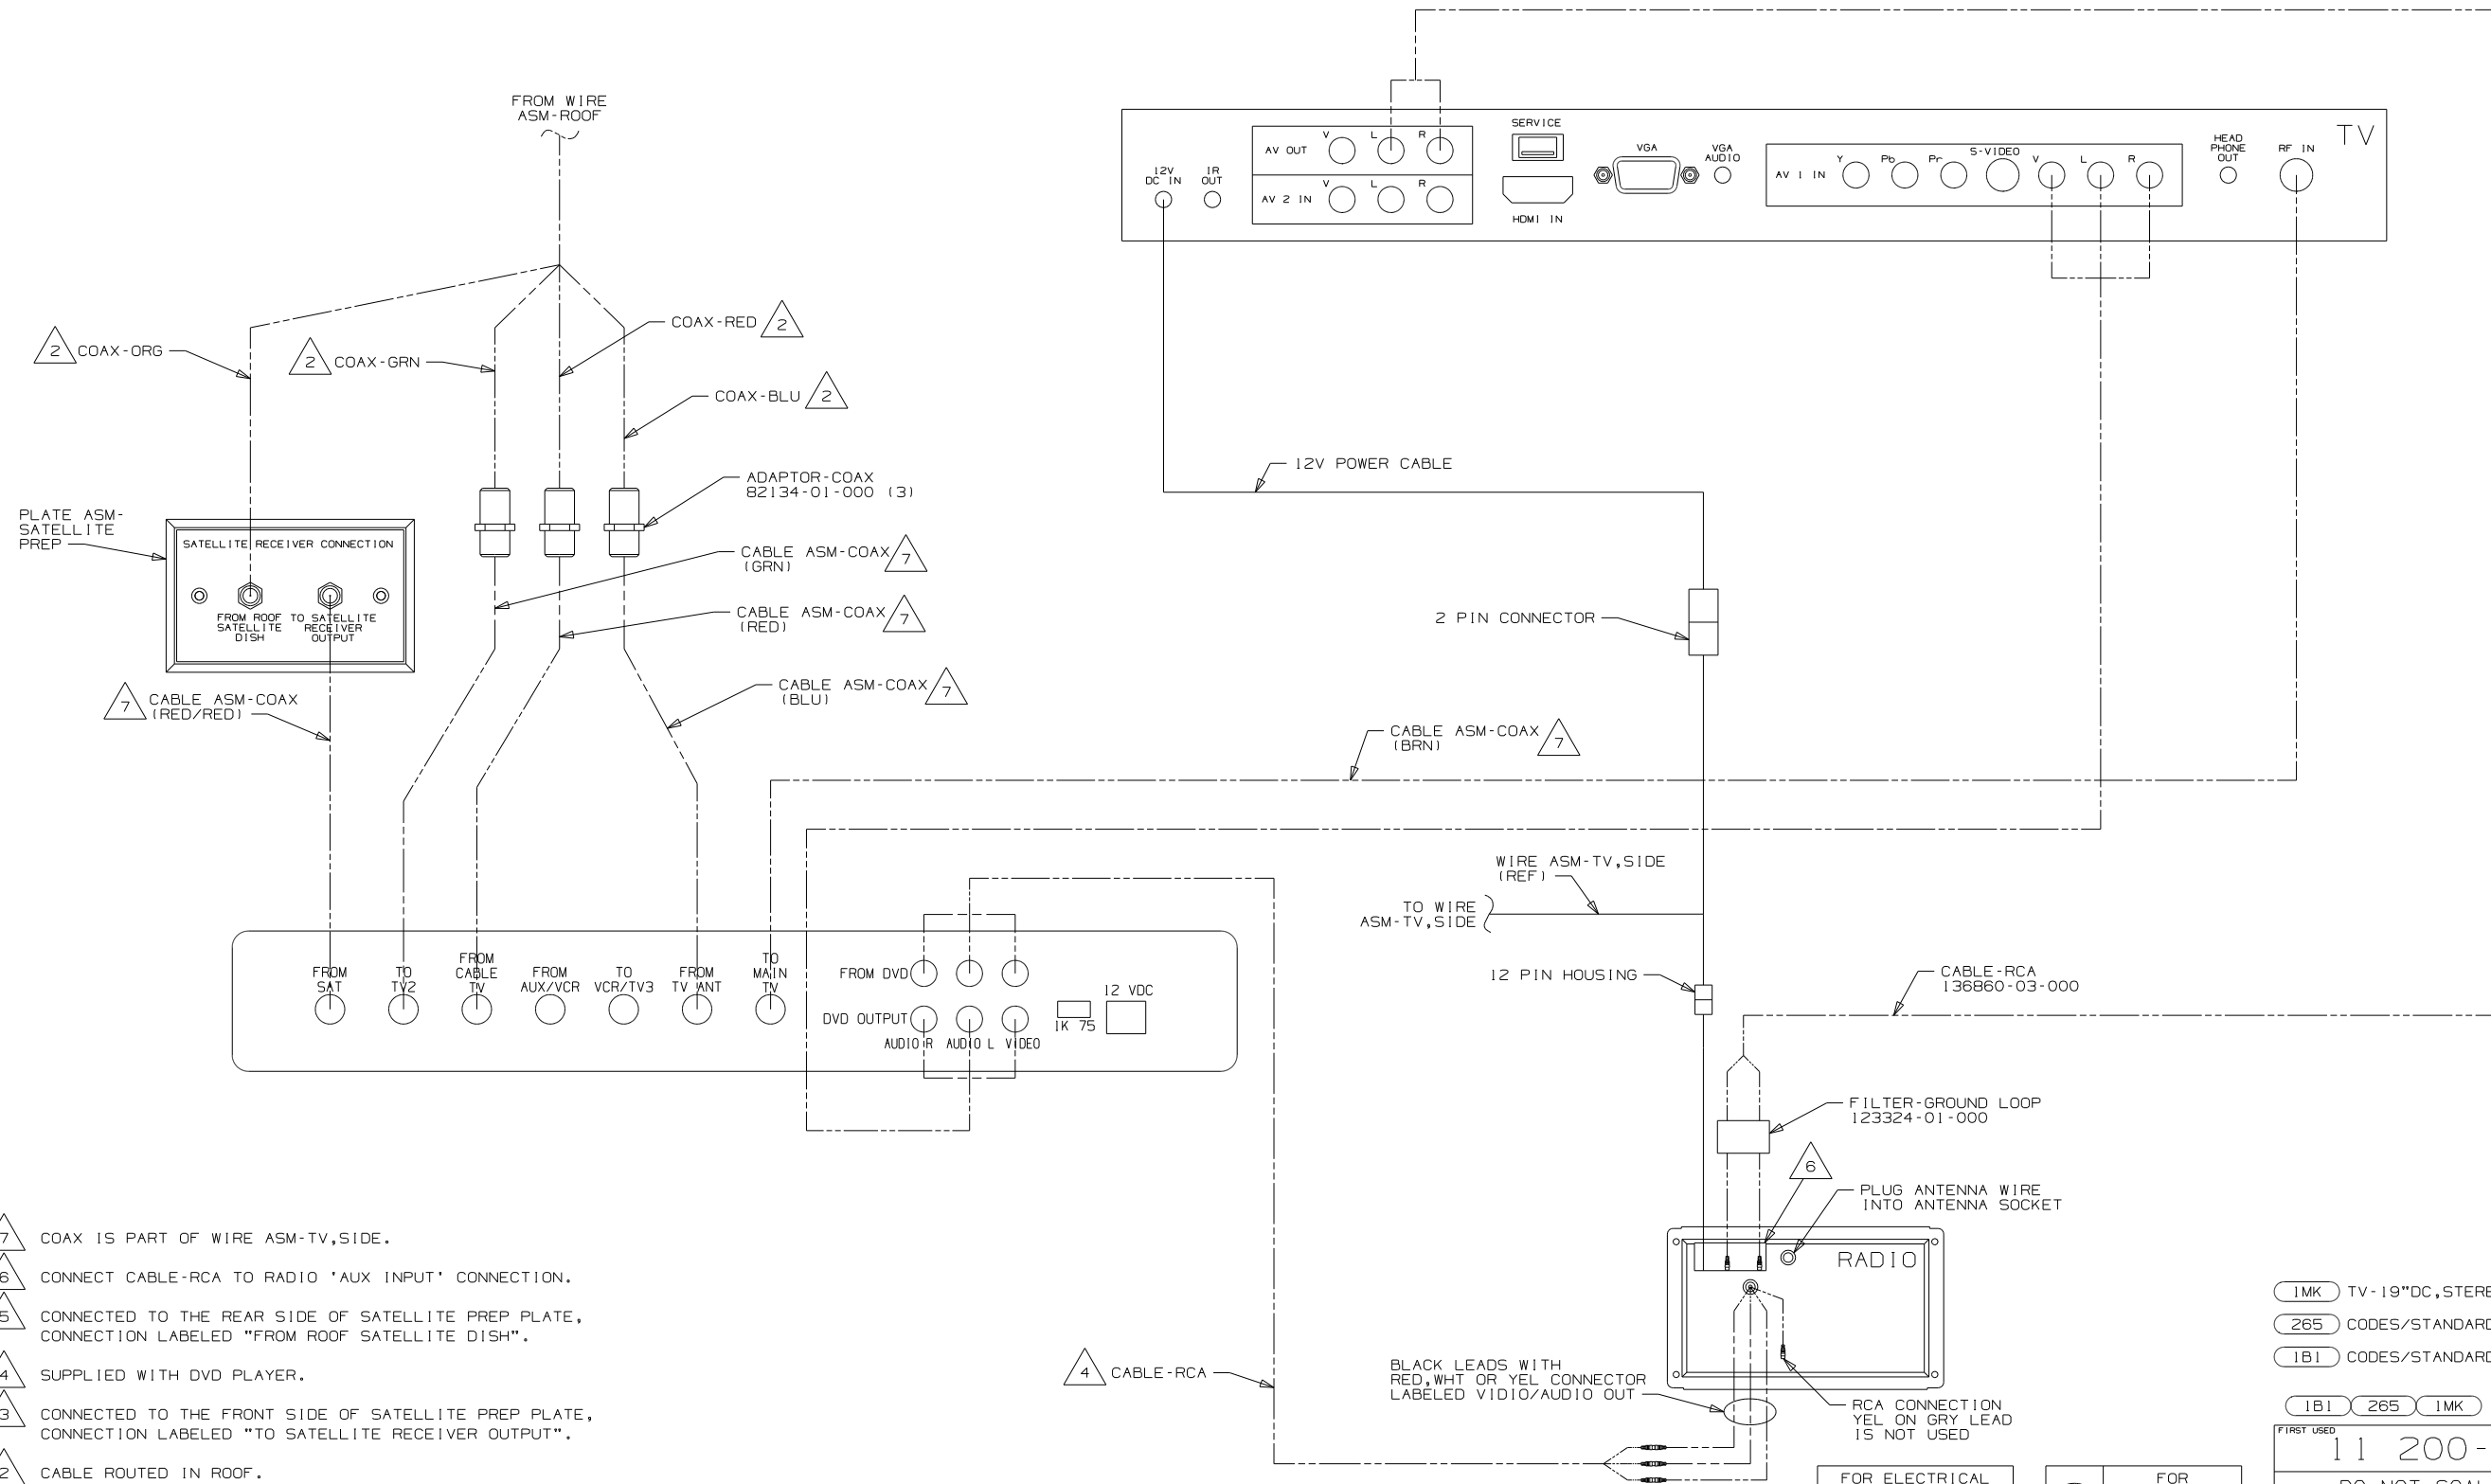

- 7 COAX IS PART OF WIRE ASM-TV,SIDE.
- 6 CONNECT CABLE-RCA TO RADIO 'AUX INPUT' CONNECTION.
- 5 CONNECTED TO THE REAR SIDE OF SATELLITE PREP PLATE, CONNECTION LABELED "FROM ROOF SATELLITE DISH".
- 4 SUPPLIED WITH DVD PLAYER.
- 3 CONNECTED TO THE FRONT SIDE OF SATELLITE PREP PLATE, CONNECTION LABELED "TO SATELLITE RECEIVER OUTPUT".
- 2 CABLE ROUTED IN ROOF.
- 1 CONNECTED TO THE REAR SIDE OF SATELLITE PREP PLATE, CONNECTION LABELED "TO SATELLITE RECEIVER OUTPUT".

NOTES:


DETAIL DA

FOR ELECTRICAL
TORQUE
SPECIFICATIONS
SEE DWG NO.
128783-01-000

FOR
ELECTRICAL
CALLOUTS
SEE DWG NO.
121339-01-000

1MK TV-19"DC,STEREO SYS,VDEO SEL
265 CODES/STANDARDS-CSA/CMVSS
1B1 CODES/STANDARDS USA

FIRST USED		11 200-SERIES	
		DO NOT SCALE DRAWING	
TITLE:		WIRING INSTL-TV/DVD	
SHEET 4	PART NO	174974	REV

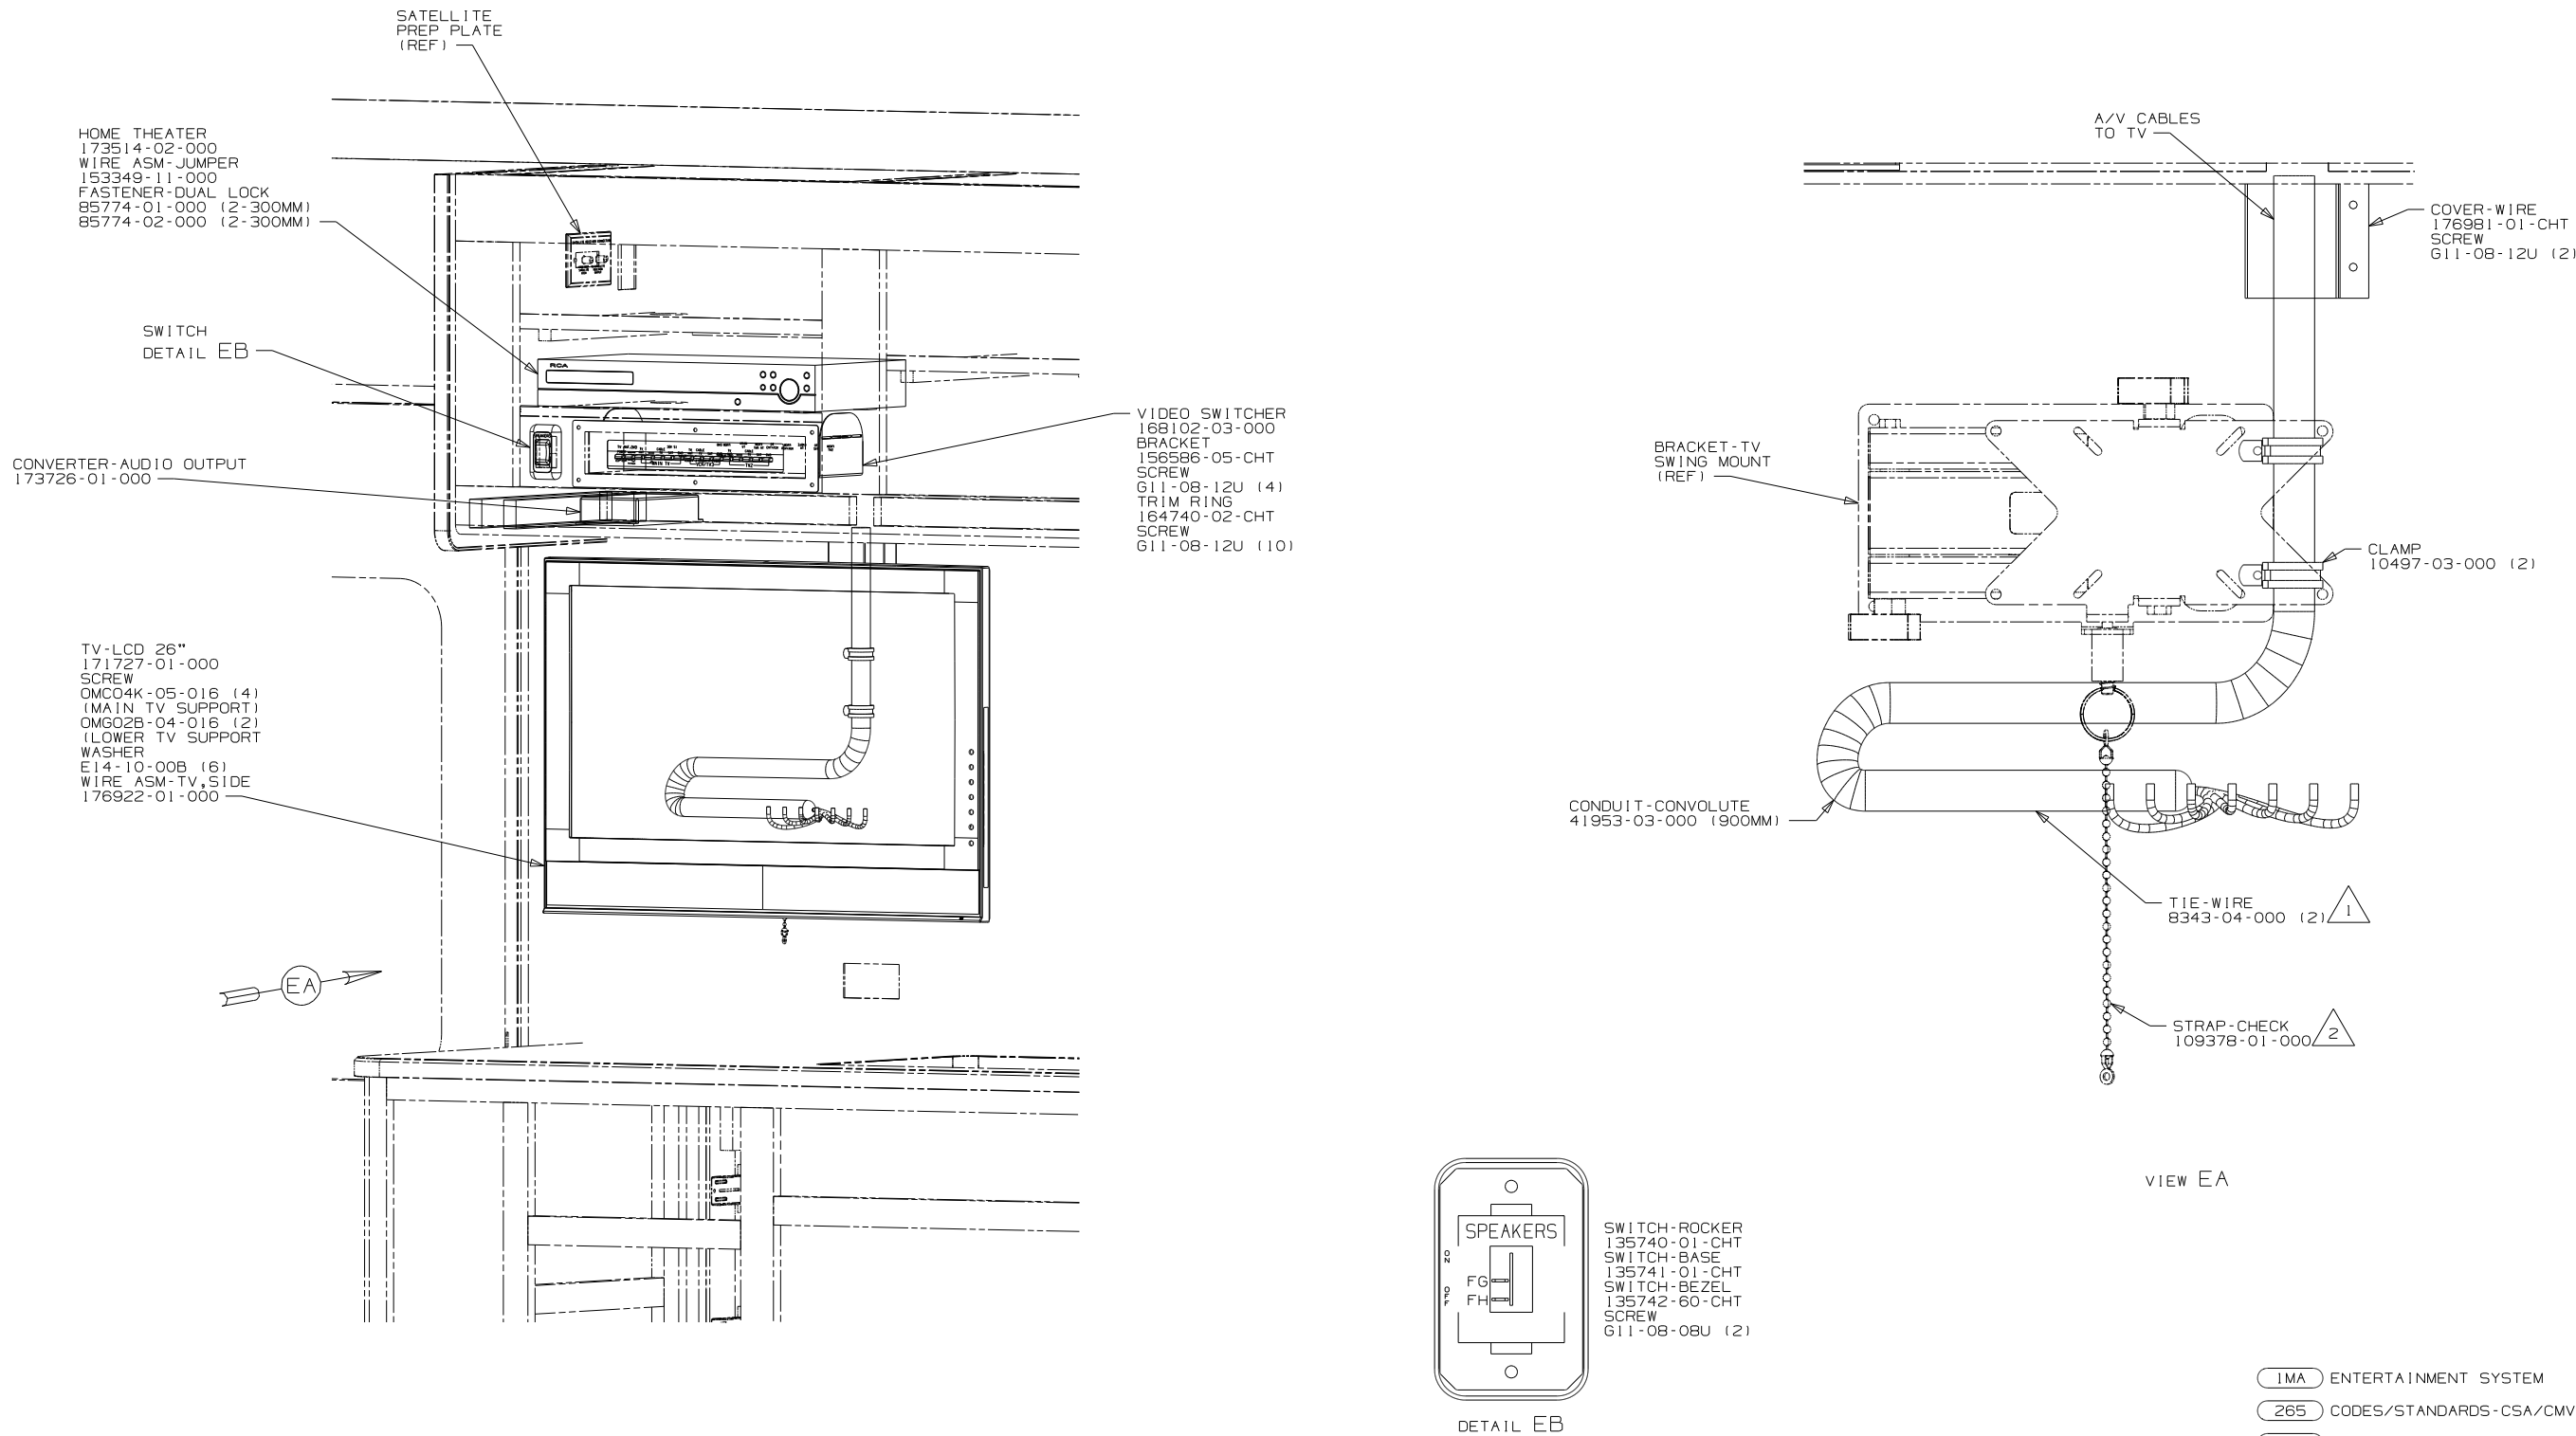

NOTES:

2 REPLACE CHAIN WITH STRAP.

1 USE HOLES ON PLATE-MOUNTING, TV TO ATTACH WIRE
ASM TO PLATE-MOUNTING, TV WITH WIRE TIES.

FOR ELECTRICAL
TORQUE
SPECIFICATIONS
SEE DWG NO.
128783-01-000

FOR
ELECTRICAL
CALLOUTS
SEE DWG NO.
121339-01-000

IMA ENTERTAINMENT SYSTEM

265 CODES/STANDARDS-CSA/CMVSS

1B1 CODES/STANDARDS USA

1B1 265 IMA

FIRST USED


11 200-SERIES

DO NOT SCALE DRAWING

TITLE:

WIRING INSTL-TV/DVD

SHEET 5 PART NO 174974 REV

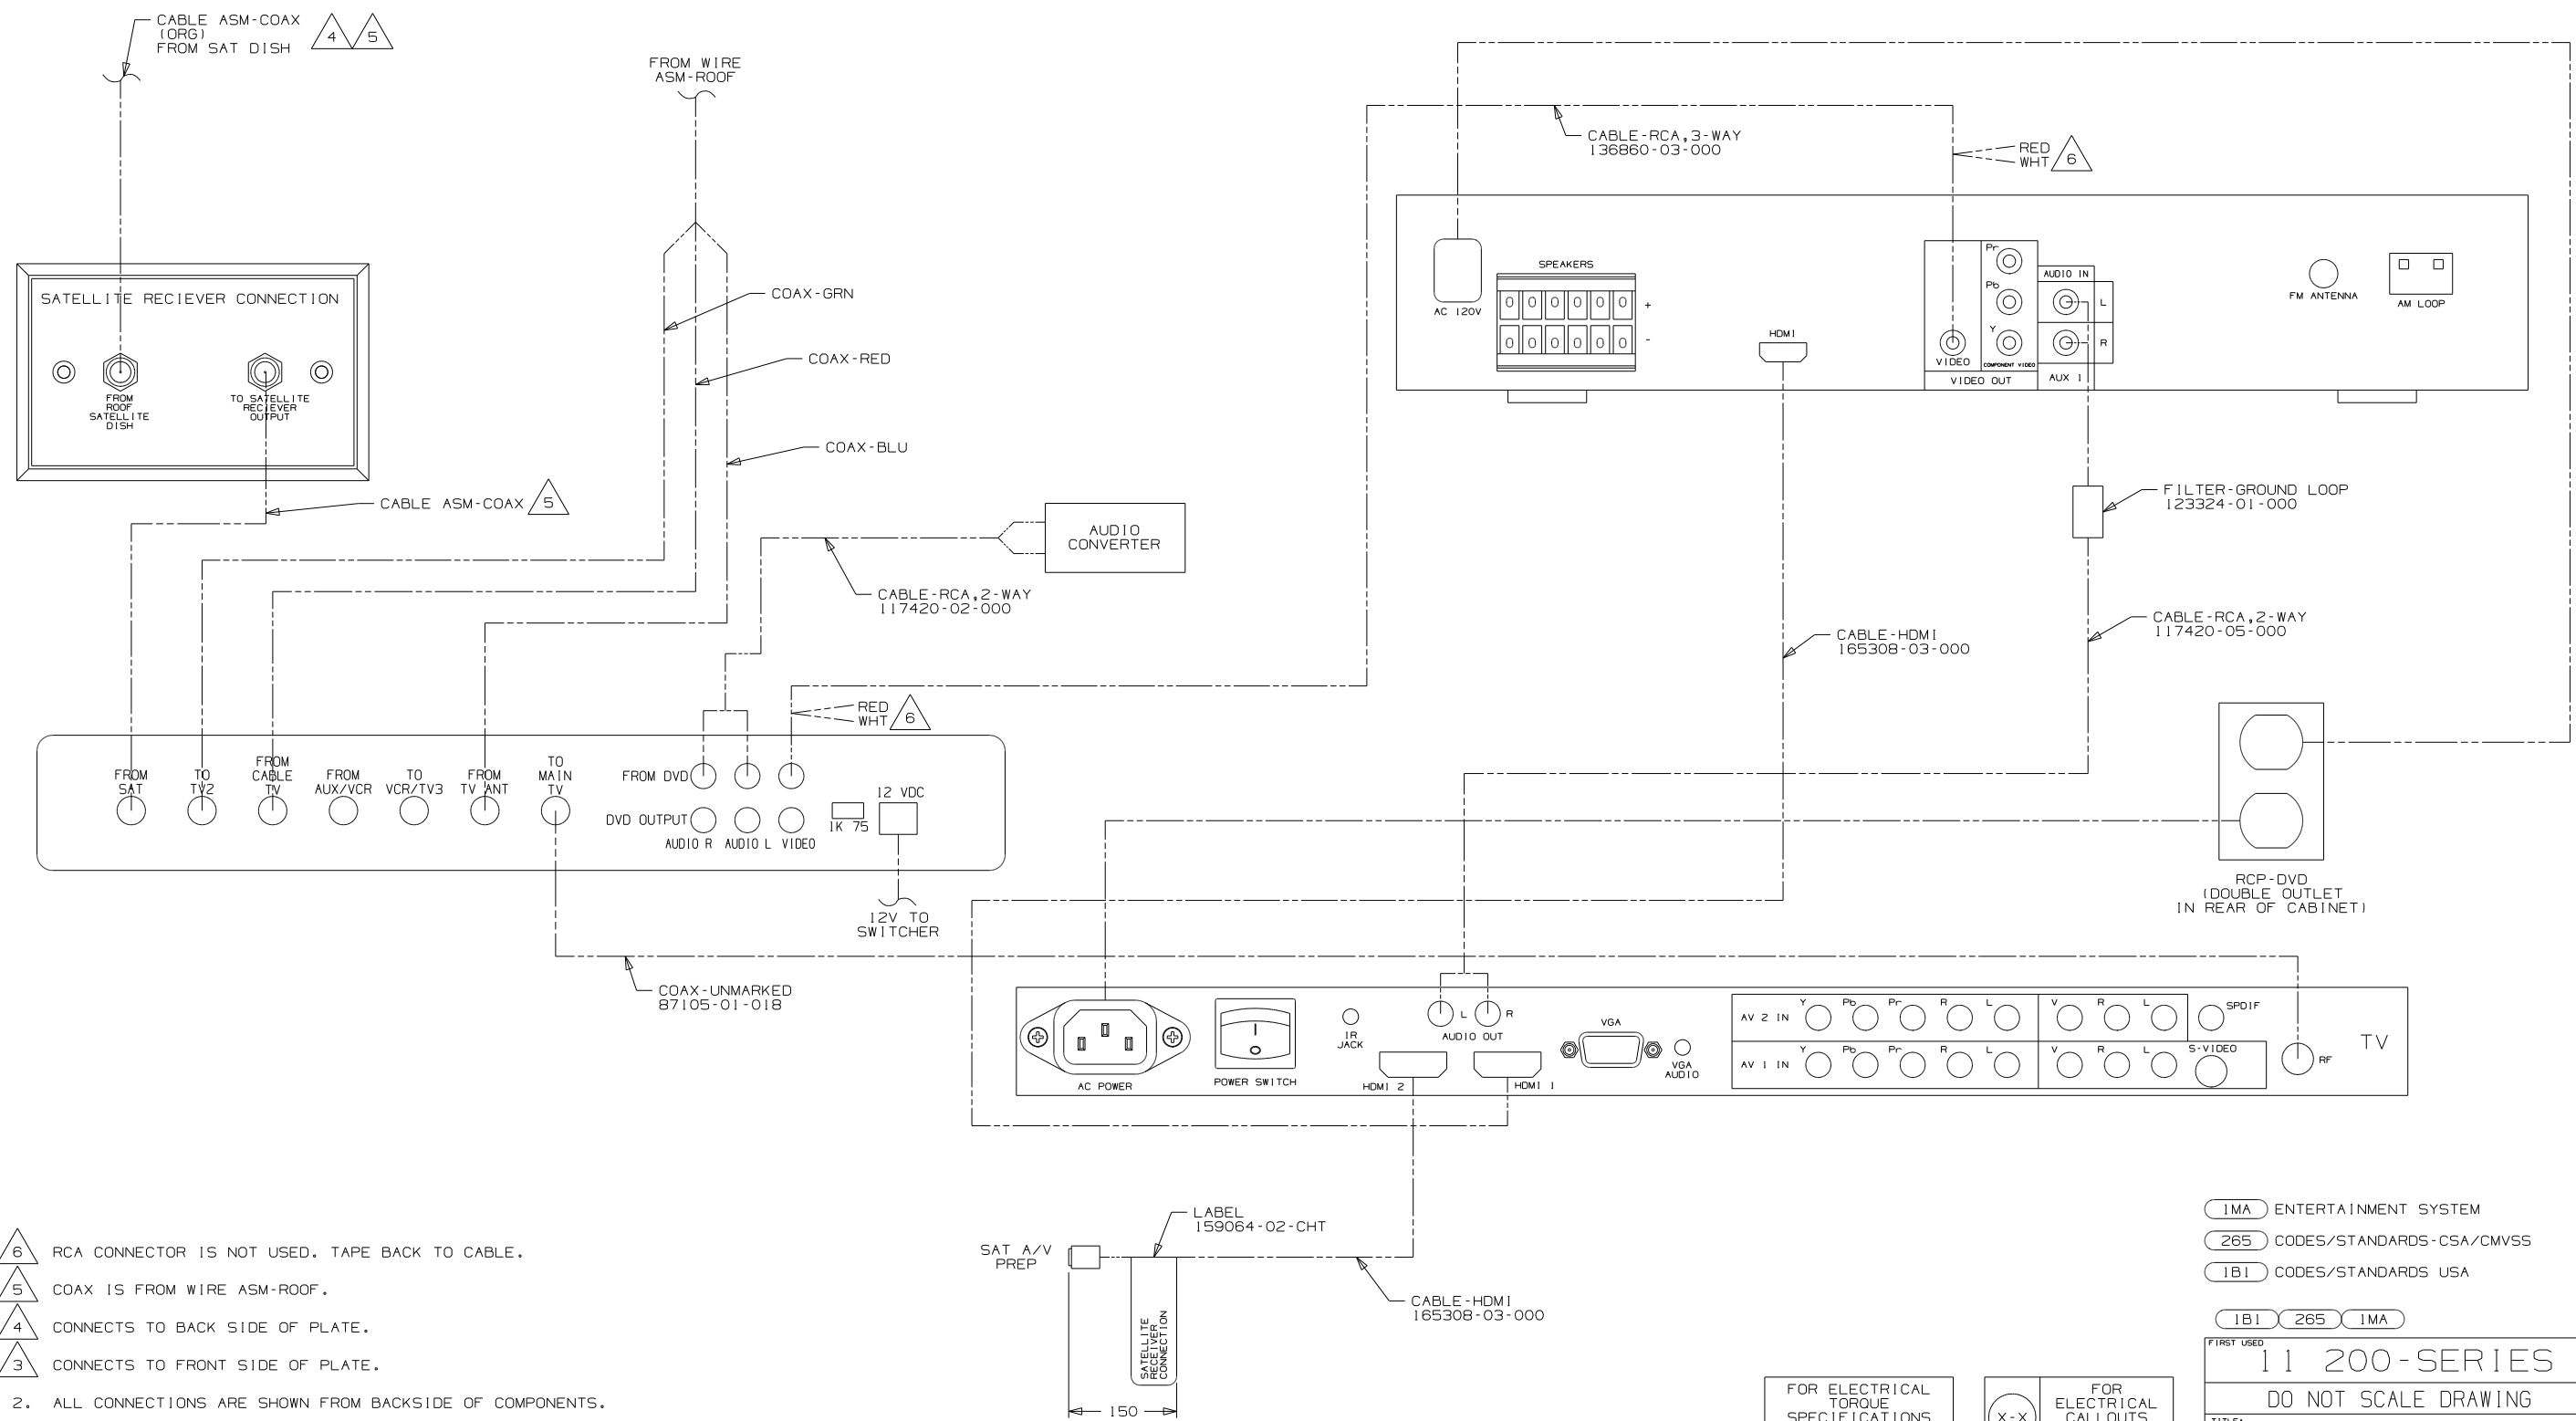

- △ 6 RCA CONNECTOR IS NOT USED. TAPE BACK TO CABLE.
- △ 5 COAX IS FROM WIRE ASM-ROOF.
- △ 4 CONNECTS TO BACK SIDE OF PLATE.
- △ 3 CONNECTS TO FRONT SIDE OF PLATE.

2. ALL CONNECTIONS ARE SHOWN FROM BACKSIDE OF COMPONENTS.

1. SEE WIRING INSTL-BODY,12V FOR ADDITIONAL INFORMATION.

NOTES:

VIEW FA


FOR ELECTRICAL
TORQUE
SPECIFICATIONS
SEE DWG NO.
128783-01-000

FOR
ELECTRICAL
CALLOUTS
SEE DWG NO.
121339-01-000

IMA ENTERTAINMENT SYSTEM
265 CODES/STANDARDS-CSA/CMVSS
1B1 CODES/STANDARDS USA

1B1 265 IMA

FIRST USED		11 200-SERIES
DO NOT SCALE DRAWING		
TITLE:		WIRING INSTL-TV/DVD
SHEET 6	PART NO	174974
		REV

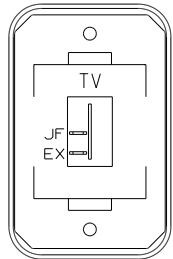

DETAIL GA

SWITCH-ROCKER
135740-01-CHT
SWITCH-BASE
135741-01-CHT
SWITCH-BEZEL
135742-45-CHT
SCREW
611-08-08U (2)

WALLPLATE, TV
COAX (GRN)
(REF)

SWITCH
DETAIL GA

TV-19"
170909-01-000
DC POWER CABLE
170909-02-000
WASHER
E11-10-00B (4)
CONVOLUTE
41953-06-000 (600 MM)
WIRE TIE
8343-01-000 (2)
WIRE ASM-TV EXTENSION
165275-01-000


ILK TV-19"DC,COLOR,LCD W/REMOTE
265 CODES/STANDARDS-CSA/CMVSS
1B1 CODES/STANDARDS USA

1B1 265 ILK

FOR ELECTRICAL
TORQUE
SPECIFICATIONS
SEE DWG NO.
128783-01-000

FOR
ELECTRICAL
CALLOUTS
SEE DWG NO.
121339-01-000

11 200-SERIES		
DO NOT SCALE DRAWING		
TITLE: WIRING INSTL-TV/DVD		
SHEET 7	PART NO 174974	REV

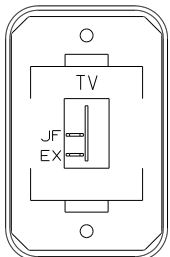

SWITCH-ROCKER
135740-01-CHT
SWITCH-BASE
135741-01-CHT
SWITCH-BEZEL
135742-45-CHT
SCREW
611-08-08U (2)

SWITCH
DETAIL HA

WALLPLATE, TV
COAX (GRN)
(REF)

TV-19" LCD
170909-01-000
TV-19" DC POWER CABLE
170909-02-000
WASHER
E11-10-00B (4)
CONVOLUTE
41953-06-000 (600MM)
WIRE TIE
8343-01-000 (2)

WIRE ASM-TV EXTENSION
165275-01-000


1LK TV-19"DC,COLOR,LCD W/REMOTE
265 CODES/STANDARDS-CSA/CMVSS
1B1 CODES/STANDARDS USA

1B1 265 1LK

FIRST USED		
11 200-SERIES		
DO NOT SCALE DRAWING		
TITLE: WIRING INSTL-TV/DVD		
SHEET 8	PART NO 174974	REV

FOR ELECTRICAL
TORQUE
SPECIFICATIONS
SEE DWG NO.
128783-01-000


FOR
ELECTRICAL
CALLOUTS
SEE DWG NO.
121339-01-000

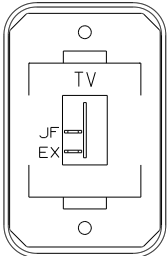

SWITCH-ROCKER
135740-01-CHT
SWITCH-BASE
135741-01-CHT
SWITCH-BEZEL
135742-45-CHT
SCREW
G11-08-08U (2)

DETAIL JA

3 SWITCH
DETAIL JA

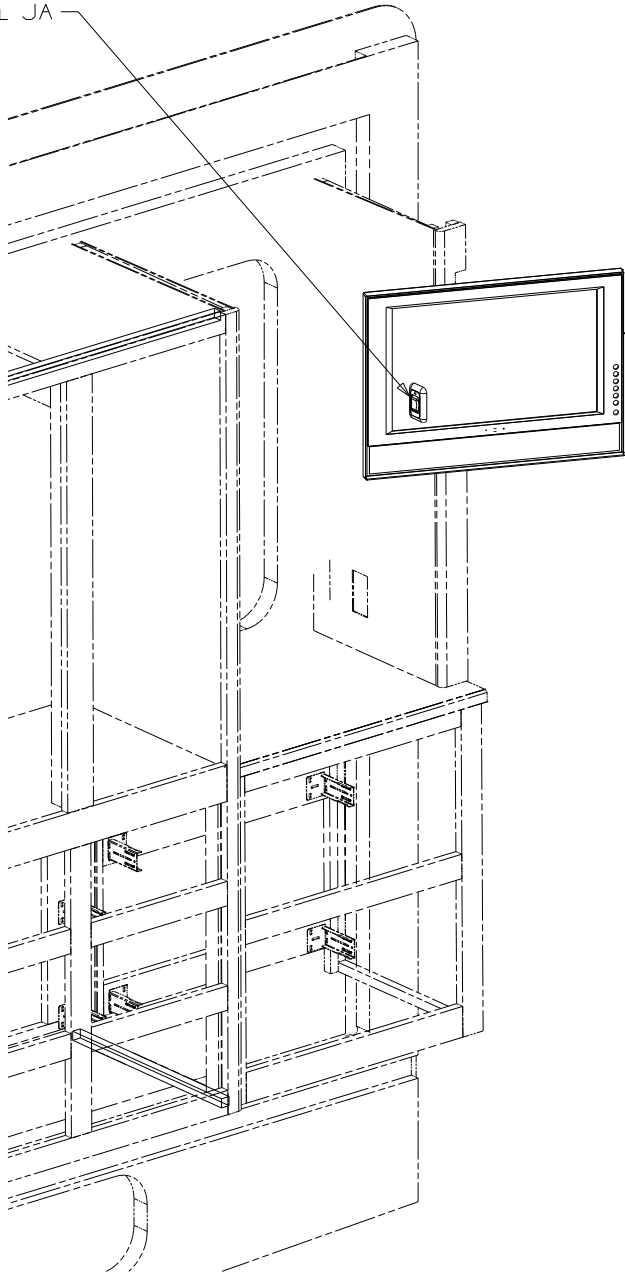

TV-19" LCD
170909-01-000
TV-19" DC POWER CABLE
170909-02-000
WASHER
E11-10-00B (4)
CONVOLUTE
41953-06-000 (600MM)
WIRE TIE
8343-01-000 (2)
WIRE ASM-TV EXTENSION
165275-01-000

ILK

1 2 3

- 3 SEE WIRING INSTL-BODY,12V FOR ADDITIONAL INFORMATION.
- 2 SEE FLOOR PLAN-CABT & APPLIANCE FOR MOUNTING INFORMATION.
- 1 USE SCREWS SUPPLIED WITH TV.

NOTES:

FOR ELECTRICAL
TORQUE
SPECIFICATIONS
SEE DWG NO.
128783-01-000

FOR
ELECTRICAL
CALLOUTS
SEE DWG NO.
121339-01-000


ILK TV-19"DC,COLOR,LCD W/REMOTE

265 CODES/STANDARDS-CSA/CMVSS

1B1 CODES/STANDARDS USA

1B1 265 ILK

FIRST USED		
11 200-SERIES		
DO NOT SCALE DRAWING		
TITLE: WIRING INSTL-TV/DVD		
SHEET 9	PART NO 174974	REV

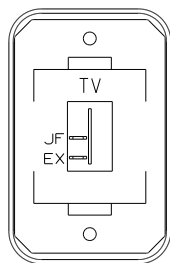


DETAIL KA

SWITCH-ROCKER
135740-01-CHT
SWITCH-BASE
135741-01-CHT
SWITCH-BEZEL
135742-45-CHT
SCREW
G11-08-08U (2)

TV-19" LCD
170909-01-000
TV-19" DC POWER CABLE
170909-02-000
WASHER
E11-10-00B (4)
CONVOLUTE
41953-06-000 (600MM)
WIRE TIE
8343-01-000 (2)
WIRE ASM-TV EXTENSION
165275-01-000

1LK 1 2 3

SWITCH
DETAIL KA 3

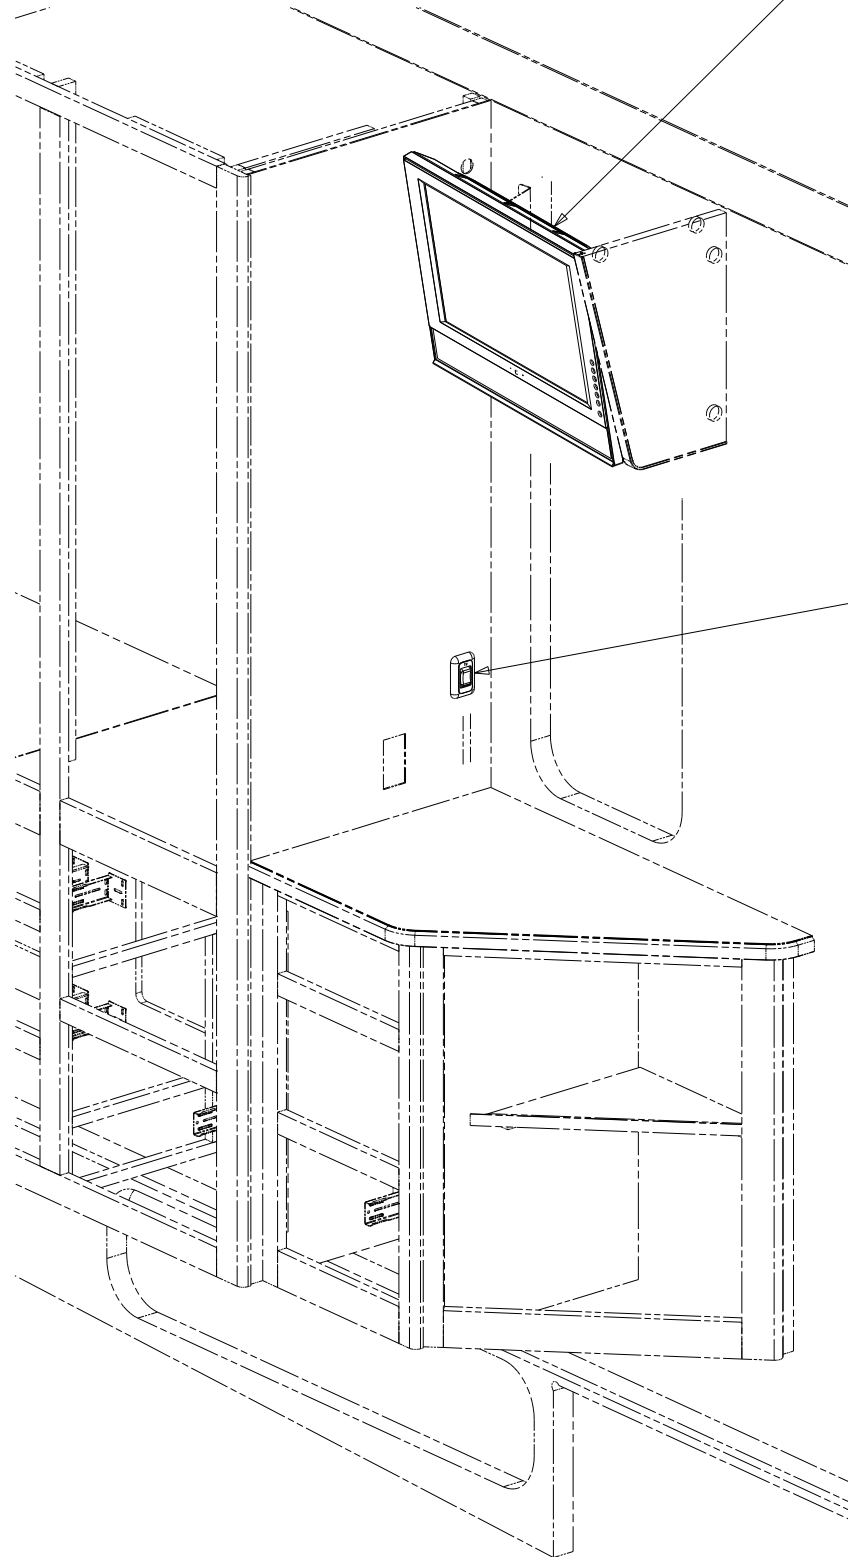

- 3 SEE WIRING INSTL-BODY,12V FOR ADDITIONAL INFORMATION.
- 2 SEE FLOOR PLAN-CABT & APPLIANCE FOR MOUNTING INFORMATION.
- 1 USE SCREWS SUPPLIED WITH TV.

NOTES:

FOR ELECTRICAL
TORQUE
SPECIFICATIONS
SEE DWG NO.
128783-01-000

FOR
ELECTRICAL
CALLOUTS
SEE DWG NO.
121339-01-000

1LK TV-19"DC,COLOR,LCD W/REMOTE
265 CODES/STANDARDS-CSA/CMVSS
1B1 CODES/STANDARDS USA

1B1 265 1LK



11 200-SERIES

DO NOT SCALE DRAWING

TITLE:
WIRING INSTL-TV/DVD

SHEET 10 PART NO 174974 REV

1 12/22/2010

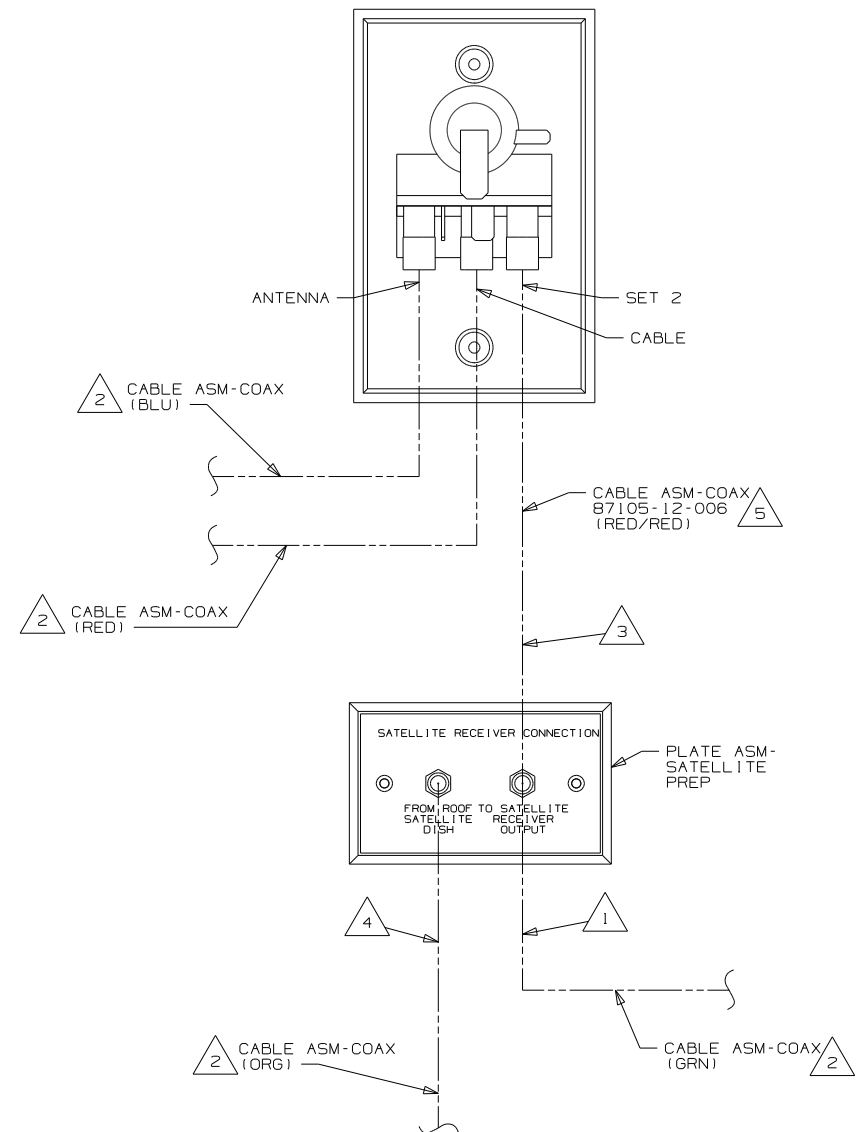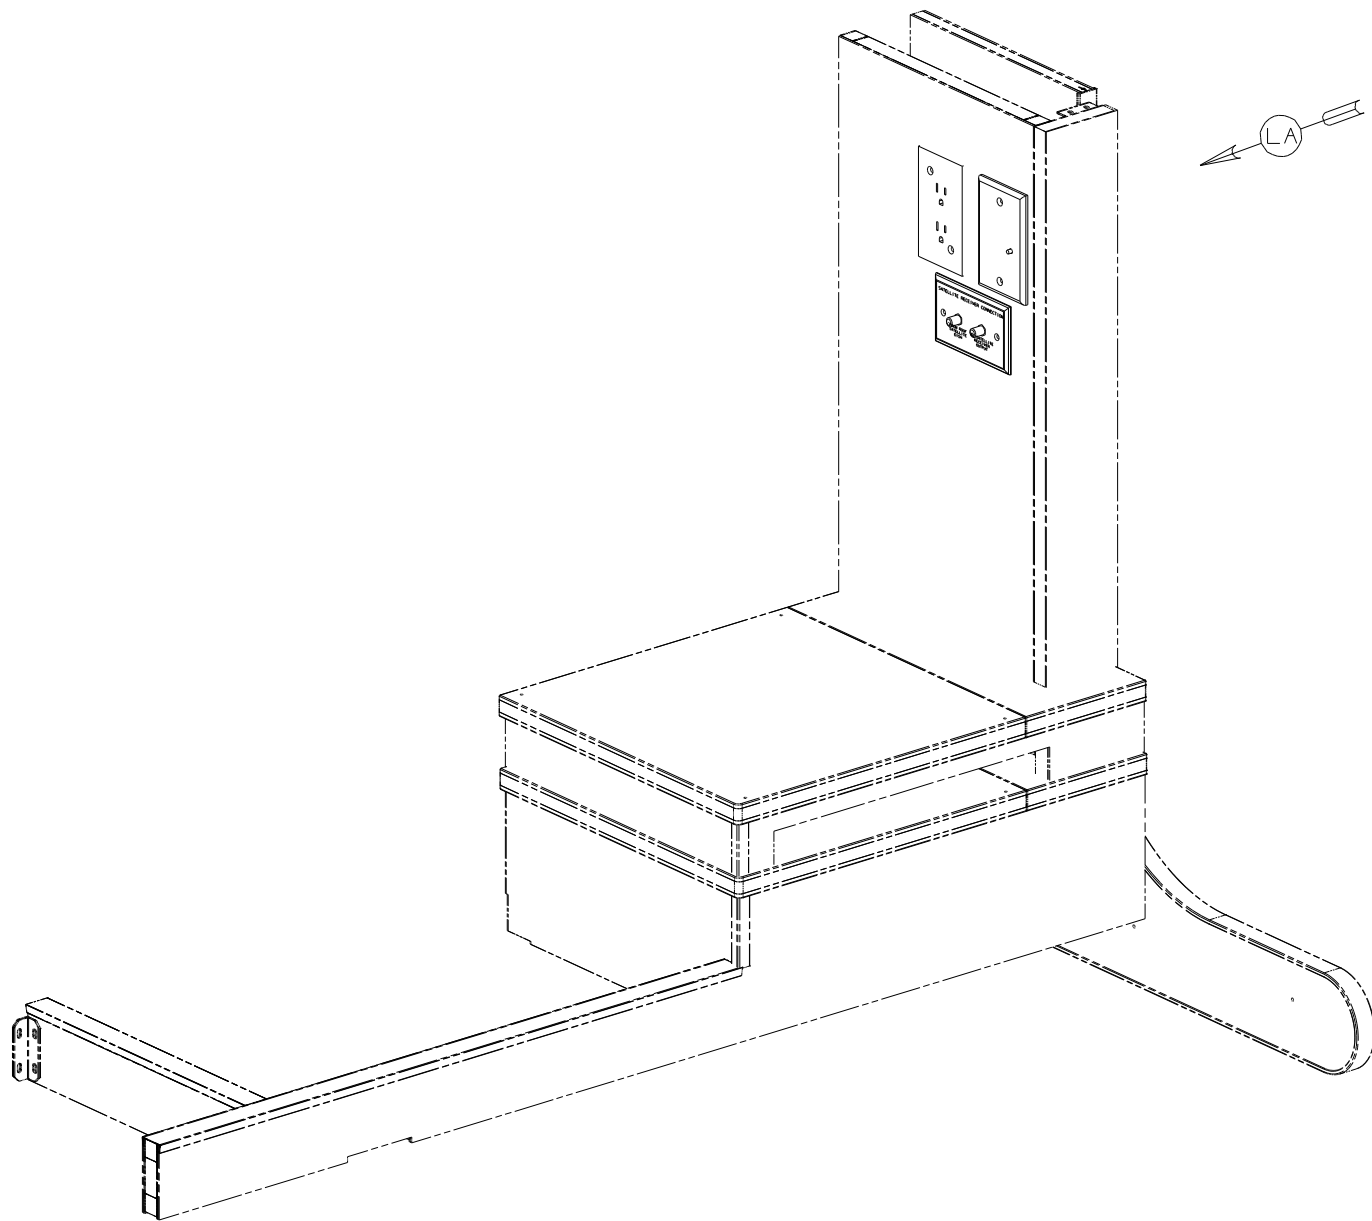

DETAIL LA

- 5 NOT USED WITH IMK
- 4 CONNECTED TO THE REAR SIDE OF SATELLITE PREP PLATE, CONNECTION LABELED "FROM ROOF SATELLITE DISH".
- 3 CONNECTED TO THE FRONT SIDE OF SATELLITE PREP PLATE, CONNECTION LABELED "TO SATELLITE RECEIVER OUTPUT".
- 2 CABLE ROUTED IN ROOF.
- 1 CONNECTED TO THE REAR SIDE OF SATELLITE PREP PLATE, CONNECTION LABELED "TO SATELLITE RECEIVER OUTPUT".

NOTES:

FOR ELECTRICAL
TORQUE
SPECIFICATIONS
SEE DWG NO.
128783-01-000

FOR ELECTRICAL
CALLOUTS
SEE DWG NO.
121339-01-000

IMK TV-19"DC, STEREO SYS, VIDEO SEL

265 CODES/STANDARDS-CSA/CMVSS

1B1 CODES/STANDARDS USA

1B1 265 5

FIRST USED


11 200-SERIES

DO NOT SCALE DRAWING

TITLE: WIRING INSTL-TV/DVD


SHEET 11 PART NO 174974 REV

12/22/2010

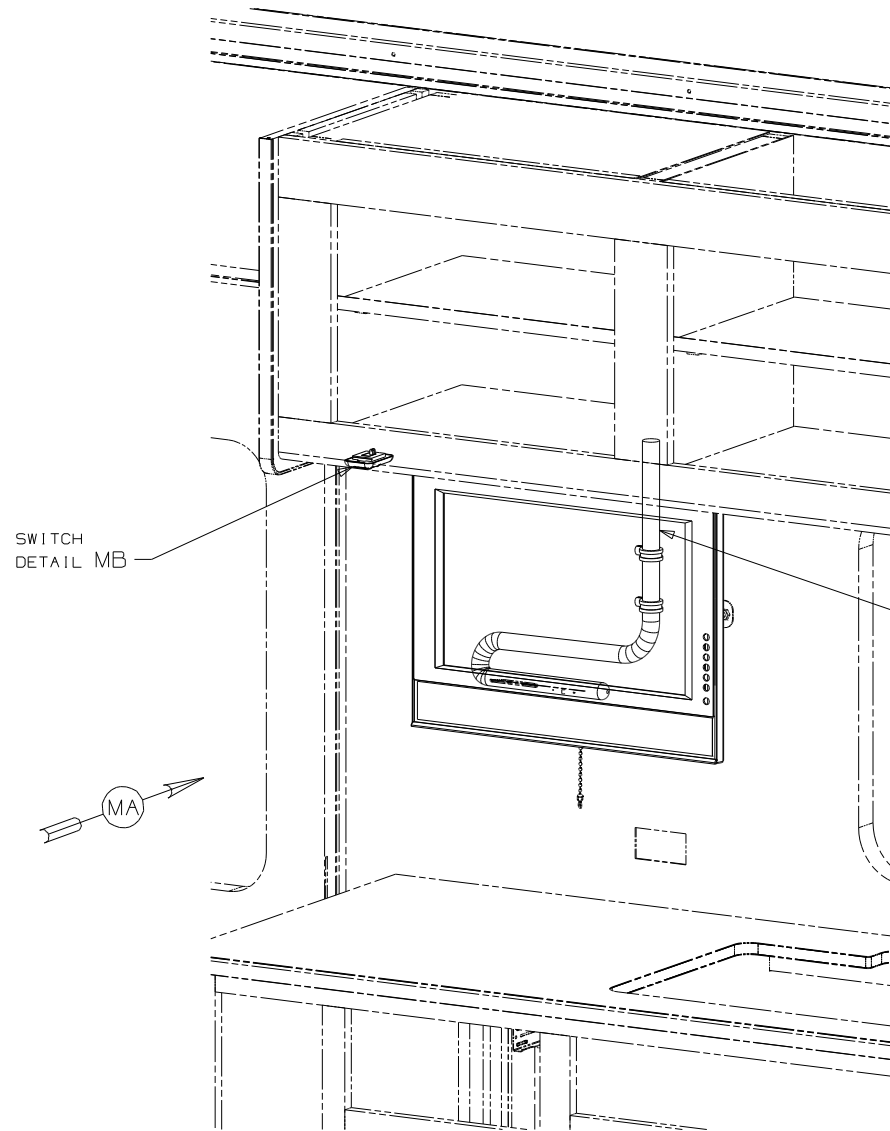


SWITCH
DETAIL MB

TV-19" LCD
170909-01-000
TV-19" DC POWER CABLE
170909-02-000
WASHER
E11-10-00B (4)
WIRE ASM-TV EXTENSION
178212-01-000

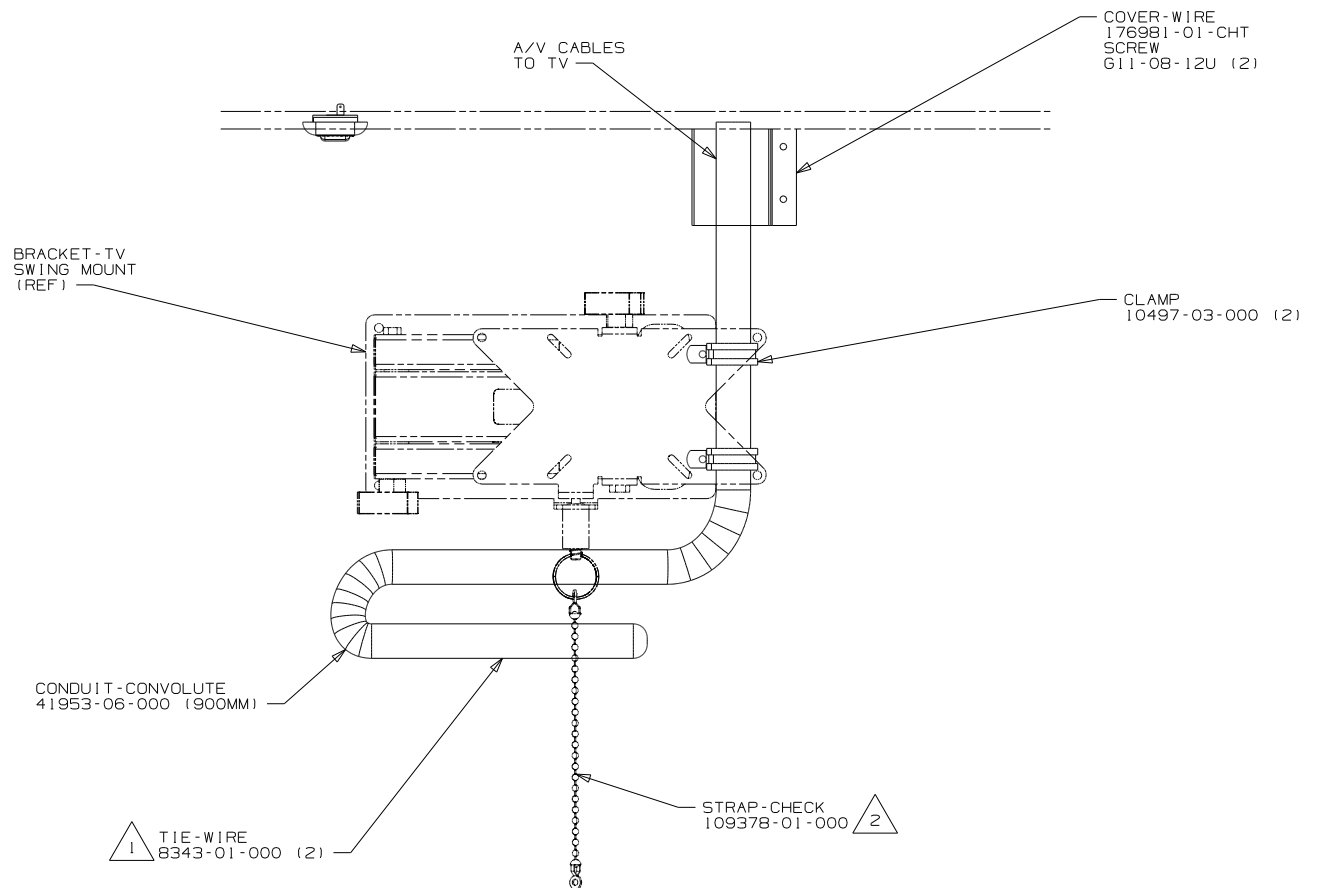

VIEW MA

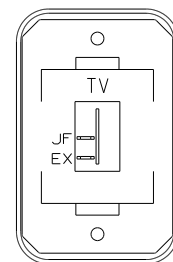

DETAIL MB

SWITCH-ROCKER
135740-01-CHT
SWITCH-BASE
135741-01-CHT
SWITCH-BEZEL
135742-45-CHT
SCREW
G11-08-08U (2)

FOR ELECTRICAL
TORQUE
SPECIFICATIONS
SEE DWG NO.
128783-01-000

FOR ELECTRICAL
CALLOUTS
SEE DWG NO.
121339-01-000

IMR TV(FRT)-19" DC LCD STEREO
265 CODES/STANDARDS-CSA/CMVSS
1B1 CODES/STANDARDS USA

1B1 265 IMR

11 200-SERIES

DO NOT SCALE DRAWING

TITLE: WIRING INSTL-TV/DVD

SHEET 12 PART NO 174974 REV

12/22/2010

NOTES:
2 REPLACE CHAIN WITH STRAP.
1 USE HOLES ON PLATE-MOUNTING,TV TO ATTACH WIRE
ASM TO PLATE-MOUNTING,TV WITH WIRE TIES.