


DRAWING NO.	FEATURE
170104-01	-----
170104-11	1B112D
170104-15	26512D

170104

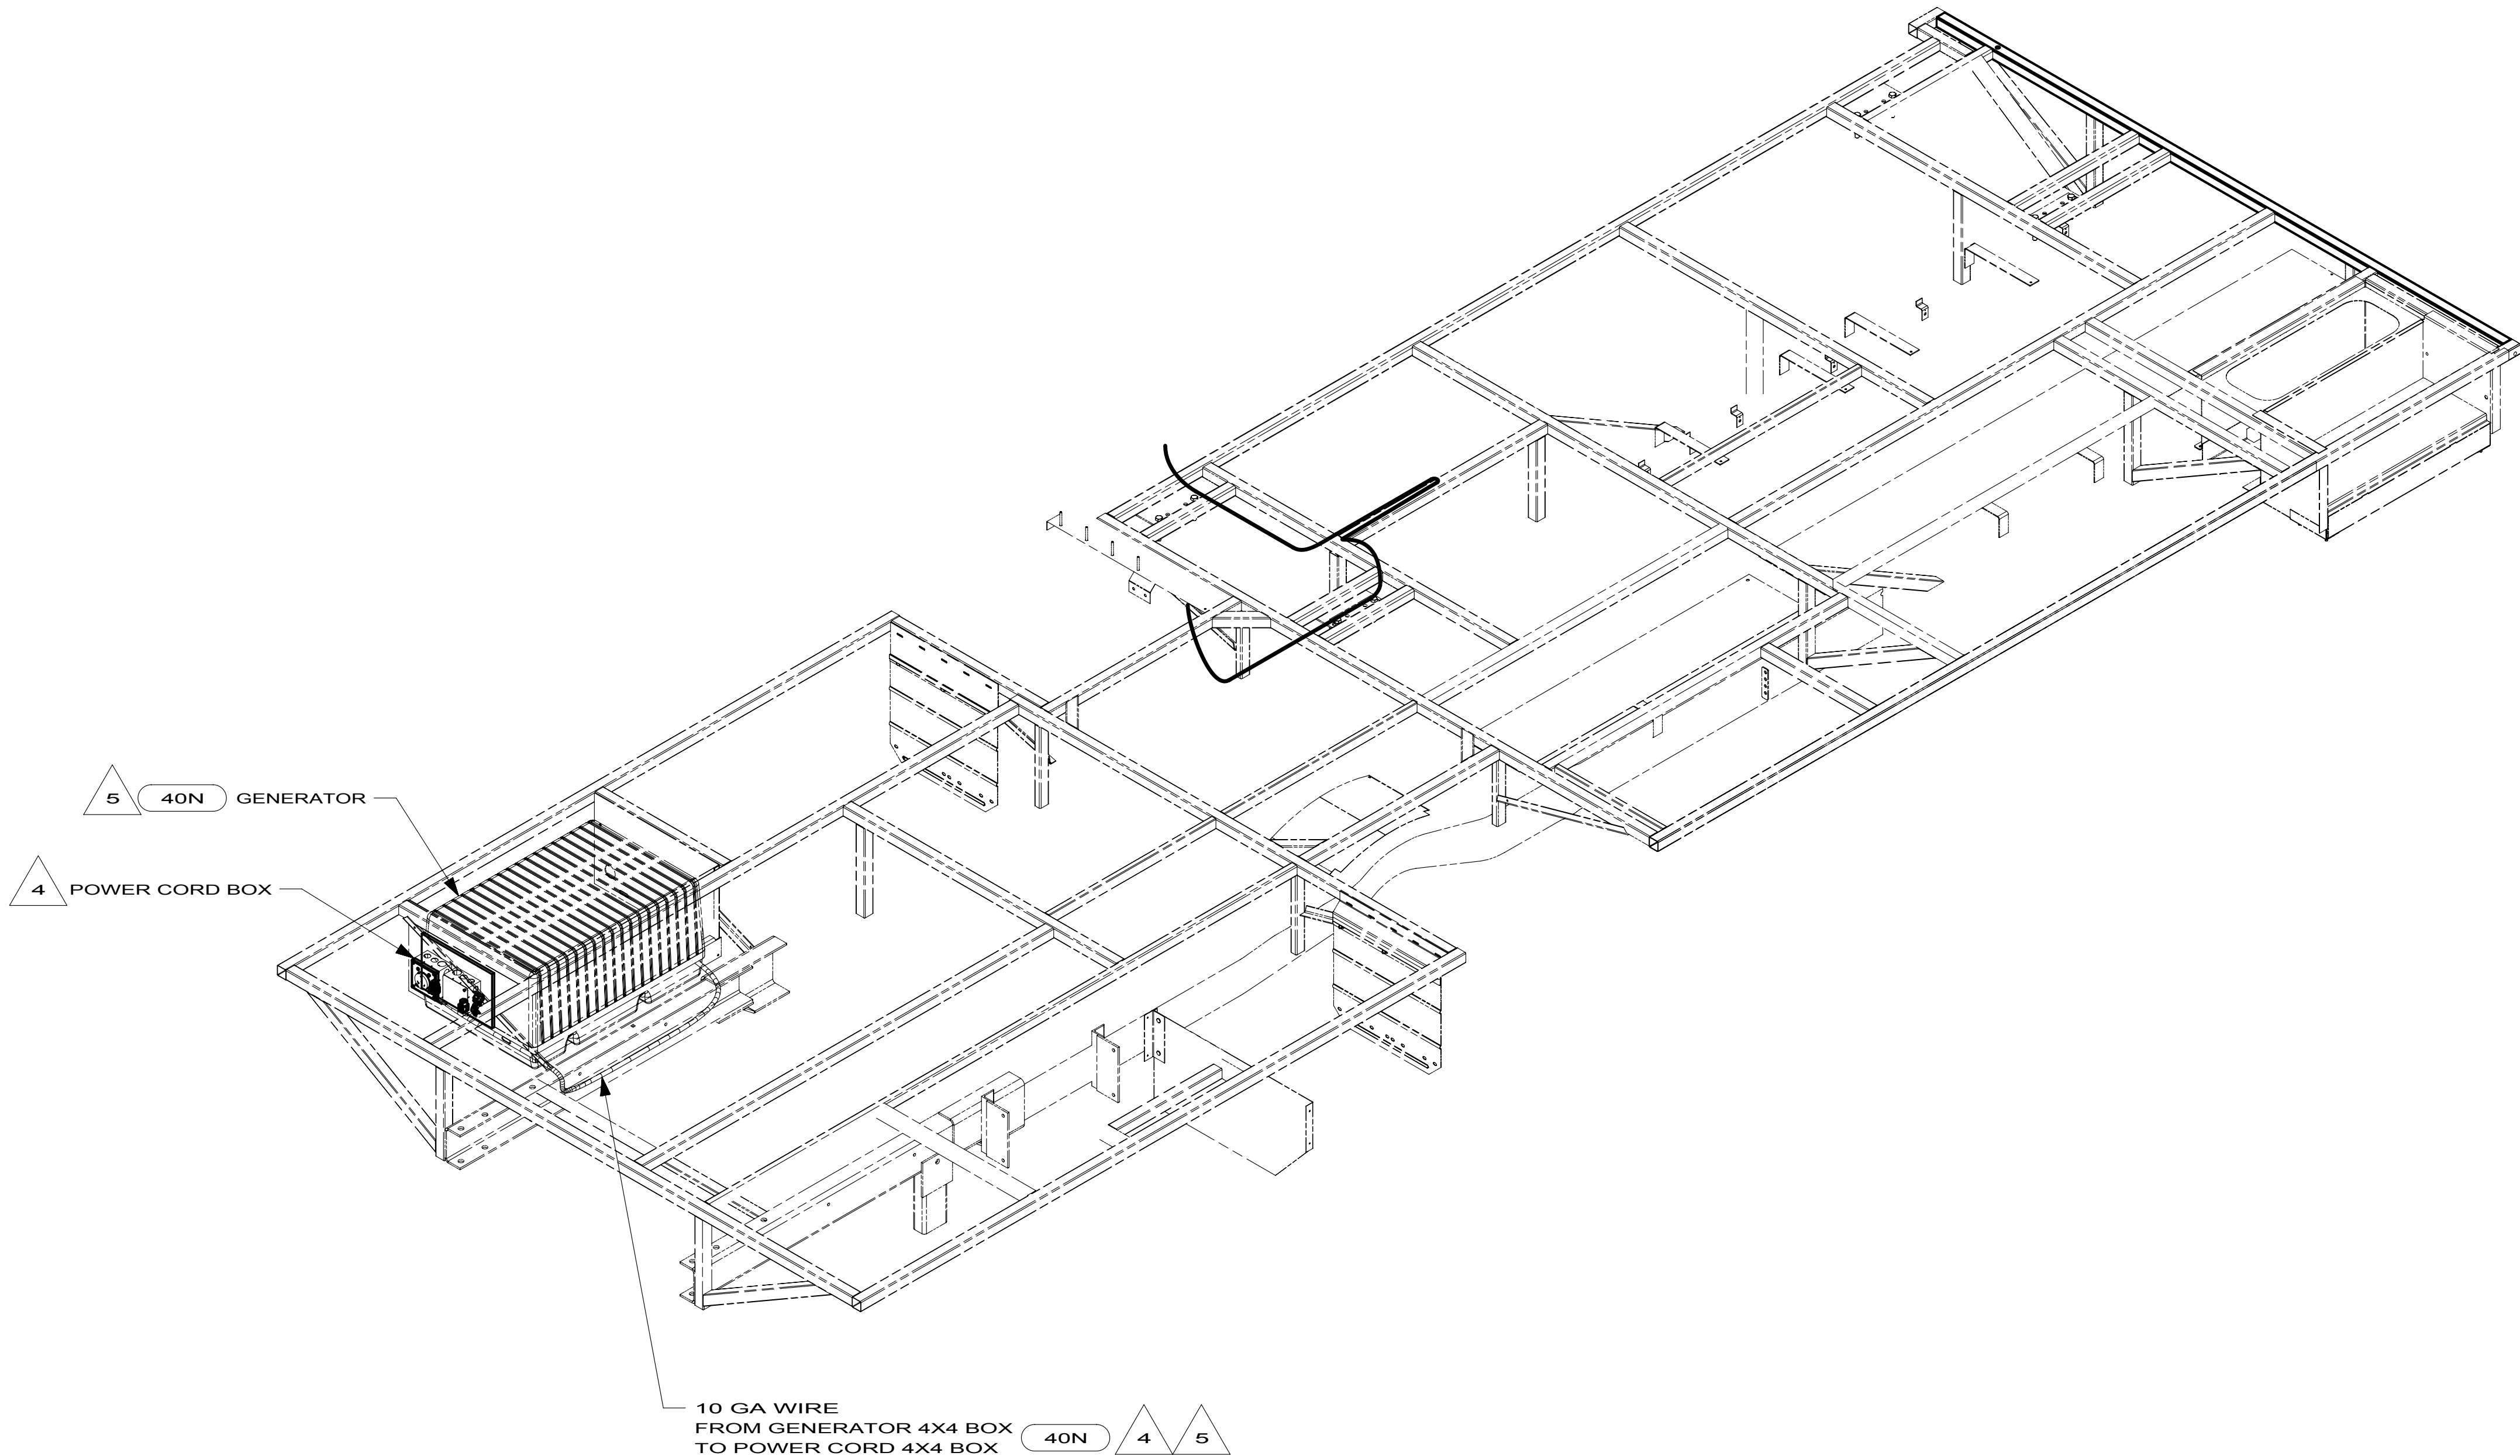

5 SEE GENERATOR INSTL FOR ADDITIONAL INFORMATION.

4 SEE LOAD CENTER INSTL FOR ADDITIONAL INFORMATION.

3. ALL GROUND WIRES TO BE COVERED WITH TUBING 008041-02-000.

2. ALL 110V WIRES ARE TO BE CLAMPED WITH CLAMP 010497-05-000 WITHIN 200MM OF OUTLET BOXES, USE SCREW 000G67-10-12B.

1. ALL WIRES TO BE SECURED WITH CLAMP 010495 OR 010497 OR WIRE TIE 008343 OR 108046 EVERY 600MM, USE SCREW 000G67-XX-XXX OR 000G56-XX-XXX AS APPROPRIATE FOR INSTALLATION.


NOTES:

FOR ELECTRICAL
TORQUE
SPECIFICATIONS
SEE DWG NO.
128783-01-000

FOR
ELECTRICAL
CALLOUTS
SEE DWG NO.
121339-01-000

WIRING INSTL-BODY,110V

1 3 170104

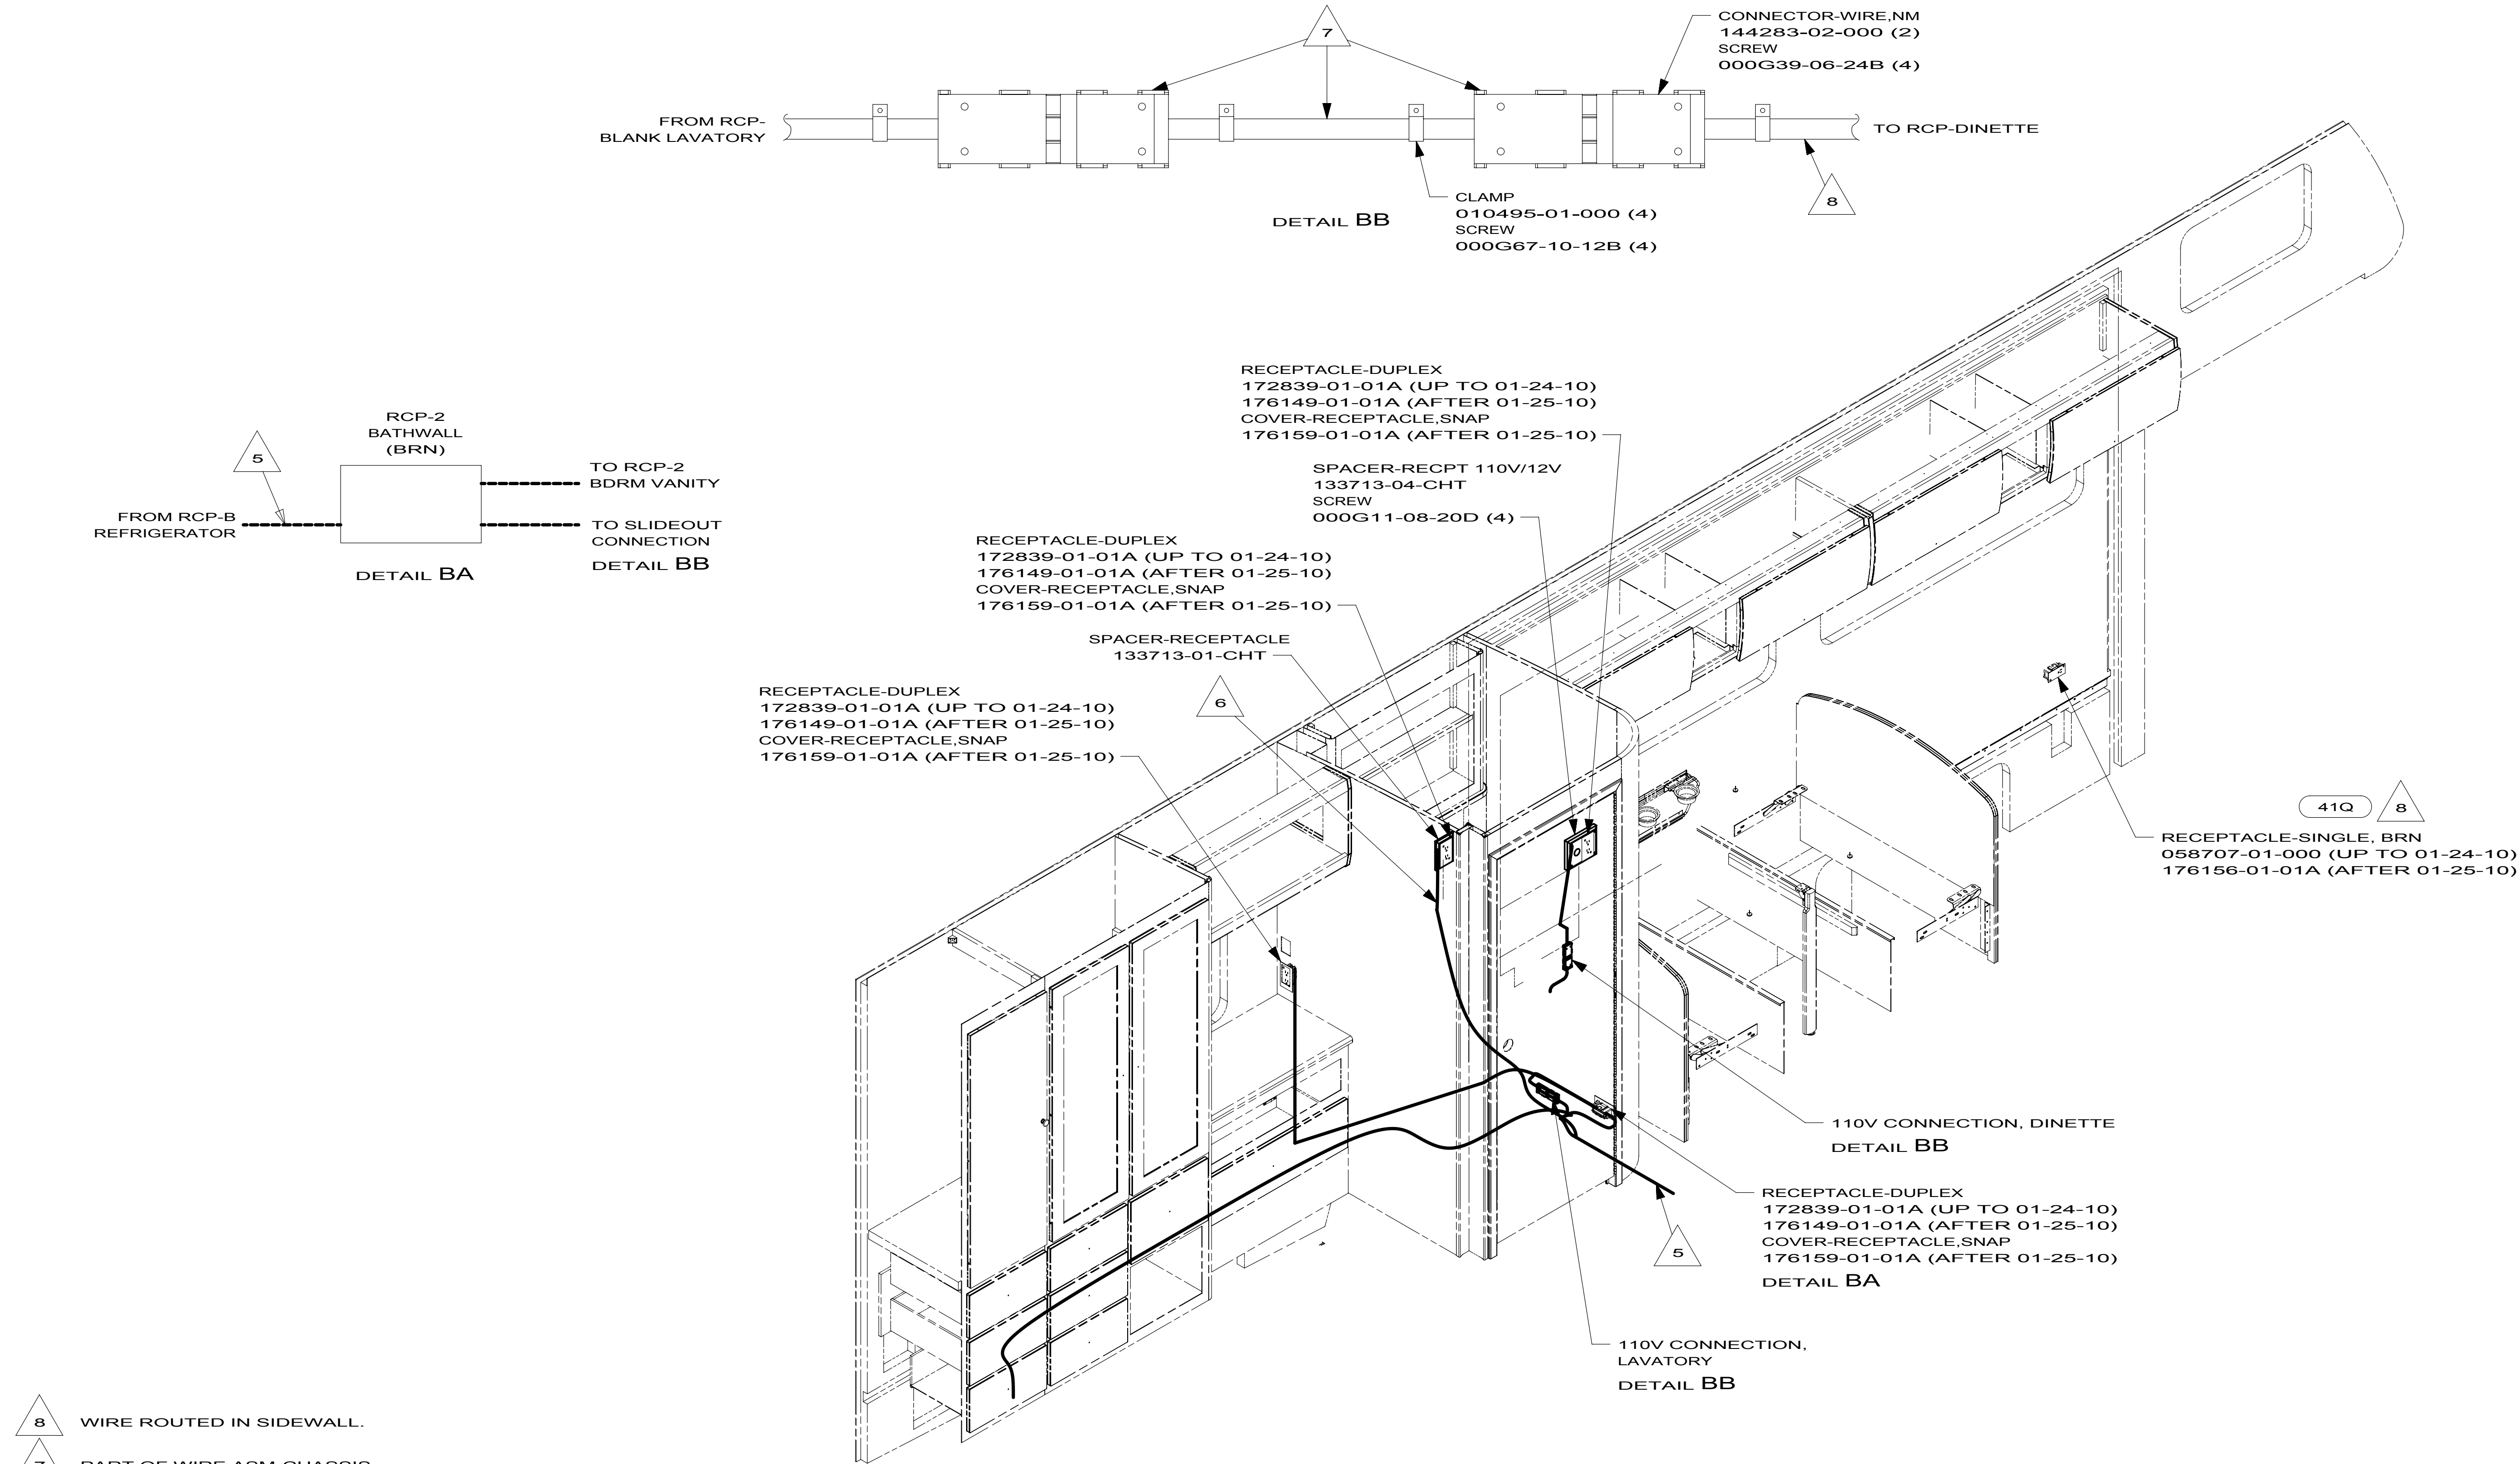

- 8 WIRE ROUTED IN SIDEWALL.
- 7 PART OF WIRE ASM-CHASSIS.
- 6 ROUTE WIRE THRU SIDEWALL.
- 5 ROUTE WIRE THRU FLOOR.

4. FOR MORE INFORMATION SEE WIRING DIAGRAM-BODY,110V.
3. ALL GROUND WIRE TO BE COVERED WITH TUBING 008041-02-000.
2. ALL 110V WIRE TO BE CLAMPED WITH CLAMP 010497-05-000 WITHIN 200MM OF OUTLET BOXES, USE SCREW 000G67-10-12B.
1. ALL WIRES TO BE SECURED WITH CLAMP 010495 OR 010497 OR WIRE TIE 008343 OR 108046 EVERY 600MM, USE SCREW 000G67-XX-XXX OR 000G56-XX-XXX AS APPROPRIATE FOR INSTALLATION.

NOTES:

FOR ELECTRICAL
TORQUE
SPECIFICATIONS
SEE DWG NO.
128783-01-000

X-X


FOR
ELECTRICAL
CALLOUTS
SEE DWG NO.
121339-01-000

- 41Q SOFA/SLEEPER-ULTRALEATHER HP
- 40N GEN-4.0KW-ONANGAS-MICROQUIET
- 12D ELECTRICAL SYSTEM 30 AMP
- 265 CODES/STANDARDS-CSA/CMVSS
- 1B1 CODES/STANDARDS USA

1B1 265 12D

10 331C

WIRING INSTL-BODY,110V

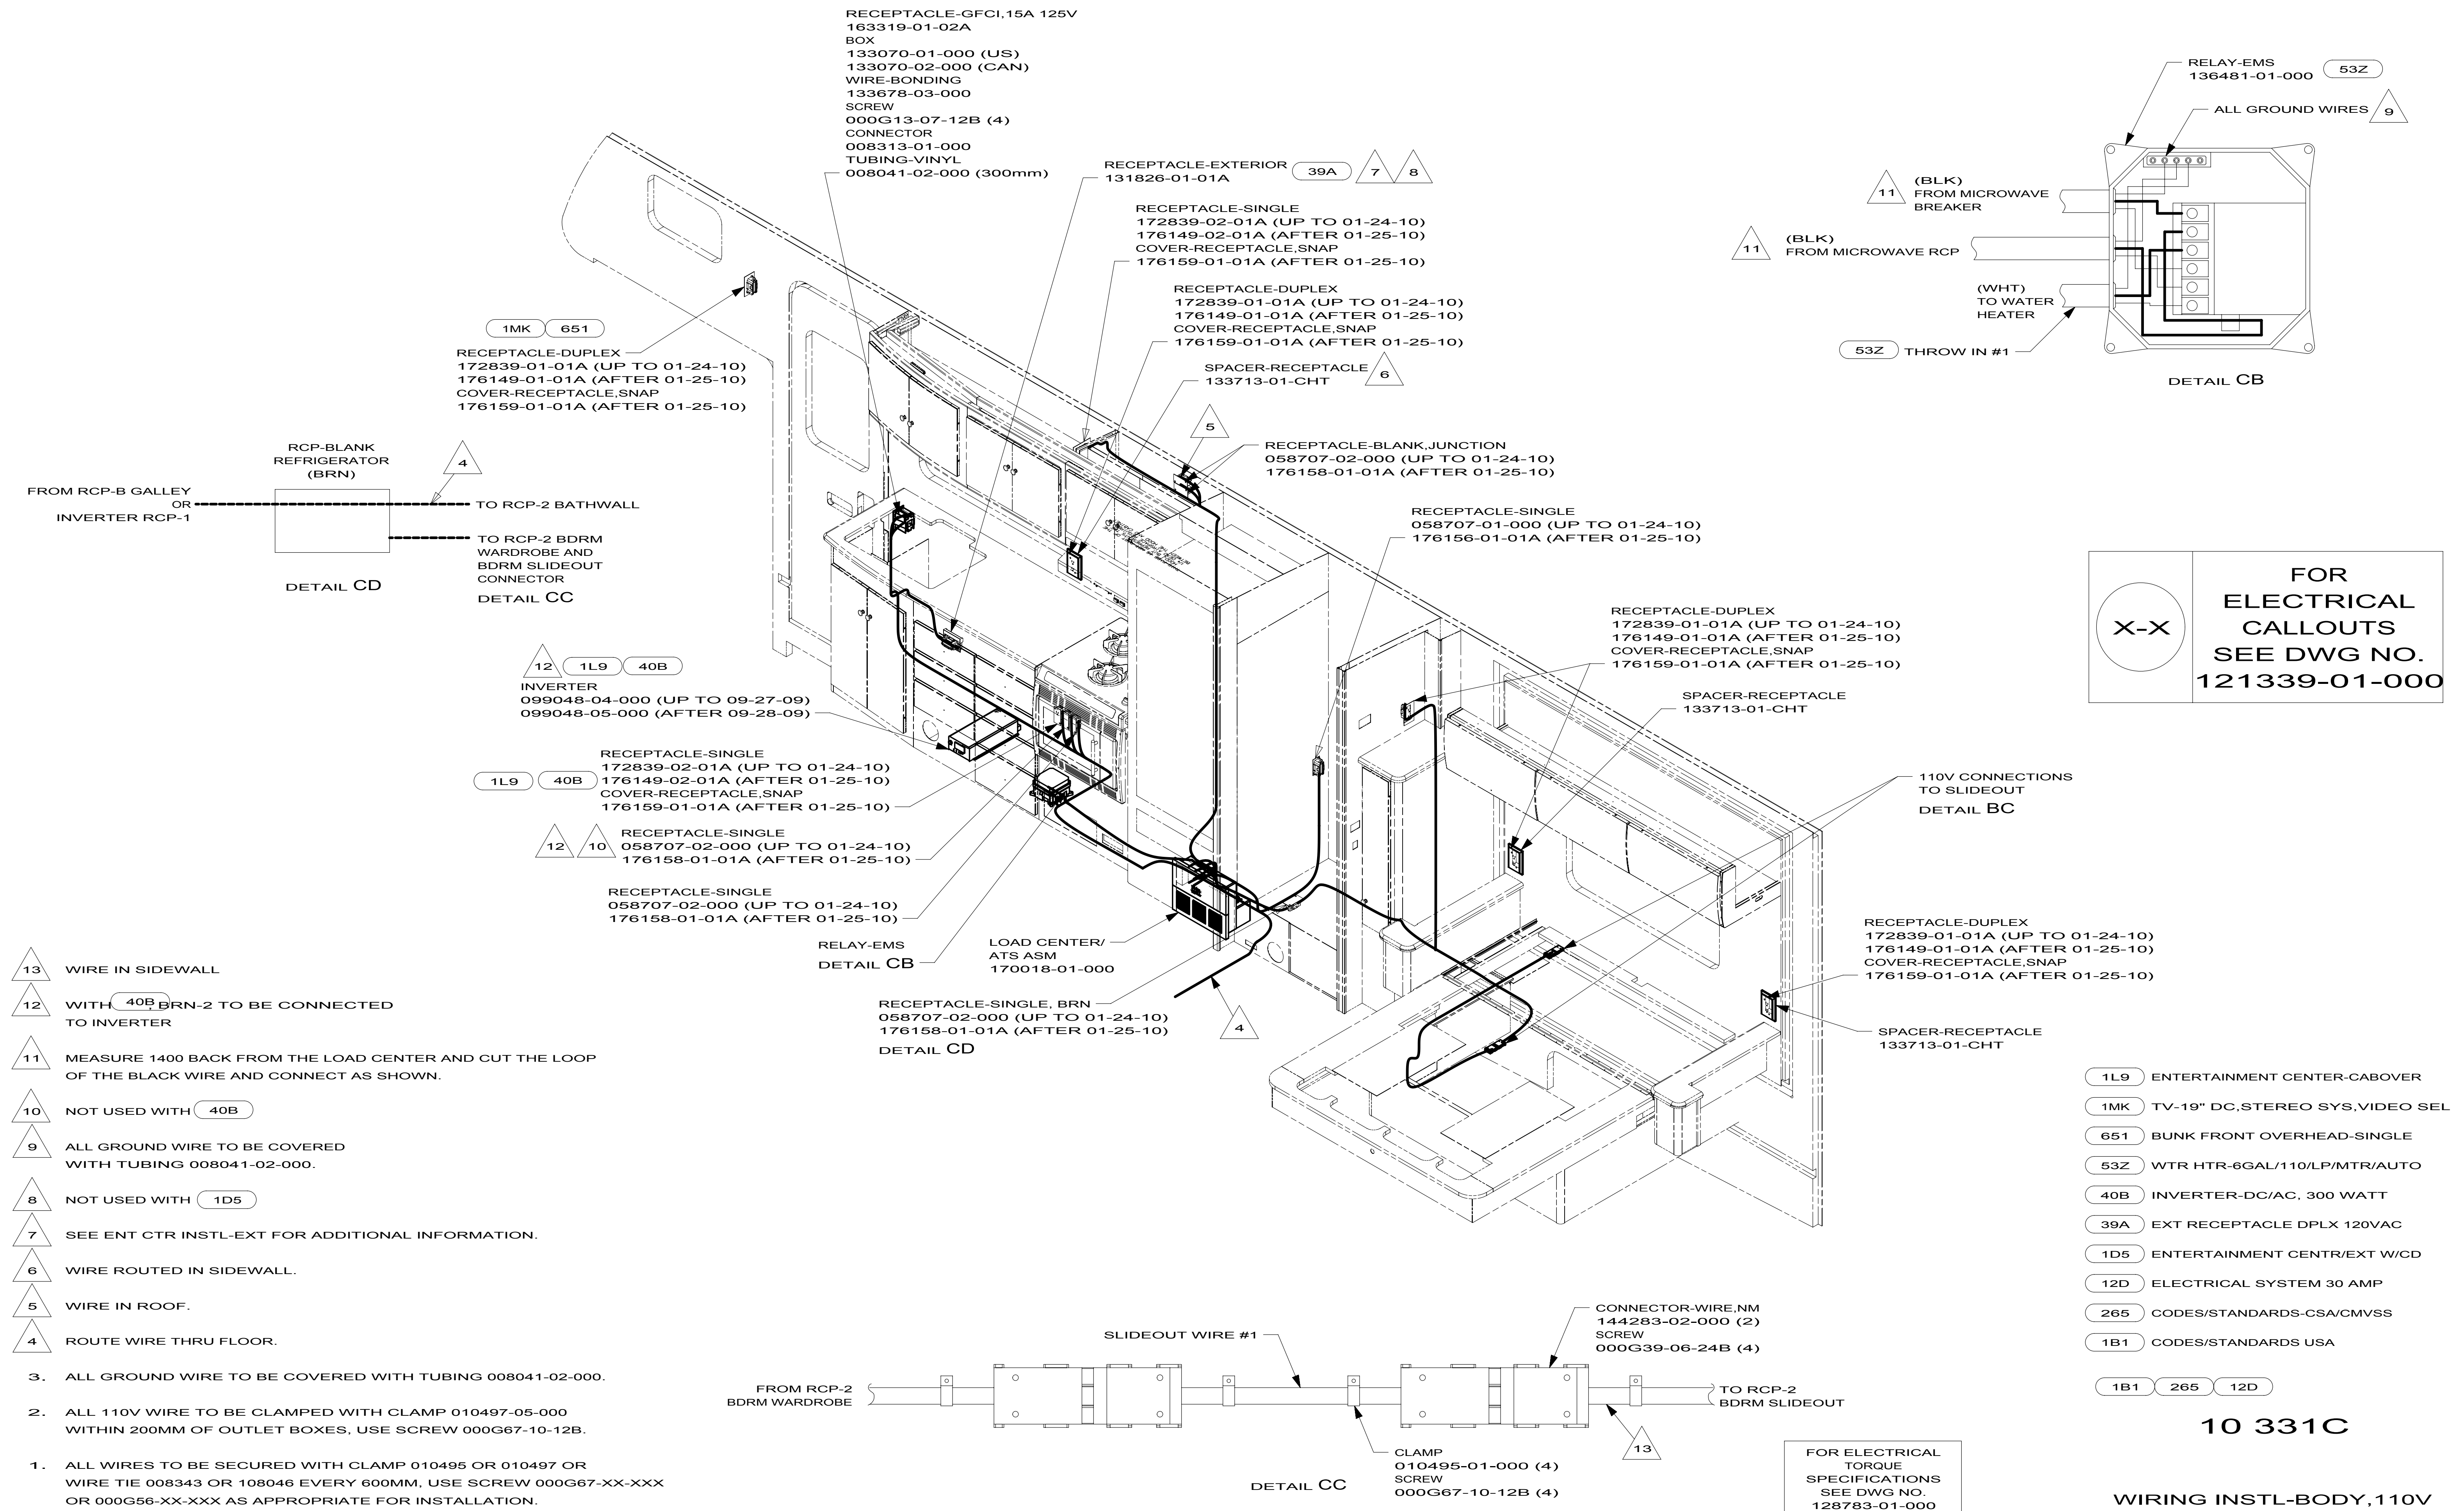

KEY	PART NUMBER	U/M DESCRIPTION	083208-07-000 VENDOR NO.
	083208-06-701	EA CONVERTER ONLY (LOWER UNIT)	7345R

		329B		331C
GROUND	8-G	136145-02-015		136145-02-022
WIRE ASM 110V US		170895-01-000		170199-01-000
WIRE ASM 110V CA		170895-02-000		170199-02-000
GENEARATOR CABLE ASM	UL	136137-01-025		X
	CA	136138-01-025		X
THROW-IN #1	UL	136135-09-040 53Z		136135-09-020 53Z
	CA	136136-09-040 53Z		136136-09-020 53Z
THROW-IN #2	UL	X		136131-03-025
	CA	X		136134-03-025
THROW-IN #3	UL	X		X
	CA	X		X
THROW-IN #4	UL	X		X
	CA	X		X
THROW-IN #5	UL	X		X
	CA	X		X
THROW-IN #6	UL	X		X
	CA	X		X
THROW-IN #7	UL	X		X
	CA	X		X
SLIDEOUT WIRE #1	UL	136151-03-017 3		136151-03-020 3
	CA	136151-03-017 3		136151-03-020 3
SLIDEOUT WIRE #2	UL	X		X
	CA	X		X
MAIN EXTENSION	UL	X		X
	CA	X		X
CONDUIT		X		X

40N

40N

		224V	229T	231C	231N	231J
GROUND	8-G	136145-02-016	136145-02-012	136145-02-022	136145-02-024	136145-02-021
WIRE ASM 110V US		168359-01-000	168226-01-000	165476-01-000	169106-01-000	168597-01-000
WIRE ASM 110V CA		168359-02-000	168226-02-000	165476-02-000	169106-02-000	168597-02-000
GENEARATOR CABLE ASM	UL	8022-01-000 (4400)	X	X	X	X
	CA	24743-01-000 (4400)	X	X	X	X
CONDUIT		91234-01-000 (4000)	X	X	X	X
THROW-IN #1	UL	136135-09-067 53B	136135-09-050 53B	136131-03-012 40B	136151-03-028 3	136135-09-035 53B
	CA	136136-09-067 53B	136136-09-050 53B	136131-03-012 40B	136151-03-028 3	136136-09-035 53B
THROW-IN #2	UL	136131-02-012 1MB	X	136131-04-015 40B	136131-05-018 2	136131-03-003 2
	CA	136134-02-012 1MB	X	136134-04-015 40B	136134-05-018 2	136134-03-003 2
THROW-IN #3	UL	X	X	136135-09-018 53B	136135-09-022 53B	136131-03-071 2
	CA	X	X	136136-09-018 53B	136136-09-022 53B	136134-03-071 2
THROW-IN #4	UL	X	X	X	136131-03-050 2	X
	CA	X	X	X	136134-03-050 2	X
MAIN EXTENSION	UL	X	8022-01-000 (3400)	8022-01-000 (4000)	8022-01-000 (4600)	8022-01-000 (3500)
	CA	X	24743-01-000 (3400)	24743-01-000 (4000)	24743-01-000 (4600)	24743-01-000 (3500)
CONDUIT		X	91234-01-000 (3000)	91234-01-000 (3600)	91234-01-000 (4200)	91234-01-000 (3200)

40N

40N

40N

- 4

NOT USED WITH 1L6
- 3

FOR CONNECTOR INSTALLATION SEE DETAIL BH.
- 2

FOR CONNECTOR INSTALLATION SEE DETAIL BE.

1. ALL GROUND WIRES TO BE COVERED WITH TUBING 8041-02-000.

NOTES:

		728B	730C
GROUND	8-G	136145-02-023	136145-02-015
WIRE ASM 110V US		171925-01-000	166007-01-000
WIRE ASM 110V CA		171925-02-000	166007-02-000
GENEARATOR CABLE ASM	UL	X	X
	CA	X	X
THROW IN #1	UL	136135-09-040 53B	136135-09-040 53B
	CA	136136-09-040 53B	136136-09-040 53B
THROW IN #2	UL	X	X
	CA	X	X
THROW IN #3	UL	X	136135-06-004 41Q
	CA	X	136136-06-004 41Q
THROW IN #4	UL	X	136131-03-003 2
	CA	X	136134-03-003 2
SLIDEOUT WIRE #1		136151-03-020 3	136151-03-020 3

FOR ELECTRICAL
TORQUE
SPECIFICATIONS
SEE DWG NO.
128783-01-000

FOR
ELECTRICAL
CALLOUTS
SEE DWG NO.
121339-01-000


- 41Q SOFA/SLEEPER-ULTRALEATHER HP
- 1L6 TV-15"DC,COLOR,LCD W/REMOTE
- 1MB CUSTOM FLOORPLAN - OFFICE
- 40B INVERTER-DC/AC, 300 WATT
- 53Z WTR HTR-6GAL/110/LP/MTR/AUTO
- 53B WTR HTR-6GAL ELECTRIC/LP GAS
- 23T DRAINAGE SYSTEM-HEATED
- 40N GEN-4.0KW-ONANGAS-MICROQUIET
- 1L6 TV-15"DC,COLOR,LCD W/REMOTE
- 265 CODES/STANDARDS-CSA/CMVSS
- 1B1 CODES/STANDARDS USA


1B1 265

10 200/300/700

LOAD CENTER/ATS ASM

1 3 170018

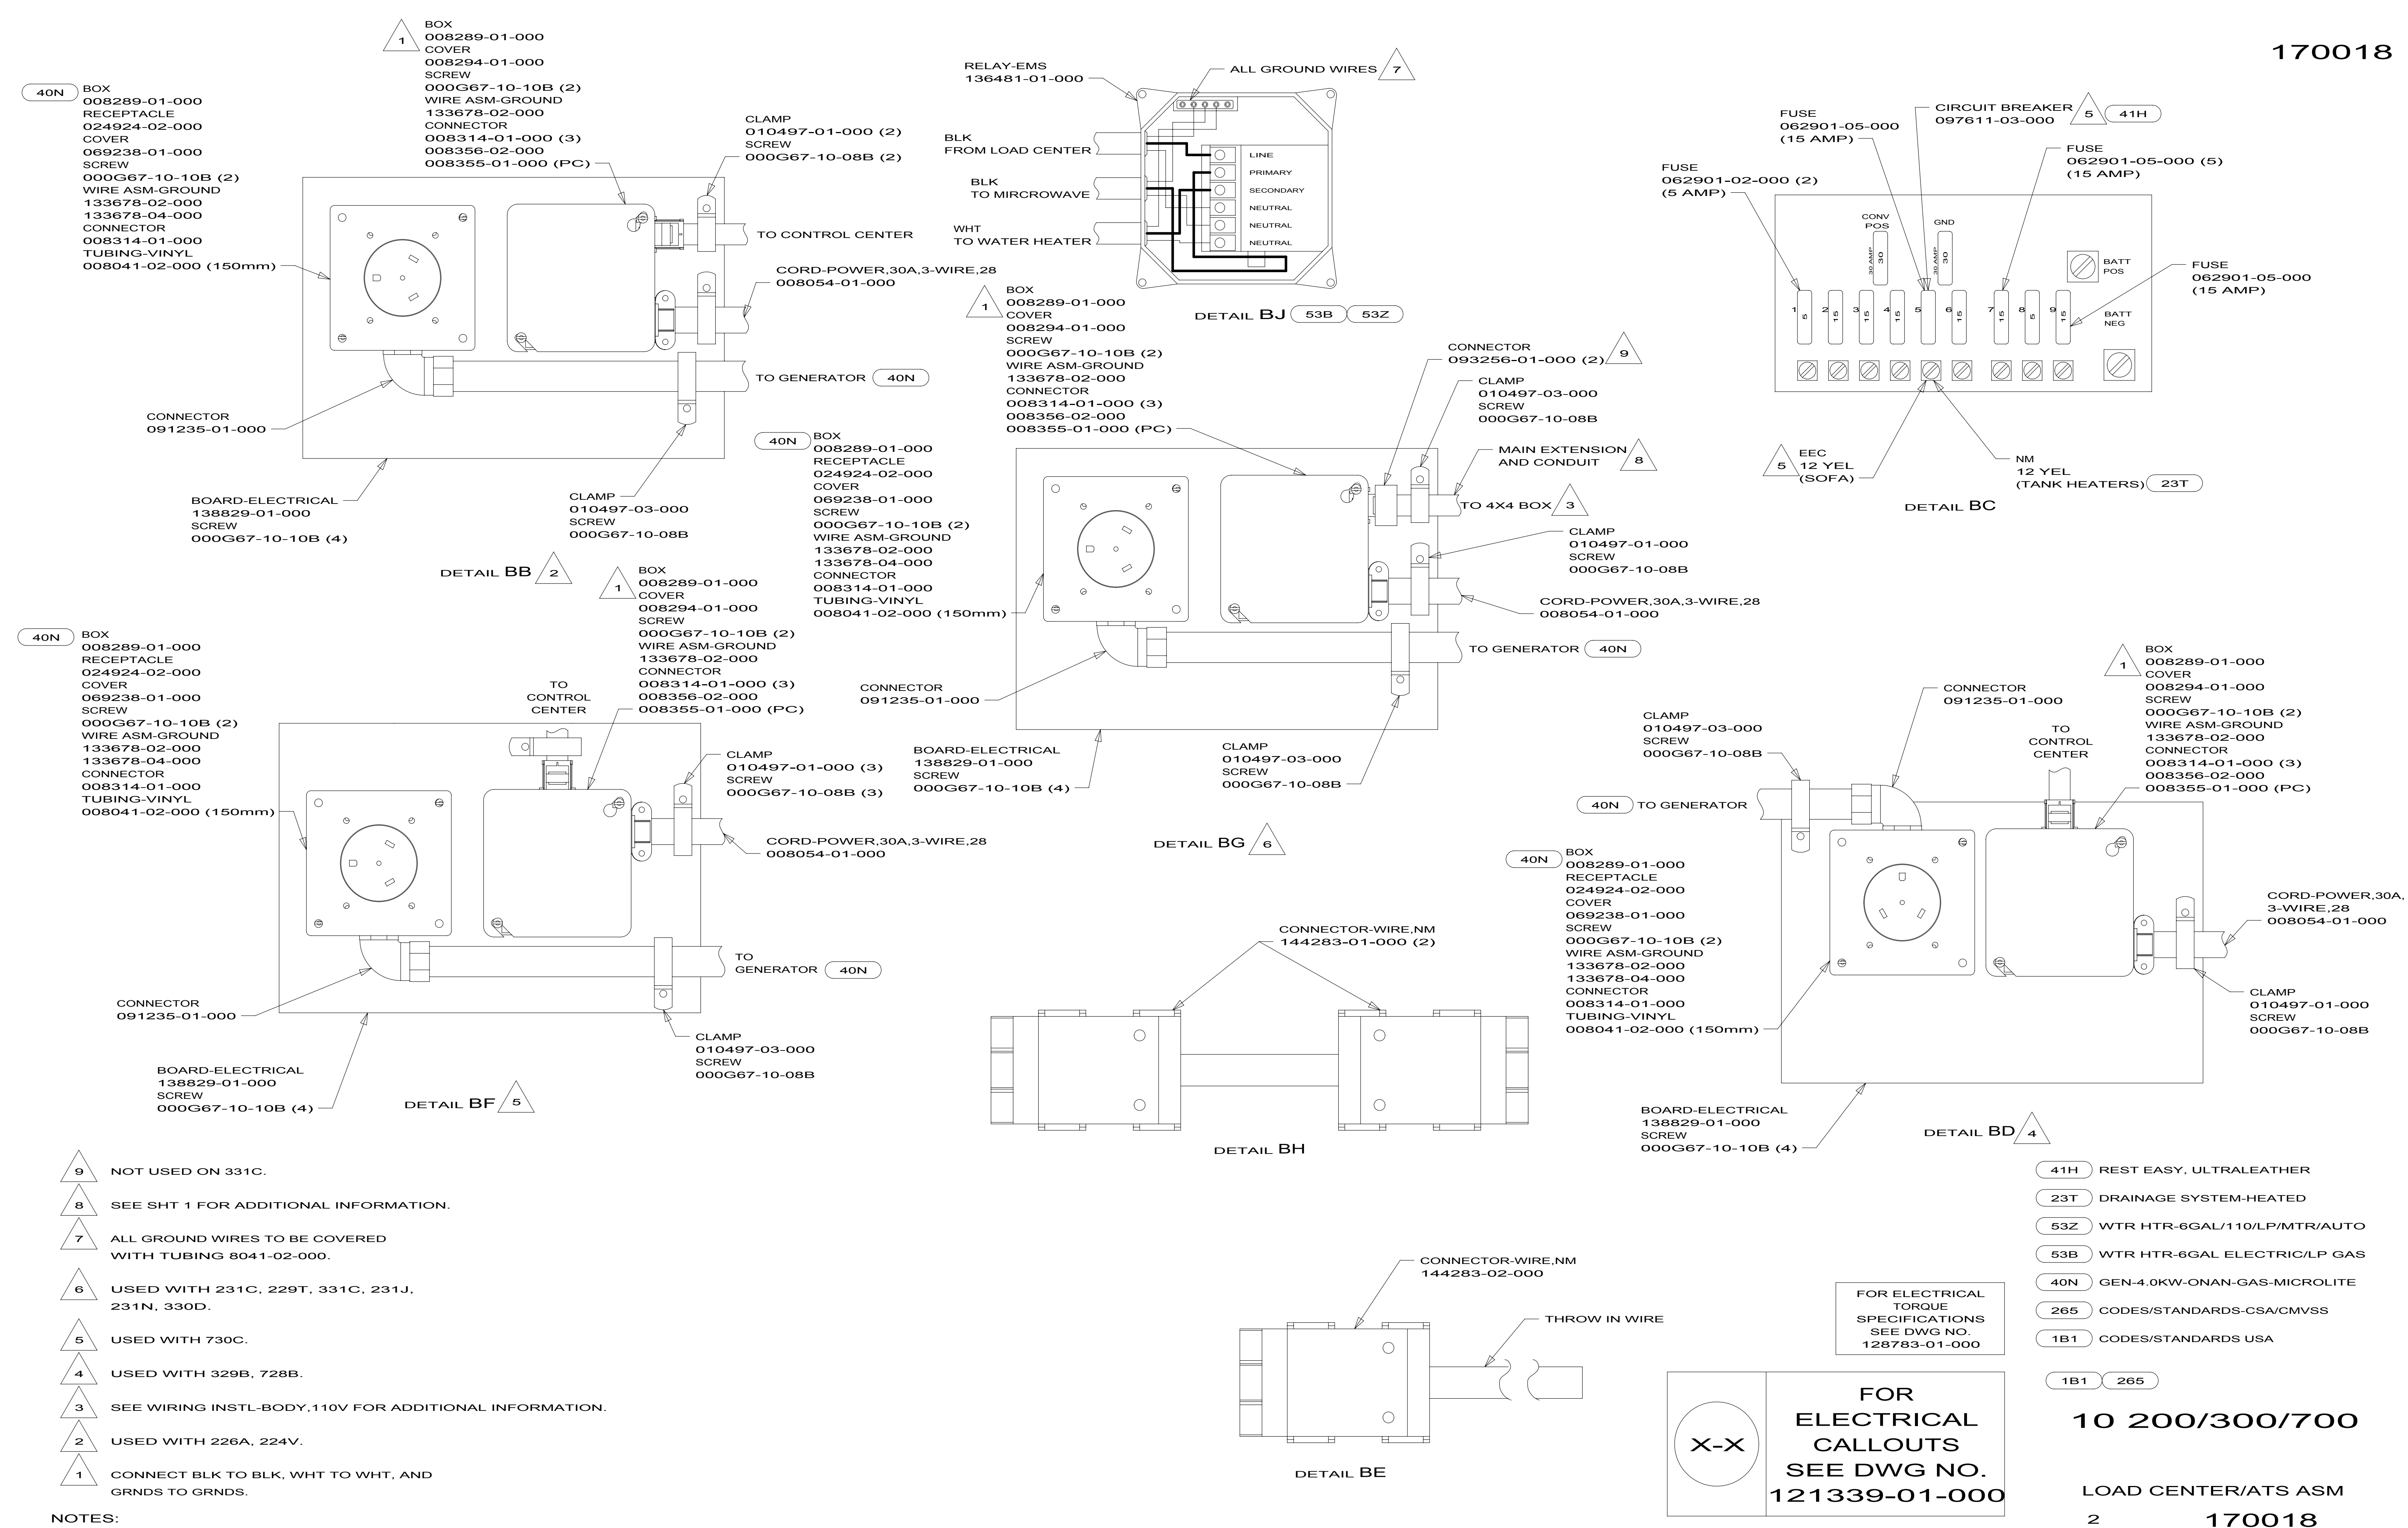

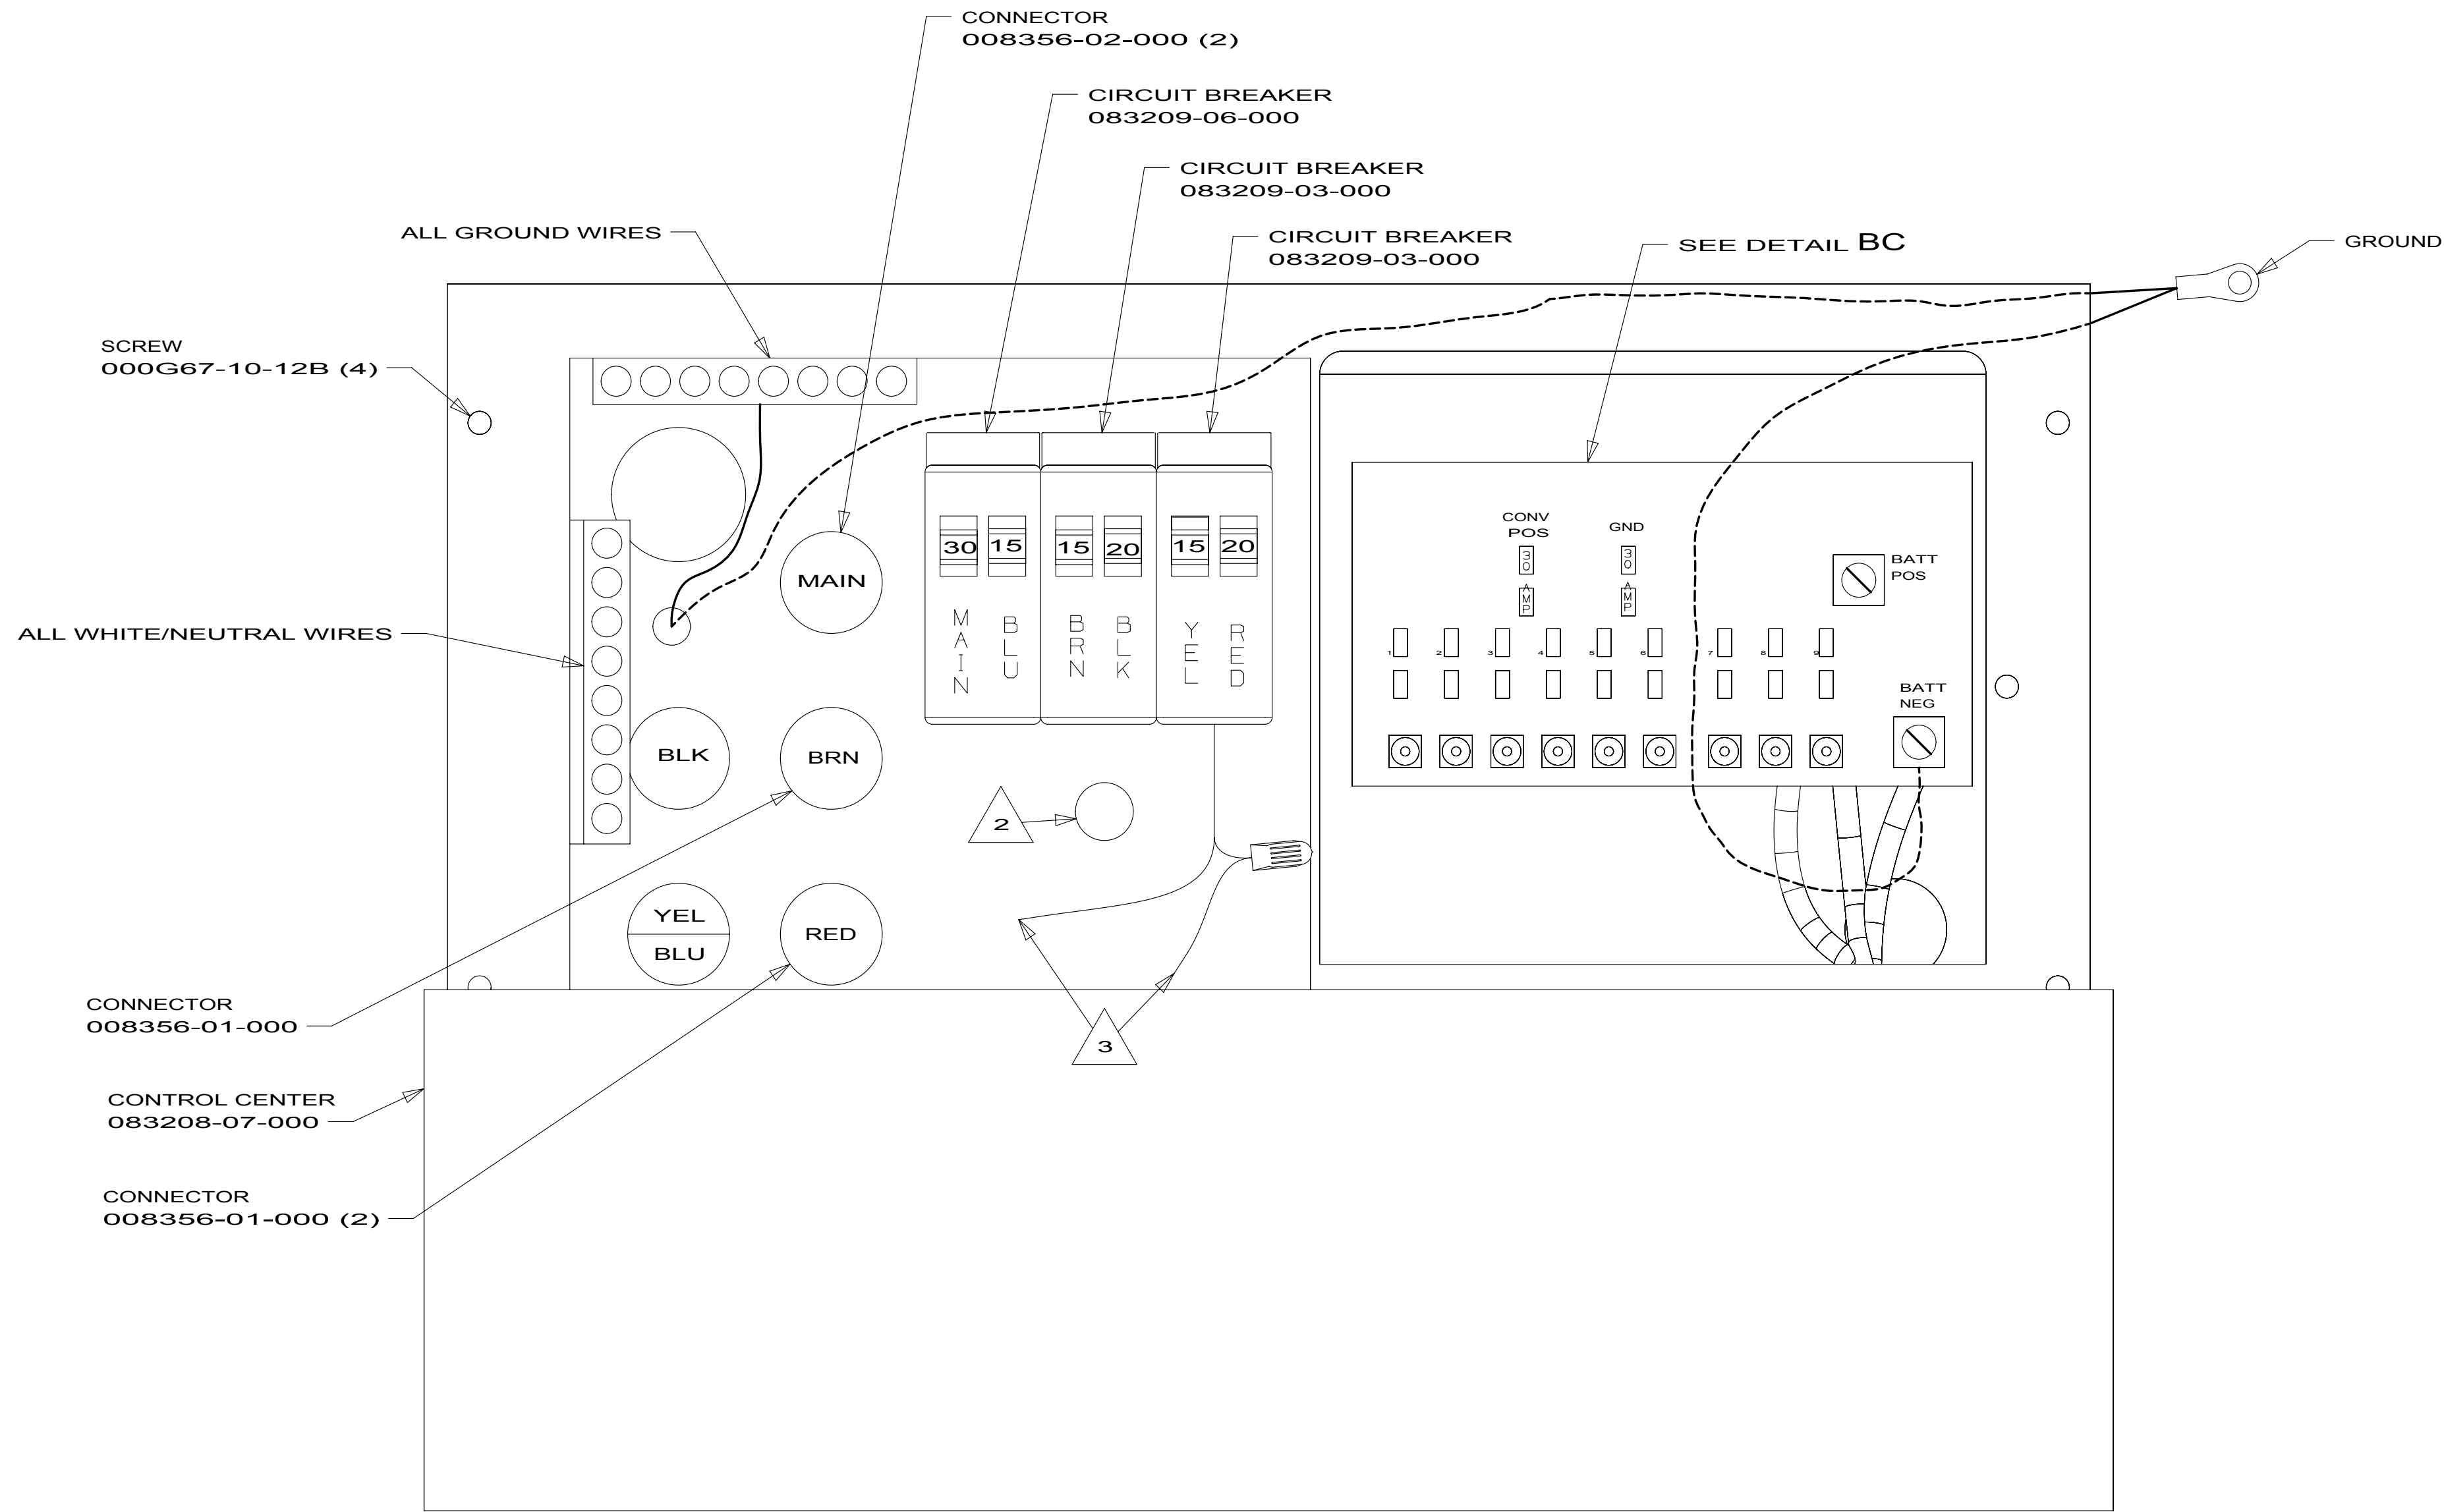

3 CONNECT CONVERTER POWER INTO YELLOW BREAKER AND USE SUPPLIED WIRE NUT TO CONNECT YELLOW CIRCUIT.

2 SECURE WIRES TO BACKSIDE OF LOAD CENTER WITH WIRE TIE 116673-01-000.

1. ALL GROUND WIRES TO BE COVERED WITH TUBING 008041-02-000.

NOTES:

265 CODES/STANDARDS-CSA/CMVSS

1B1 CODES/STANDARDS USA

1B1 265

10 200/300/700


LOAD CENTER/ATS ASM

3

170018

FOR ELECTRICAL
TORQUE
SPECIFICATIONS
SEE DWG NO.
128783-01-000

FOR
ELECTRICAL
CALLOUTS
SEE DWG NO.
121339-01-000

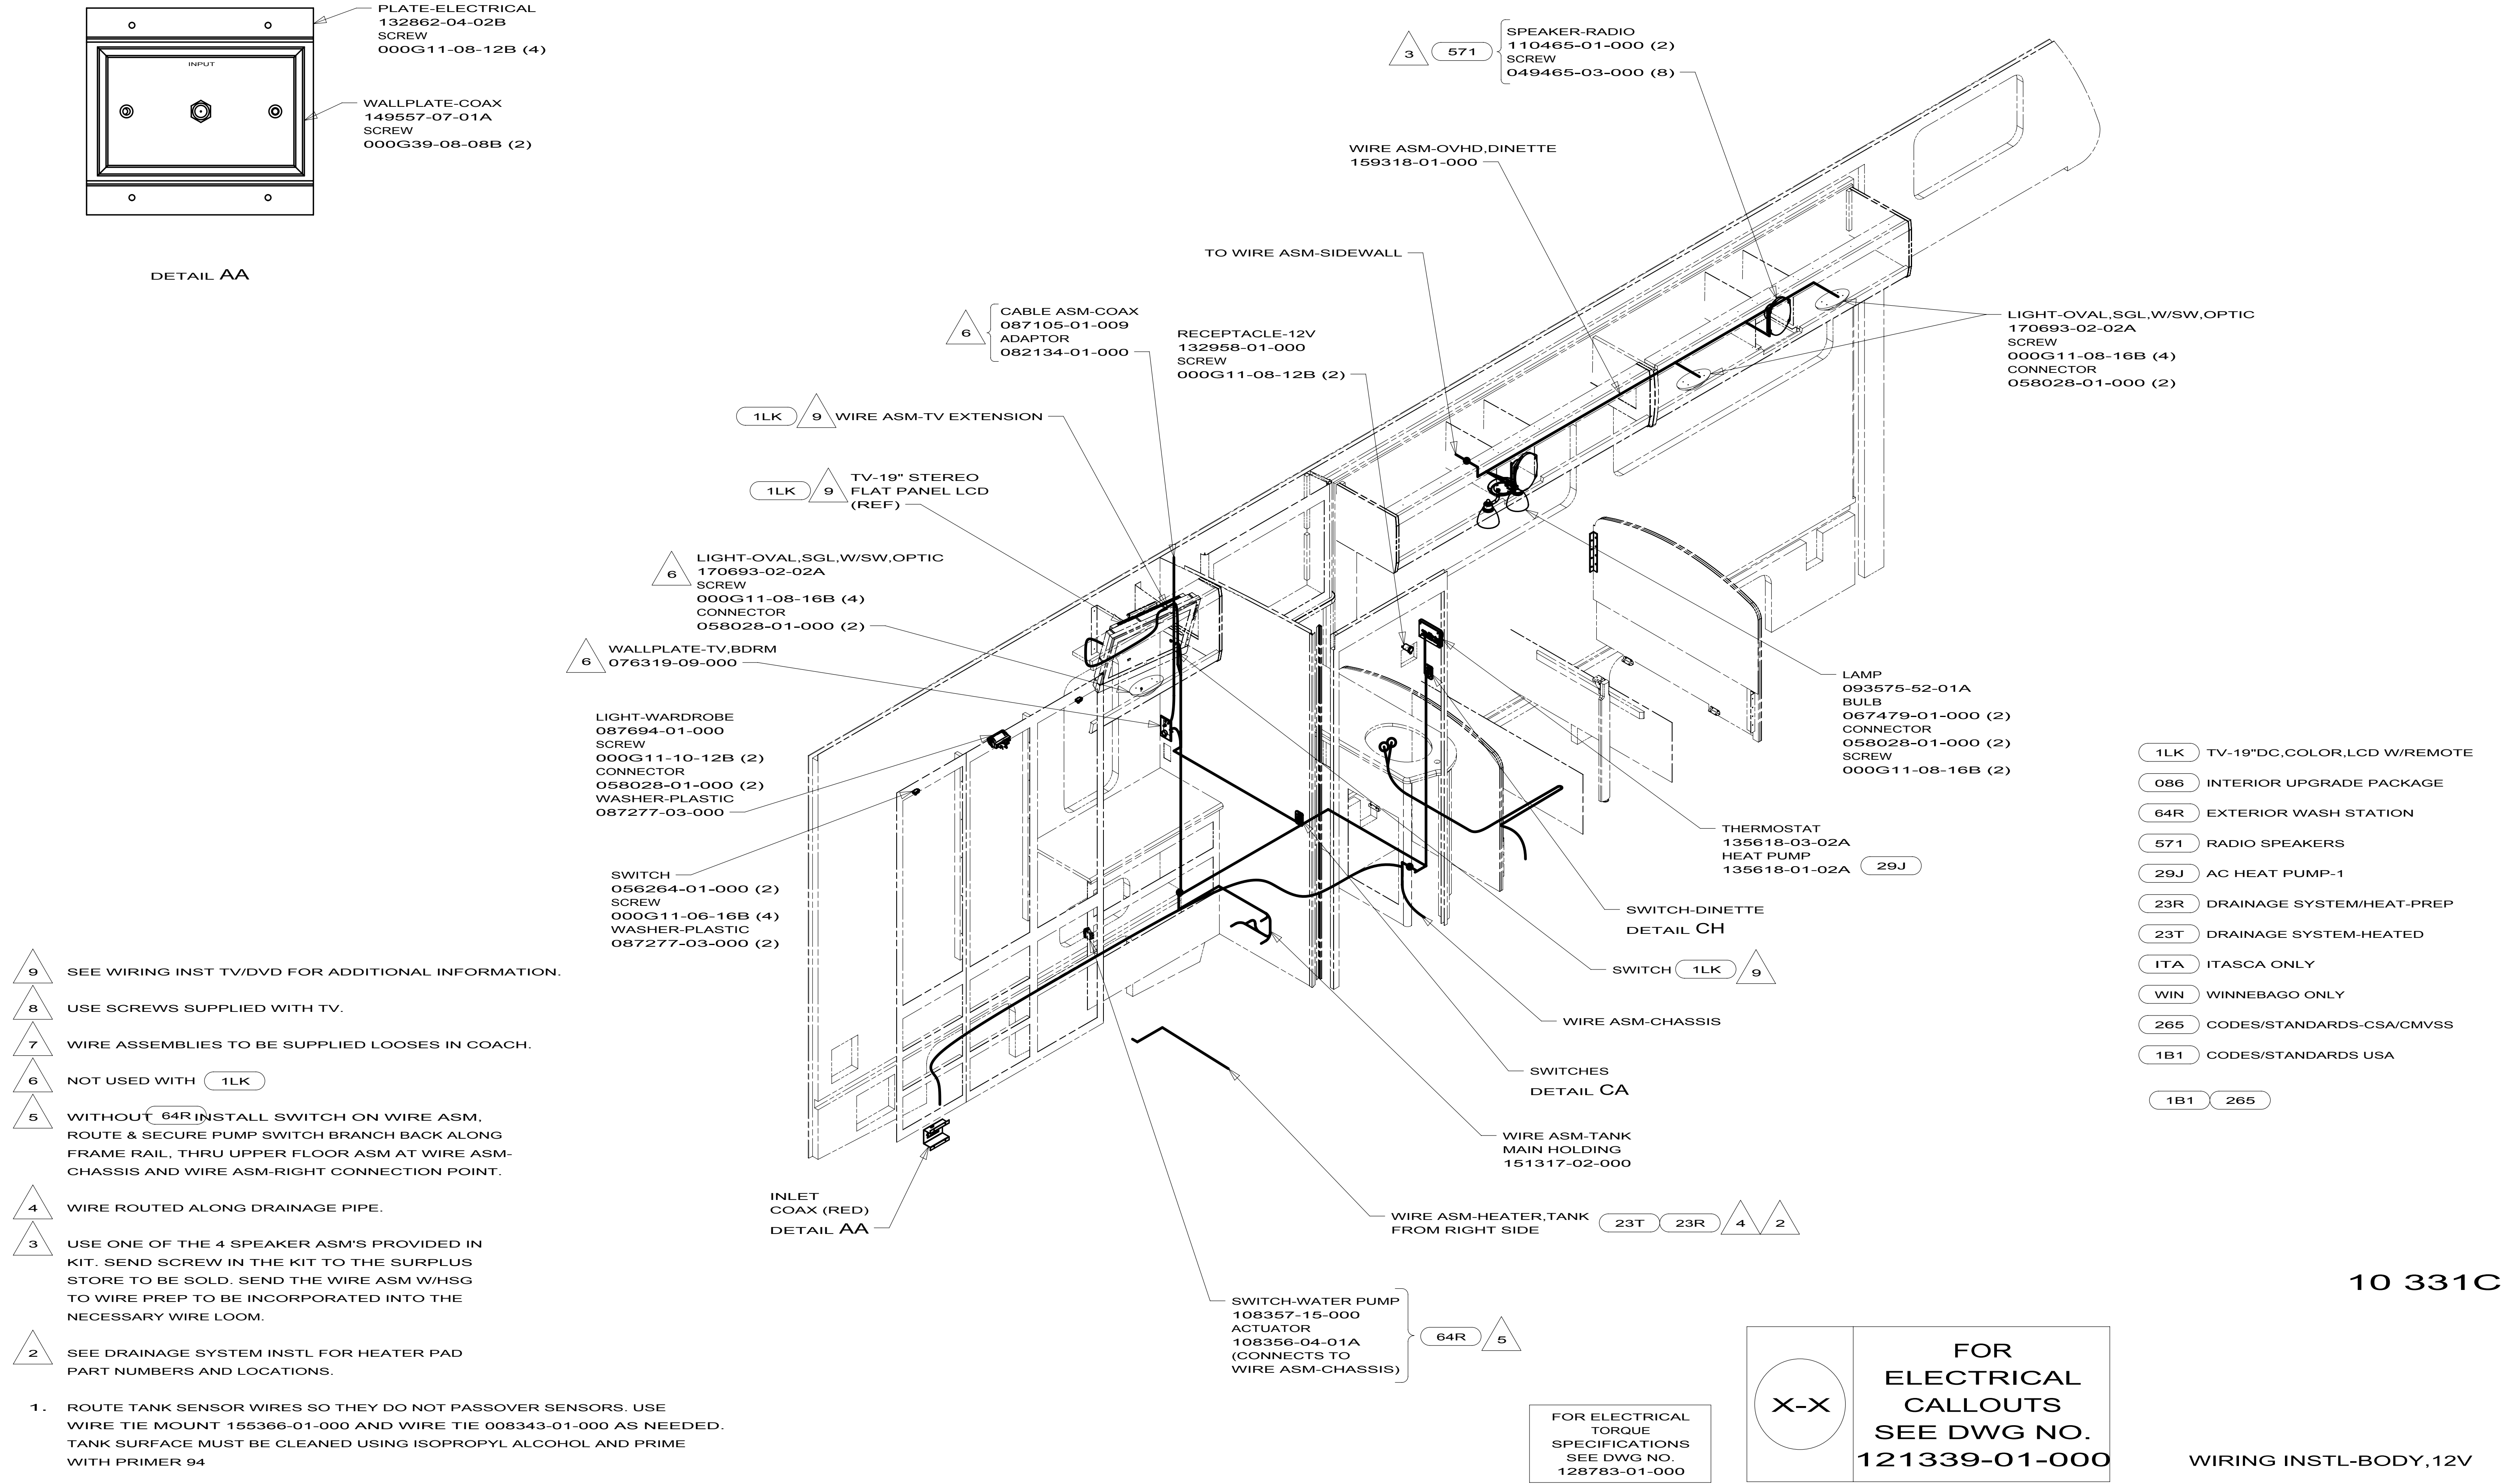

NOTES:

- 1. ROUTE TANK SENSOR WIRES SO THEY DO NOT PASSOVER SENSORS. USE WIRE TIE MOUNT 155366-01-000 AND WIRE TIE 008343-01-000 AS NEEDED. TANK SURFACE MUST BE CLEANED USING ISOPROPYL ALCOHOL AND PRIME WITH PRIMER 94

10 331C


FOR ELECTRICAL
TORQUE
SPECIFICATIONS
SEE DWG NO.
128783-01-000


X-X

FOR
ELECTRICAL
CALLOUTS
SEE DWG NO.
121339-01-000

WIRING INSTL-BODY,12V


1 6 170103

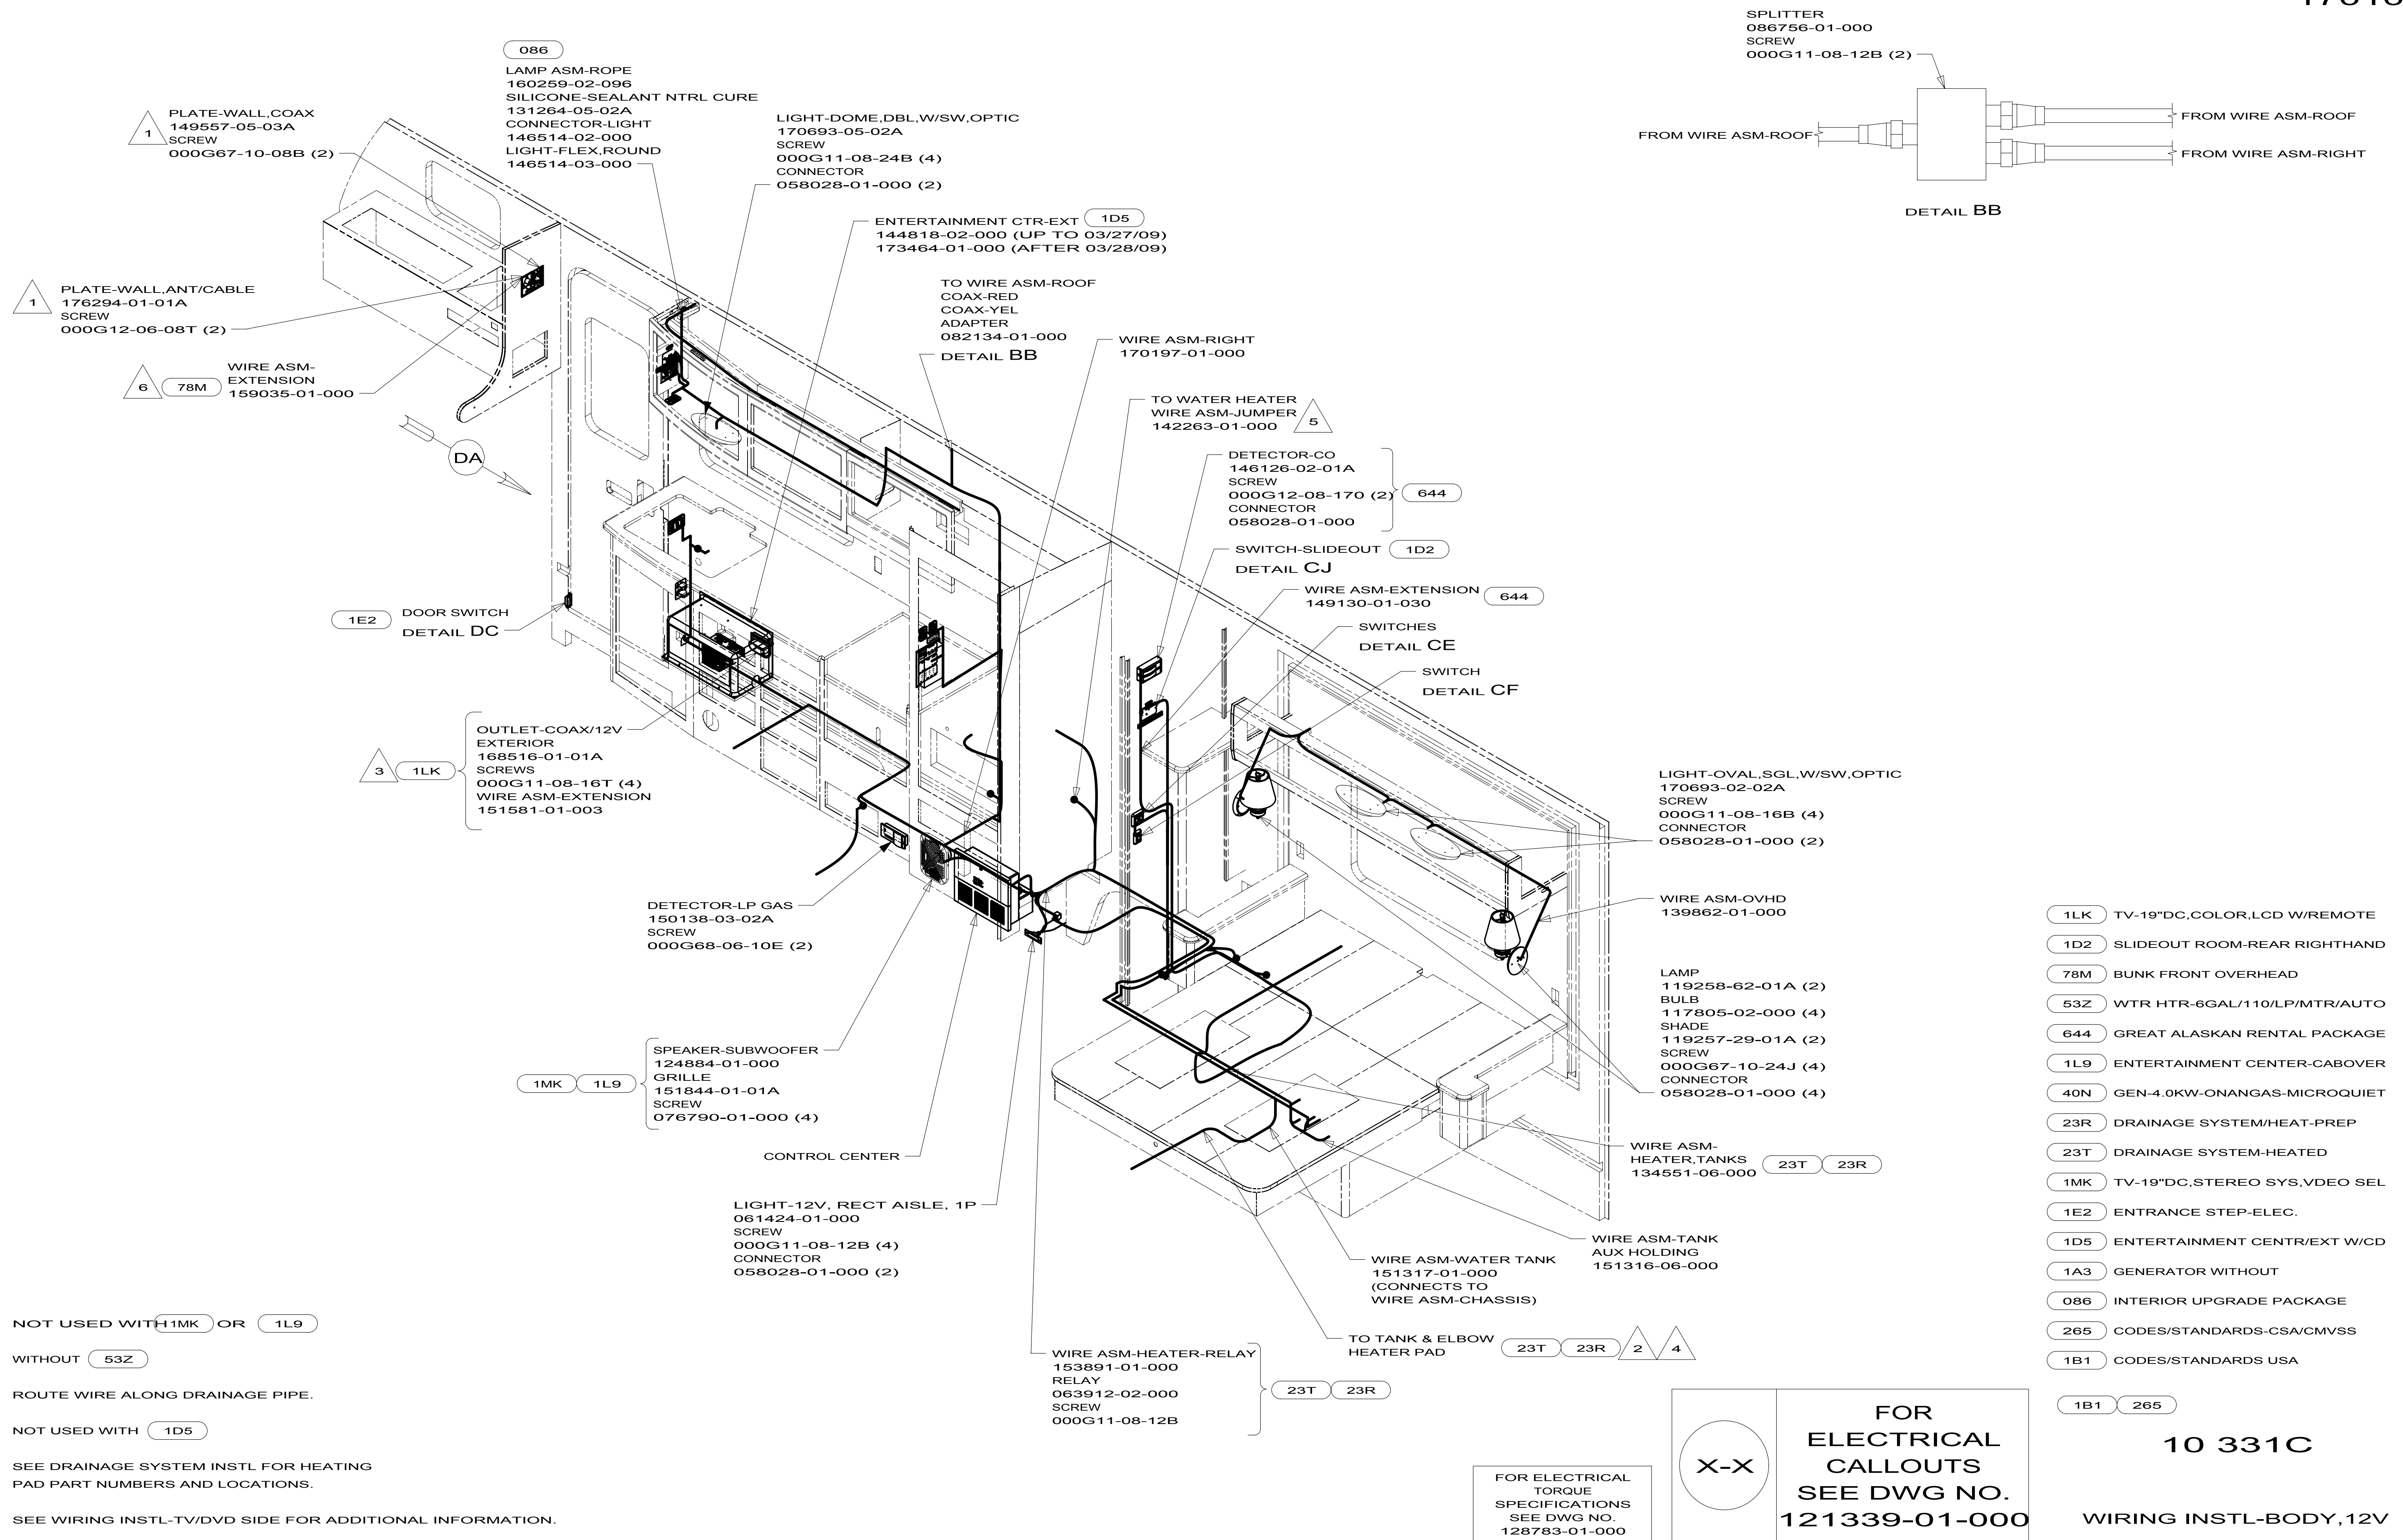

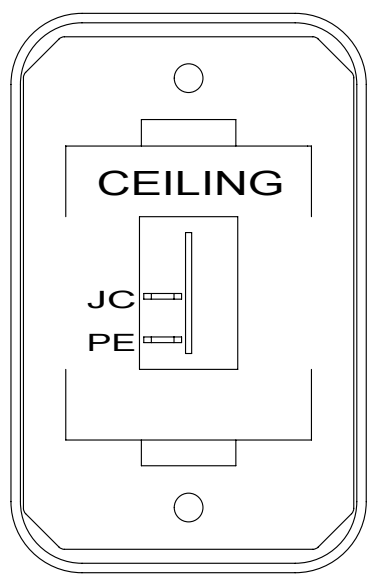

SWITCH-ROCKER
135740-01-01A
SWITCH-BASE
135741-01-01A
SWITCH-BEZEL
135742-07-02A
SCREW
000G11-08-08B (2)

DETAIL CA

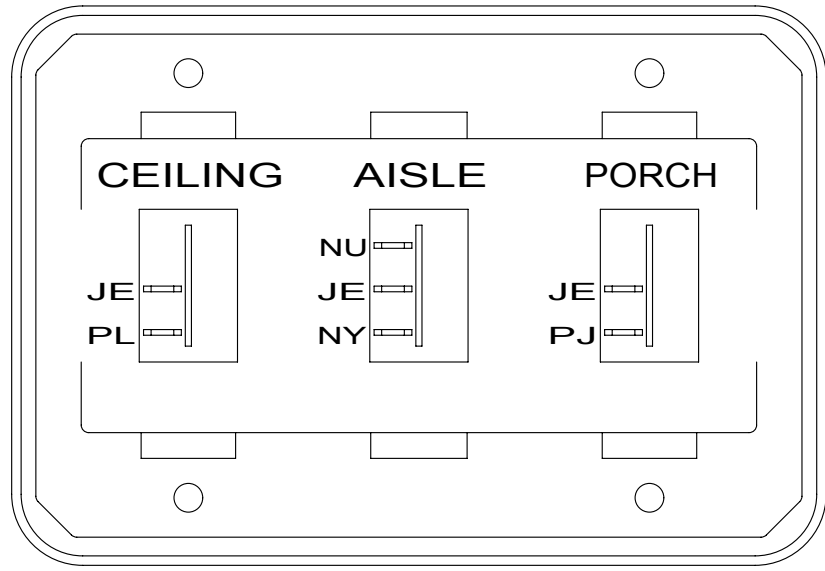


SWITCH-ROCKER
135740-01-01A (2)
135740-02-01A
SWITCH-BASE
135741-03-01A
SWITCH-BEZEL
135742-26-02A
SCREW
000G11-08-08B (4)


DETAIL CB

DRIVER'S
SIDE FRONT

LABEL-SLIDEOUT, DRIVER, FRONT
163992-01-01A

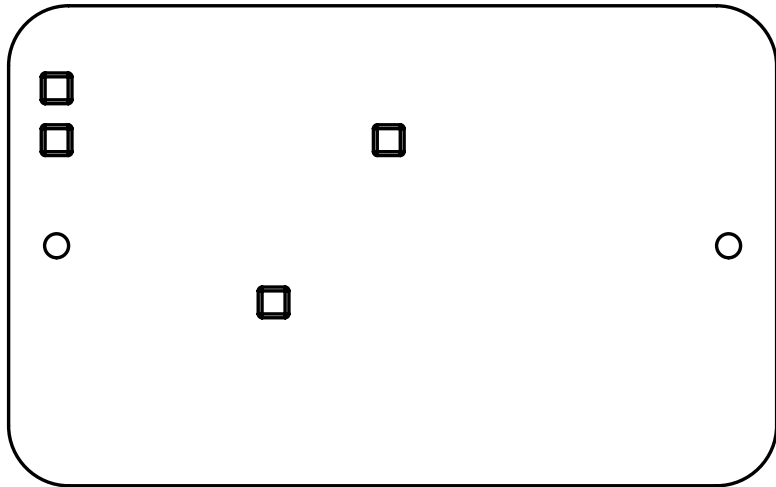

SWITCH, SLIDEOUT
138173-04-000 (UP TO 06-21-09)
171341-01-000 (AFTER 06-22-09)
SCREW
076790-05-000 (2)

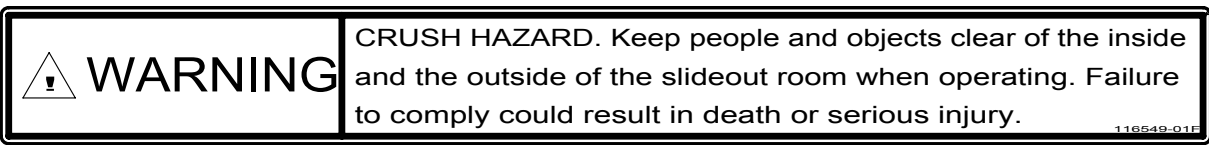

LABEL-WARNING, SLIDEOUT
116549-01-000


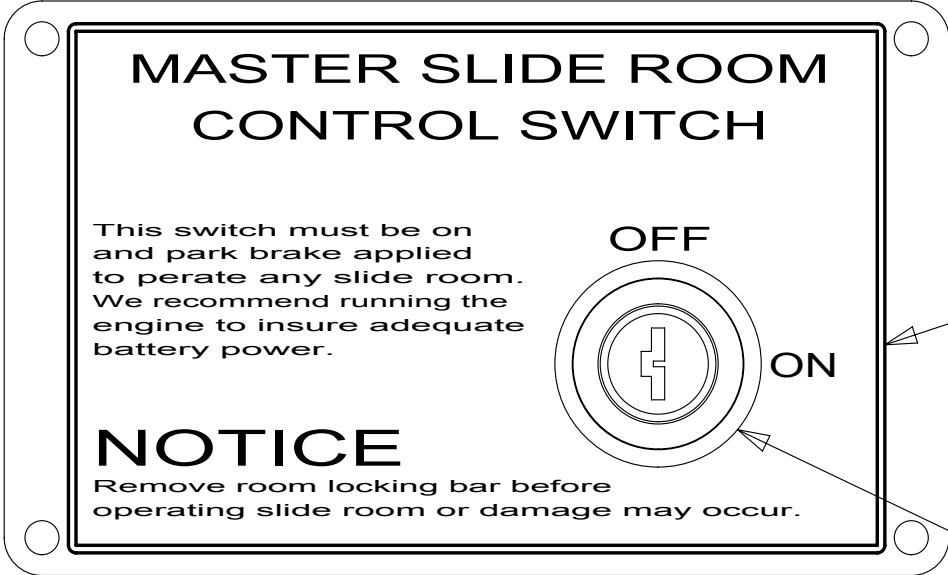


PLATE-KEY, SLIDE ROOM
163987-01-02B
SCREW
076790-05-000 (4)


LABEL-SLIDROOM CONTROL, MAN
163988-01-01A

SWITCH-KEY, SPST-ILLINOIS LCK
163097-01-000


DETAIL CD

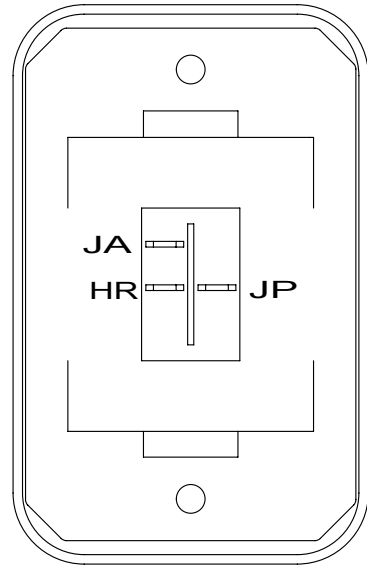

SWITCH-ROCKER
135740-06-01A
SWITCH-BASE
135741-01-01A
SWITCH-BEZEL
135742-01-01A
SCREW
000G11-08-08B (2)
LABEL-SWITCH
134563-01-02A

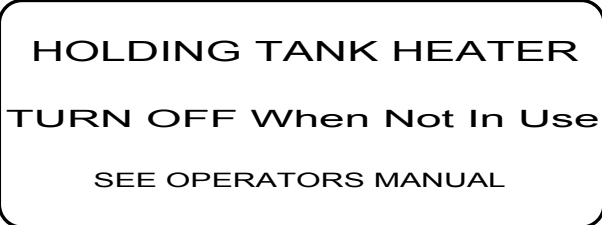


DETAIL CG 23T OR 23R

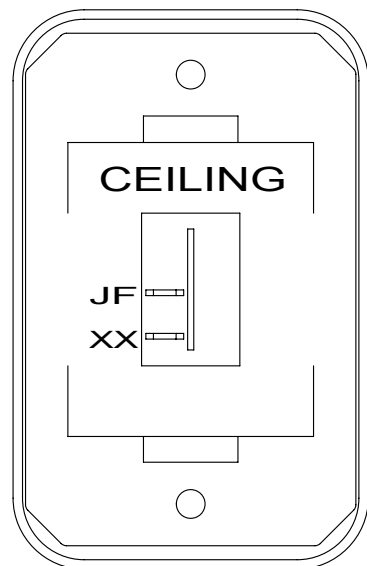

SWITCH-ROCKER
135740-01-01A
SWITCH-BASE
135741-01-01A
SWITCH-BEZEL
135742-07-02A
SCREW
000G11-08-08B (2)

DETAIL CH


PLATE-SWITCH
098351-22-02A
SCREW
000G11-06-10B (4)

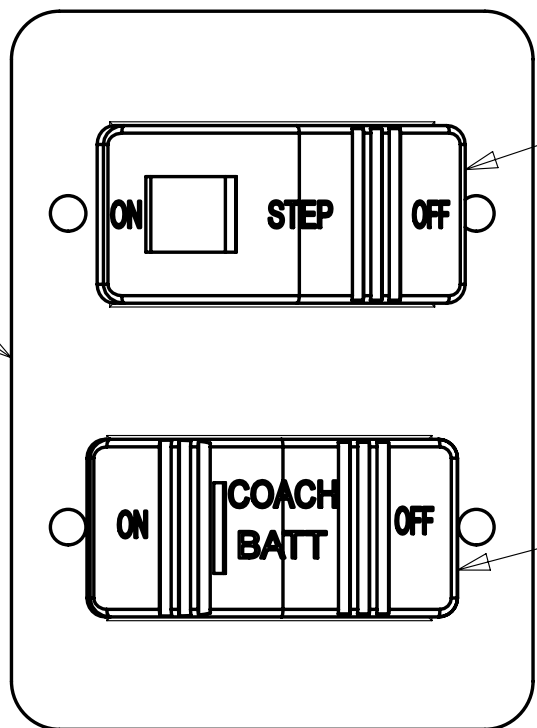

SWITCH-STEP
108357-19-000 1E2
SWITCH-BLANK
096241-03-000 1


SWITCH-BATT DISC
108357-17-000
ACTUATOR-BATT DISC
108356-19-01A

DETAIL CC

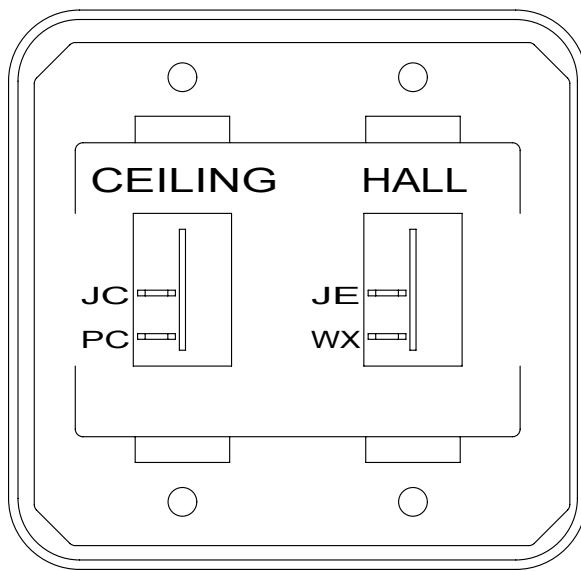


SWITCH-ROCKER
135740-01-01A (2)
SWITCH-BASE
135741-02-01A
SWITCH-BEZEL
135742-16-02A
SCREW
000G11-08-08B (4)

DETAIL CE

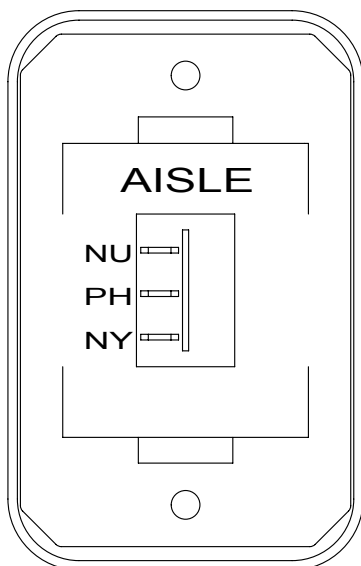

SWITCH-ROCKER
135740-02-01A
SWITCH-BASE
135741-01-01A
SWITCH-BEZEL
135742-06-02A
SCREW
000G11-08-08B (2)

DETAIL CF

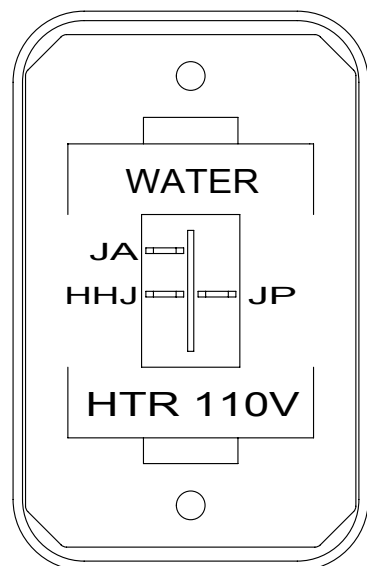


SWITCH-ROCKER
135740-06-01A
SWITCH-BASE
135741-01-01A
SWITCH-BEZEL
135742-35-02A
SCREW
000G11-08-08B (2)


DETAIL CK 53Z

PASSENGER'S
SIDE REAR

LABEL-SLIDEOUT, PASS, REAR
163992-03-01A

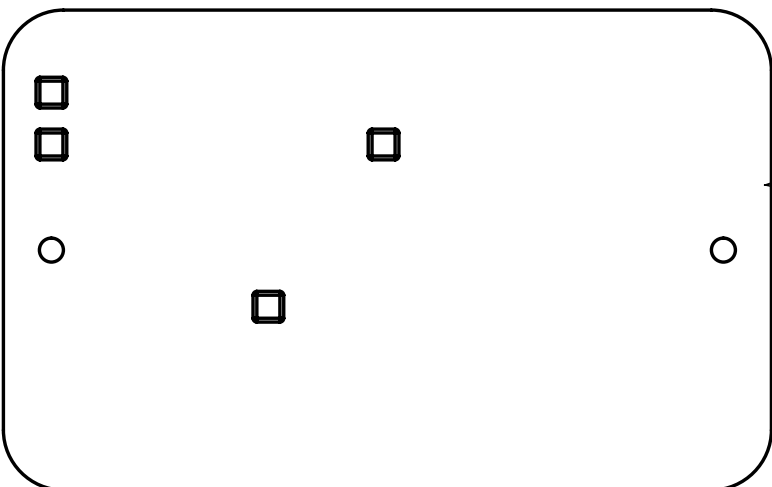


SWITCH-SLIDEOUT
138173-04-000 (UP TO 06-21-09)
171341-01-000 (AFTER 06-22-09)
SCREW
076790-05-000 (2)

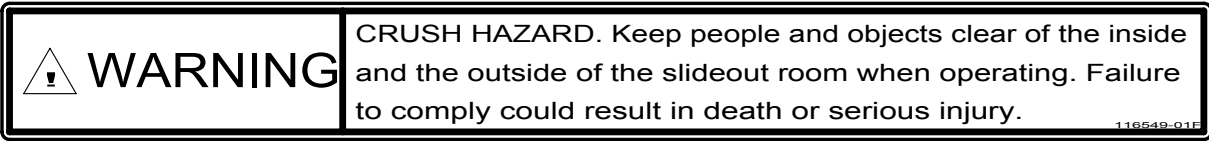

LABEL-WARNING, SLIDEOUT
116549-01-000

DETAIL CJ

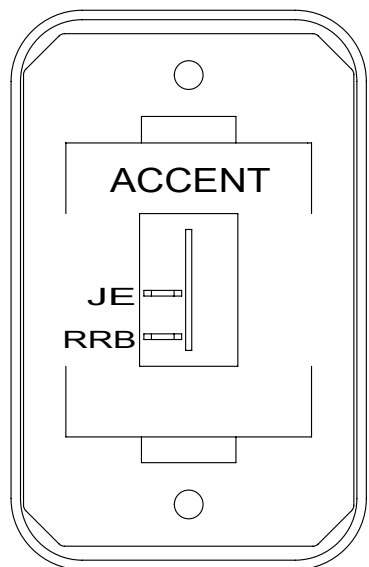

SWITCH-ROCKER
135740-01-01A
SWITCH-BASE
135741-01-01A
SWITCH-BEZEL
135742-50-02A
SCREW
000G11-08-08B (2)

DETAIL CM 086

- 1LK TV-19"DC, COLOR, LCD W/REMOTE
- 23R DRAINAGE SYSTEM/HEAT-PREWIRE
- 53Z WTR HTR-6GAL/110/LP/MTR/AUTO
- 23T DRAINAGE SYSTEM-HEATED
- 1E2 ENTRANCE STEP-ELEC.
- 086 INTERIOR UPGRADE PACKAGE
- 265 CODES/STANDARDS-CSA/CMVSS
- 1B1 CODES/STANDARDS USA

1B1 265

10 331C



WIRING INSTL-BODY, 12V

1 NOT USED WITH 1E2

NOTES:

FOR ELECTRICAL
TORQUE
SPECIFICATIONS
SEE DWG NO.
128783-01-000

FOR
ELECTRICAL
CALLOUTS
SEE DWG NO.
121339-01-000

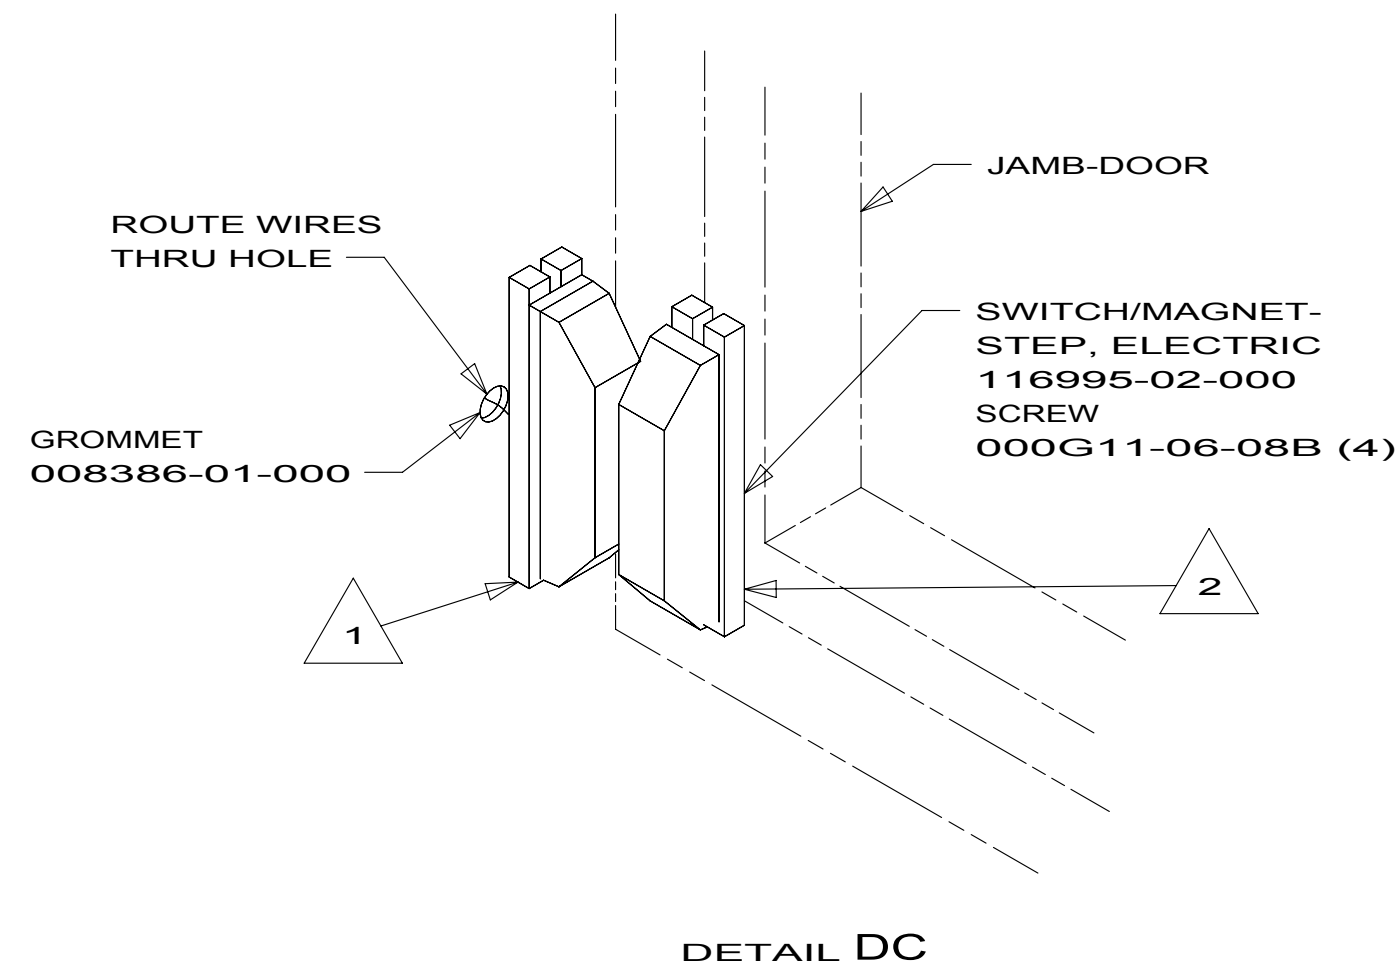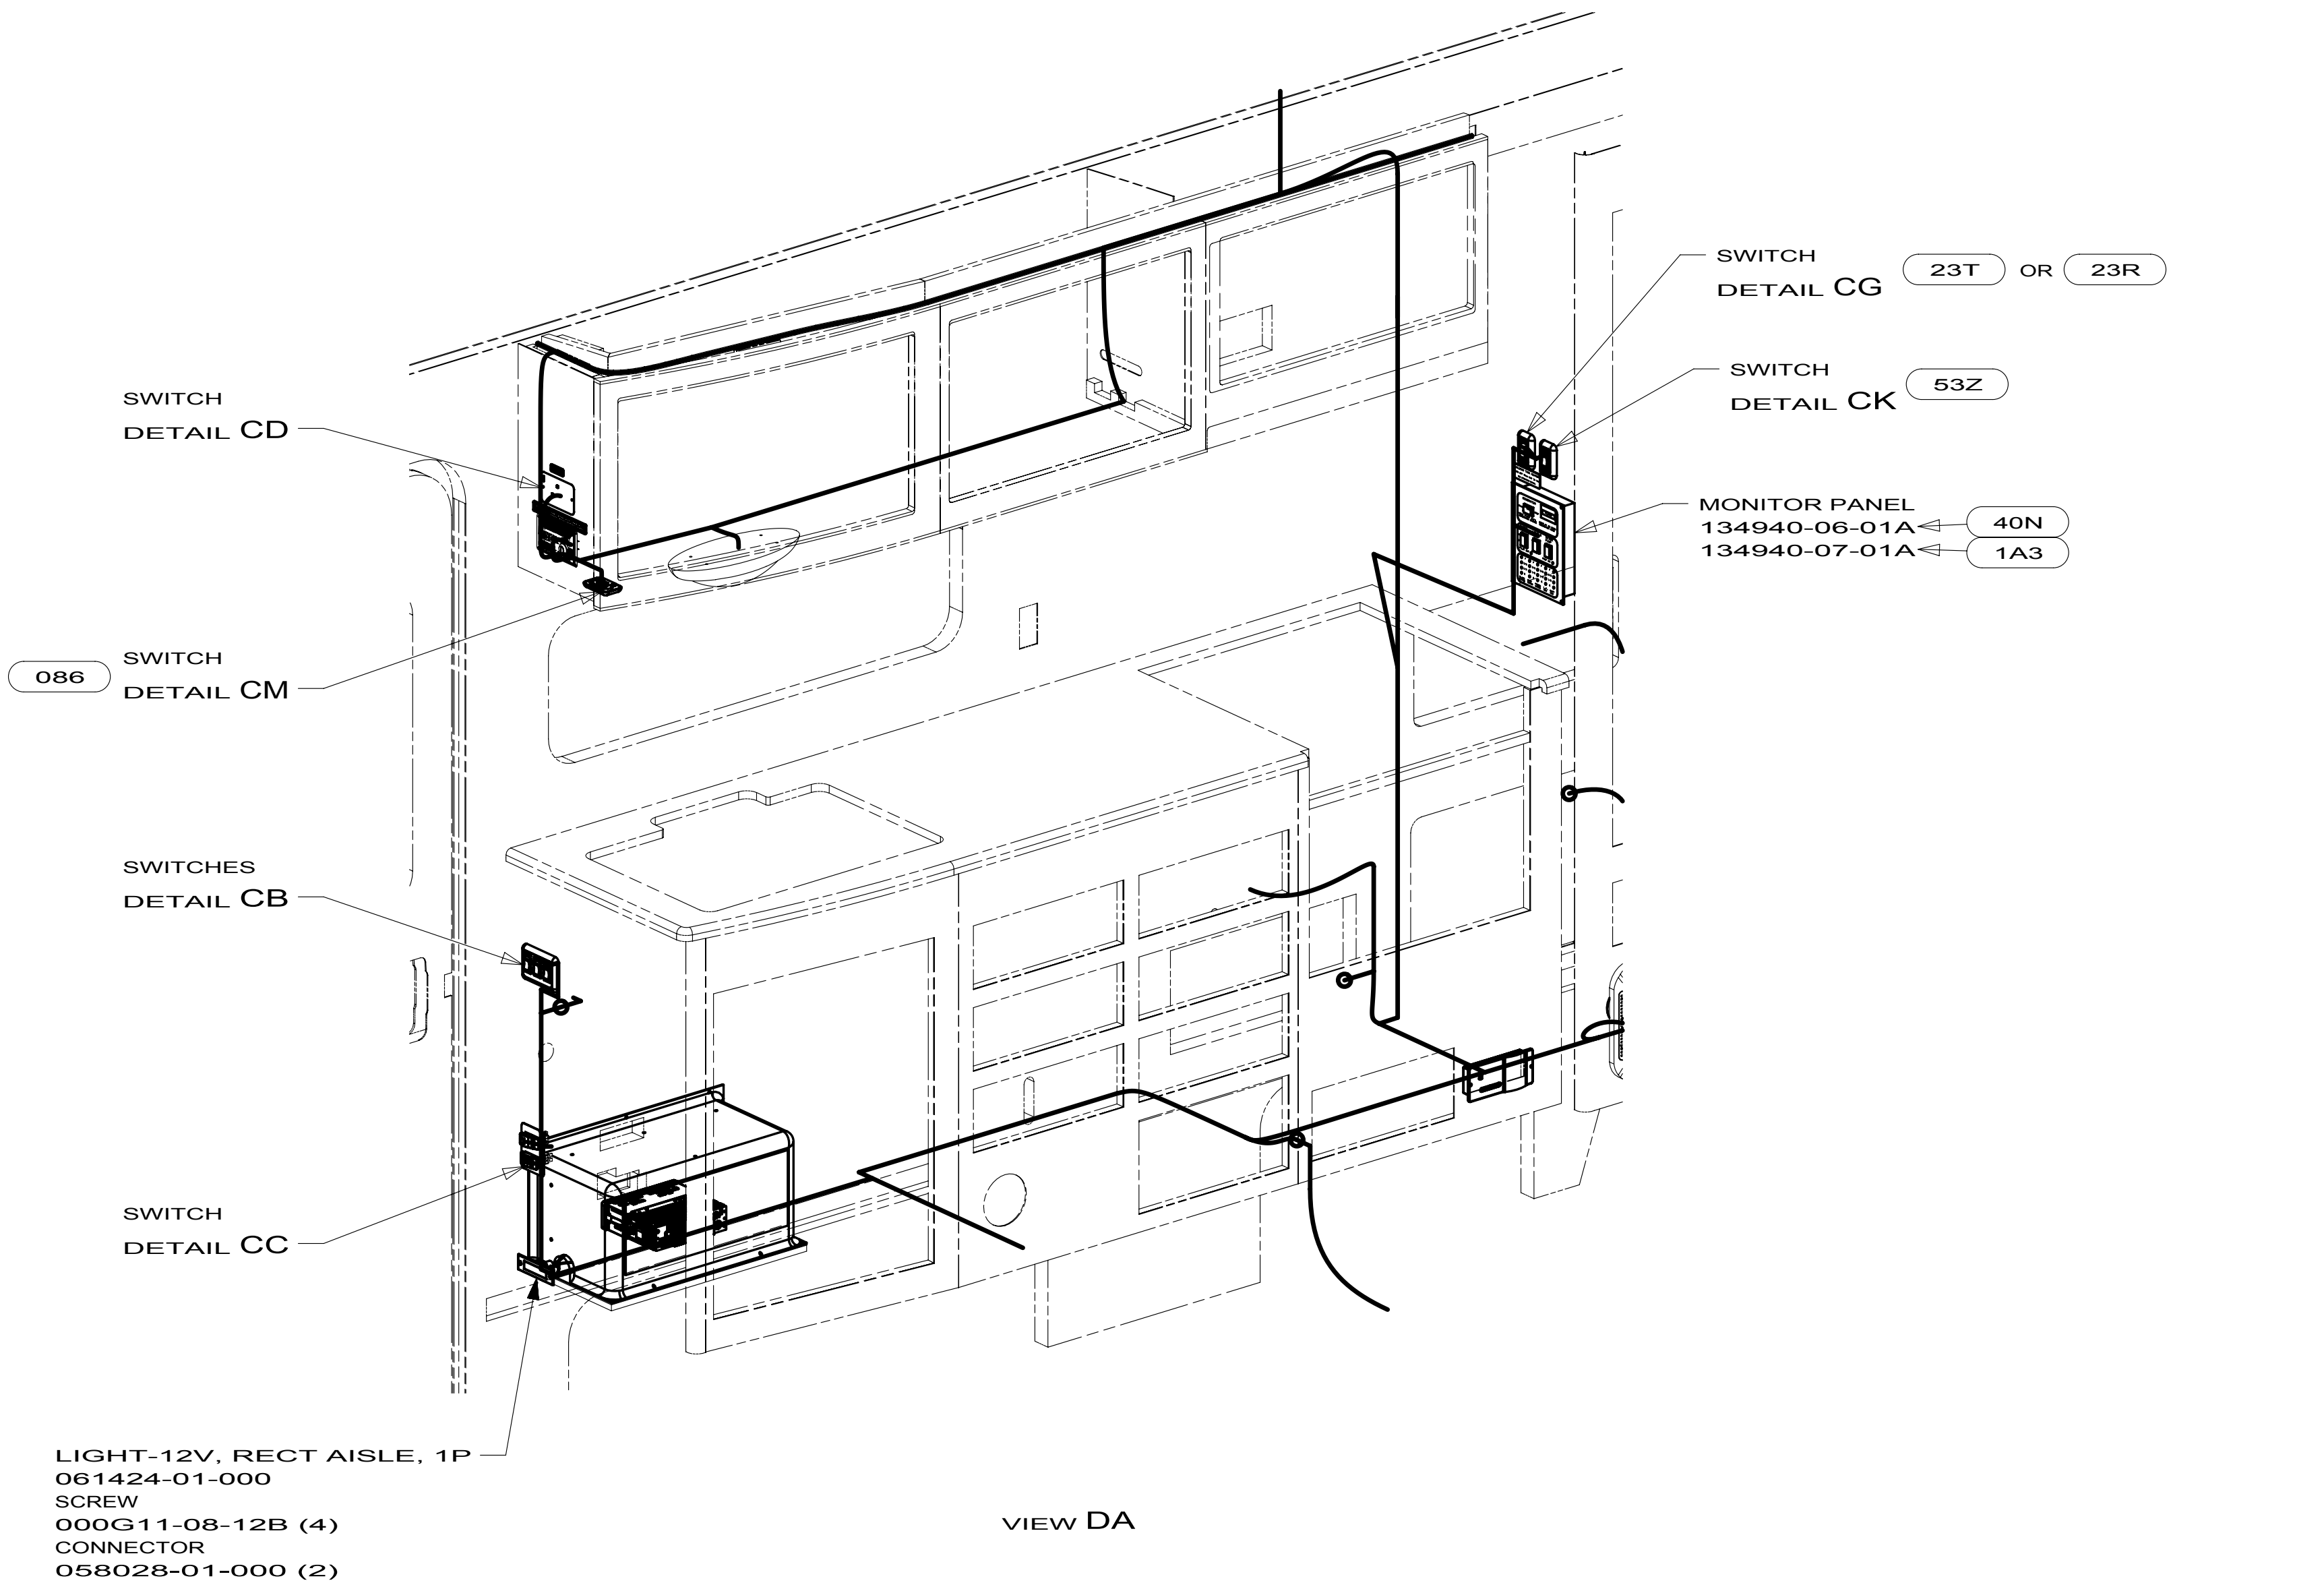

- 3 SEE WIRING INSTL-BODY, 110V FOR ADDITIONAL INFORMATION.
- 2 MOUNT MAGNET USING PILOT HOLES IN SCREEN DOOR FRAME
MOUNT WITH MAGNET TOWARD SWITCH.
- 1 MOUNT SWITCH AND SPACER TO BLOCK ON JAMB
ADJUST HEIGHT TO MATCH MAGNET.

NOTES:

FOR ELECTRICAL
TORQUE
SPECIFICATIONS
SEE DWG NO.
128783-01-000

X-X


FOR
ELECTRICAL
CALLOUTS
SEE DWG NO.
121339-01-000

- 53Z WTR HTR-6GAL/110/LP/MTR/AUTO
- 23R DRAINAGE SYSTEM/HEAT-PREWIRE
- 23T DRAINAGE SYSTEM-HEATED
- 086 INTERIOR UPGRADE PACKAGE
- 50H RADIOS TWO-WAY (4)
- 40N GEN-4.0KW-ONANGAS-MICROQUIET
- 23T DRAINAGE SYSTEM-HEATED
- 1E2 ENTRANCE STEP-ELEC.
- 1A3 GENERATOR WITHOUT
- 265 CODES/STANDARDS-CSA/CMVSS
- 1B1 CODES/STANDARDS USA

1B1 265

10 331C

WIRING INSTL-BODY, 12V

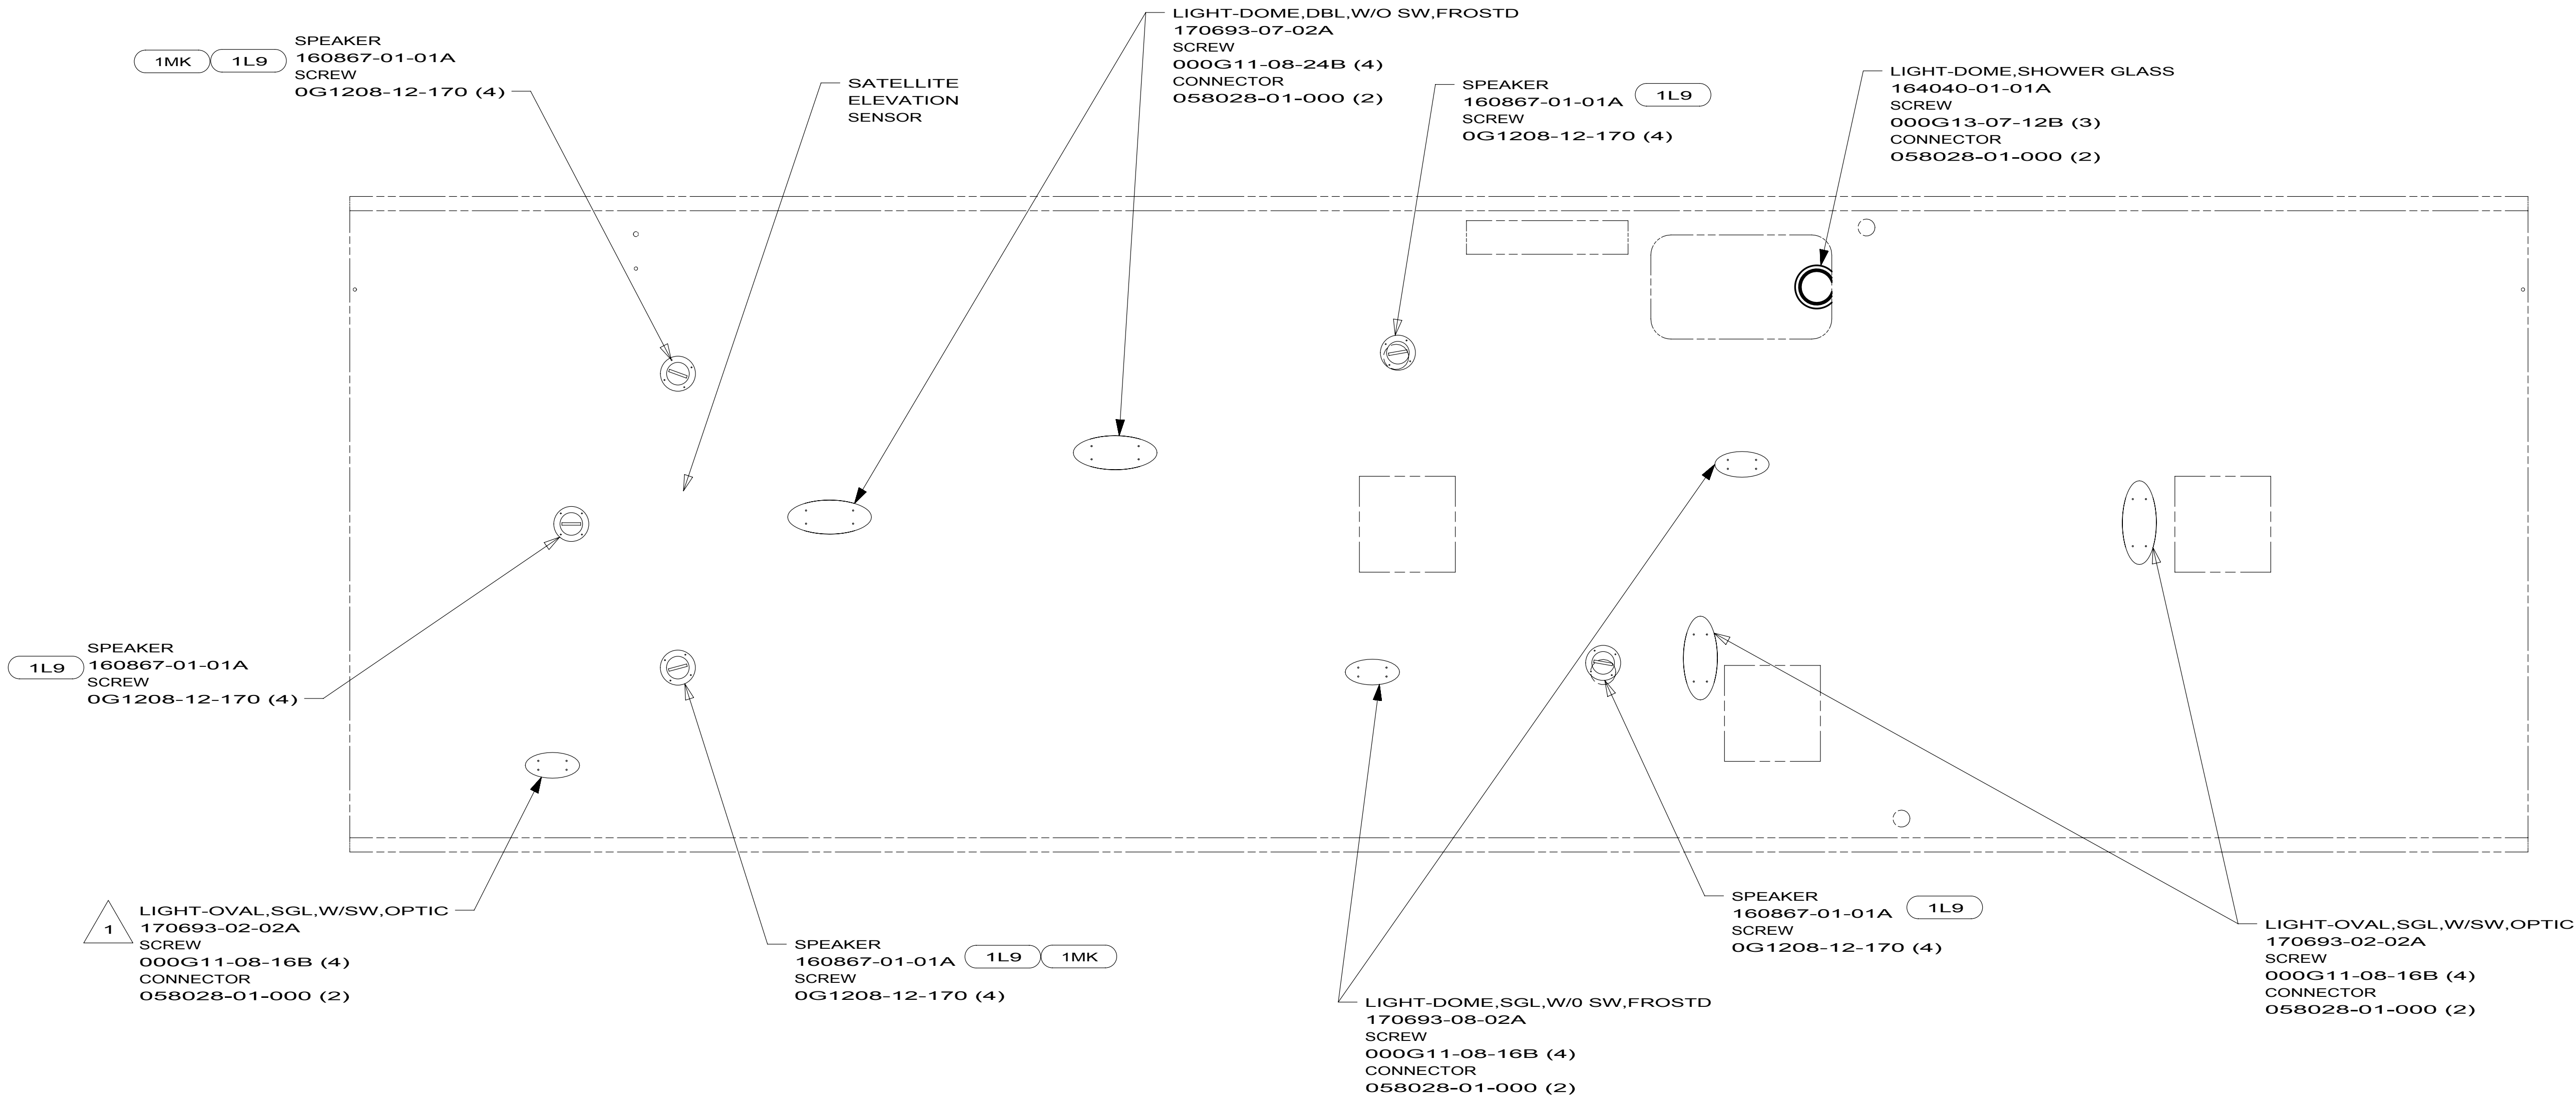

NOTES:

1 NOT USED WITH 1L9

FOR ELECTRICAL TORQUE SPECIFICATIONS SEE DWG NO. 128783-01-000

X-X


FOR ELECTRICAL CALLOUTS SEE DWG NO. 121339-01-000

- 1MK TV-19"DC, STEREO SYS, VDEO SEL
- 1L9 ENTERTAINMENT CENTER-CABOVER
- 265 CODES/STANDARDS-CSA/CMVSS
- 1B1 CODES/STANDARDS USA
- 1B1 265

10 331C

WIRING INSTL-BODY, 12V

5 170103

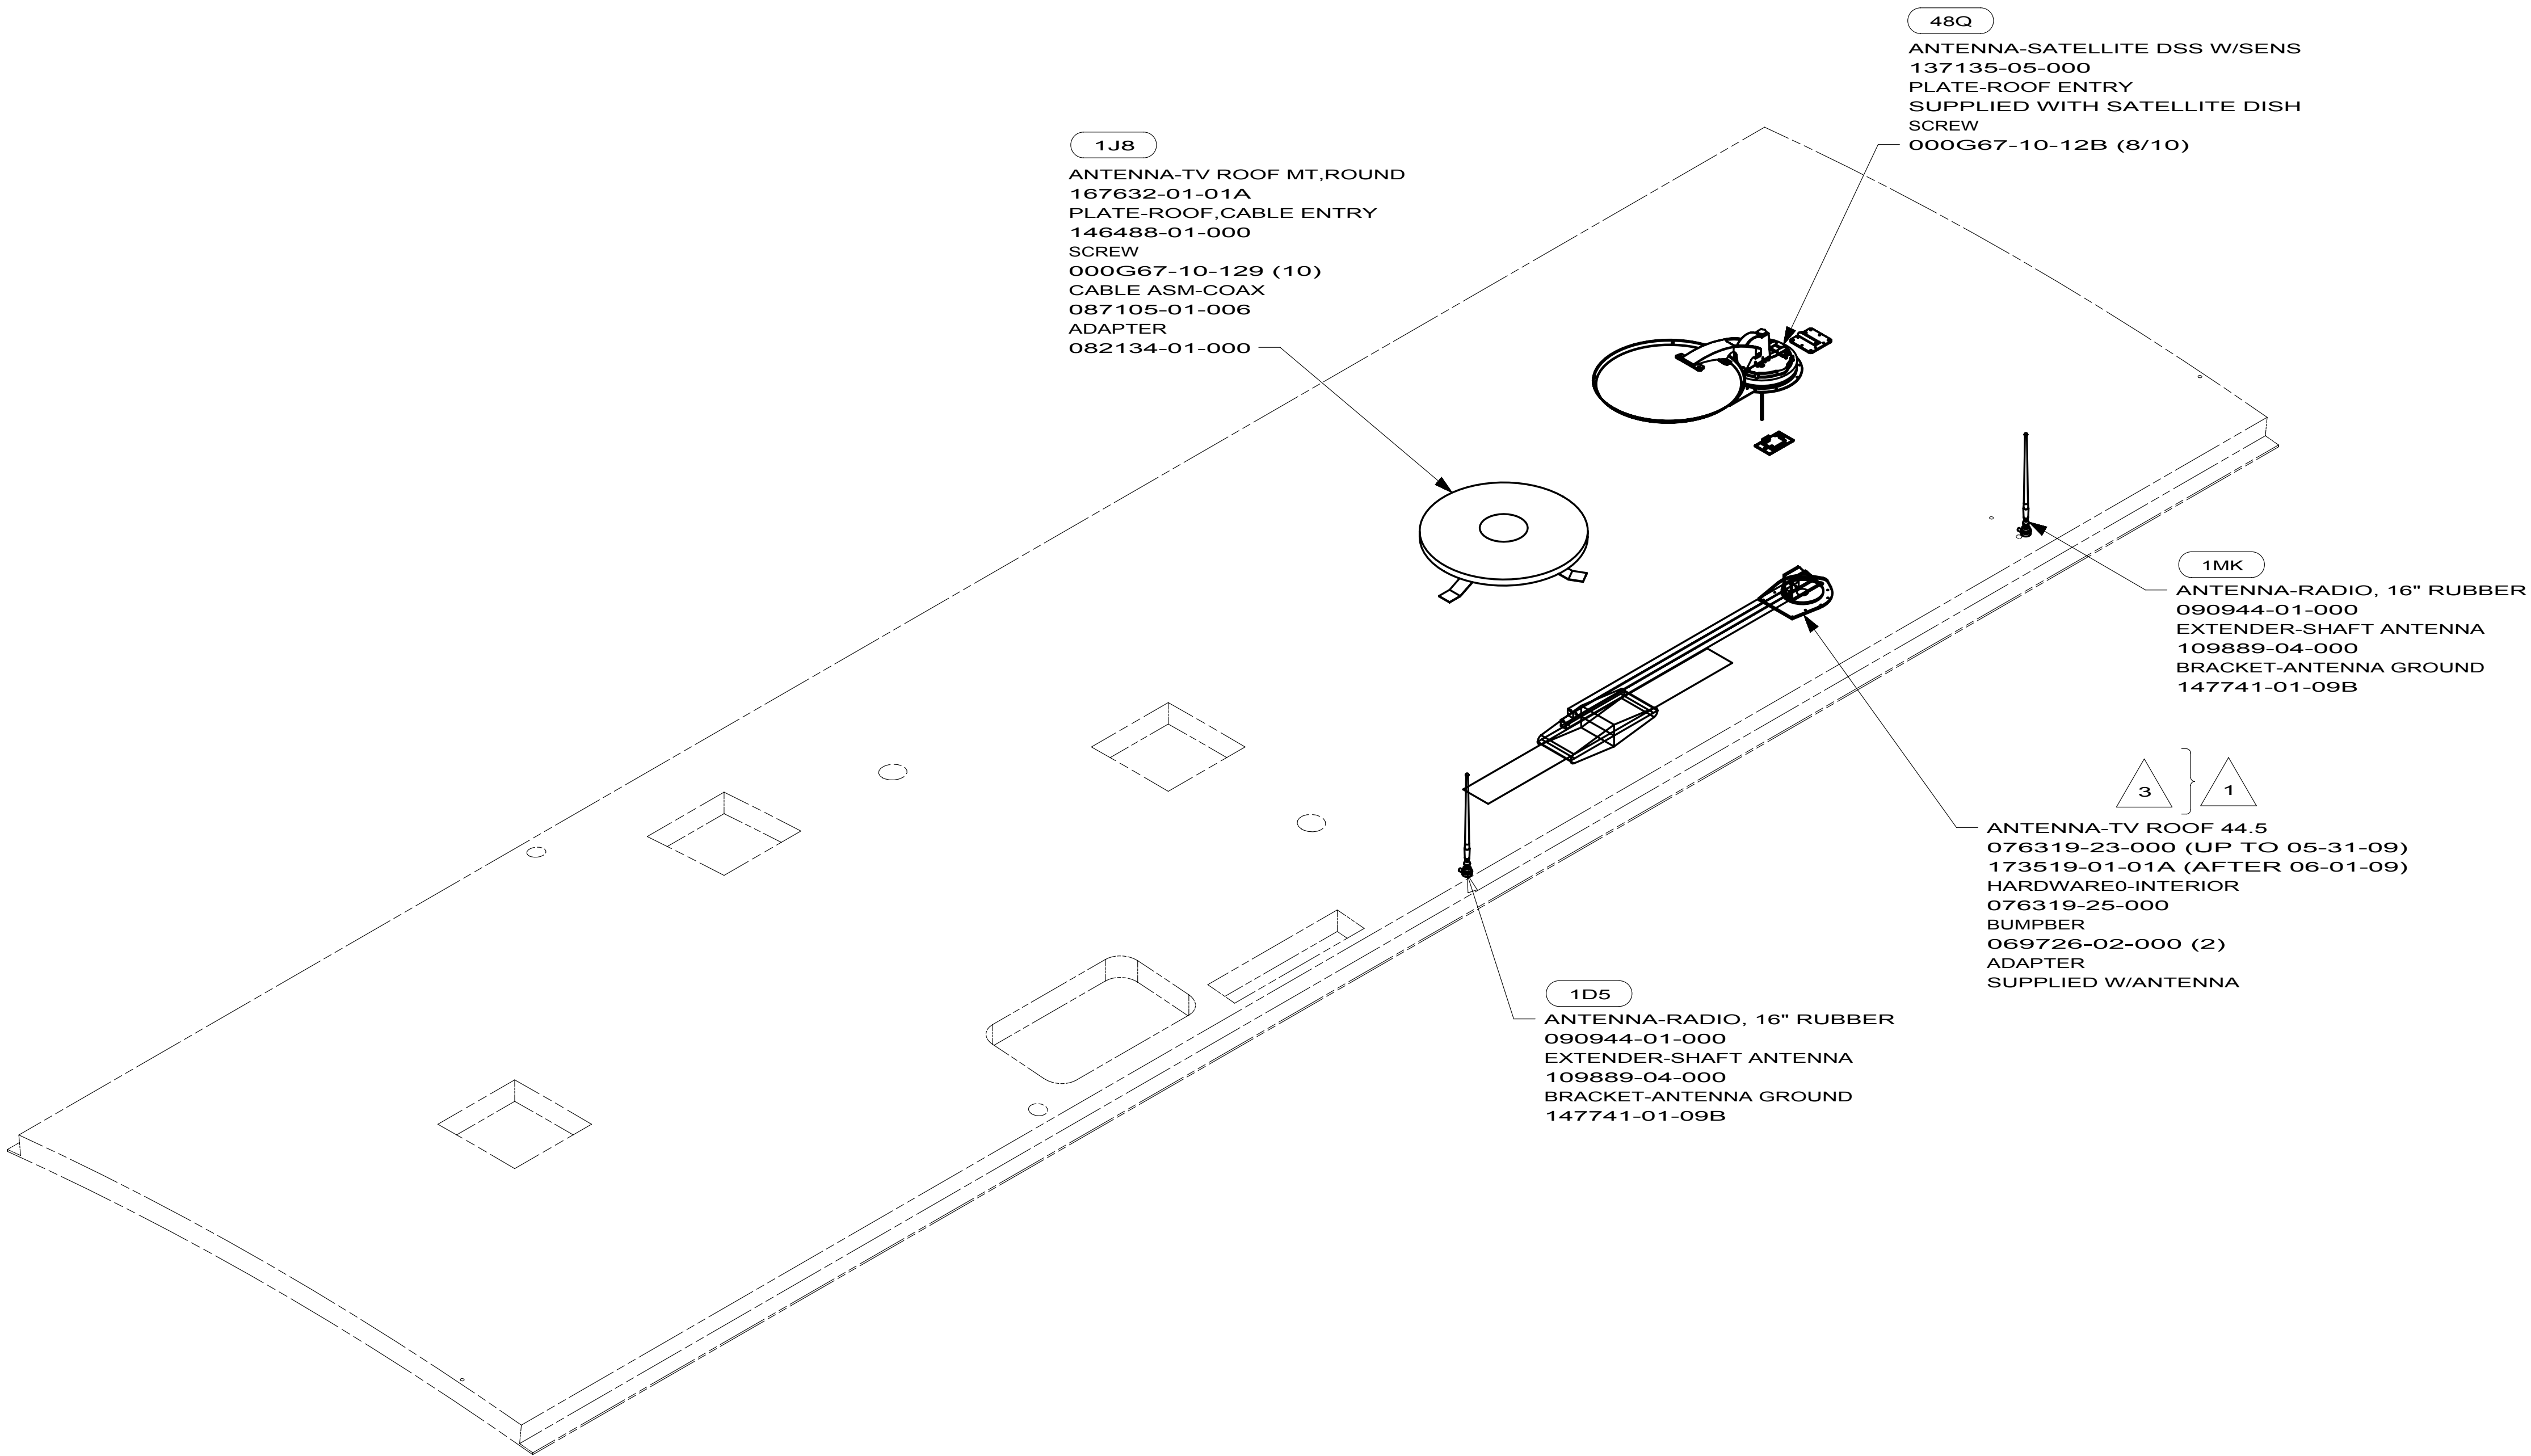

3 SEE DRAWING 076319-01-000 FOR INSTALLATION OF TV ANTENNA.

1 NOT USED WITH **1J8**

NOTES:

FOR ELECTRICAL
TORQUE
SPECIFICATIONS
SEE DWG NO.
128783-01-000

X-X

FOR
ELECTRICAL
CALLOUTS
SEE DWG NO.
121339-01-000


- 1MK** TV-19"DC,STEREO SYS,VDEO SEL
- 48Q** SATELLITE DISH & ELEV.SENSOR
- 1J8** TV ANTENNA-OMNIDIRECTIONAL
- 1D5** ENTERTAINMENT CENTR/EXT W/CD
- 265** CODES/STANDARDS-CSA/CMVSS
- 1B1** CODES/STANDARDS USA

1B1 **265**

10 331C

WIRING INSTL-BODY,12V

6 **170103**

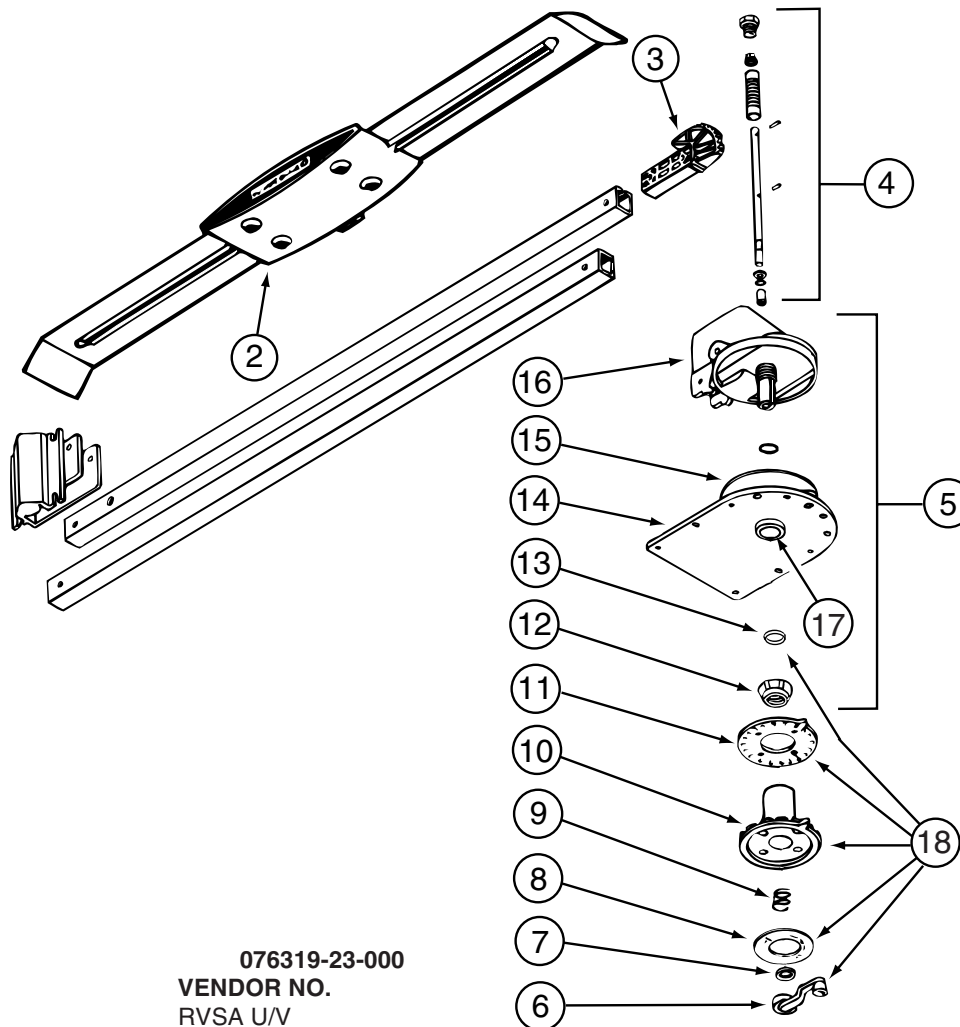


KEY PART NUMBER

2	076319-01-700	EA	HEAD-ANTENNA, AMPLIFIED
3	076319-01-701	EA	GEAR-ELEVATING, PLASTIC
4	076319-01-702	EA	SHAFT ASM-ELEVATING
5	076319-01-711	EA	BASE & LIFT ASM
7	076319-01-705	EA	GROMMET-NYLON, 7/8"ID
8	076319-01-708	EA	DECAL-CRANK
9	076319-01-707	EA	SPRING-HANDLE
11	076319-01-712	EA	PLATE - CEILING
12	076319-01-715	EA	NUT (GEAR HOUSING)
14	076319-01-713	EA	PLATE-BASE, STEEL
15	076319-01-703	EA	BEARING-NYLON, 5"OD
16	076319-01-714	EA	HOUSING, ROTATING GEAR
17	076319-01-704	EA	BEARING-NYLON, 1.25"OD
18	076319-01-709	EA	HANDLE-HEAD DIRECTIONAL
	076319-01-716	EA	TUBING, ELEVATING

076319-23-000
VENDOR NO.

RVSA U/V
2200046
RP-4000
2762802
3200658
5413002
2160822
3200608
2200047
3100523
3200656
2200049
3200657
200644
RP-2900

CONTACT WINNEBAGO PART SALES FOR UNLISTED COMPONENT(S)

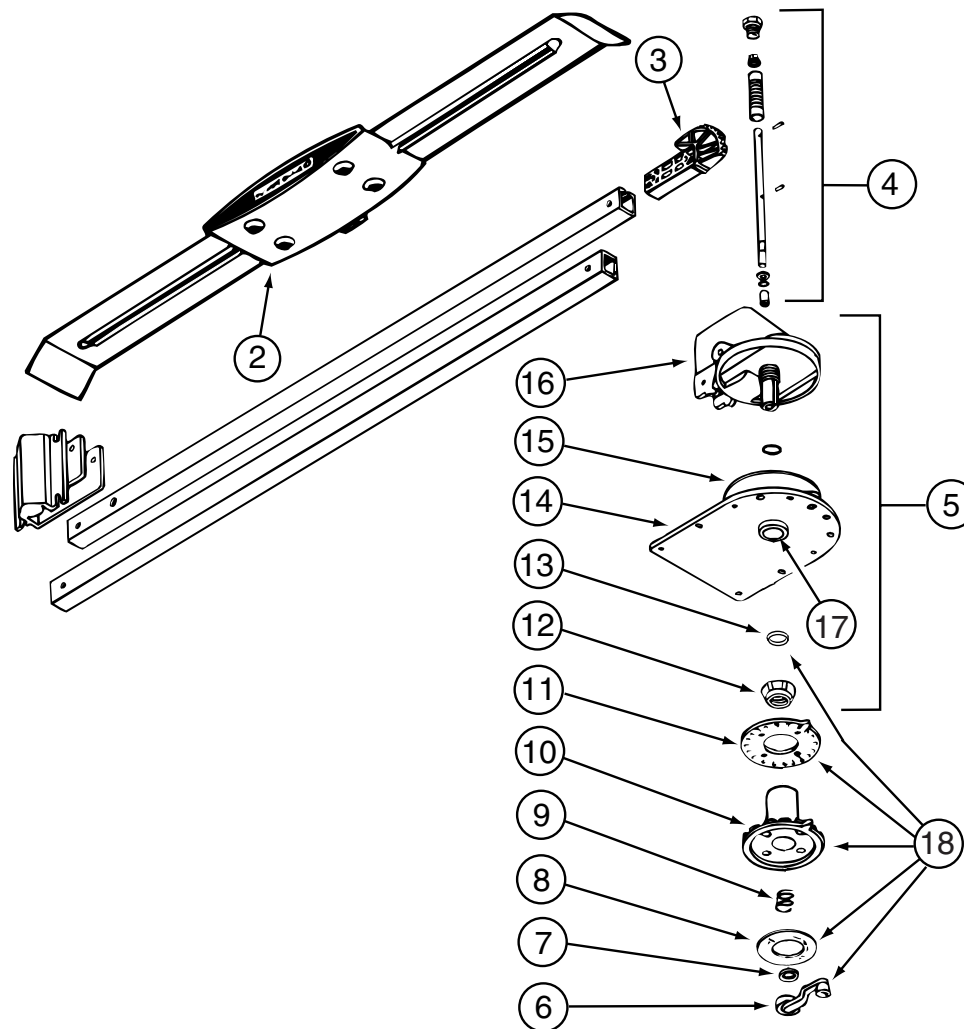

076319-25-000

KEY	PART NUMBER	U/M	DESCRIPTION	VENDOR NO.
6	076319-01-706	EA	CRANK-W/SET SCREW UNIV/BEIGE	2750897
6	120233-01-710	EA	HANDLE-CRANK W/SCREW - WHITE	RP-6795
8	076319-01-708	EA	DECAL-CRANK	5413002
10	076319-25-700	EA	DIRECTIONAL HANDLE(WHITE)	3200612
11	076319-25-701	EA	PLATE - CEILING(WHITE)	3200609
13	120233-01-709	EA	WASHER-NYLON	RP-2658
CONTACT WINNEBAGO PART SALES FOR UNLISTED COMPONENT(S)				

KEY	PART NUMBER	U/M	DESCRIPTION
	087694-01-700	EA	BULB

087694-01-000
VENDOR NO.
GE561

KEY	PART NUMBER	U/M DESCRIPTION
	093575-46-700	EA GLOBE
	093575-46-701	EA NUT-PLAS. LOCKING


093575-46-01A
VENDOR NO.
 98
 39155

KEY	PART NUMBER	U/M DESCRIPTION
	093575-47-700	EA GLOBE - GLASS

093575-47-01A
VENDOR NO.
 114-GLASS

KEY	PART NUMBER	U/M DESCRIPTION
	093575-52-700	EA SHADE-FABRIC

093575-52-01A
VENDOR NO.
 H3015

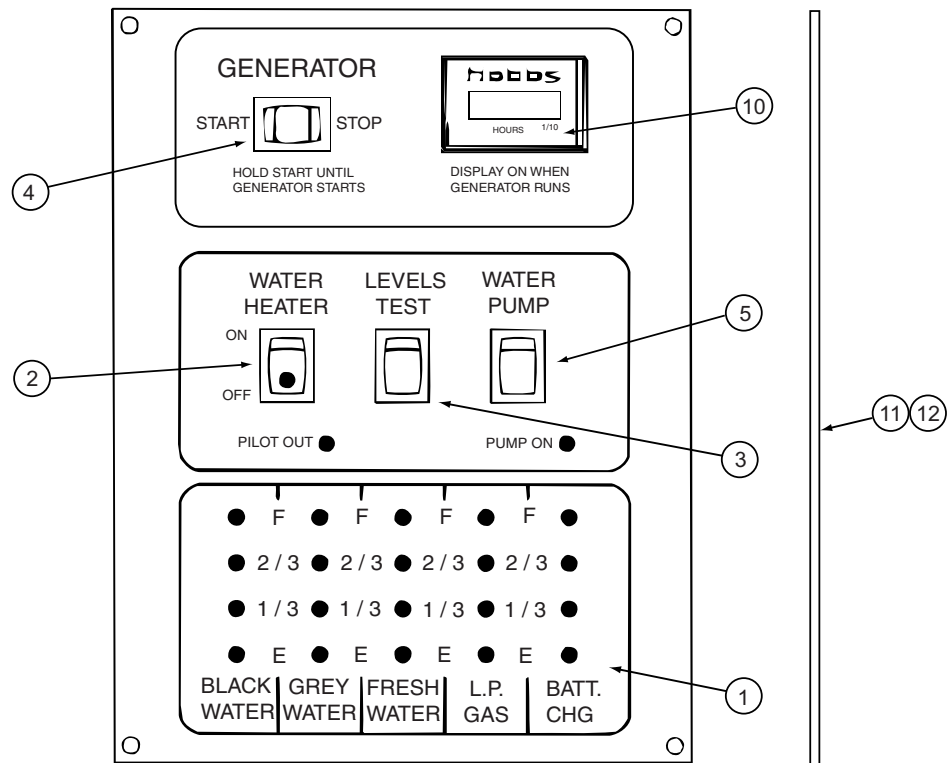

134940-06-01A


KEY	PART NUMBER	U/M	DESCRIPTION	VENDOR NO.
1	134940-01-702	EA	CHASSIS - SILKSCREENED	CC0558-00
2	134940-01-701	EA	SWITCH-SPST/ON-OFF/BLK W/LGT	L0109
3	096983-01-701	EA	SWITCH - SPST/MOM 2 TERMINAL	L0111-00
4	096983-01-702	EA	SWITCH - MOM/OFF/MOM/3 TERM	L0112-00
5	096983-01-703	EA	SWITCH - ON/ON	L0115-00
10	100258-10-701	EA	GAUGE-HR METER ONLY (LCD)	L0775-00
11	134940-06-700	EA	PC BOARD - SENSOR SYSTEM/RED	L5131-02
CONTACT WINNEBAGO PART SALES FOR UNLISTED COMPONENT(S)				

134940-07-01A

KEY	PART NUMBER	U/M	DESCRIPTION	VENDOR NO.
1	134940-01-702	EA	CHASSIS - SILKSCREENED	CC0558-00
2	134940-01-701	EA	SWITCH-SPST/ON-OFF/BLK W/LGT	L0109
3	096983-01-701	EA	SWITCH - SPST/MOM 2 TERMINAL	L0111-00
4	096983-01-703	EA	SWITCH - ON/ON	L0115-00
5	134940-02-700	EA	SWITCH - DUMMY	L0118
11	134940-06-700	EA	PC BOARD - SENSOR SYSTEM/RED	L5131-02
CONTACT WINNEBAGO PART SALES FOR UNLISTED COMPONENT(S)				

137135-05-000

KEY	PART NUMBER	U/M	DESCRIPTION	VENDOR NO.
	120233-01-714	EA	CLIP-E	5160818
	120233-01-737	EA	PLATE/INT-W/DIRECTIONAL HDLE	RK-CEIL
	120233-01-738	EA	HDW PKG-HANDLE/SPRING/WASHER	RK-HAND
	120233-04-703	EA	KIT-DIRECTIONAL HDL UPGRADE	RP-RM46
	137135-01-703	EA	KIT ELEV-SHAFT/PLUG/SPRING	RP-4400
	137135-01-704	EA	PIN - 1/4" X 3.25"	2160813
	137135-01-708	EA	TURRET	3100728
	137135-01-710	EA	PLATE - ROTATE LIMIT	3720052
	137135-01-712	EA	BEARING - OUTER	2590347
	137135-01-713	EA	TURRET BASE	3100730
	137135-01-714	EA	GEAR - ELEVATING SHAFT	2200465
	137135-01-715	EA	BEARING - INNER	2590348
	137135-01-717	EA	BOLT - FLAT HEAD	2160362
	137135-01-719	EA	BRACKET - PIVOT	2744945
	137135-01-722	EA	CLAMP	2590343

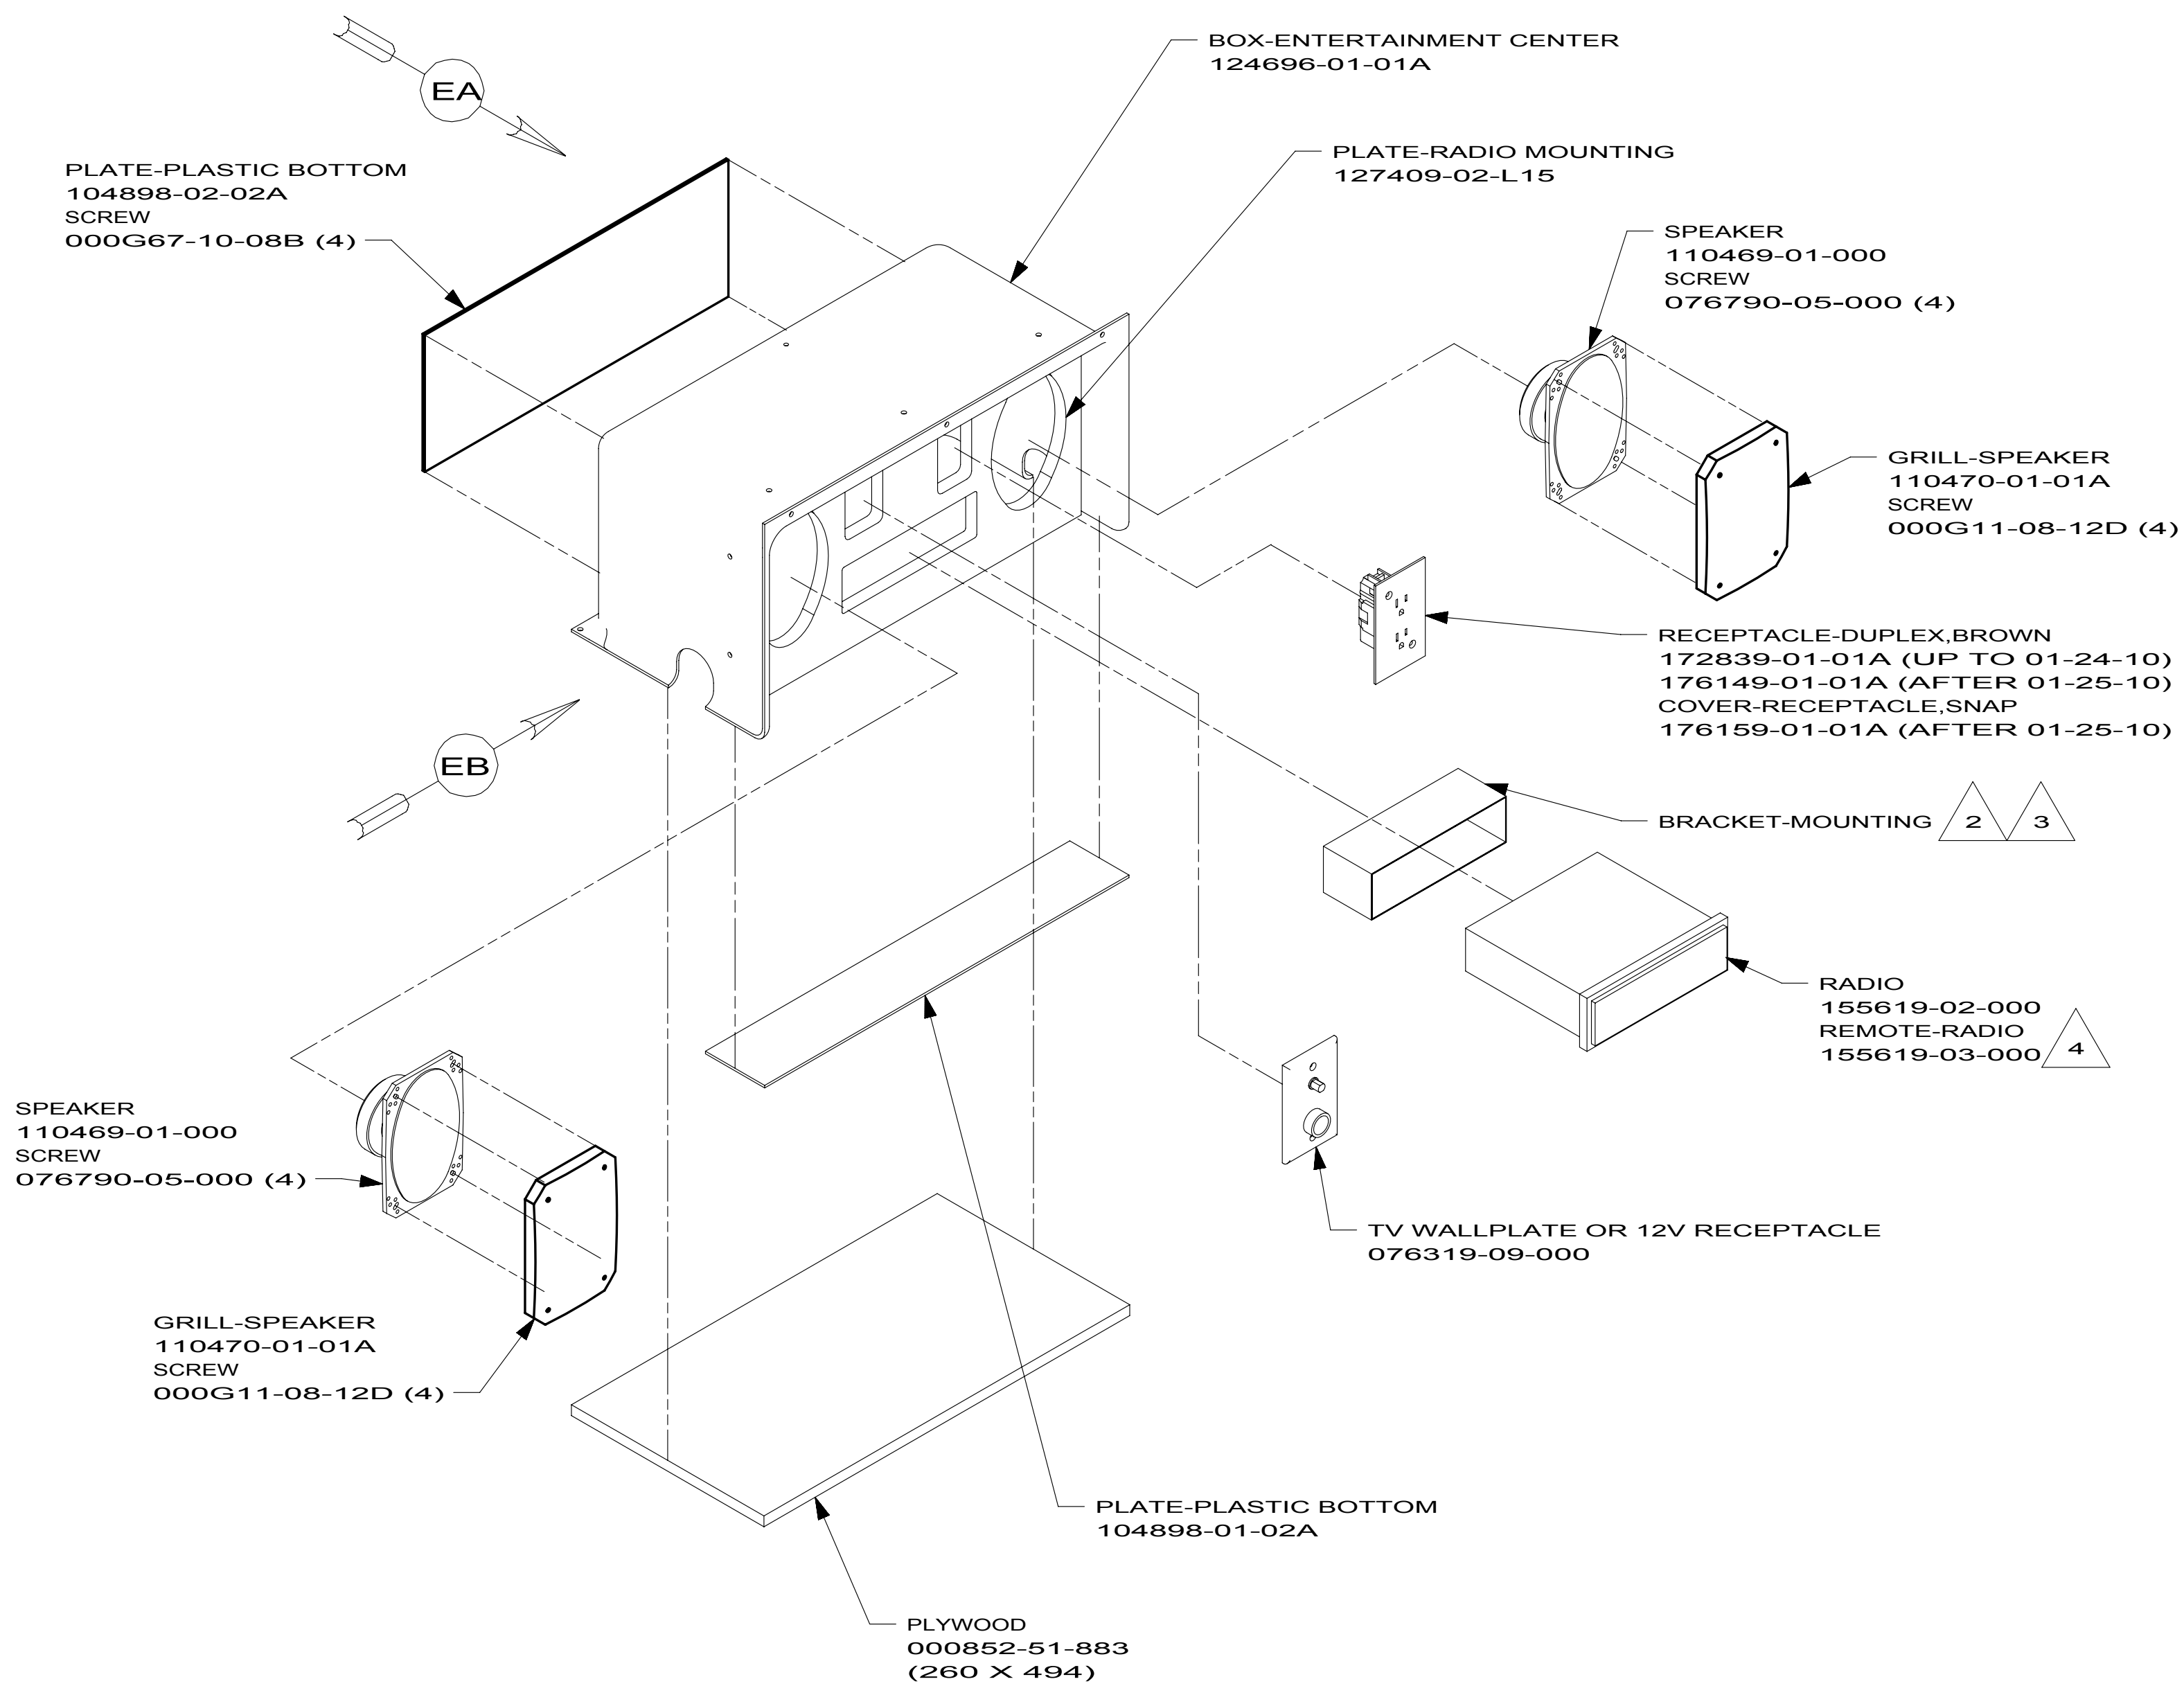

144818-02
331C
728B

- 4 PUT IN INFO CASE.
- 3 SUPPLIED WITH RADIO
- 2 BEND TABS ON MOUNTING BRACKET SUPPLIED WITH RADIO, TO HOLD IN PLACE.
1. SEE WIRING INSTL-BODY FOR ADDITIONAL INFORMATION.

NOTES:

1D5 ENTERTAINMENT CENTER/EXT W/CD

04 MOTORHOMES


ENTERTAINMENT CENTER COMPL

1


144818

FOR ELECTRICAL
TORQUE
SPECIFICATIONS
SEE DWG NO.
128783-01-000


FOR ELECTRICAL
CALLOUTS
SEE DWG NO.
121339-01-000

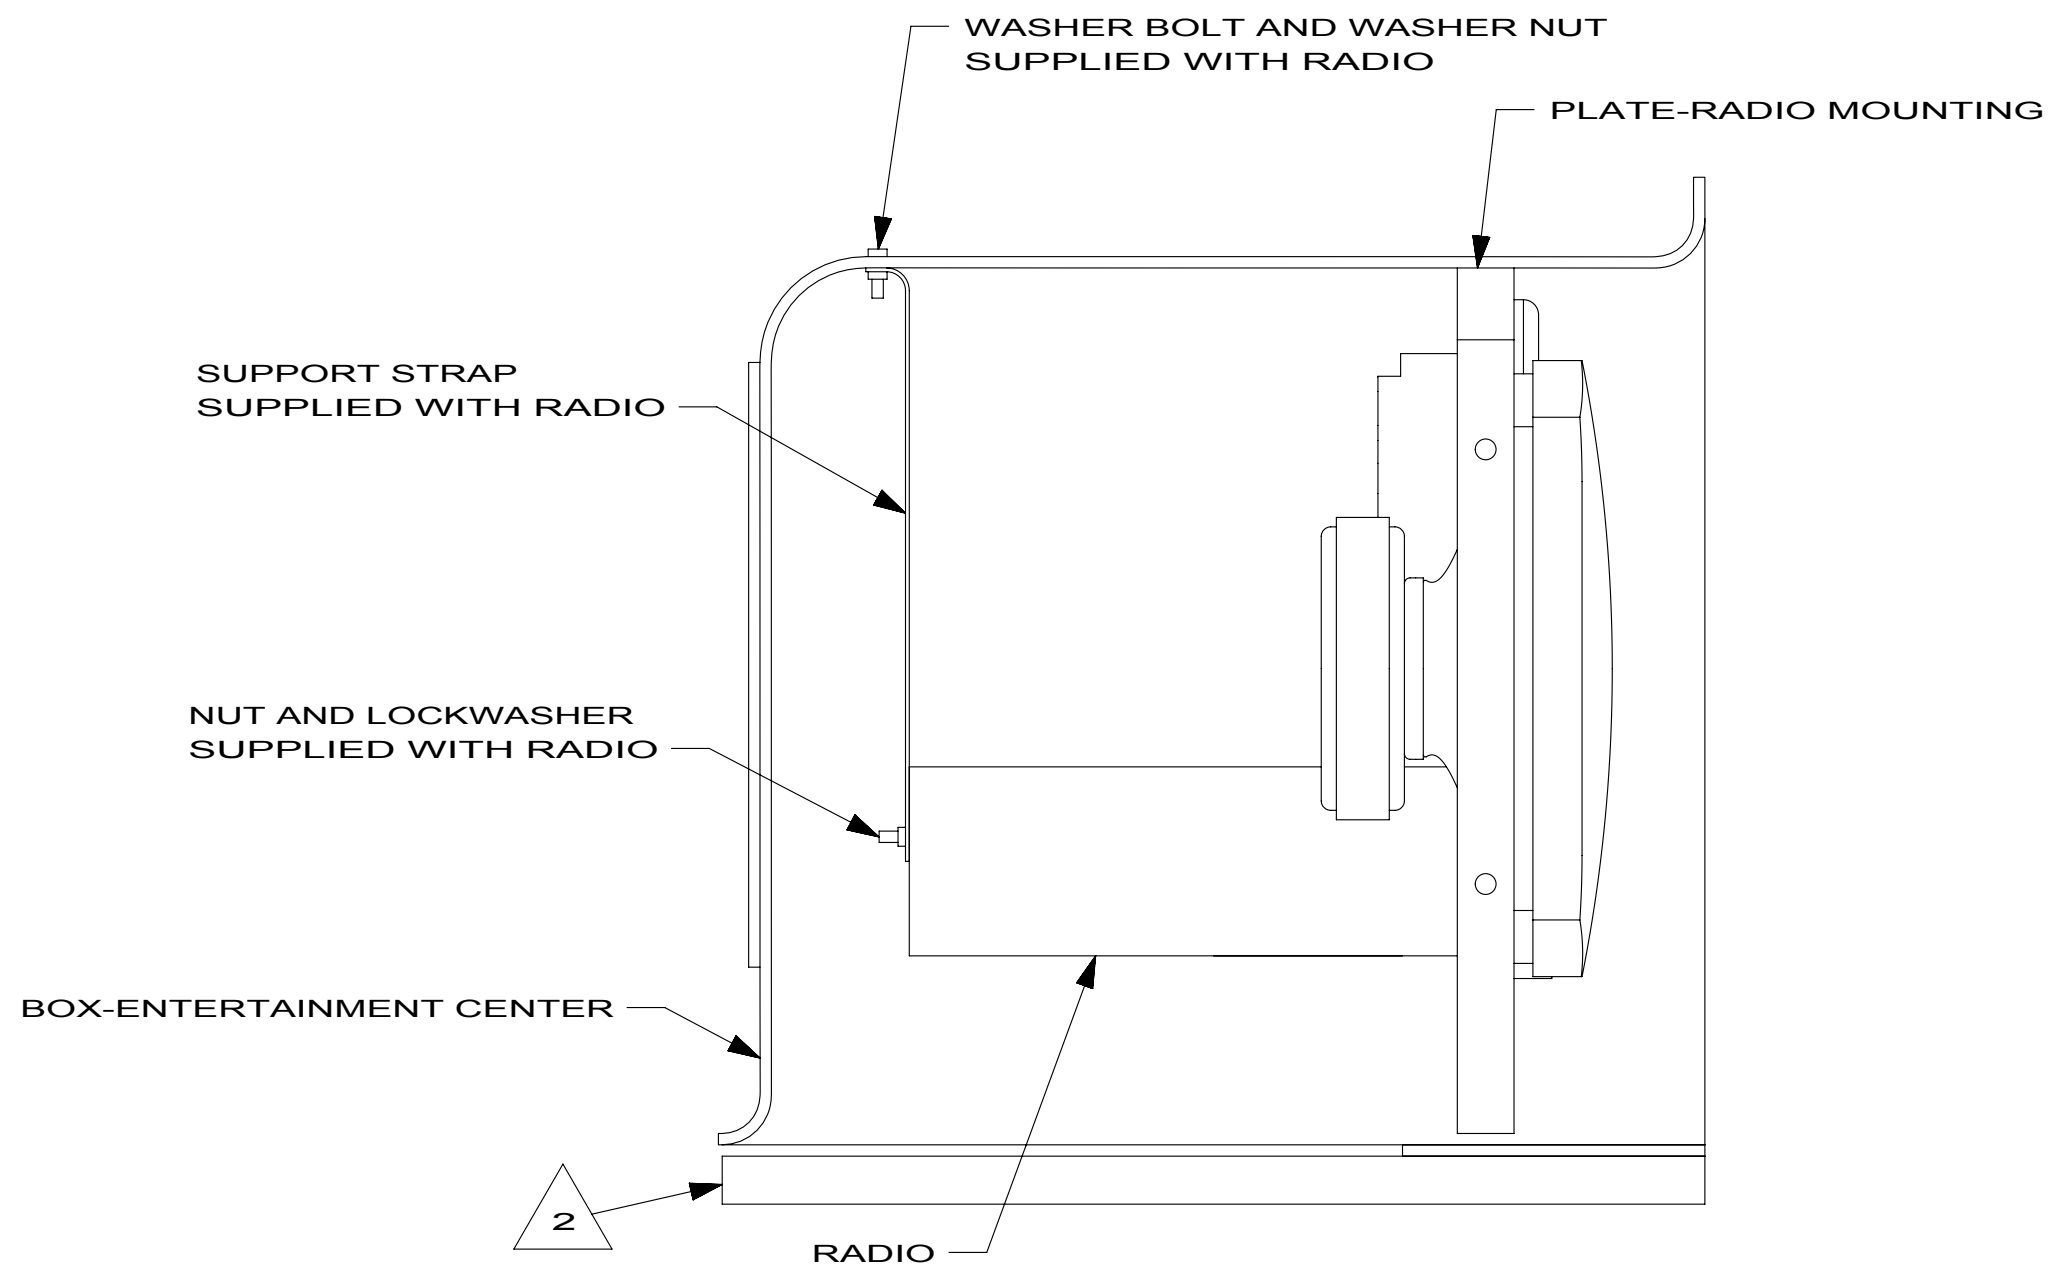


DETAIL EB

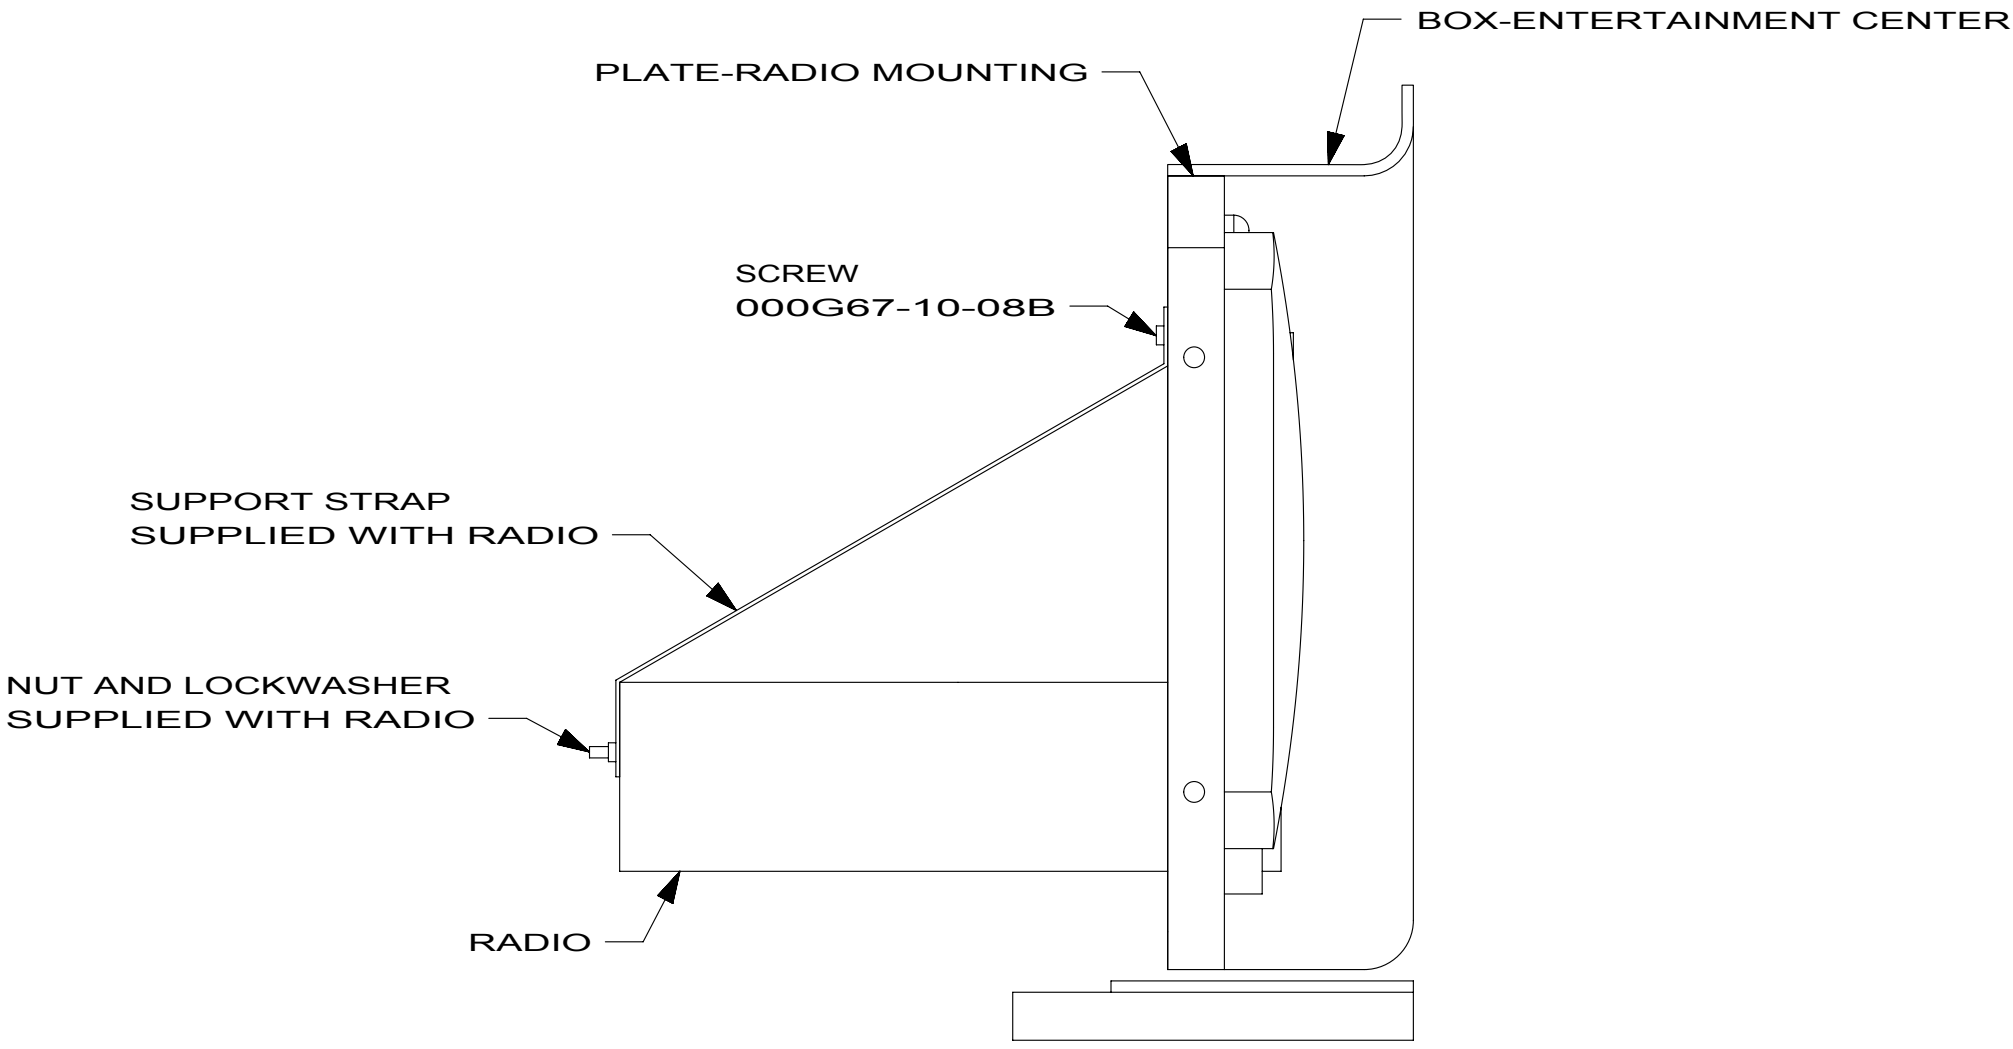

DETAIL ED

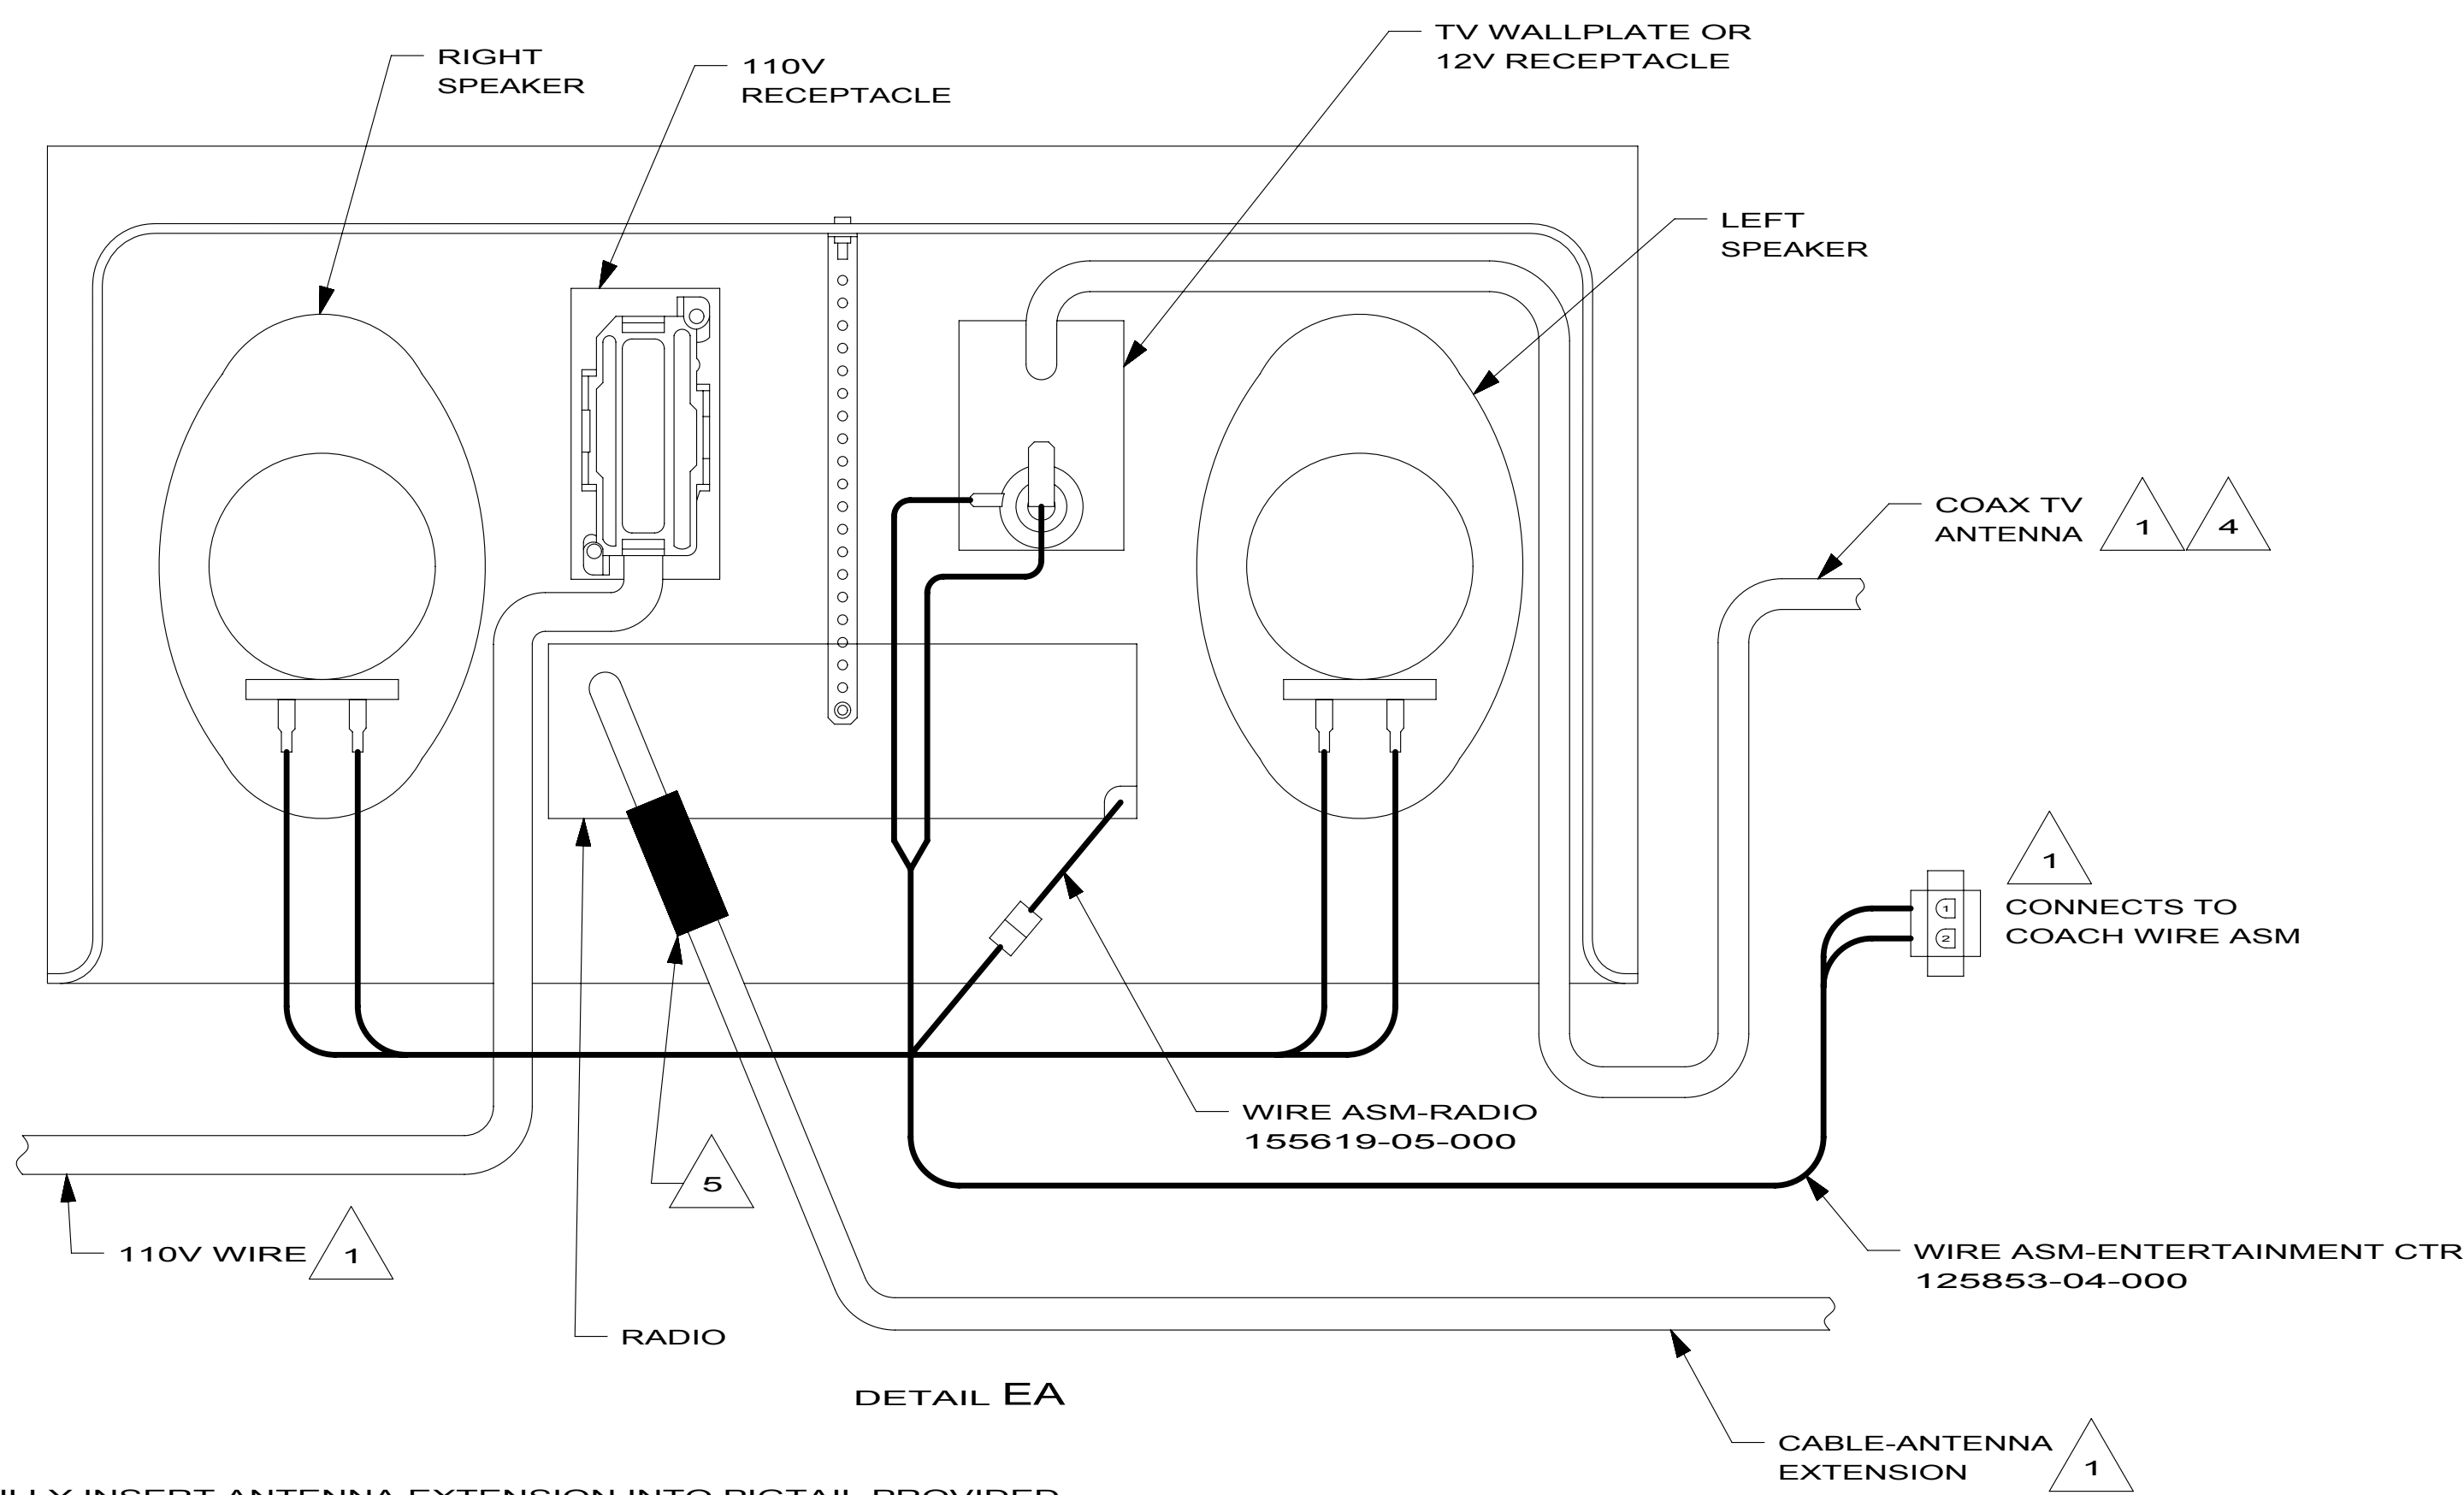

DETAIL EA

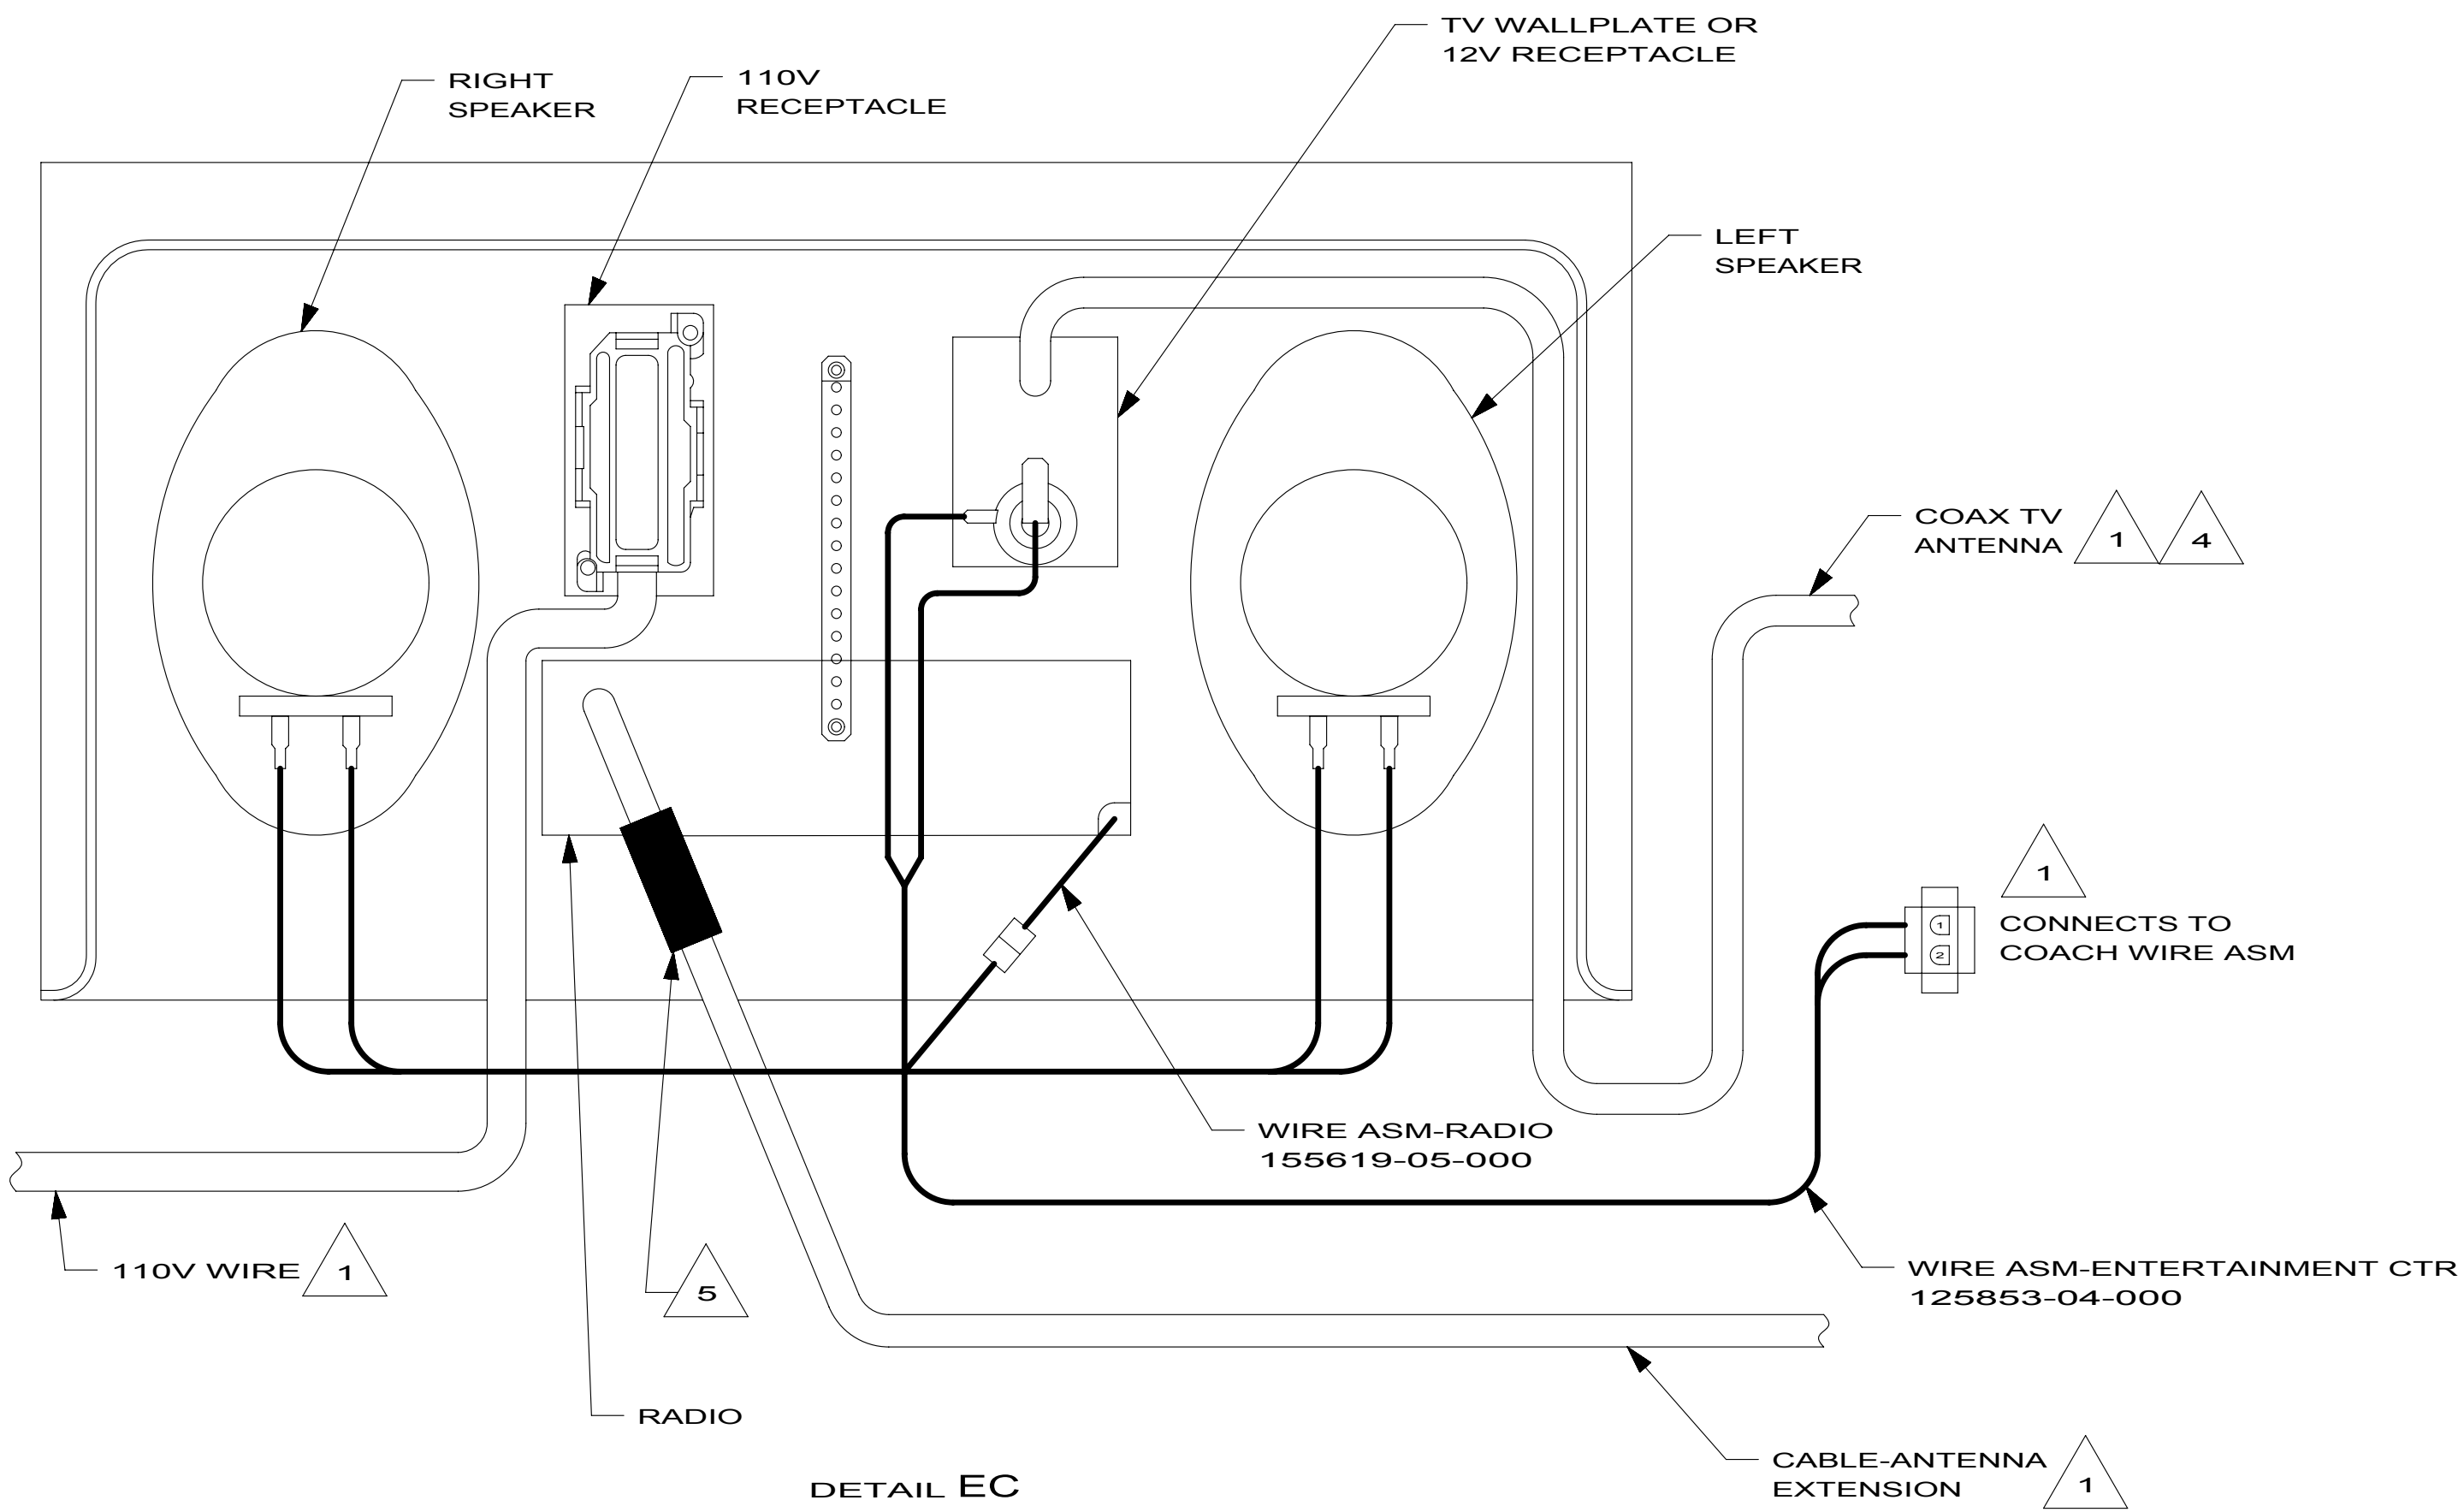

DETAIL EC

5 FULLY INSERT ANTENNA EXTENSION INTO PIGTAIL PROVIDED ON RADIO & WRAP WITH TAPE 008363-01-000 (100mm).

4 COAX ON TABS -02, & -03 ONLY.

2 PLYWOOD ON TAB -02 ONLY.

1 SEE WIRING INSTL-BODY FOR ADDITIONAL INFORMATION.

NOTES:

FOR ELECTRICAL
TORQUE
SPECIFICATIONS
SEE DWG NO.
128783-01-000

FOR ELECTRICAL
CALLOUTS
SEE DWG NO.
121339-01-000

04 MOTORHOMES

ENTERTAINMENT CENTER COMPL

KEY	PART NUMBER	U/M	DESCRIPTION	163097-01-000	VENDOR NO.
	163097-01-700	EA	KEY - #2382 (ILLINOIS LOCK)		2382
	163097-01-701	EA	KEY - #2341 (MILLER DIAL)		PART SALES


KEY	PART NUMBER	U/M	DESCRIPTION
	170693-02-700	EA	LENS-OPTIC

170693-02-02A
VENDOR NO
L8106

KEY	PART NUMBER	U/M	DESCRIPTION
	170693-05-700	EA	LENS

170693-05-02A, 171693-07-02A
VENDOR NO
L8105

KEY	PART NUMBER	U/M	DESCRIPTION	VENDOR NO.
	172120-01-700	EA	REMOTE - RADIO	REMJC

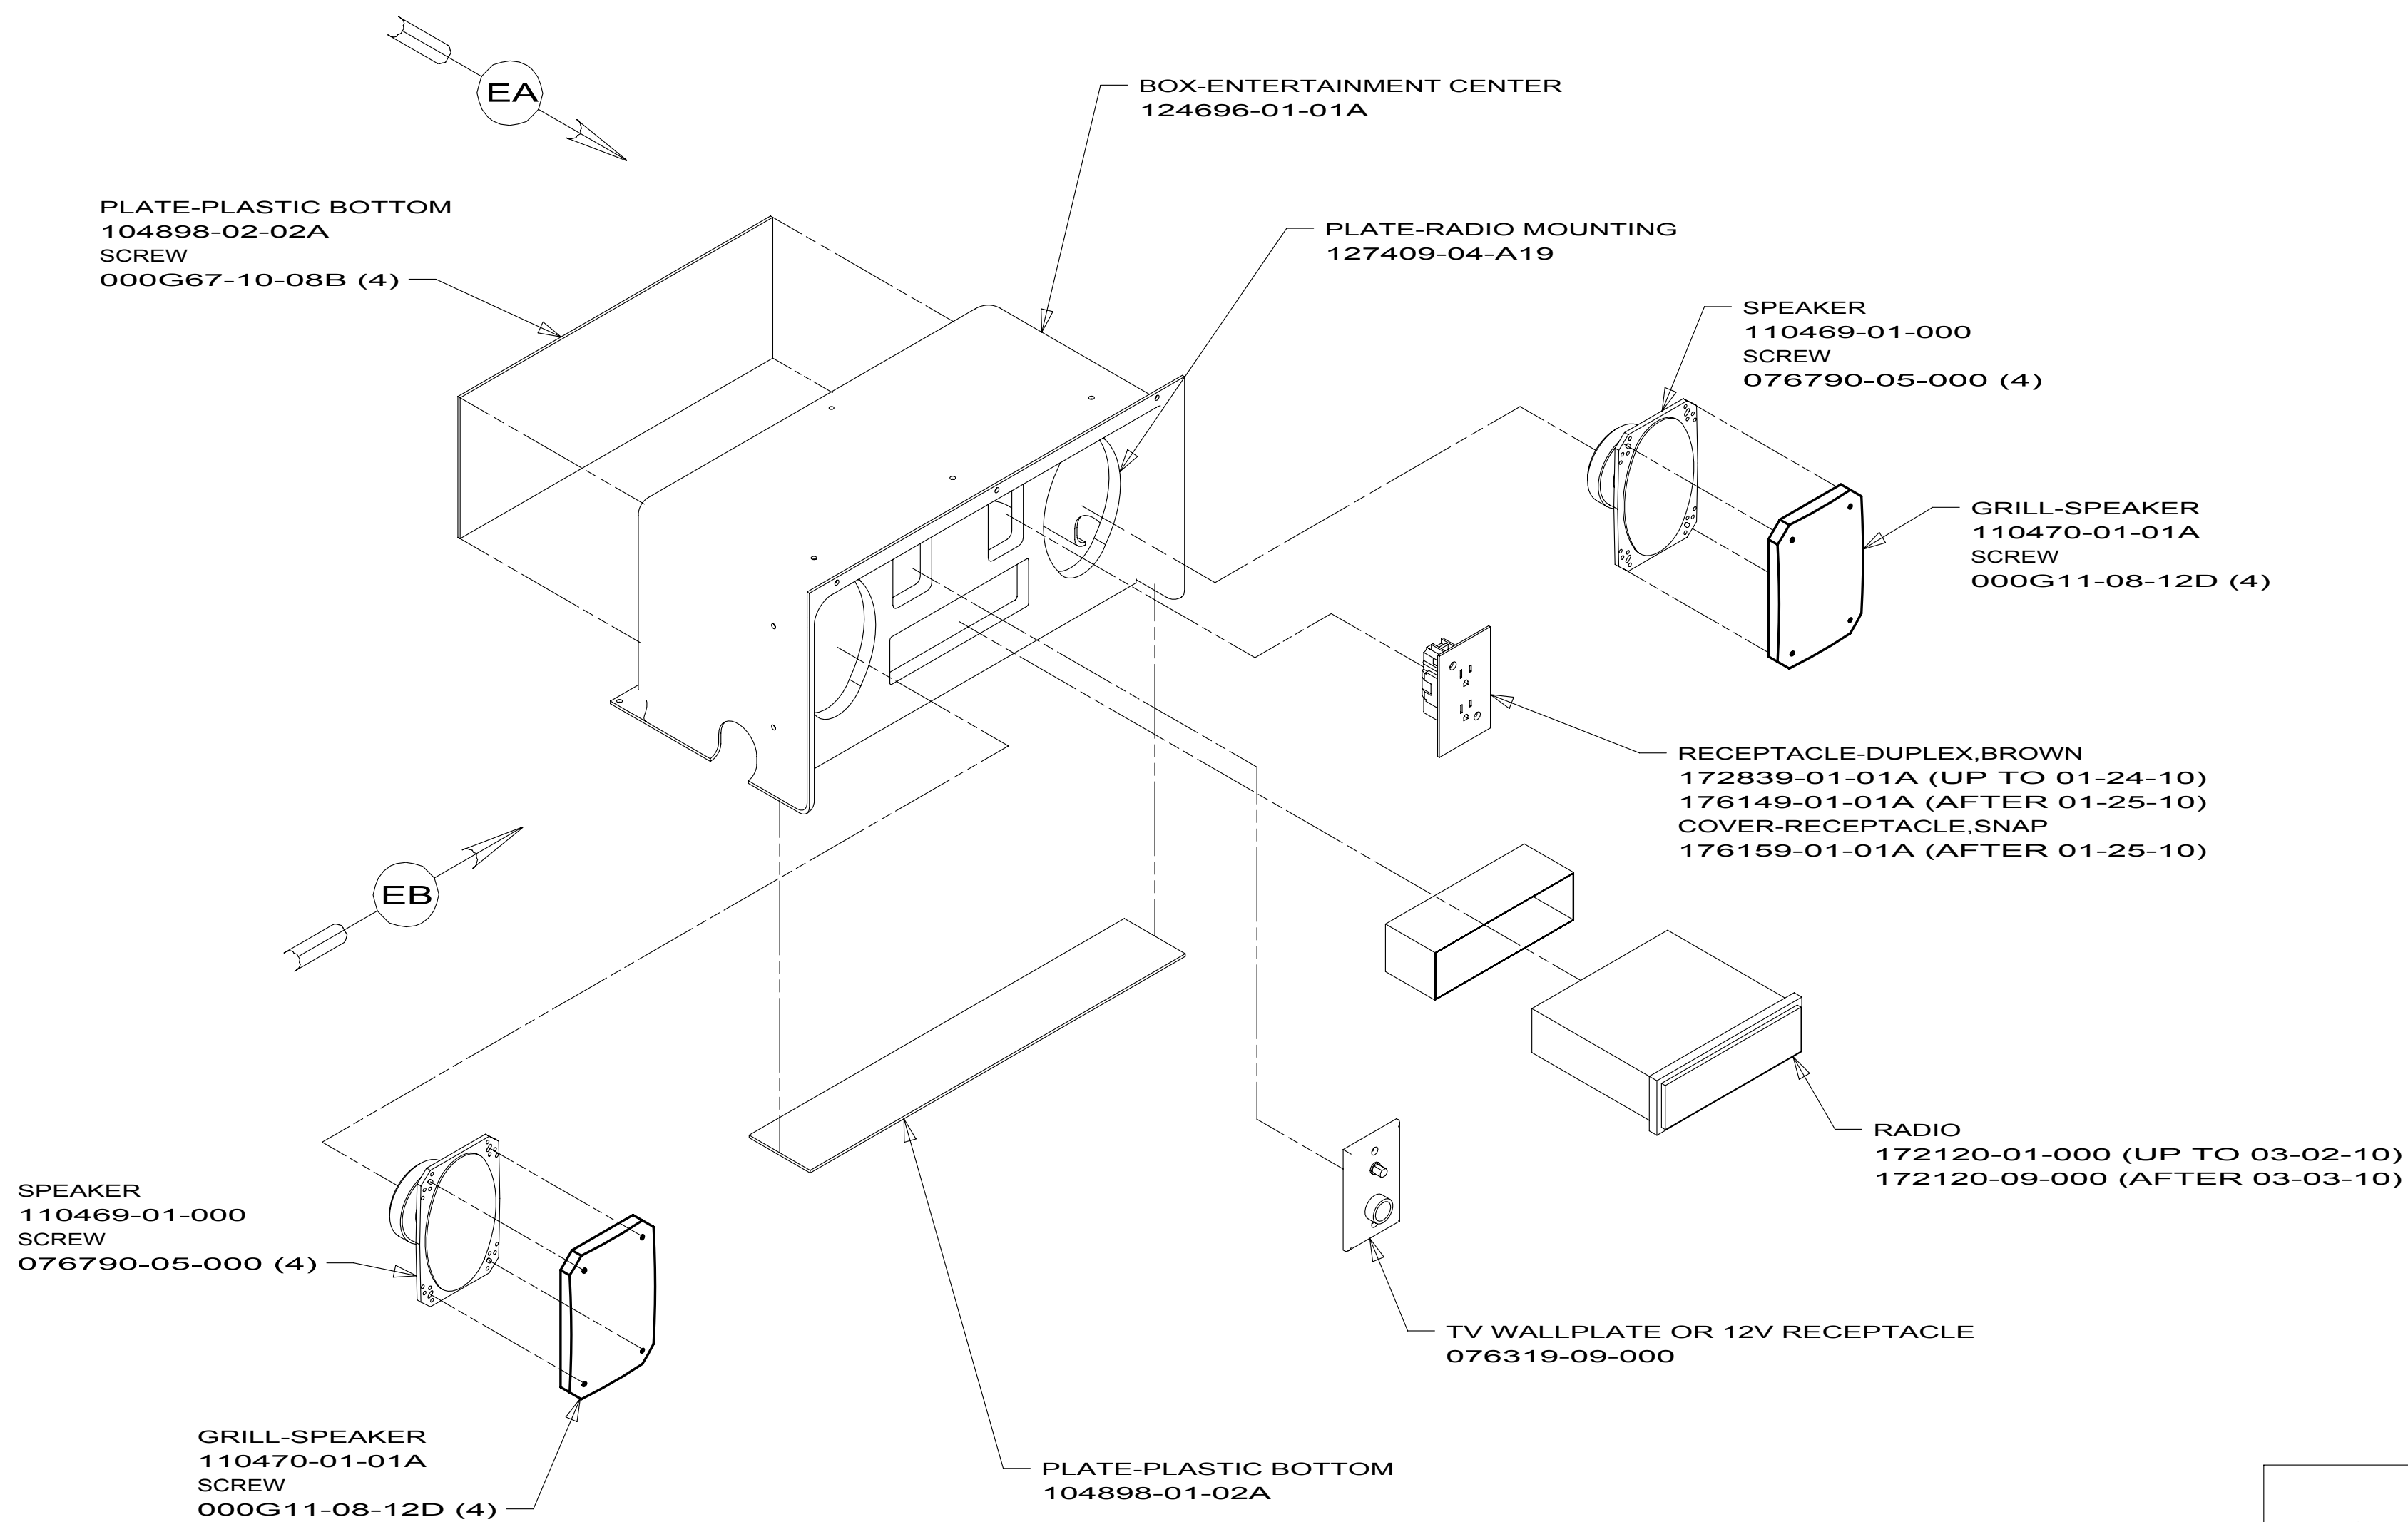

173464-01
331C
728B

1D5 ENTERTAINMENT CENTER/EXT W/CD


1. SEE WIRING INSTL-BODY FOR ADDITIONAL INFORMATION.

NOTES:


FOR ELECTRICAL
TORQUE
SPECIFICATIONS
SEE DWG NO.
128783-01-000

X-X

FOR
ELECTRICAL
CALLOUTS
SEE DWG NO.
121339-01-000

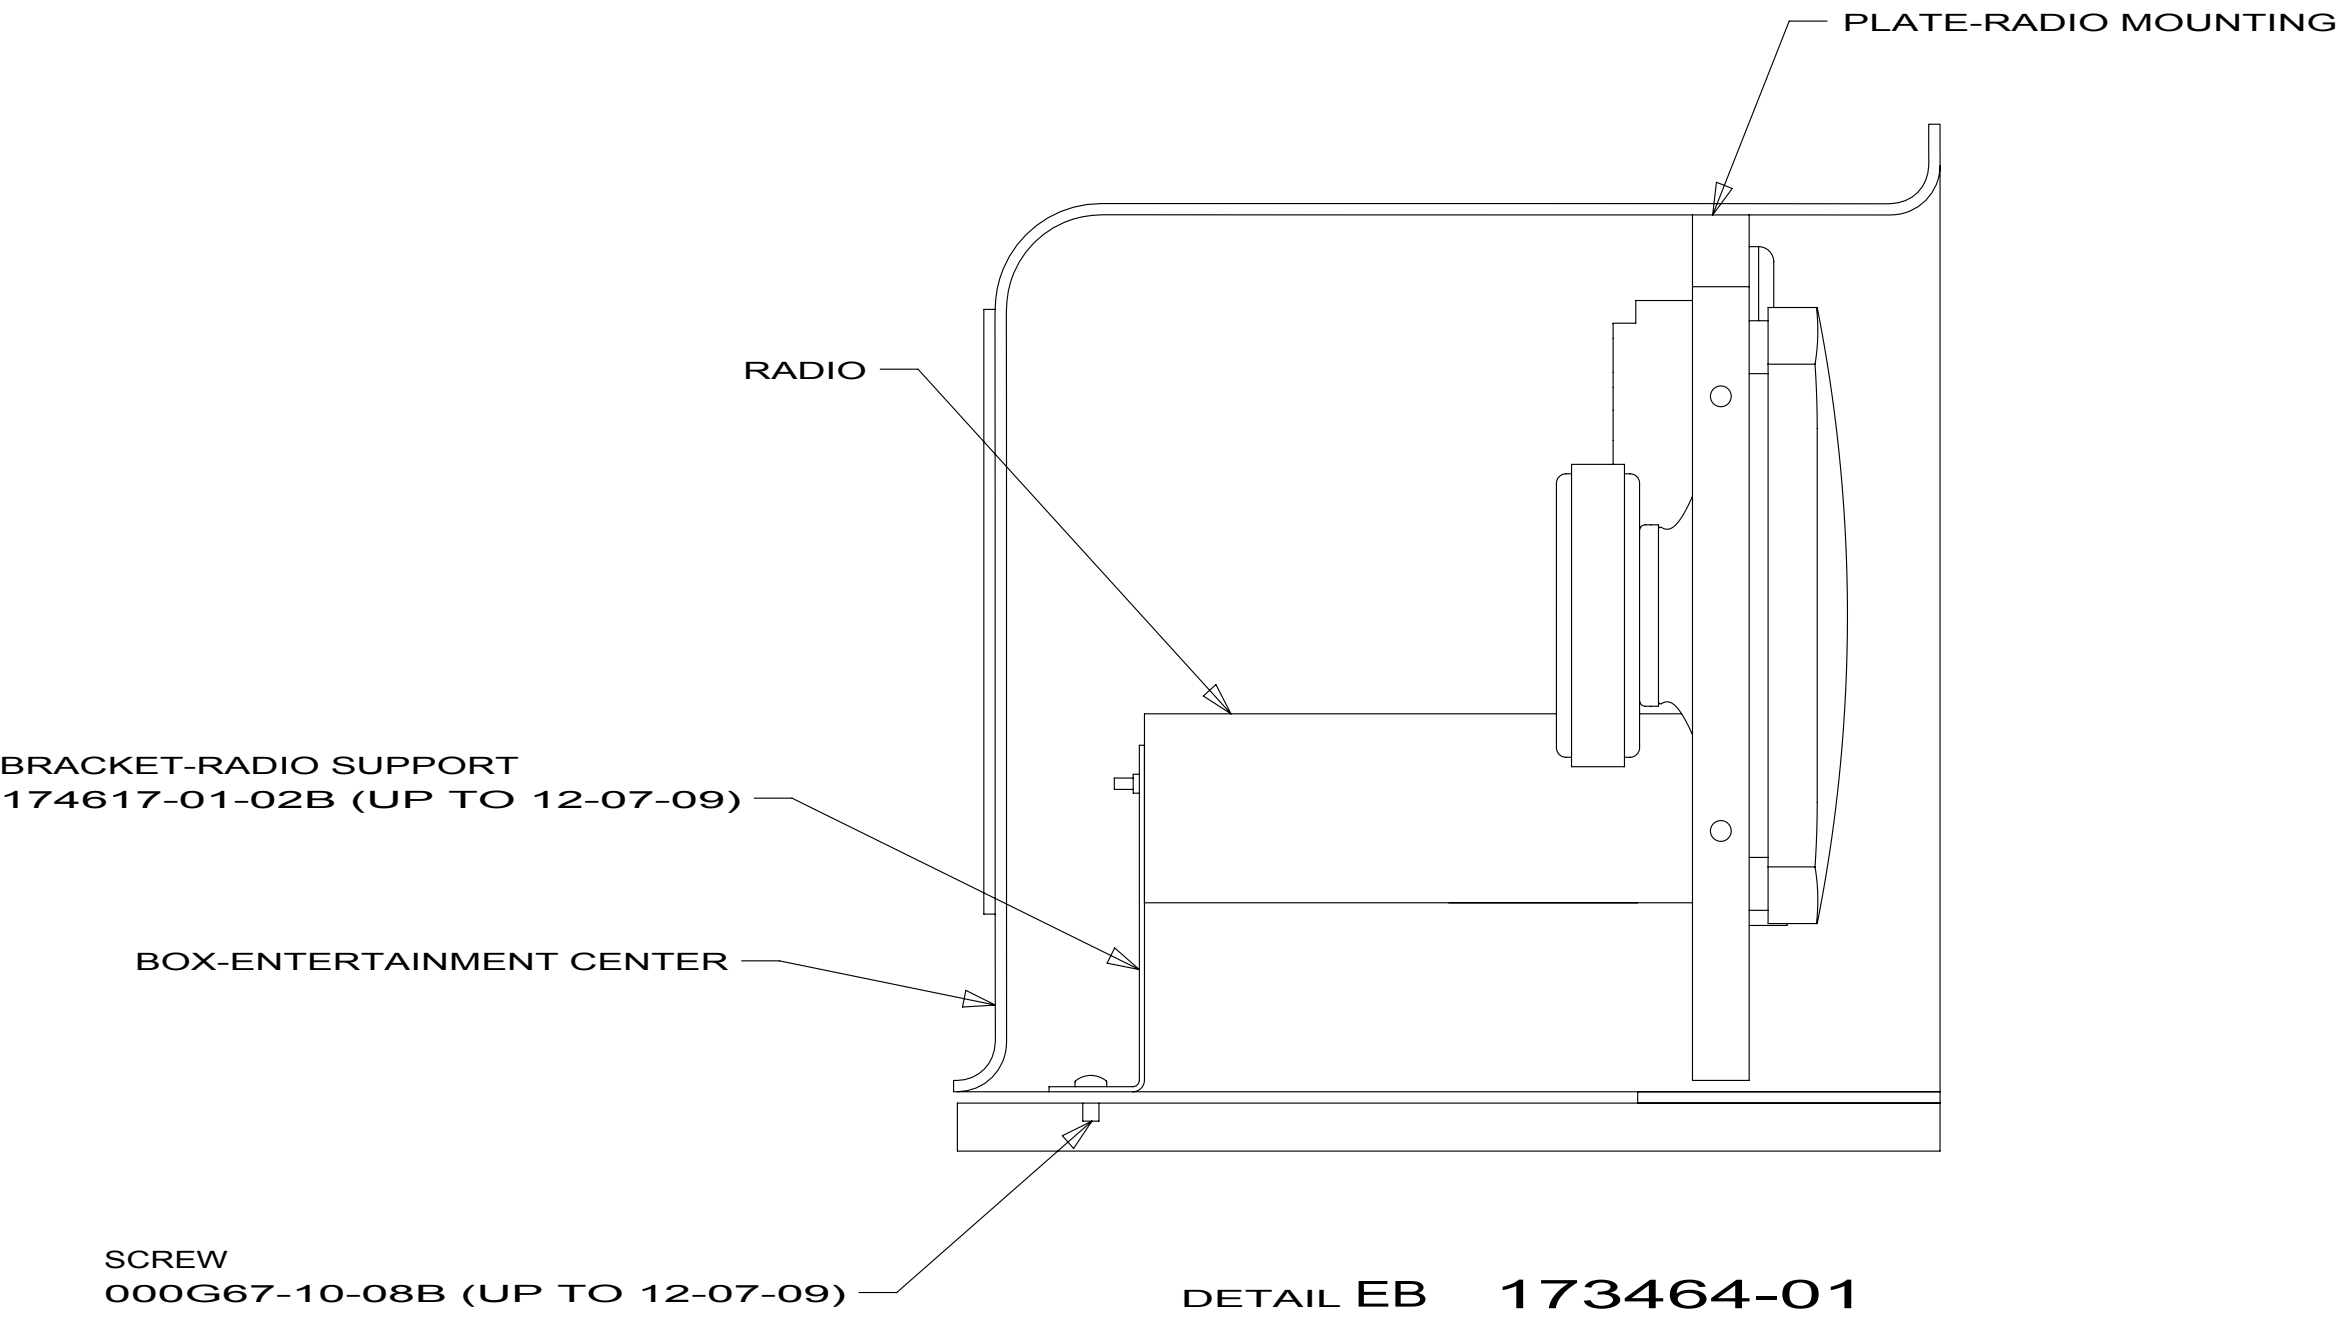


DETAIL EB 173464-01

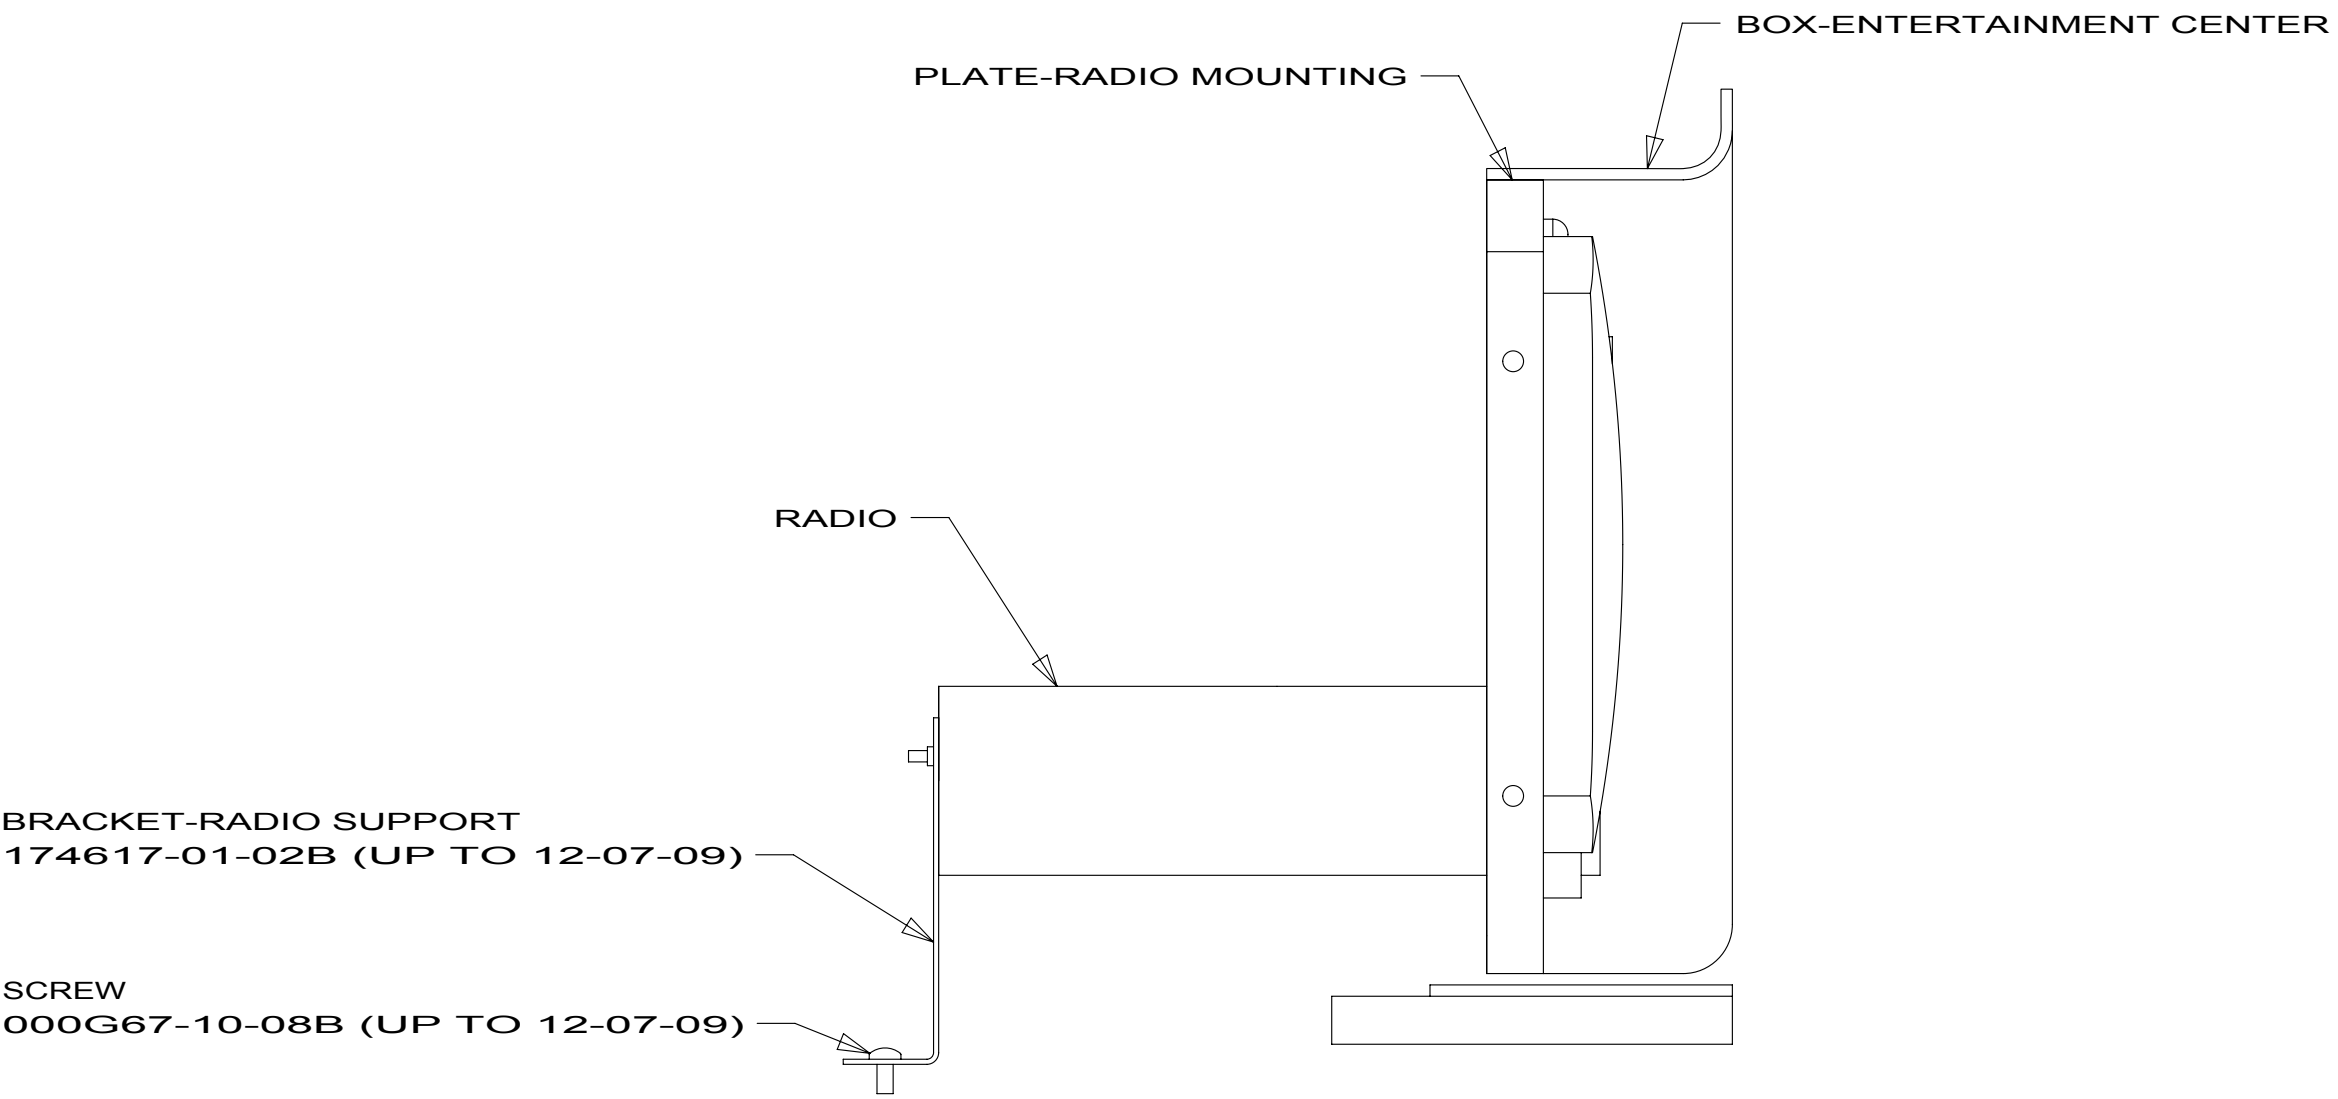


DETAIL ED 173464-03
173464-07
173464-08

173464-01
173464-03
173464-07
173464-08

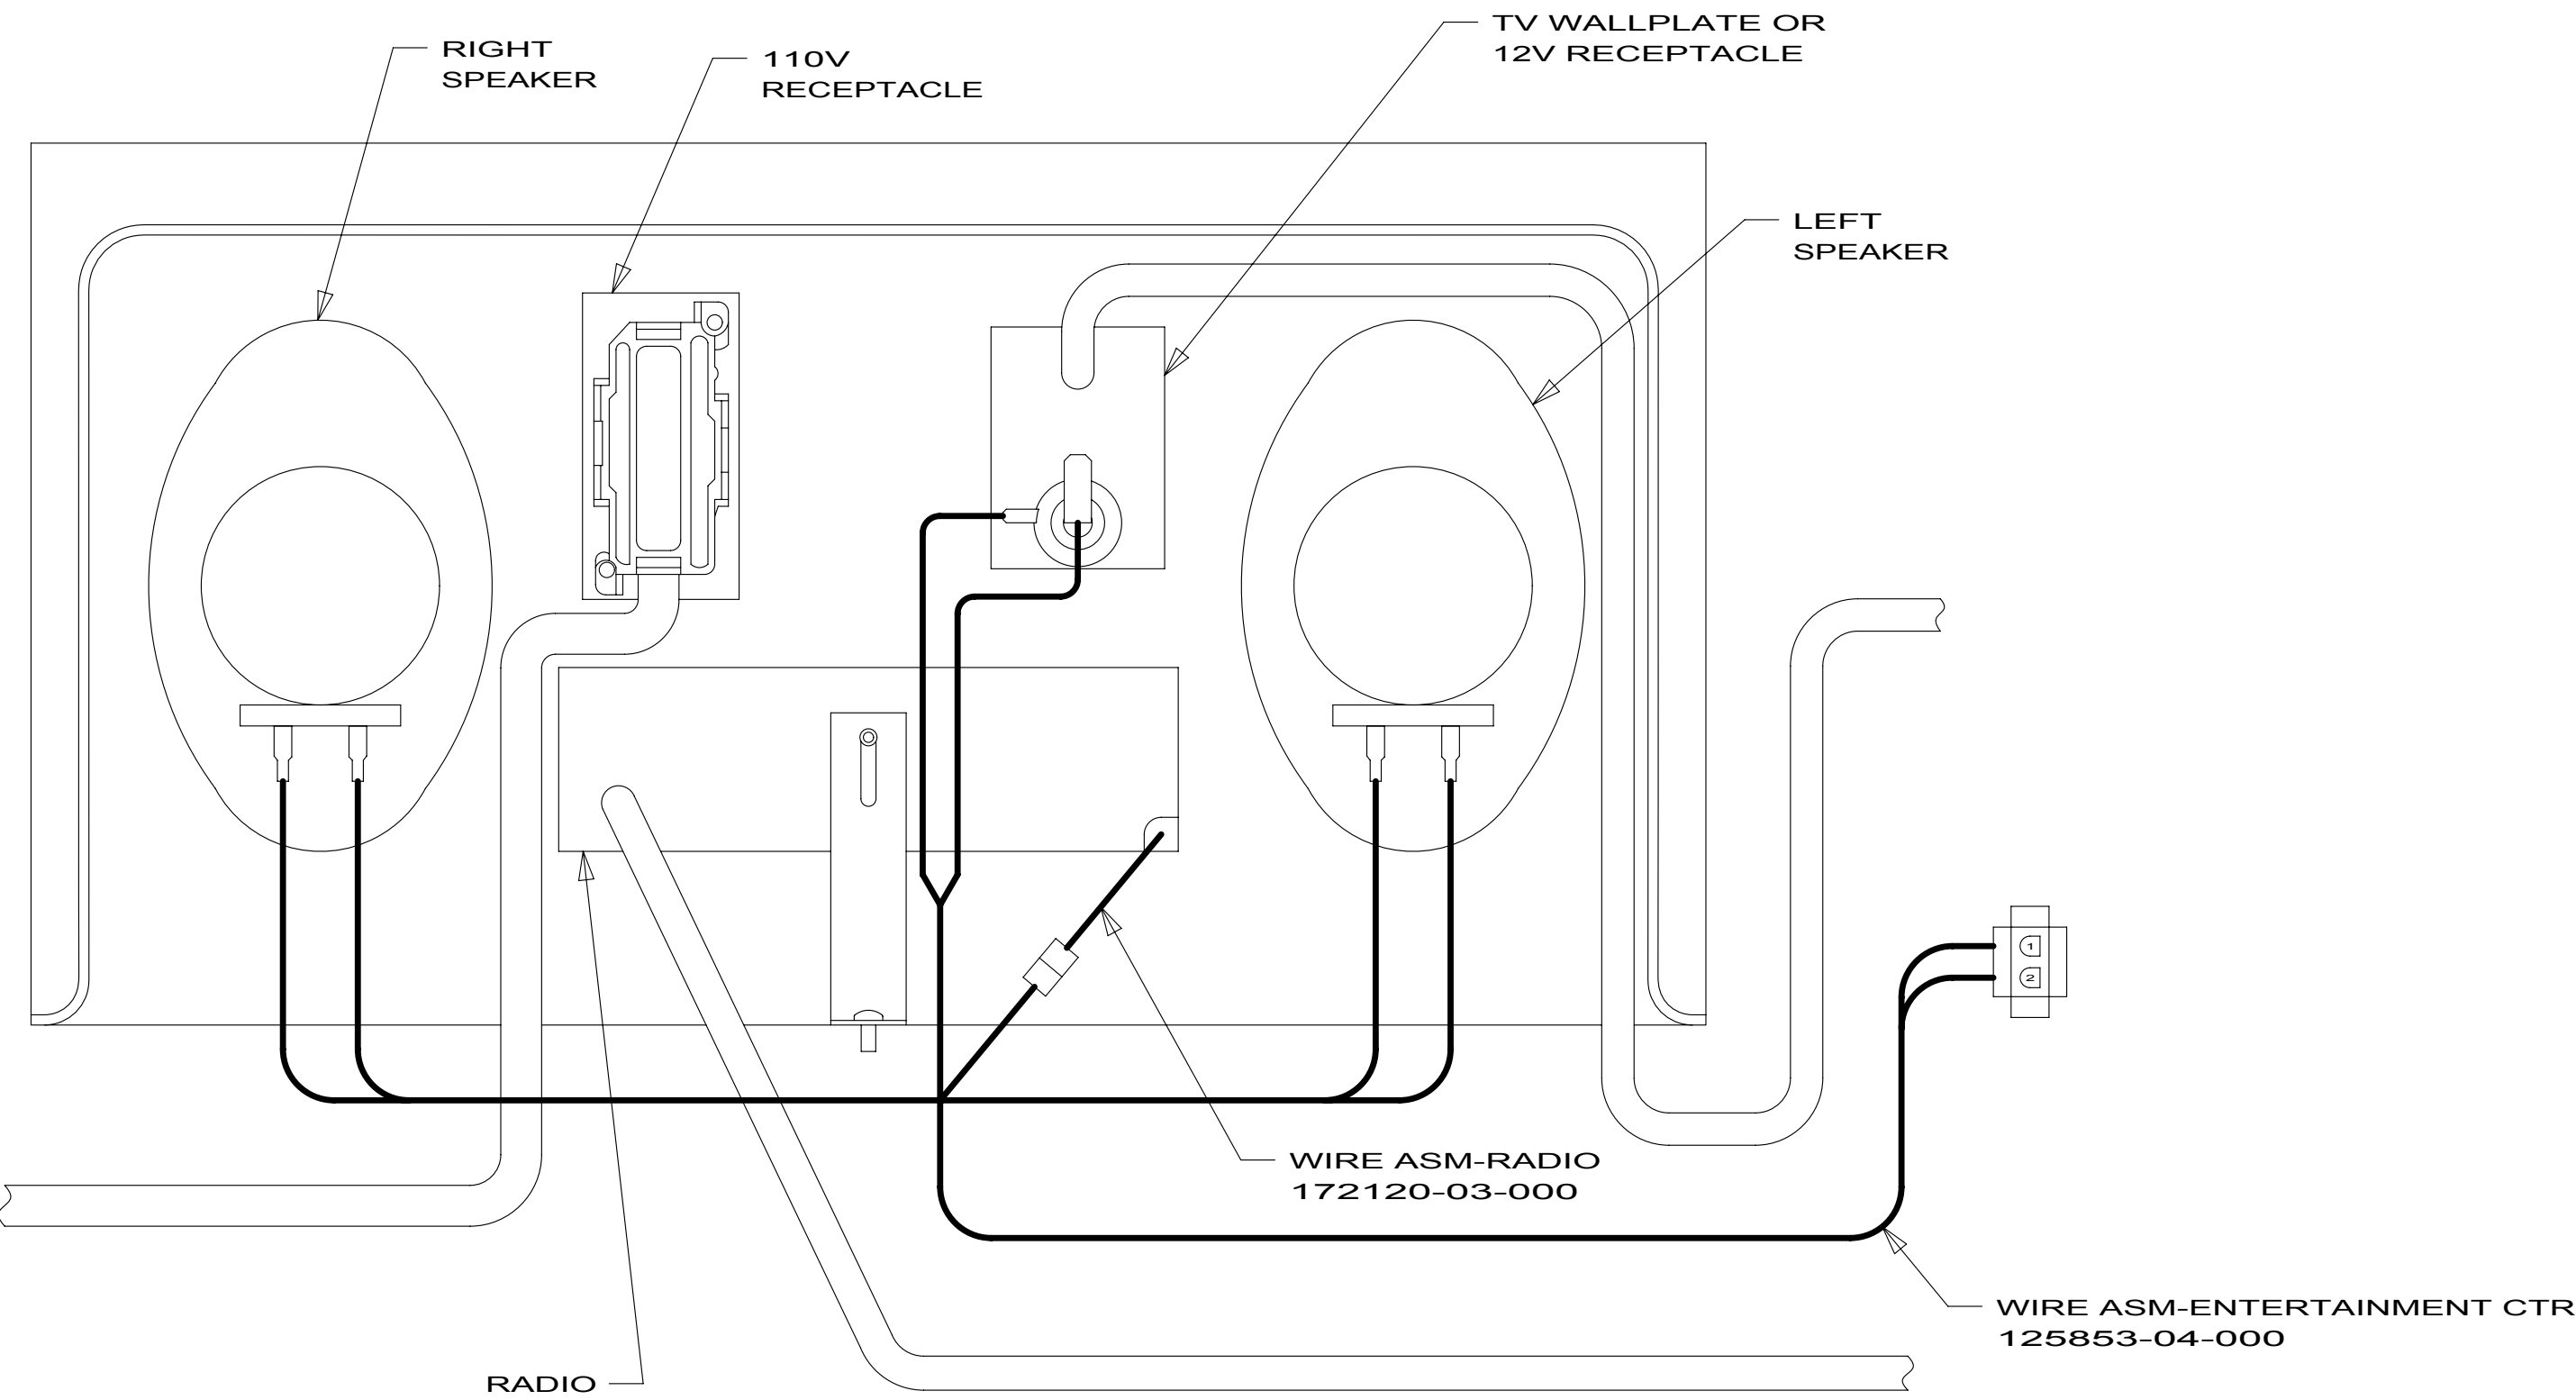

DETAIL EA 173464-01

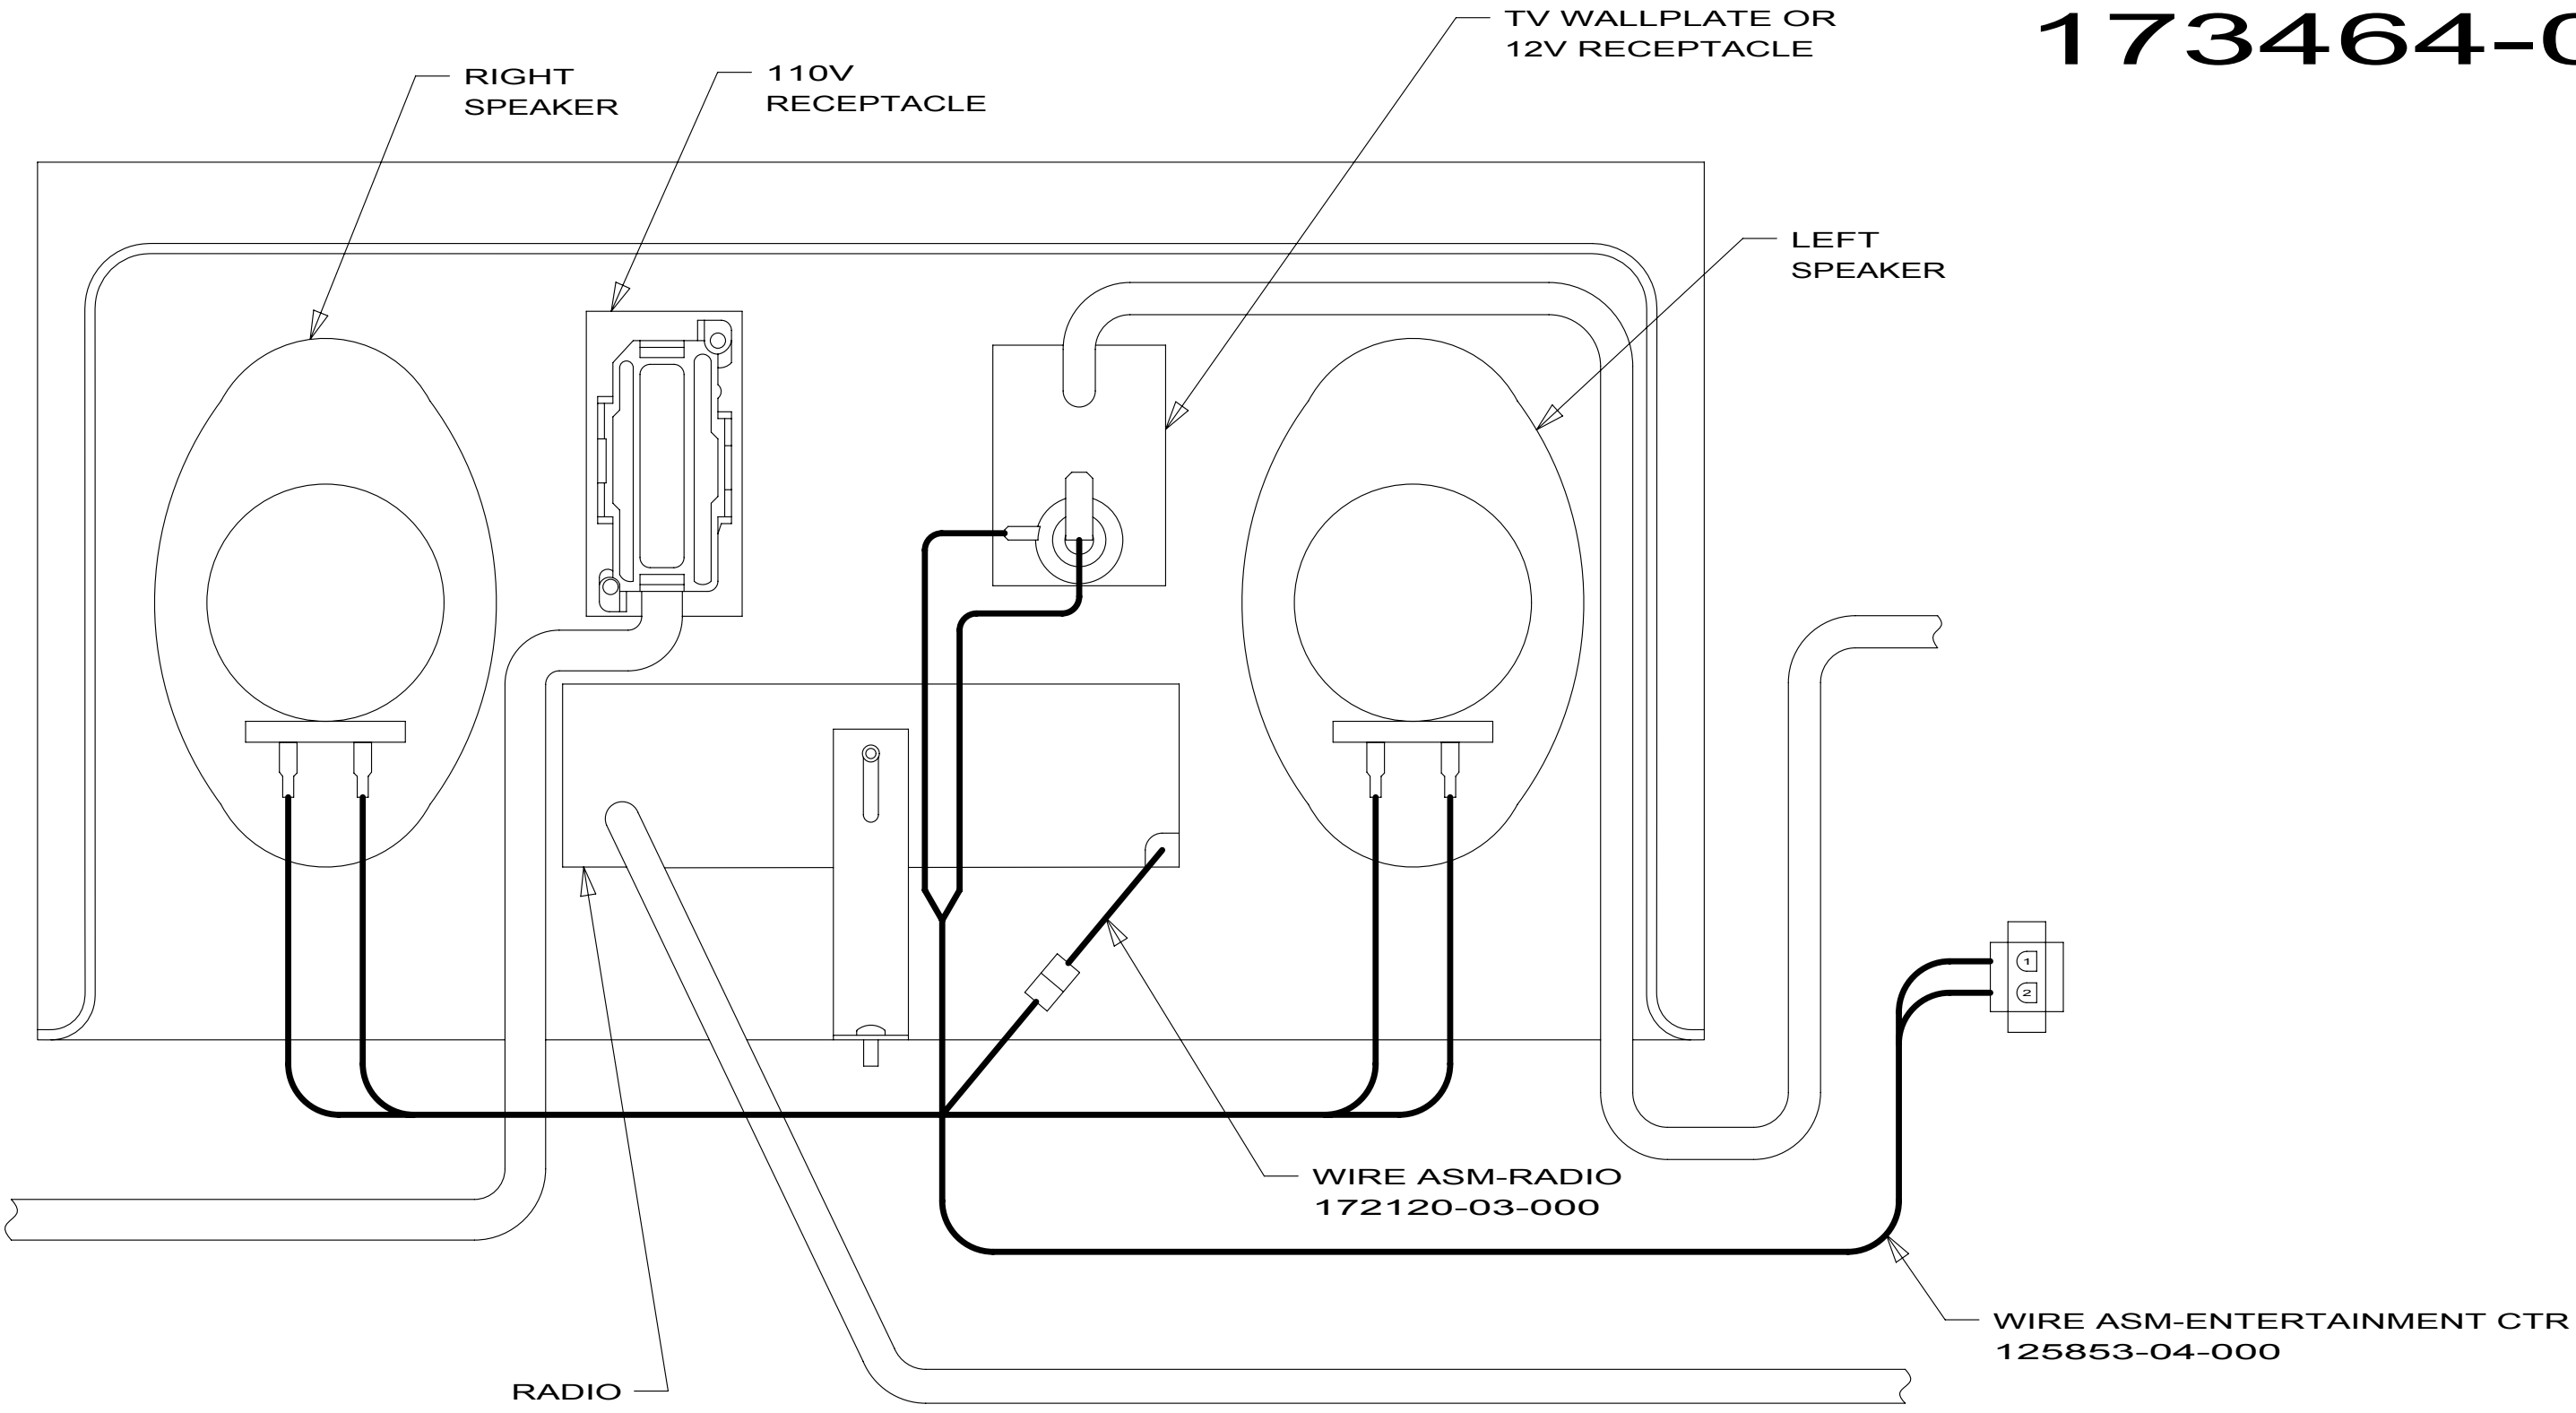

DETAIL EC 173464-03
173464-07
173464-08

1D5 ENTERTAINMENT CENTER/EXT W/CD


FOR ELECTRICAL
TORQUE
SPECIFICATIONS
SEE DWG NO.
128783-01-000

X-X

FOR
ELECTRICAL
CALLOUTS
SEE DWG NO.
121339-01-000

10 MOTORHOMES

ENTERTAINMENT CENTER COMPL

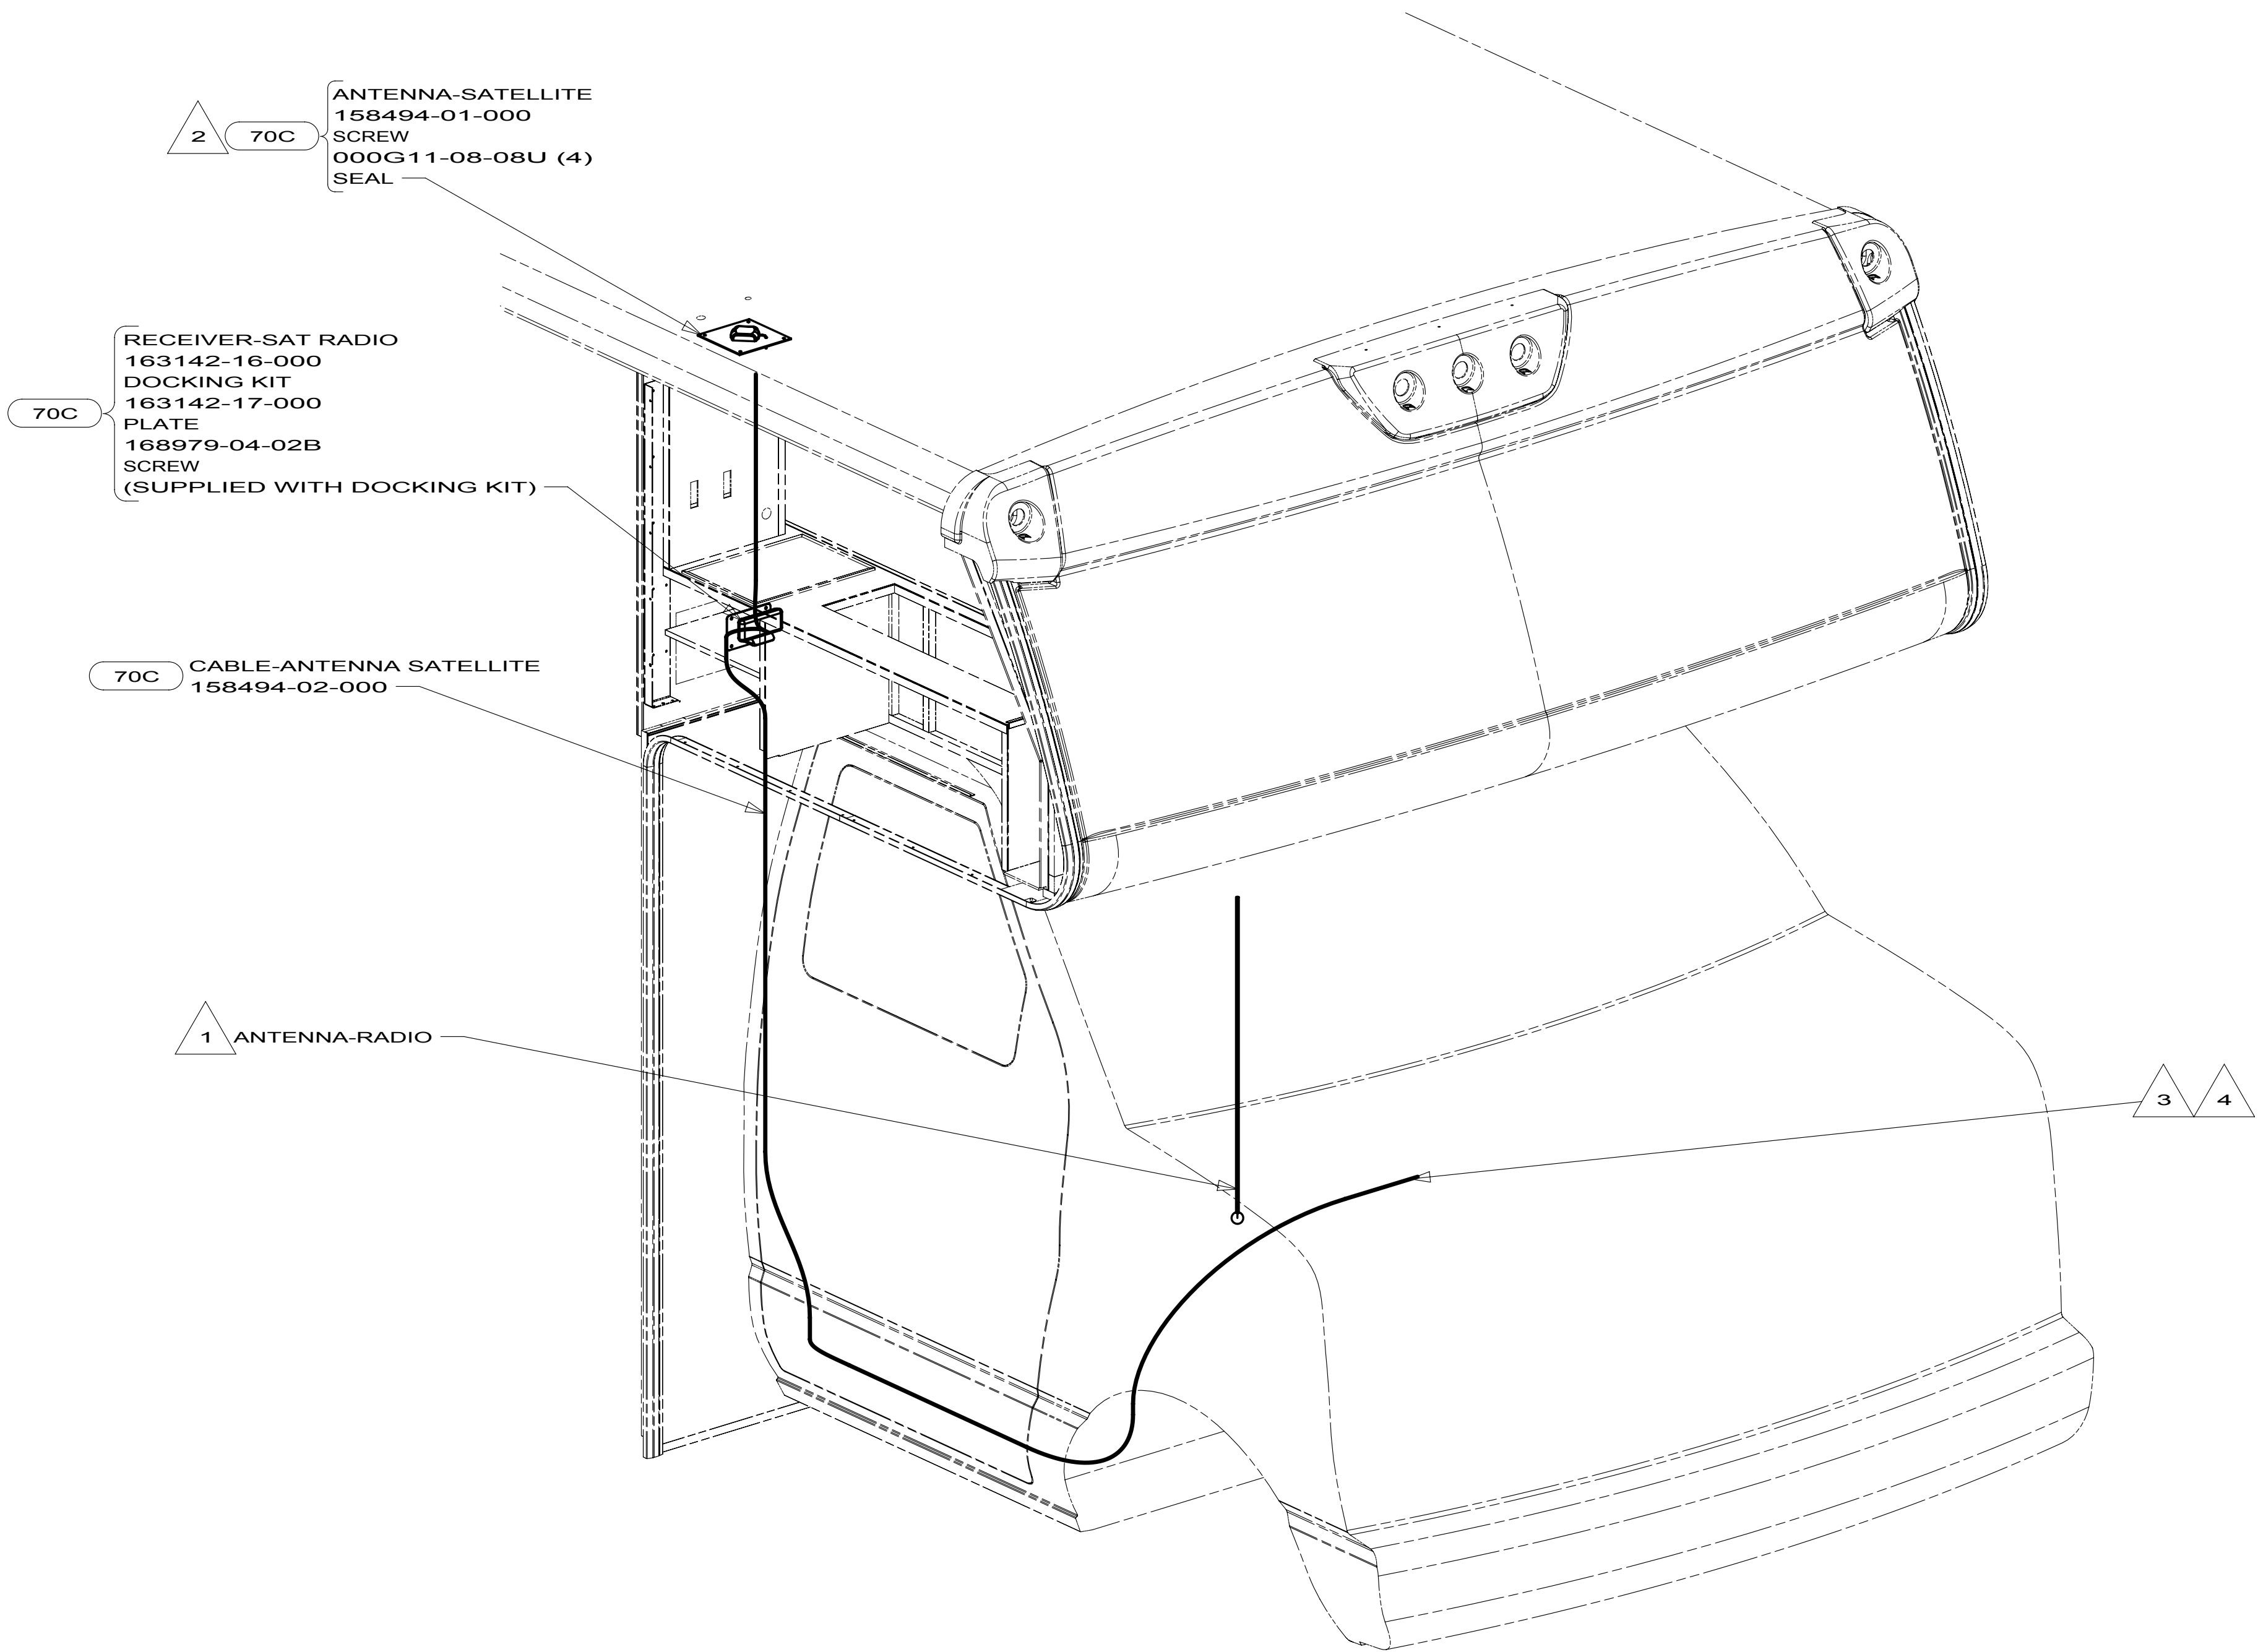

169848-01
200-SERIES

169848-02
300-SERIES

- 4 ON 300-SERIES ROUTE CABLE FROM RADIO TO PASSENGER'S STEPWELL AREA, UP B-POST, INTO WINGWALL, THROUGH SLEEP BOARD ASM, TO ENTERTAINMENT CENTER.
- 3 RECEIVER CABLE SUPPLIED WITH RECEIVER.
- 2 MOUNT ANTENNA SUCH THAT BASE IS SQUARE WITH ROOF AND HOLE IS DIRECTLY OVER HOLE IN ROOF. SEAL BOTH THE HOLE IN THE ROOF AND ANTENNA BASE AT SCREWS.
- 1 SUPPLIED WITH CHASSIS. USE SHORTEST SUPPLIED ANTENNA.

NOTES:

- 70C RADIO - SATELLITE
- 265 CODES/STANDARDS-CSA/CMVSS
- 1B1 CODES/STANDARDS USA
- 1B1 265

10 MOTORHOMES


ANTENNA INSTL-RADIO AND CB

2

169848

FOR ELECTRICAL
TORQUE
SPECIFICATIONS
SEE DWG NO.
128783-01-000

FOR
ELECTRICAL
CALLOUTS
SEE DWG NO.
121339-01-000

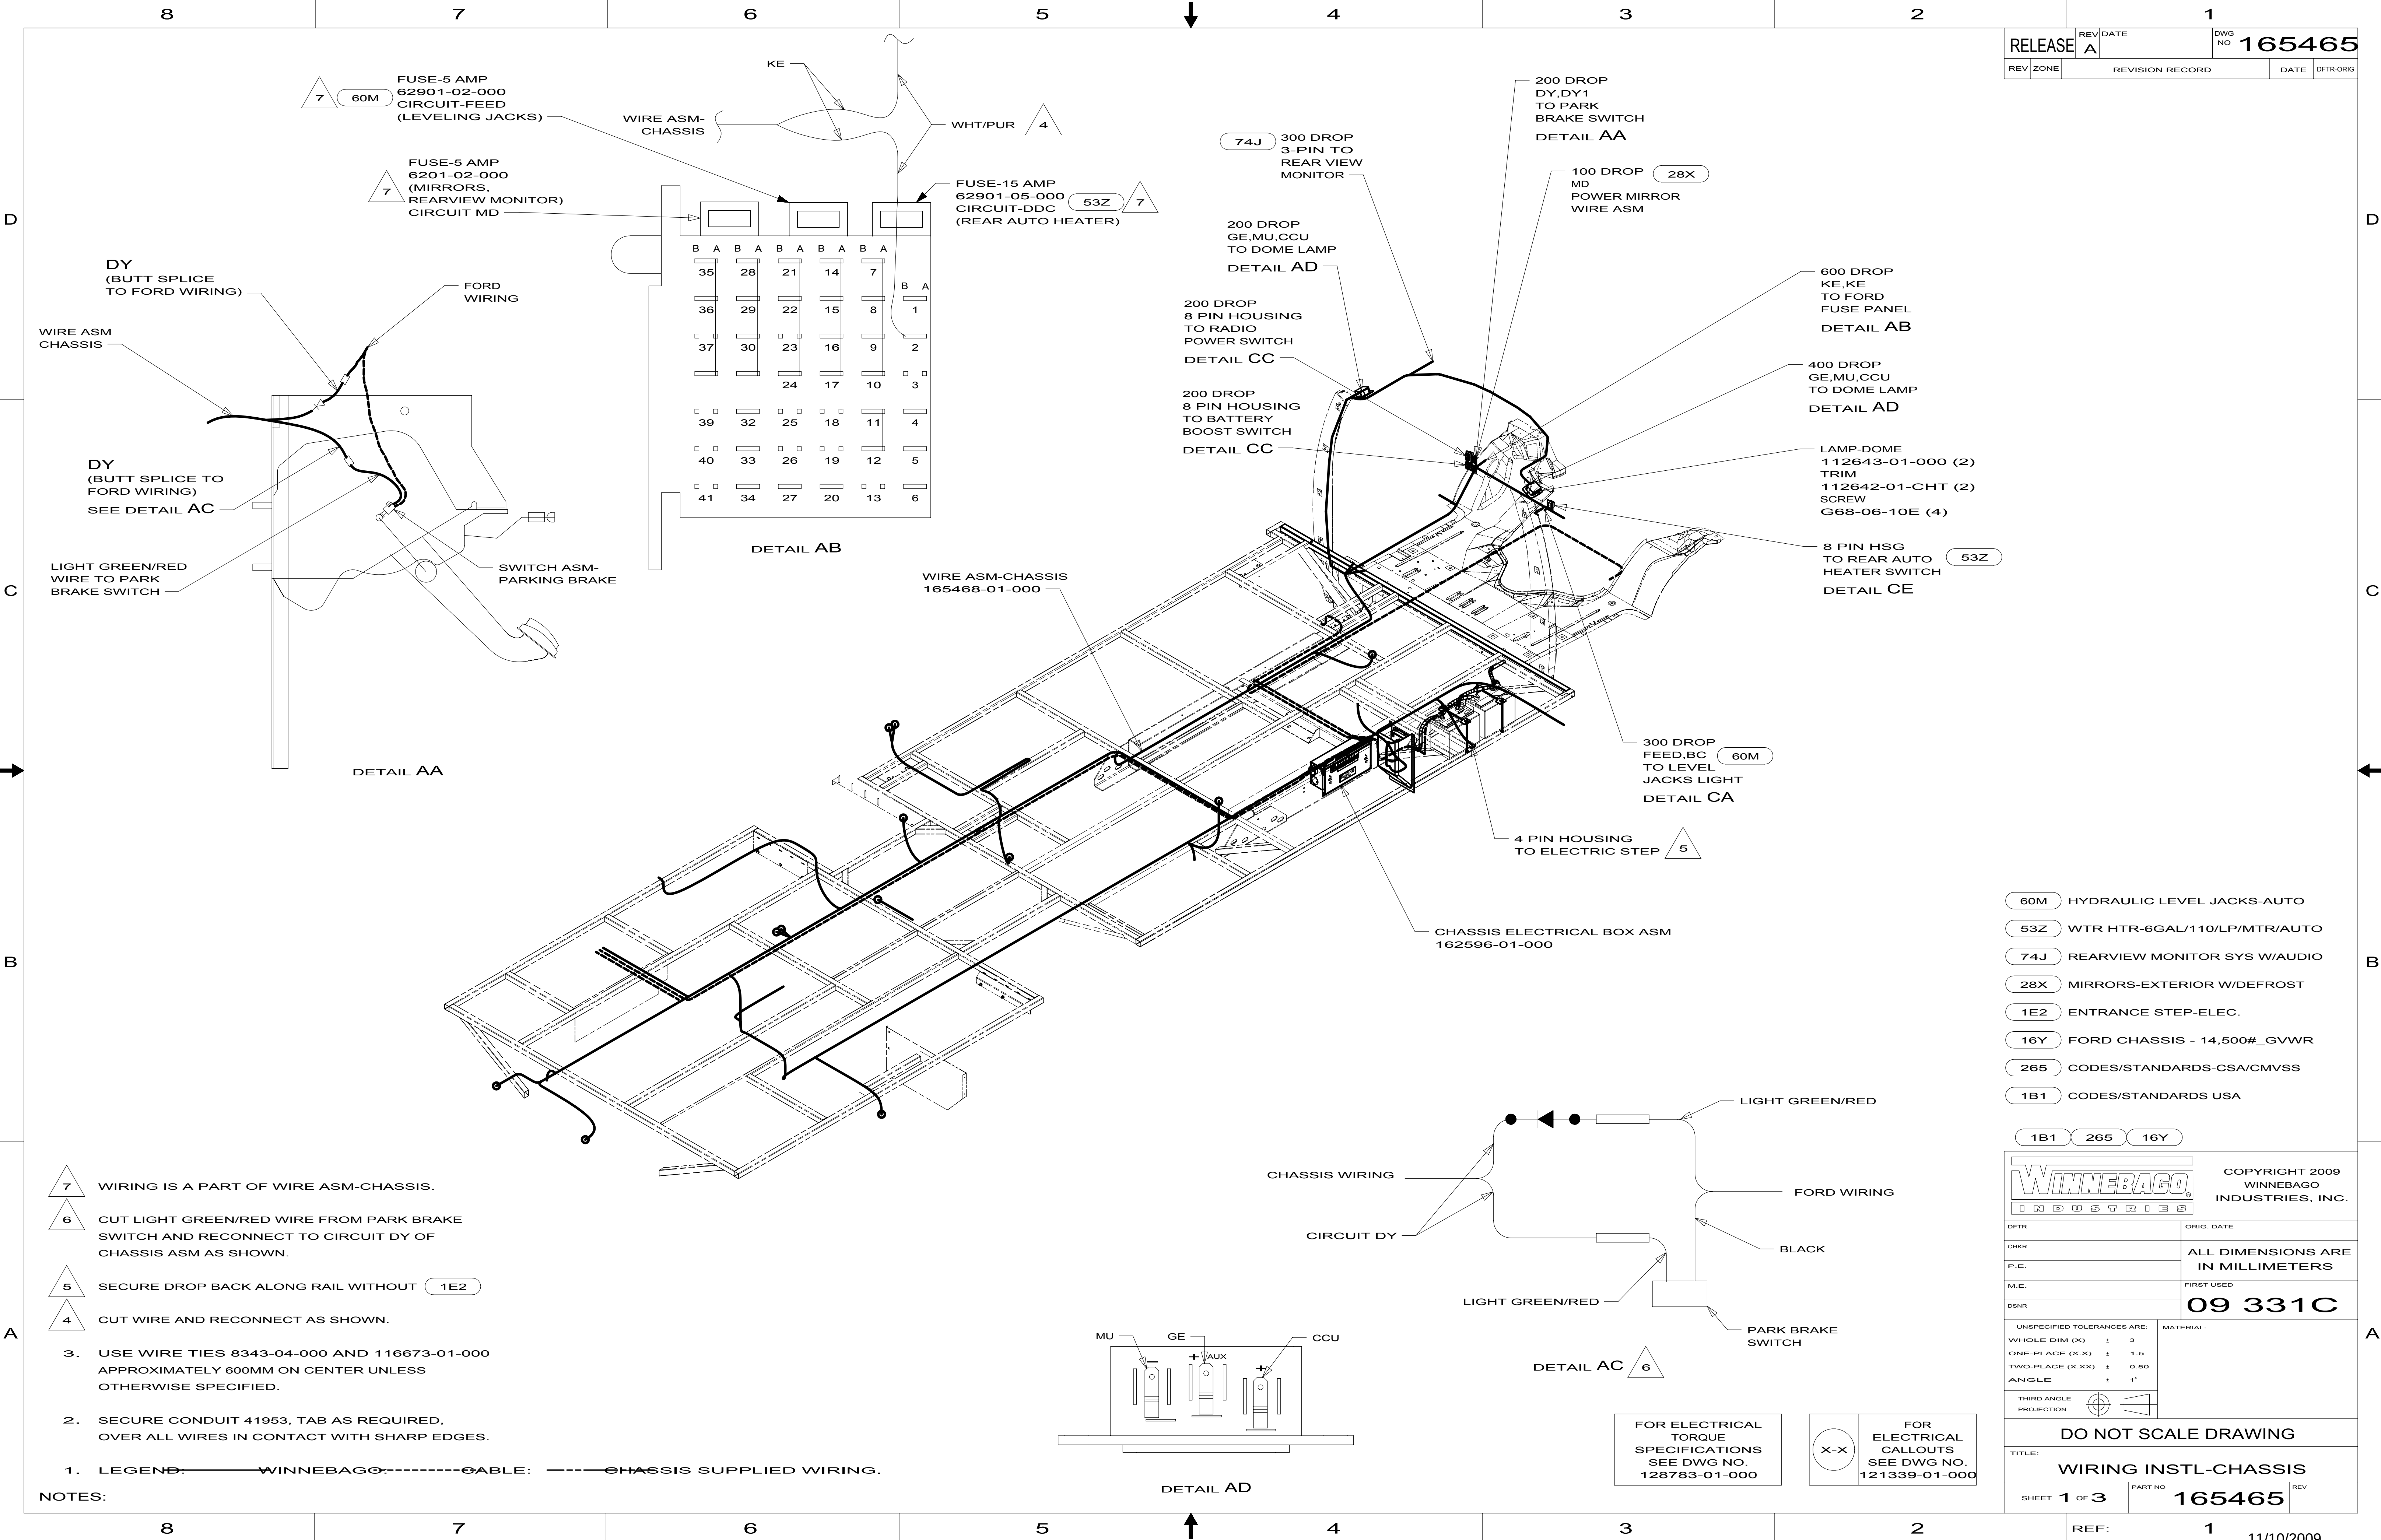

RELEASE		REV DATE	1		DWG NO	165465	
REV	ZONE	REVISION RECORD		DATE	DFT-ORIG		


- 60M HYDRAULIC LEVEL JACKS-AUTO
- 53Z WTR HTR-6GAL/110/LP/MTR/AUTO
- 74J REARVIEW MONITOR SYS W/AUDIO
- 28X MIRRORS-EXTERIOR W/DEFROST
- 1E2 ENTRANCE STEP-ELEC.
- 16Y FORD CHASSIS - 14,500#_GVWR
- 265 CODES/STANDARDS-CSA/CMVSS
- 1B1 CODES/STANDARDS USA

COPYRIGHT 2009
WINNEBAGO
INDUSTRIES, INC.

DFT-ORIG	ORIG. DATE
CHKR	ALL DIMENSIONS ARE IN MILLIMETERS
P.E.	
M.E.	
DSNR	FIRST USED
UNSPECIFIED TOLERANCES ARE:	
WHOLE DIM (X)	± 3
ONE-PLACE (X.X)	± 1.5
TWO-PLACE (X.XX)	± 0.50
ANGLE	± 1°
THIRD ANGLE PROJECTION	

09 331C

DO NOT SCALE DRAWING			
TITLE: WIRING INSTL-CHASSIS			
SHEET 1 OF 3	PART NO 165465	REV	

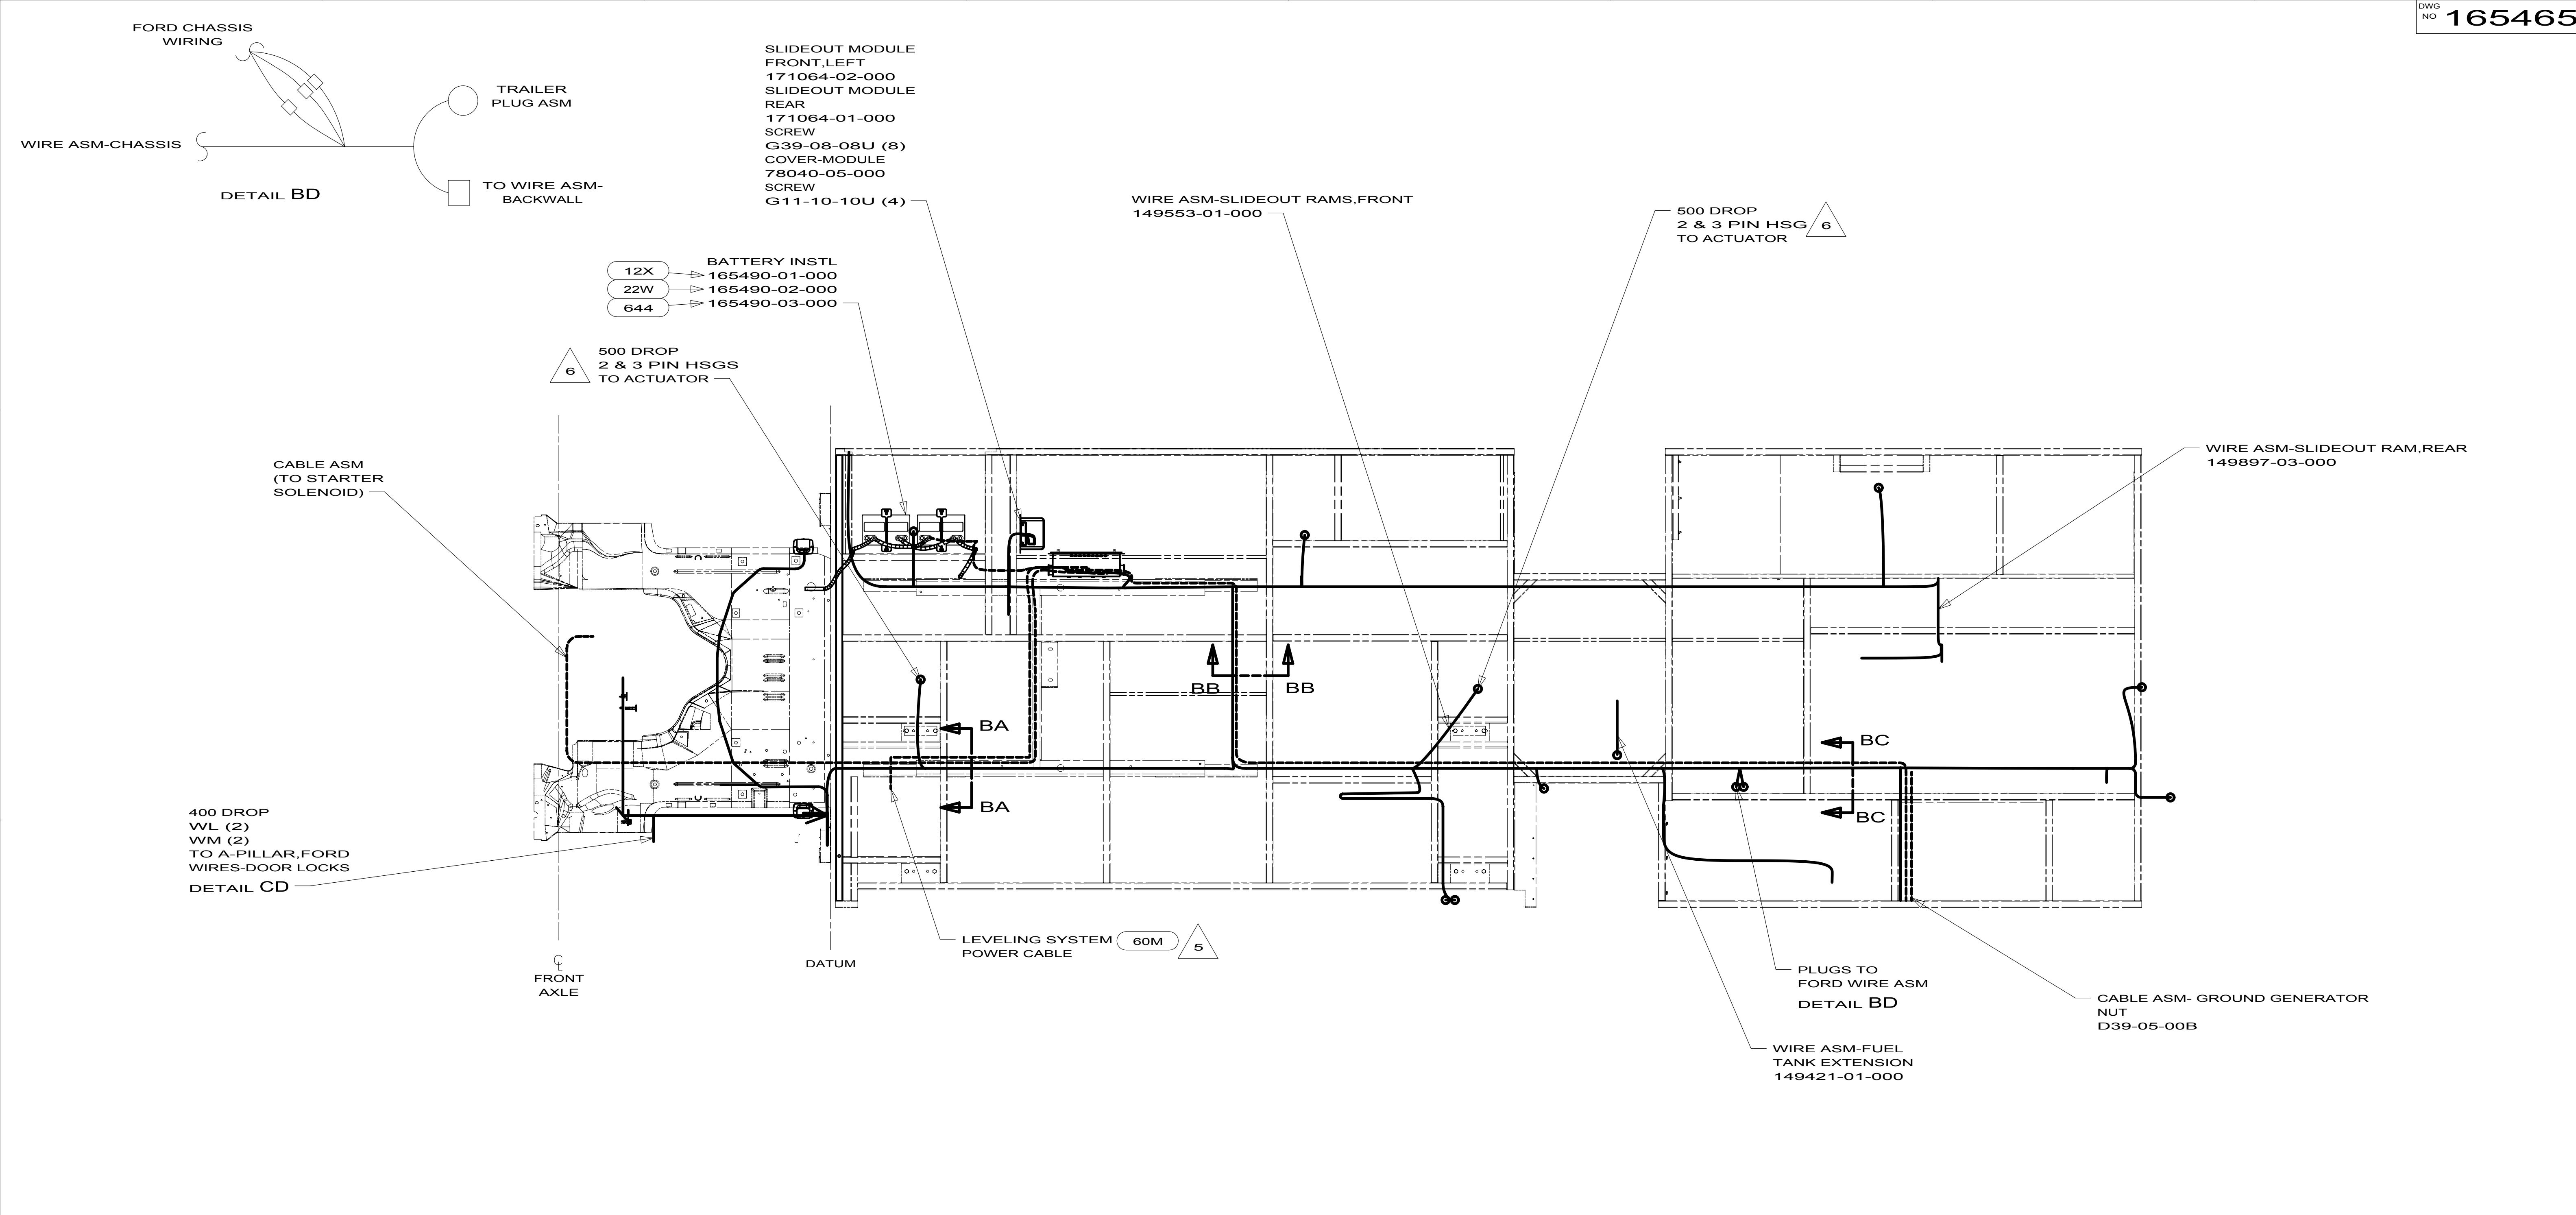

NOTES:

- 3 PIN HOUSING IS PART OF WIRE ASM-CHASSIS AND 2 PIN HOUSING IS PART OF WIRE ASM-SLIDEOUT RAMS,FRONT.
- SEE BATTERY INSTL FOR ADDITIONAL INFORMATION.
- WIRES TO BE TIED TO CROSS MEMBER USING EXISTING HOLES.
- WIRES TO BE TIED TO TOP OF RAIL USING EXISTING HOLES.
- WIRES TO BE TIED TO INSIDE OF RAIL USING EXISTING HOLES.
- CUT OFF EXCESS END OF WIRE TIE.

SECTION BA-BA
(OPPOSITE FOR RIGHT SIDE)

SECTION BB-BB

SECTION BC-BC

FOR ELECTRICAL TORQUE SPECIFICATIONS SEE DWG NO. 128783-01-000

FOR ELECTRICAL CALLOUTS SEE DWG NO. 121339-01-000

644 GREAT ALASKAN RENTAL PACKAGE

60M HYDRAULIC LEVEL JACKS-AUTO

22W BATTERY-SECOND

12X BATTERY-ONE

16Y FORD CHASSIS - 14,500#_GVWR

265 CODES/STANDARDS-CSA/CMVSS

1B1 CODES/STANDARDS USA


1B1 **265** **16Y**

09 331C

DO NOT SCALE DRAWING

WIRING INSTL-CHASSIS

SHEET 2 **165465**

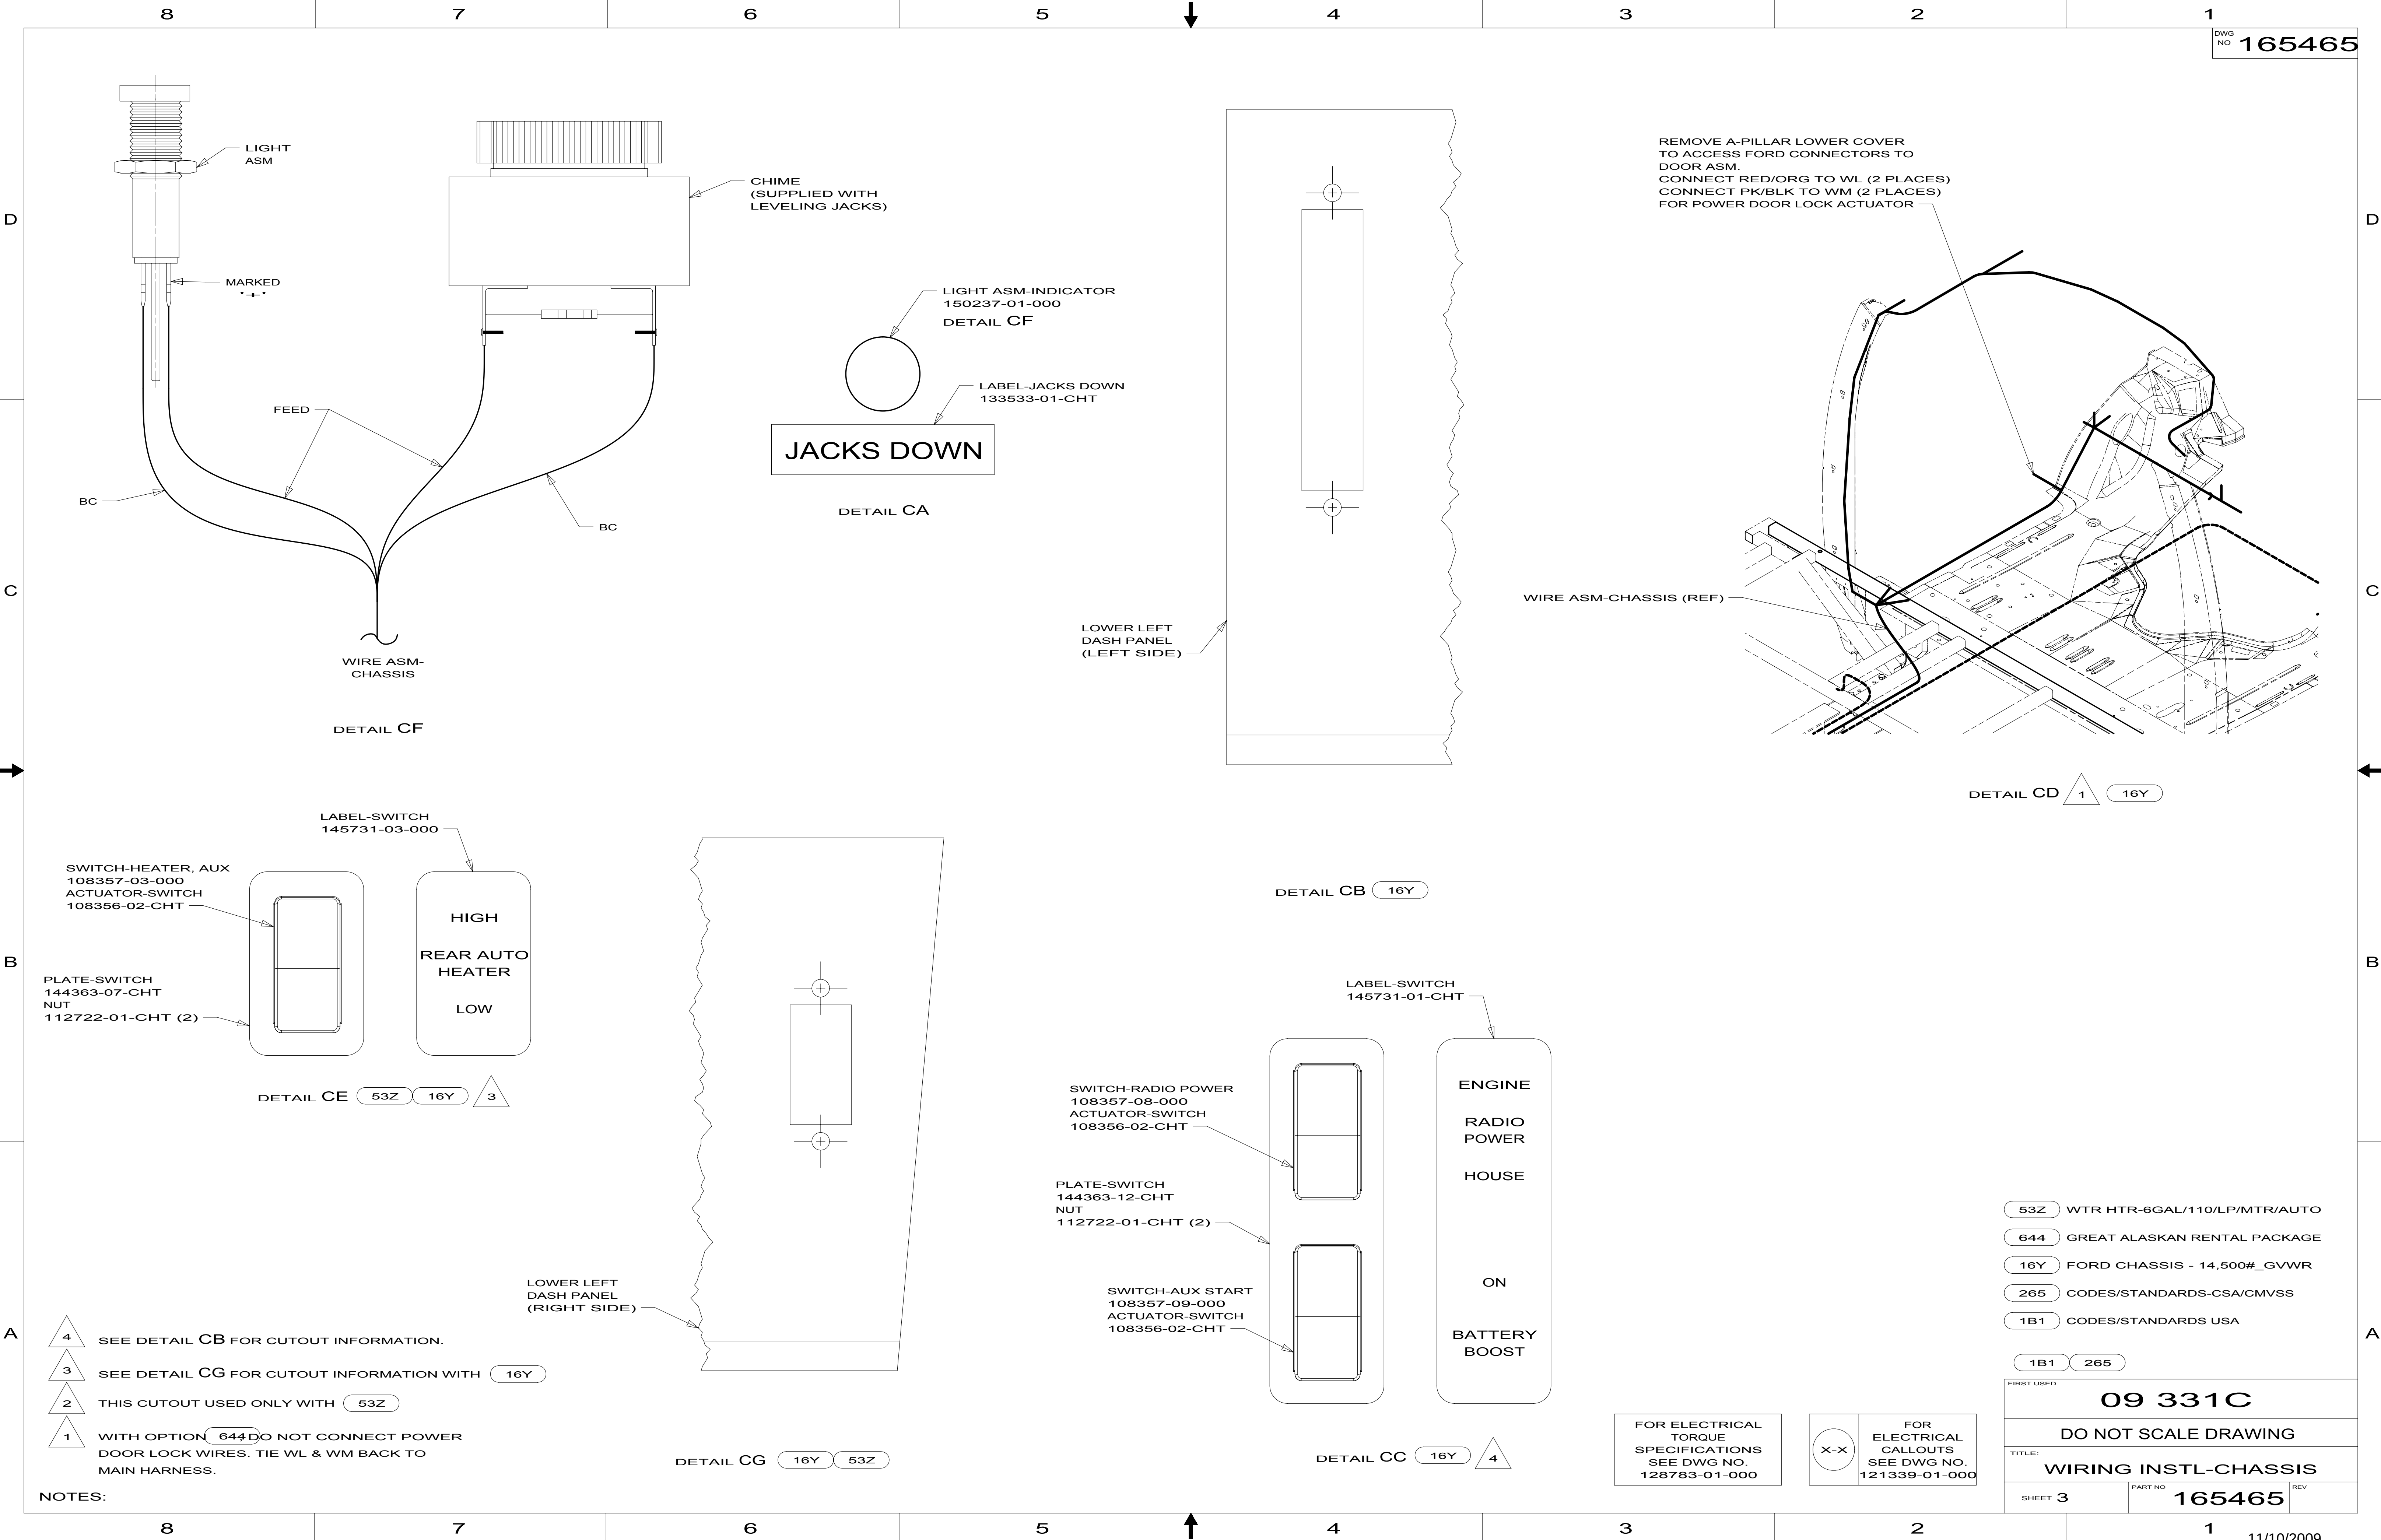

NOTES:


- 4 SEE DETAIL CB FOR CUTOUT INFORMATION.
- 3 SEE DETAIL CG FOR CUTOUT INFORMATION WITH 16Y
- 2 THIS CUTOUT USED ONLY WITH 53Z
- 1 WITH OPTION 644 DO NOT CONNECT POWER DOOR LOCK WIRES. TIE WL & WM BACK TO MAIN HARNESS.

FOR ELECTRICAL TORQUE SPECIFICATIONS SEE DWG NO. 128783-01-000

FOR ELECTRICAL CALLOUTS SEE DWG NO. 121339-01-000

- 53Z WTR HTR-6GAL/110/LP/MTR/AUTO
- 644 GREAT ALASKAN RENTAL PACKAGE
- 16Y FORD CHASSIS - 14,500#_GVWR
- 265 CODES/STANDARDS-CSA/CMVSS
- 1B1 CODES/STANDARDS USA

FIRST USED		
09 331C		
DO NOT SCALE DRAWING		
TITLE: WIRING INSTL-CHASSIS		
SHEET 3	PART NO 165465	REV

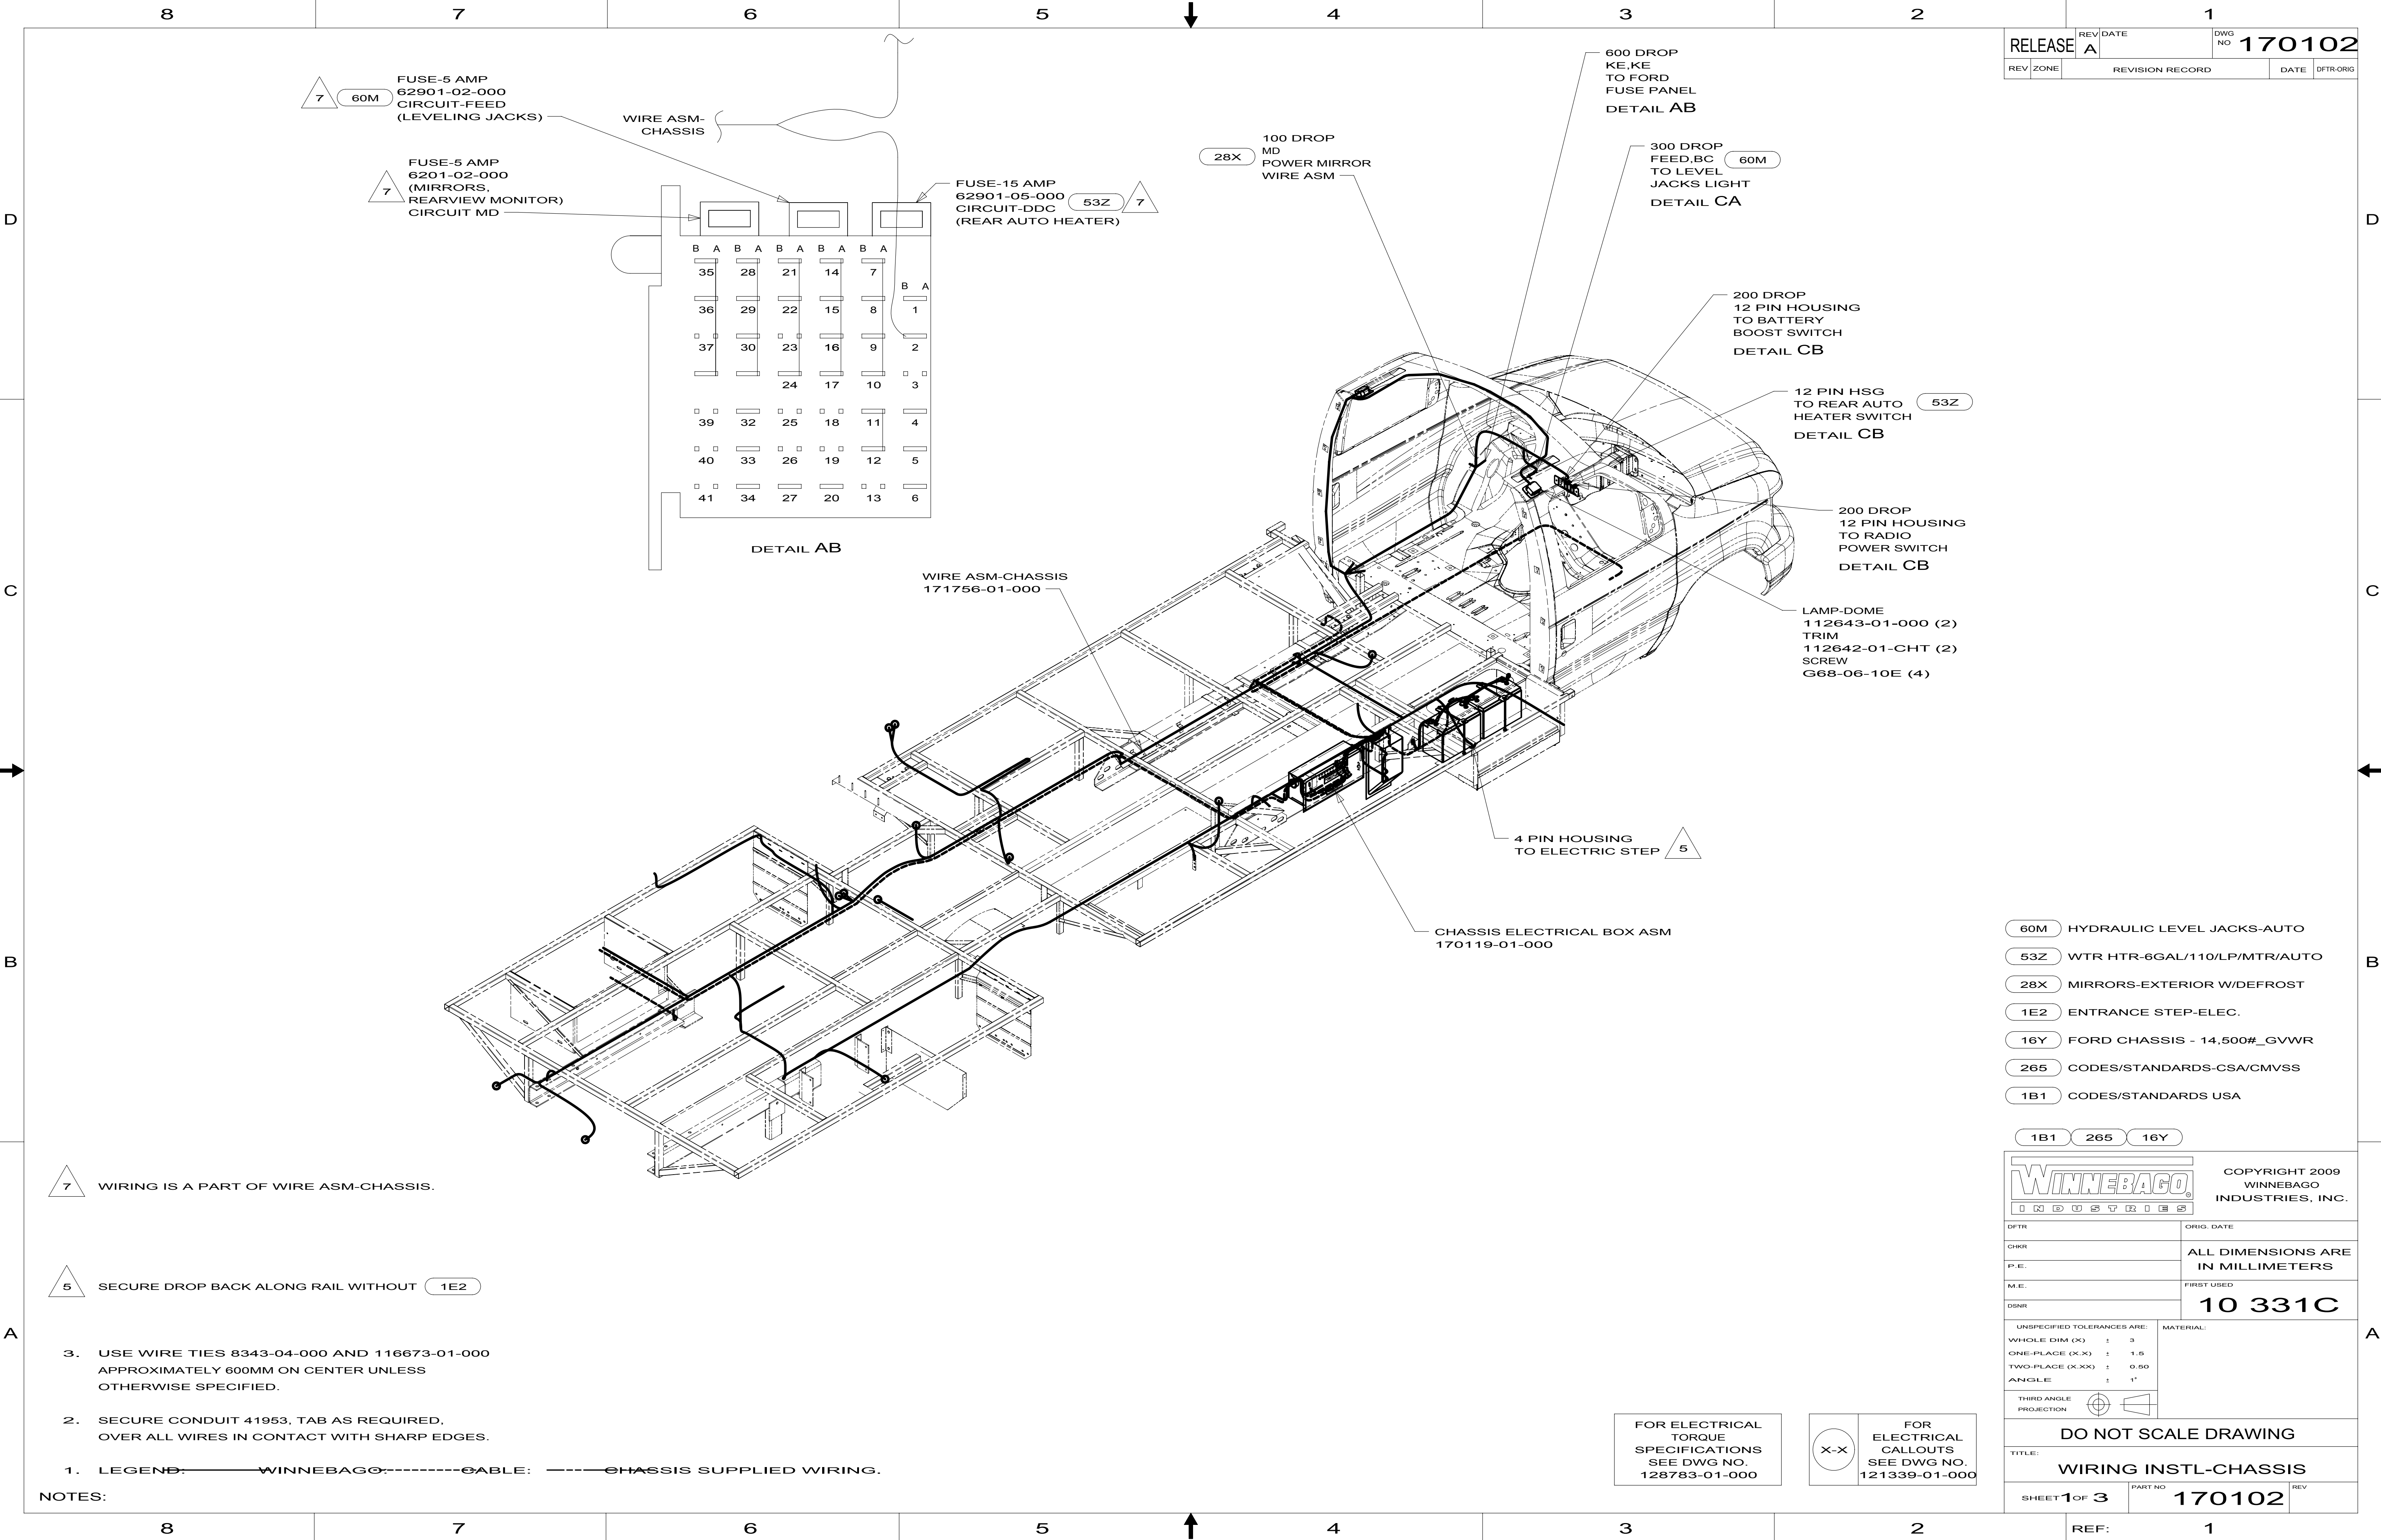

RELEASE		REV DATE	1		DWG NO 170102	
REV	ZONE	REVISION RECORD		DATE	DFT-ORIG	

- 60M HYDRAULIC LEVEL JACKS-AUTO
- 53Z WTR HTR-6GAL/110/LP/MTR/AUTO
- 28X MIRRORS-EXTERIOR W/DEFROST
- 1E2 ENTRANCE STEP-ELEC.
- 16Y FORD CHASSIS - 14,500#_GVWR
- 265 CODES/STANDARDS-CSA/CMVSS
- 1B1 CODES/STANDARDS USA

WINNEBAGO
INDUSTRIES

COPYRIGHT 2009
WINNEBAGO
INDUSTRIES, INC.

DFT-ORIG	ORIG. DATE
CHKR	ALL DIMENSIONS ARE IN MILLIMETERS
P.E.	
M.E.	
DSNR	FIRST USED
UNSPECIFIED TOLERANCES ARE:	
WHOLE DIM (X)	± 3
ONE-PLACE (X.X)	± 1.5
TWO-PLACE (X.XX)	± 0.50
ANGLE	± 1°
THIRD ANGLE PROJECTION	


DO NOT SCALE DRAWING	
TITLE: WIRING INSTL-CHASSIS	
SHEET 1 OF 3	PART NO 170102
REF:	1

FOR ELECTRICAL
TORQUE
SPECIFICATIONS
SEE DWG NO.
128783-01-000

X-X

FOR
ELECTRICAL
CALLOUTS
SEE DWG NO.
121339-01-000

- 7 WIRING IS A PART OF WIRE ASM-CHASSIS.
- 5 SECURE DROP BACK ALONG RAIL WITHOUT 1E2
3. USE WIRE TIES 8343-04-000 AND 116673-01-000 APPROXIMATELY 600MM ON CENTER UNLESS OTHERWISE SPECIFIED.
2. SECURE CONDUIT 41953, TAB AS REQUIRED, OVER ALL WIRES IN CONTACT WITH SHARP EDGES.
1. LEGEND: — WINNEBAGO; - - - CABLE; - - - CHASSIS SUPPLIED WIRING.
- NOTES:

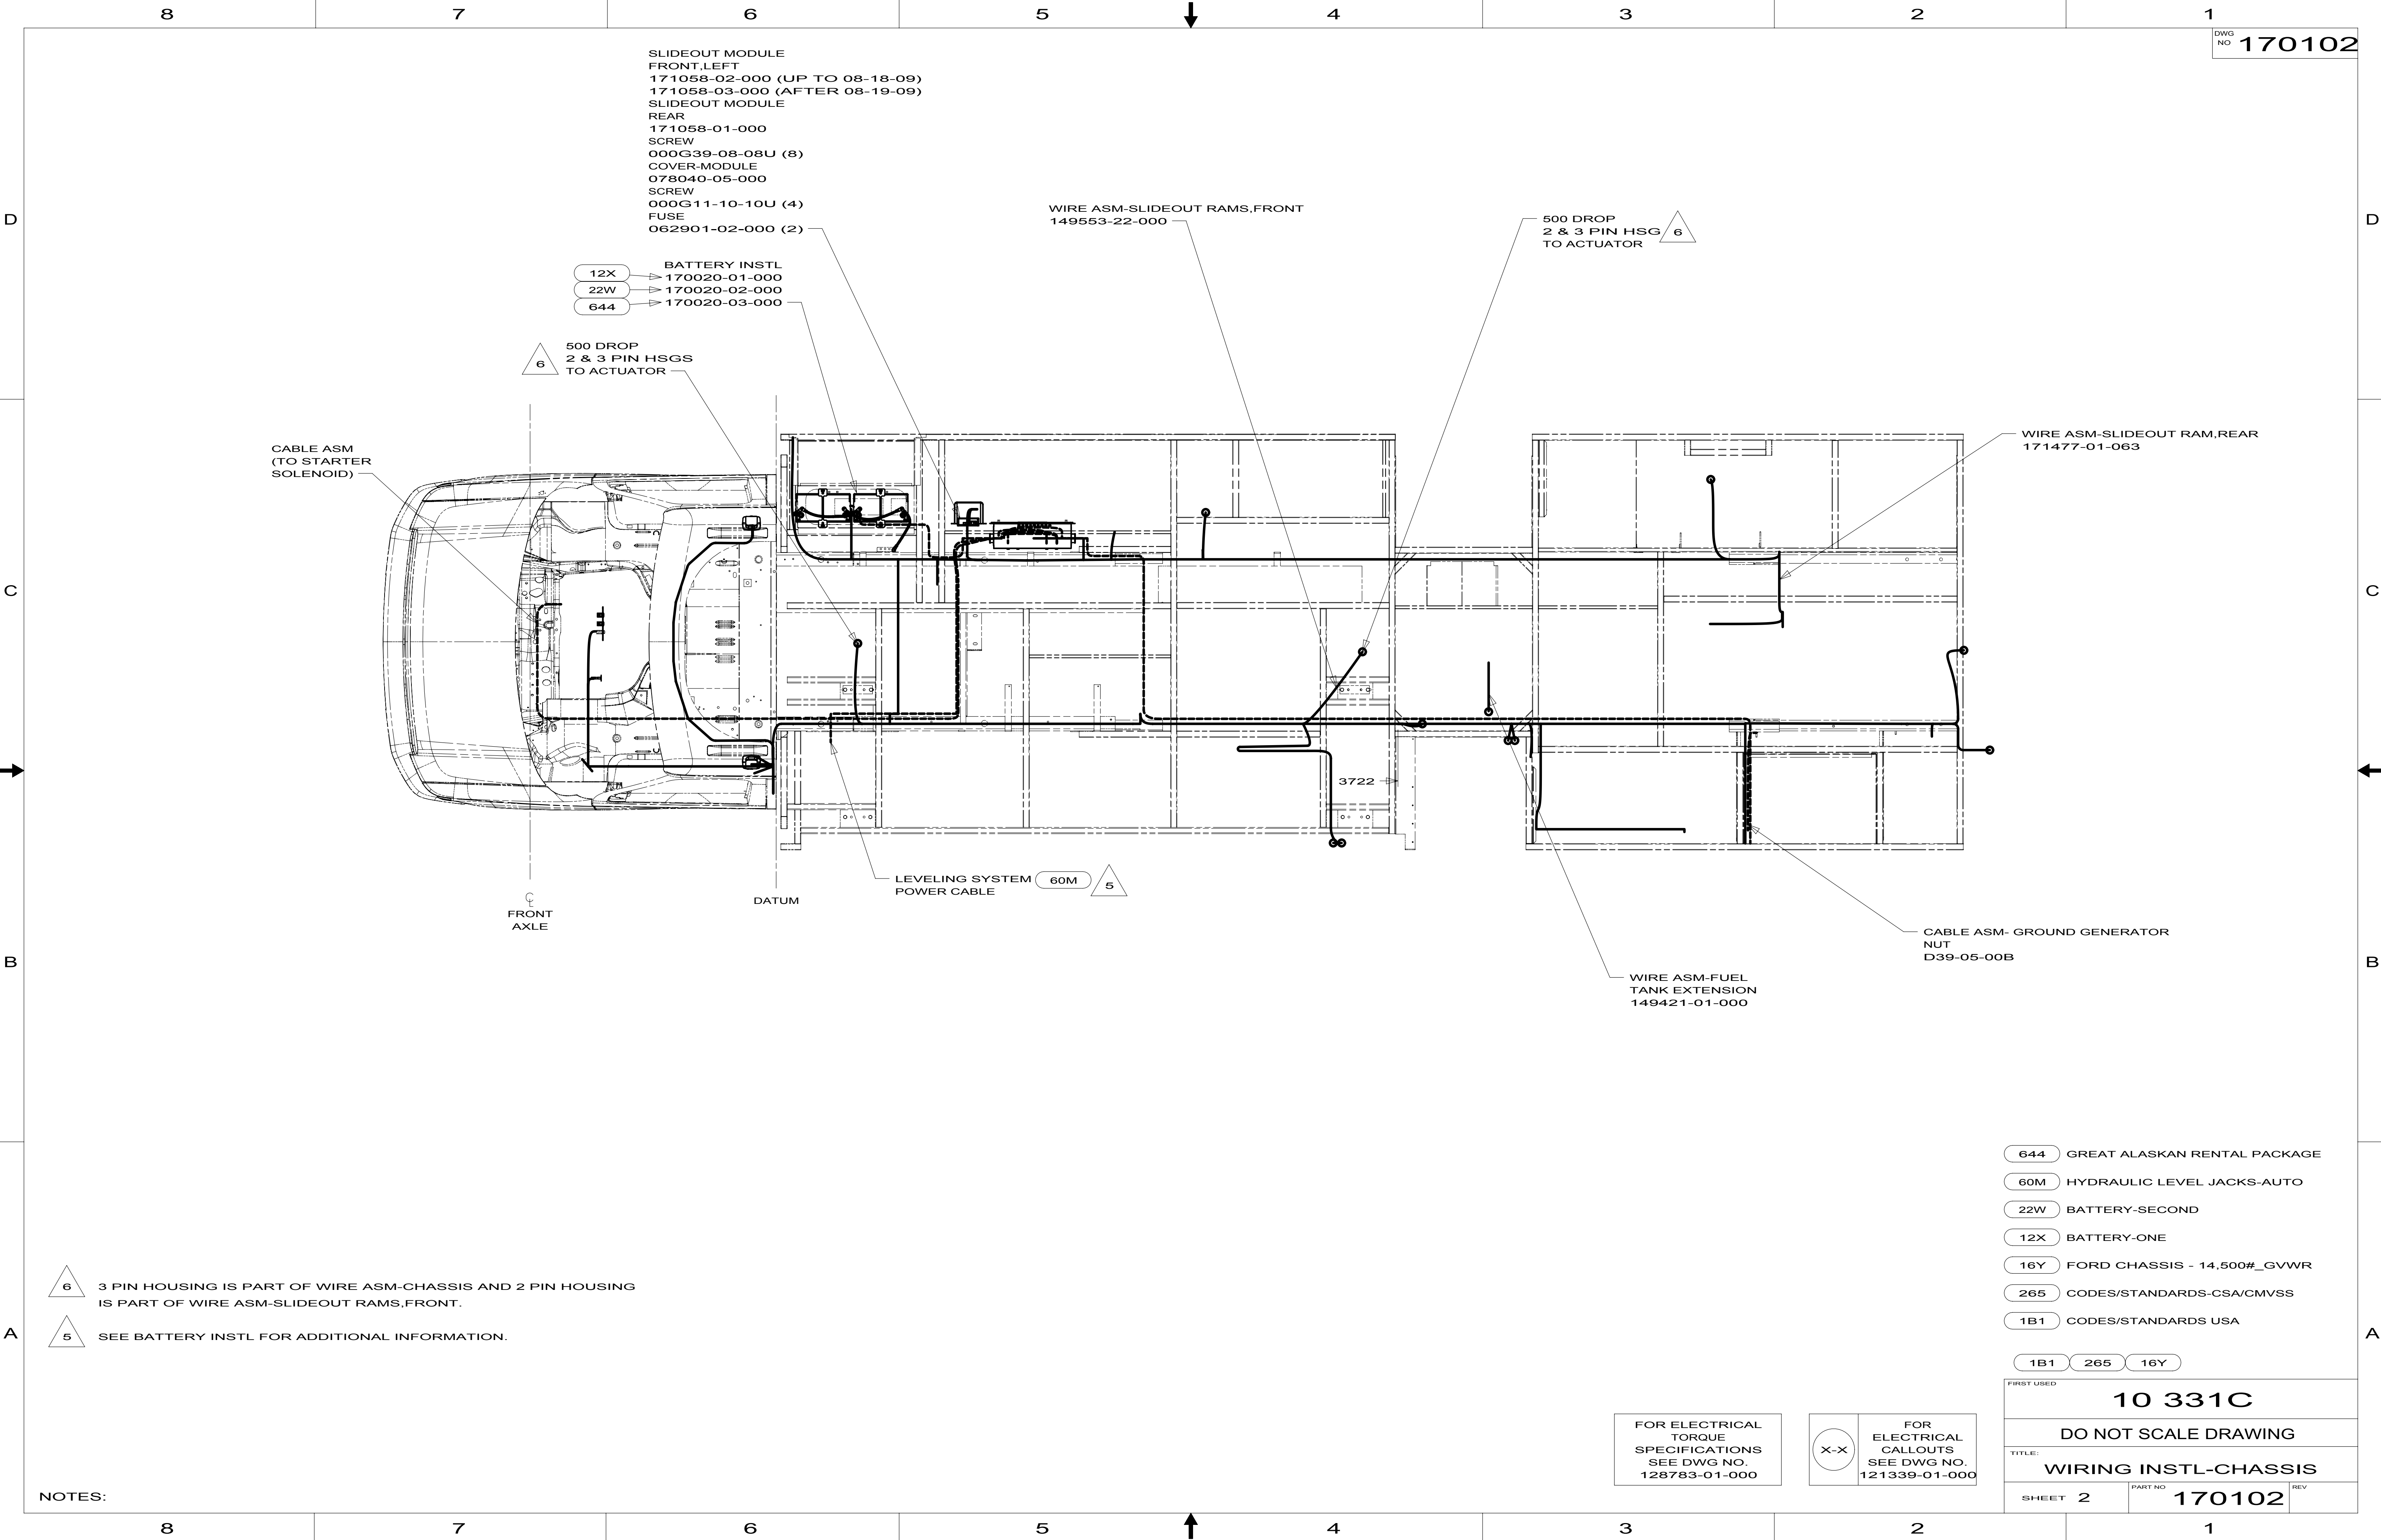

SLIDEOUT MODULE
FRONT, LEFT
171058-02-000 (UP TO 08-18-09)
171058-03-000 (AFTER 08-19-09)
SLIDEOUT MODULE
REAR
171058-01-000
SCREW
000G39-08-08U (8)
COVER-MODULE
078040-05-000
SCREW
000G11-10-10U (4)
FUSE
062901-02-000 (2)

12X → BATTERY INSTL
22W → 170020-01-000
644 → 170020-02-000
→ 170020-03-000

500 DROP
2 & 3 PIN HSGS
TO ACTUATOR 6

WIRE ASM-SLIDEOUT RAMS, FRONT
149553-22-000

500 DROP
2 & 3 PIN HSG
TO ACTUATOR 6

WIRE ASM-SLIDEOUT RAM, REAR
171477-01-063

CABLE ASM
(TO STARTER
SOLENOID)

FRONT
AXLE

DATUM

LEVELING SYSTEM
POWER CABLE 60M 5

3722

WIRE ASM-FUEL
TANK EXTENSION
149421-01-000

CABLE ASM- GROUND GENERATOR
NUT
D39-05-00B

6 3 PIN HOUSING IS PART OF WIRE ASM-CHASSIS AND 2 PIN HOUSING
IS PART OF WIRE ASM-SLIDEOUT RAMS, FRONT.

5 SEE BATTERY INSTL FOR ADDITIONAL INFORMATION.

- 644 GREAT ALASKAN RENTAL PACKAGE
- 60M HYDRAULIC LEVEL JACKS-AUTO
- 22W BATTERY-SECOND
- 12X BATTERY-ONE
- 16Y FORD CHASSIS - 14,500#_GVWR
- 265 CODES/STANDARDS-CSA/CMVSS
- 1B1 CODES/STANDARDS USA


1B1 265 16Y


FIRST USED		
10 331C		
DO NOT SCALE DRAWING		
TITLE: WIRING INSTL-CHASSIS		
SHEET 2	PART NO 170102	REV

FOR ELECTRICAL
TORQUE
SPECIFICATIONS
SEE DWG NO.
128783-01-000

FOR
ELECTRICAL
CALLOUTS
SEE DWG NO.
121339-01-000

NOTES:

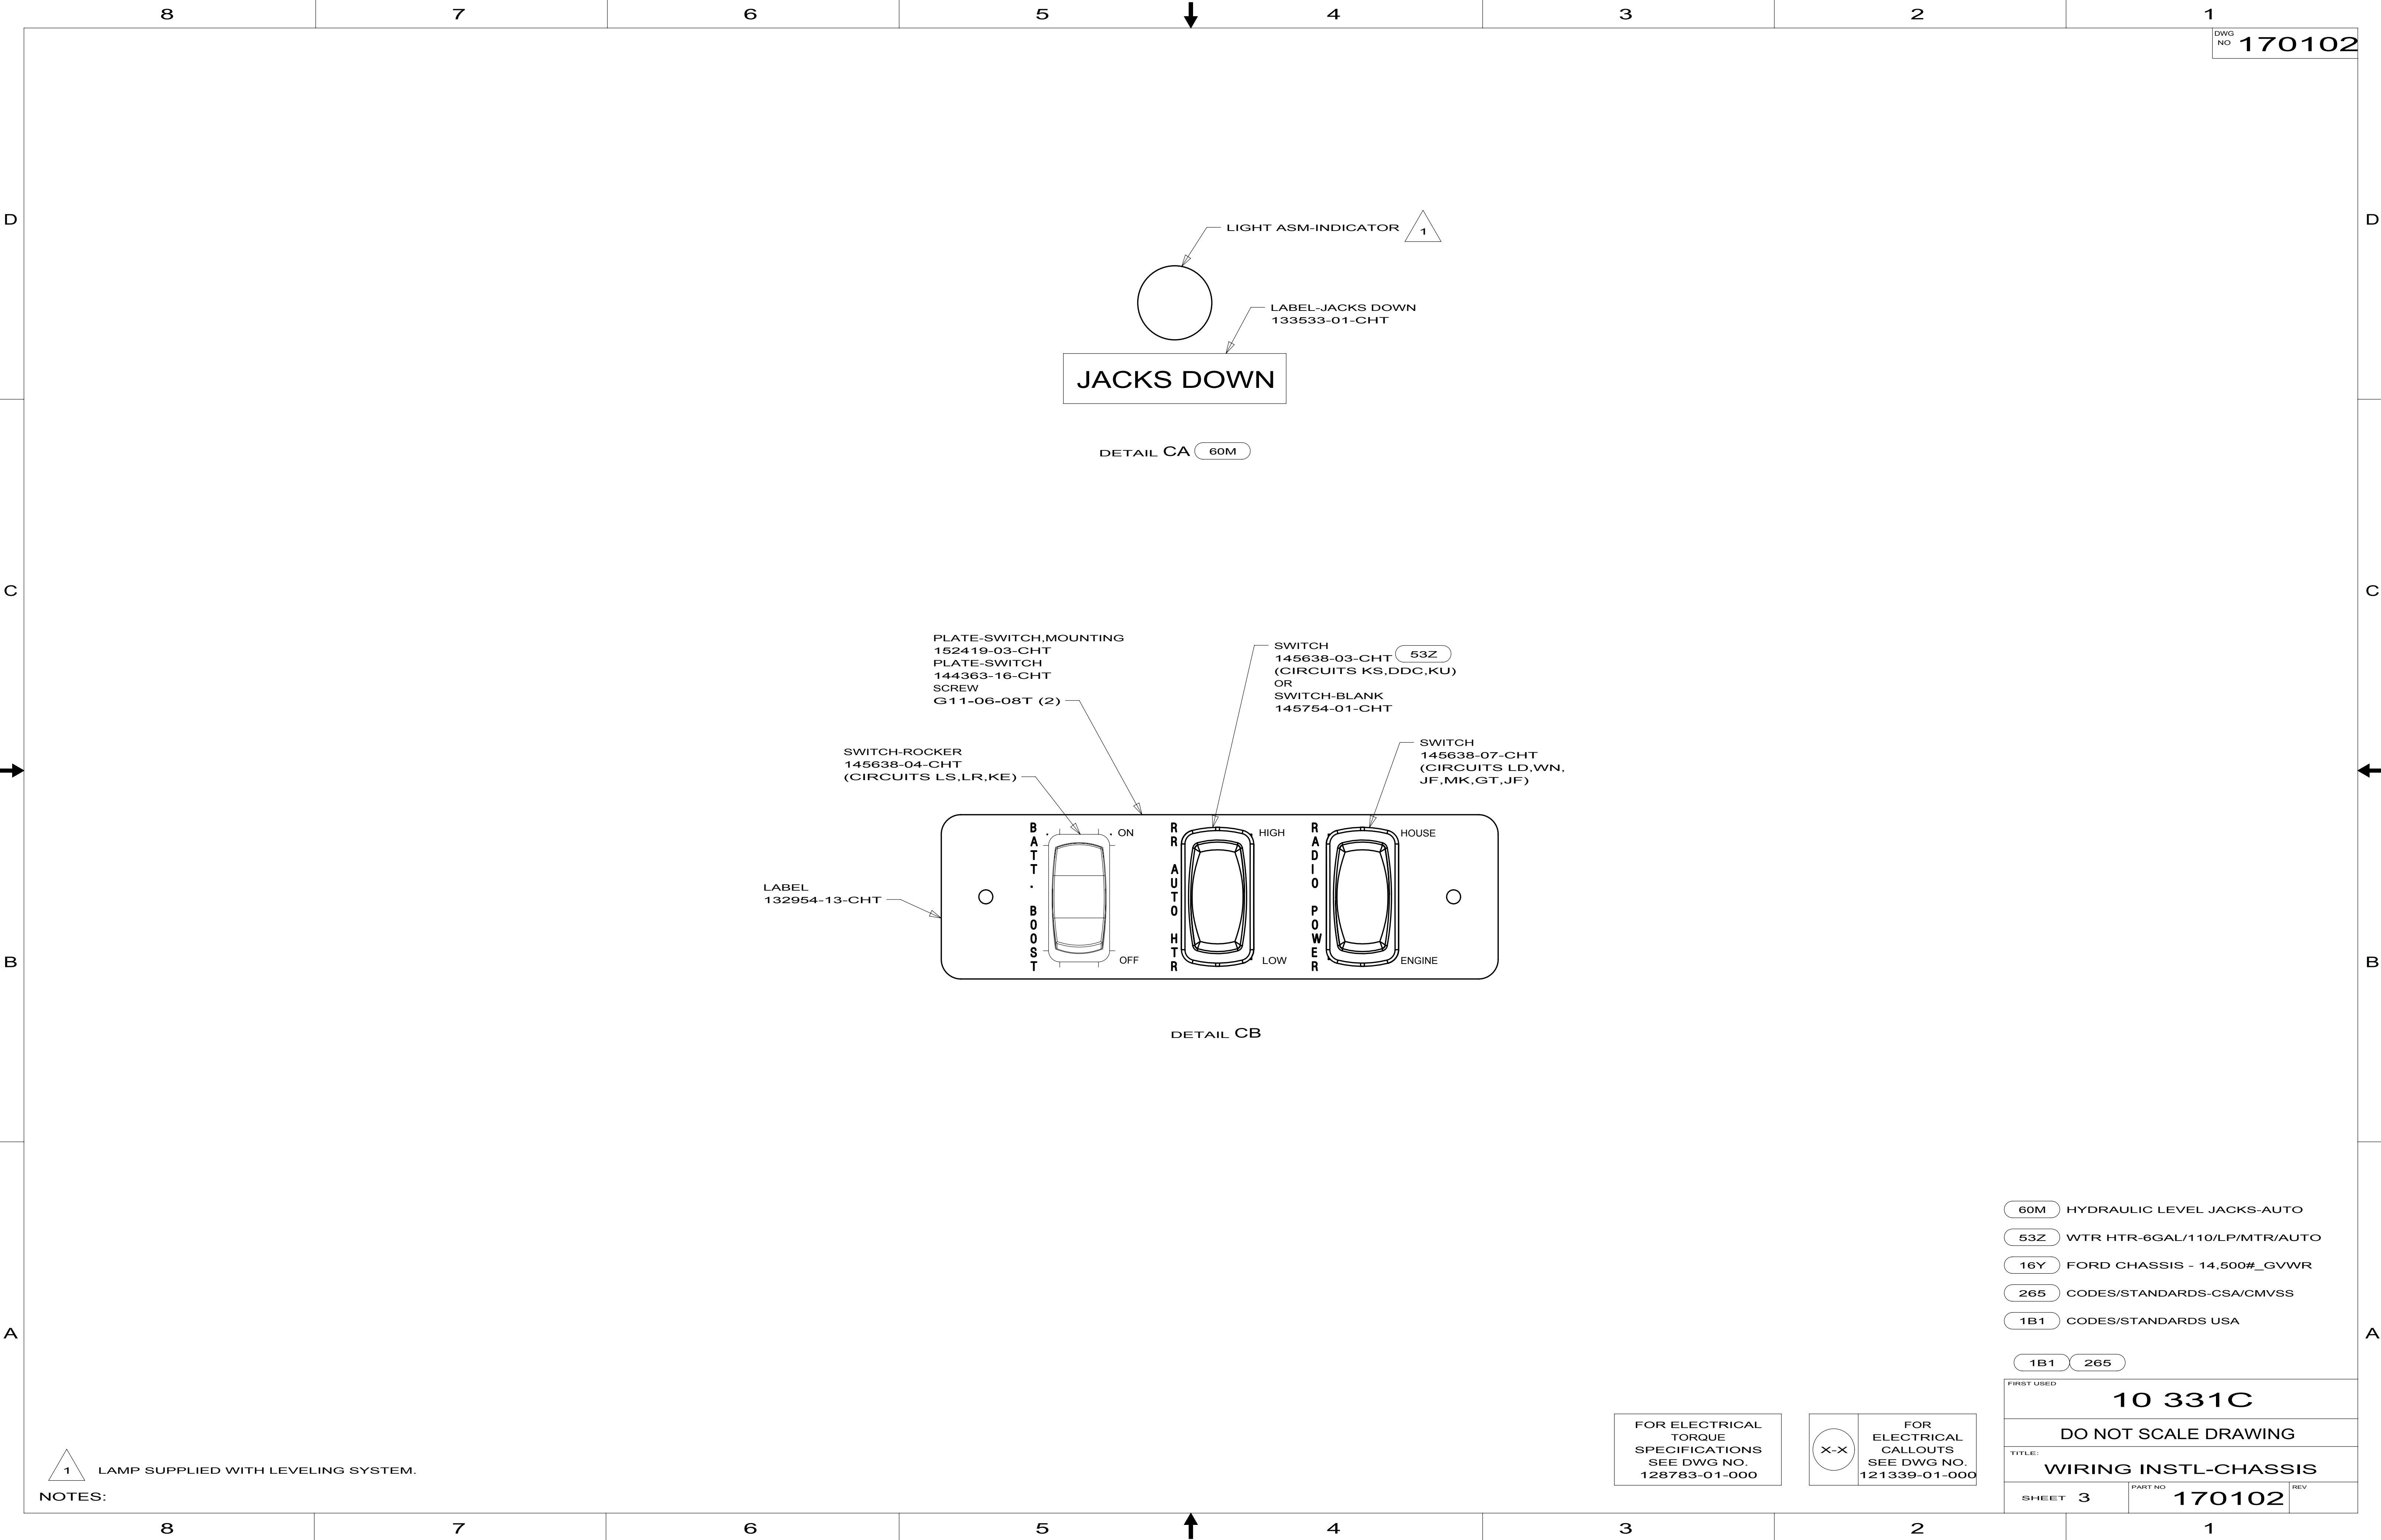

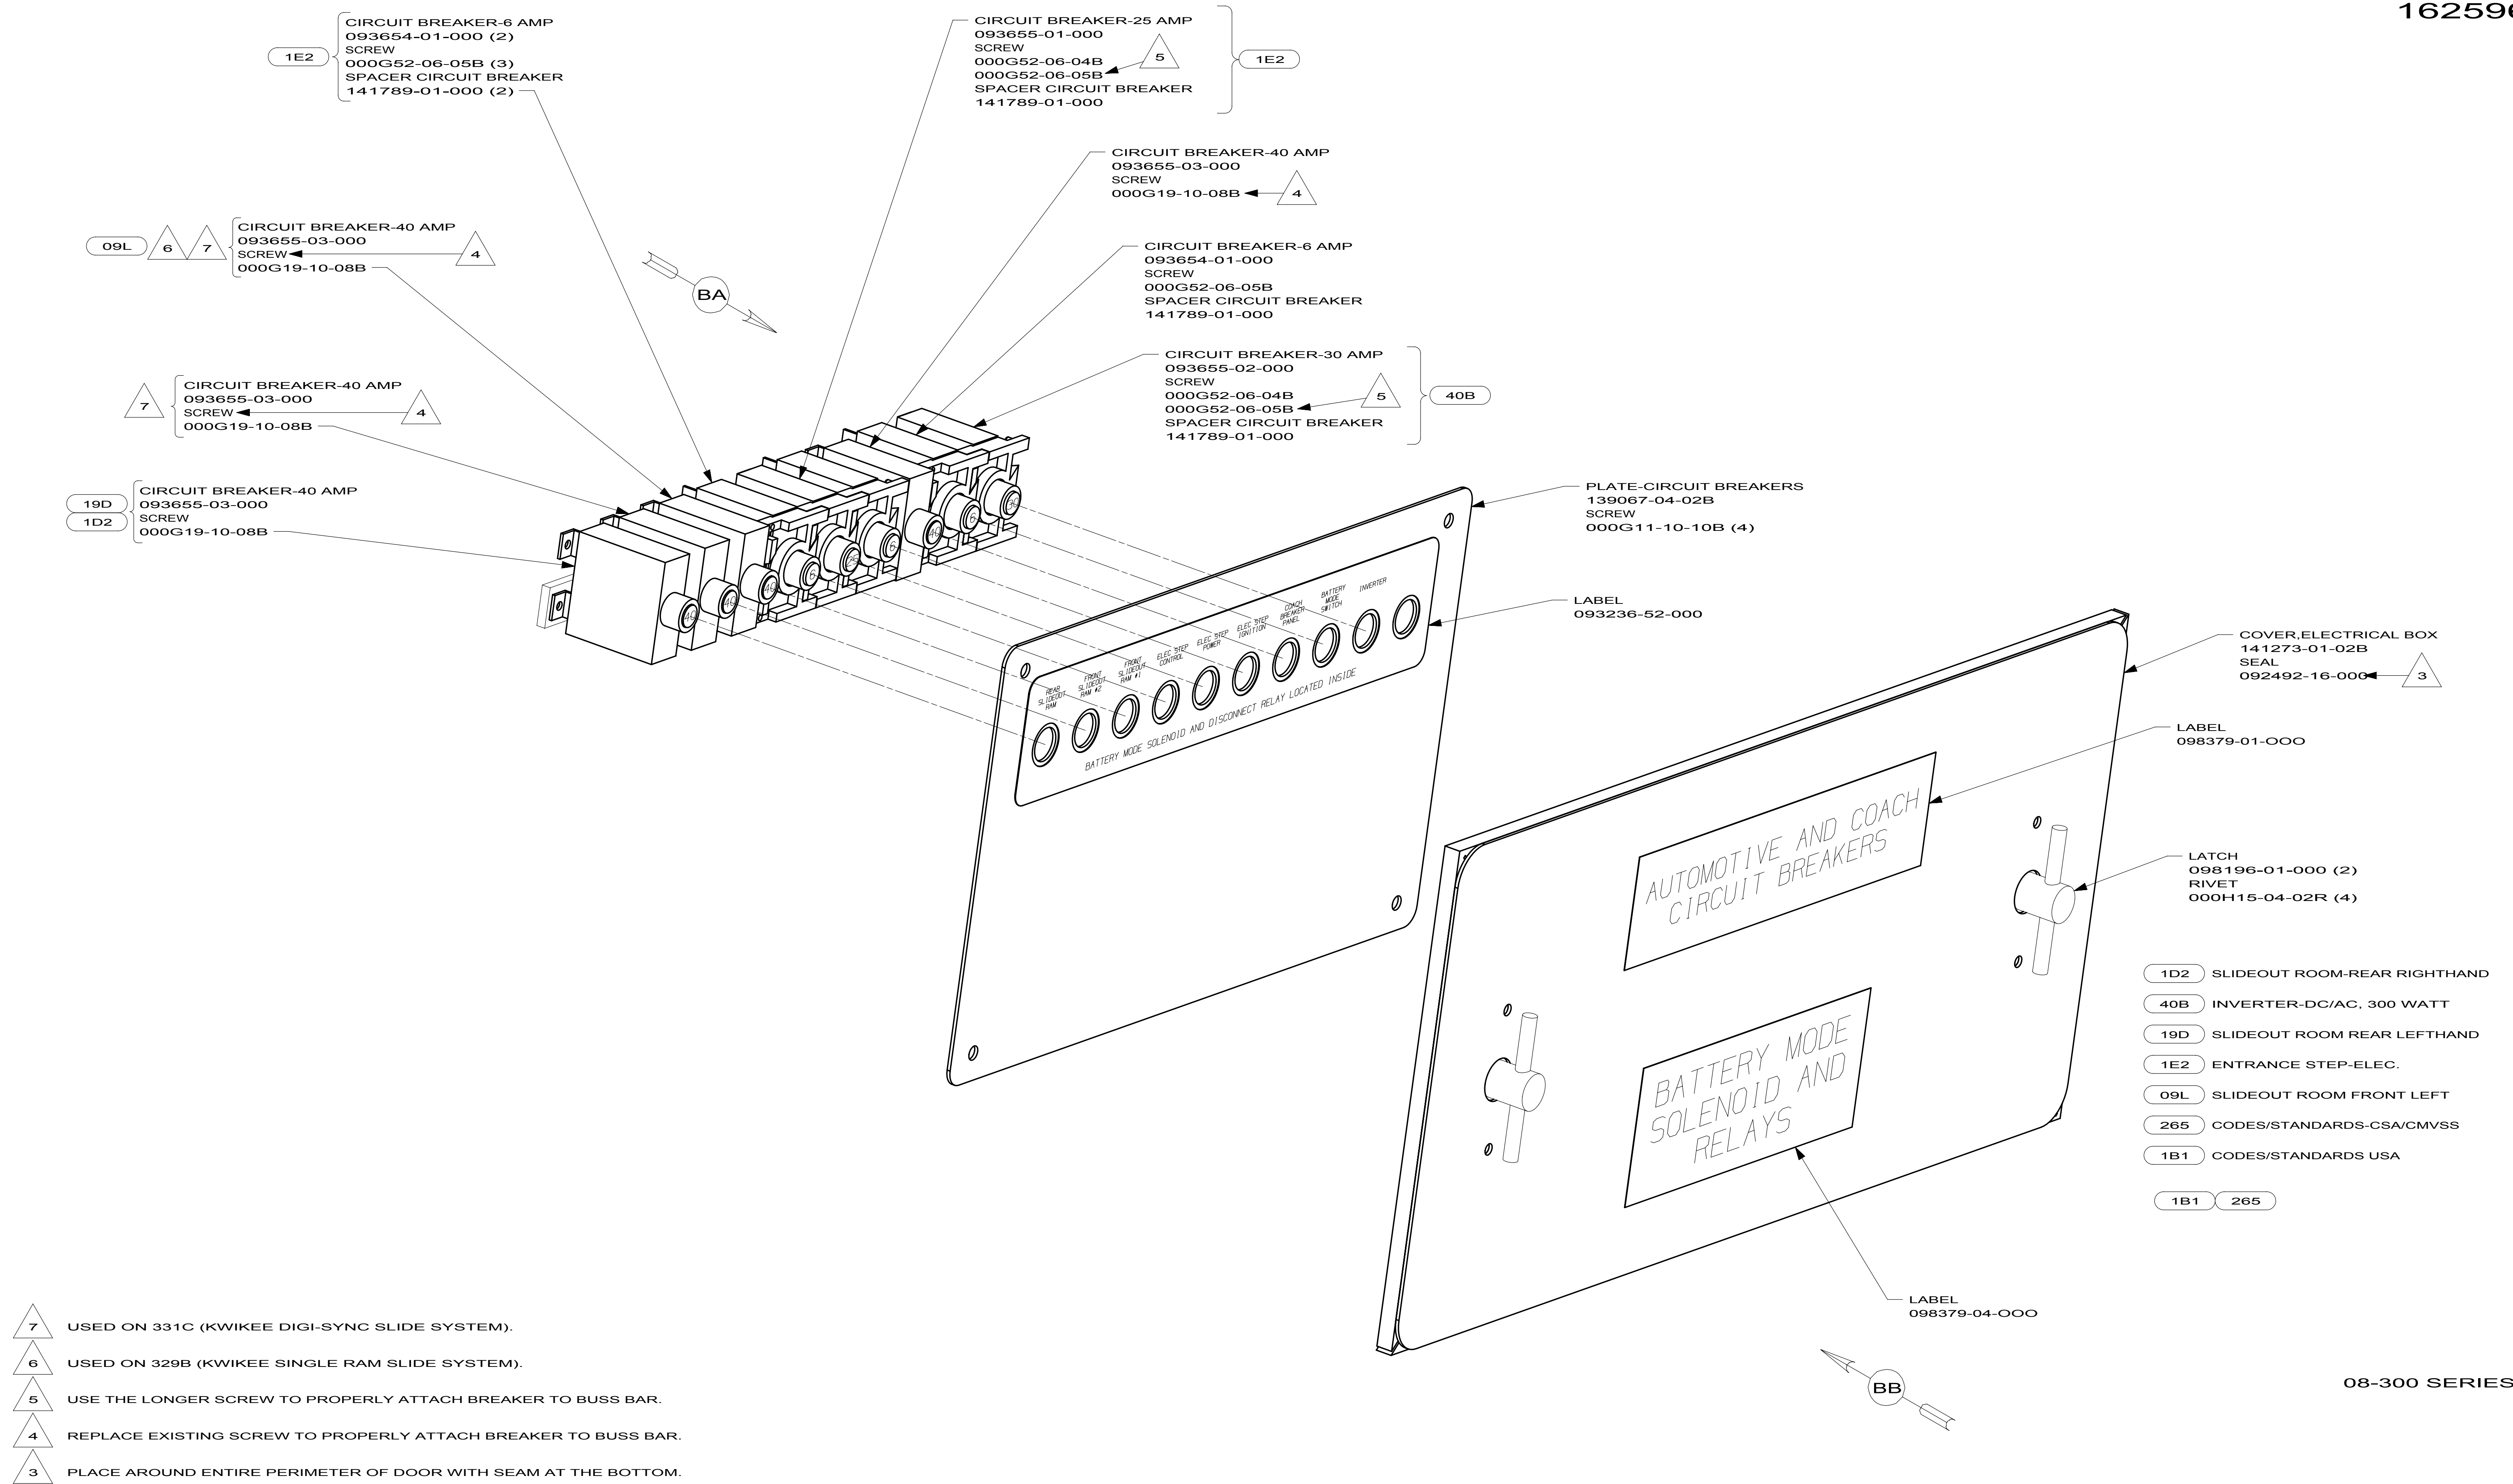

- 7 USED ON 331C (KWIKEE DIGI-SYNC SLIDE SYSTEM).
- 6 USED ON 329B (KWIKEE SINGLE RAM SLIDE SYSTEM).
- 5 USE THE LONGER SCREW TO PROPERLY ATTACH BREAKER TO BUSS BAR.
- 4 REPLACE EXISTING SCREW TO PROPERLY ATTACH BREAKER TO BUSS BAR.
- 3 PLACE AROUND ENTIRE PERIMETER OF DOOR WITH SEAM AT THE BOTTOM.



2. SECURE CONDUIT 041953, TAB AS REQUIRED, OVER ALL WIRES IN CONTACT WITH SHARP EDGES.
1. SPACER NOT REQUIRED ON 40 AMP BREAKER.

NOTES:

FOR ELECTRICAL TORQUE SPECIFICATIONS SEE DWG NO. 128783-01-000

X-X

FOR ELECTRICAL CALLOUTS SEE DWG NO. 121339-01-000

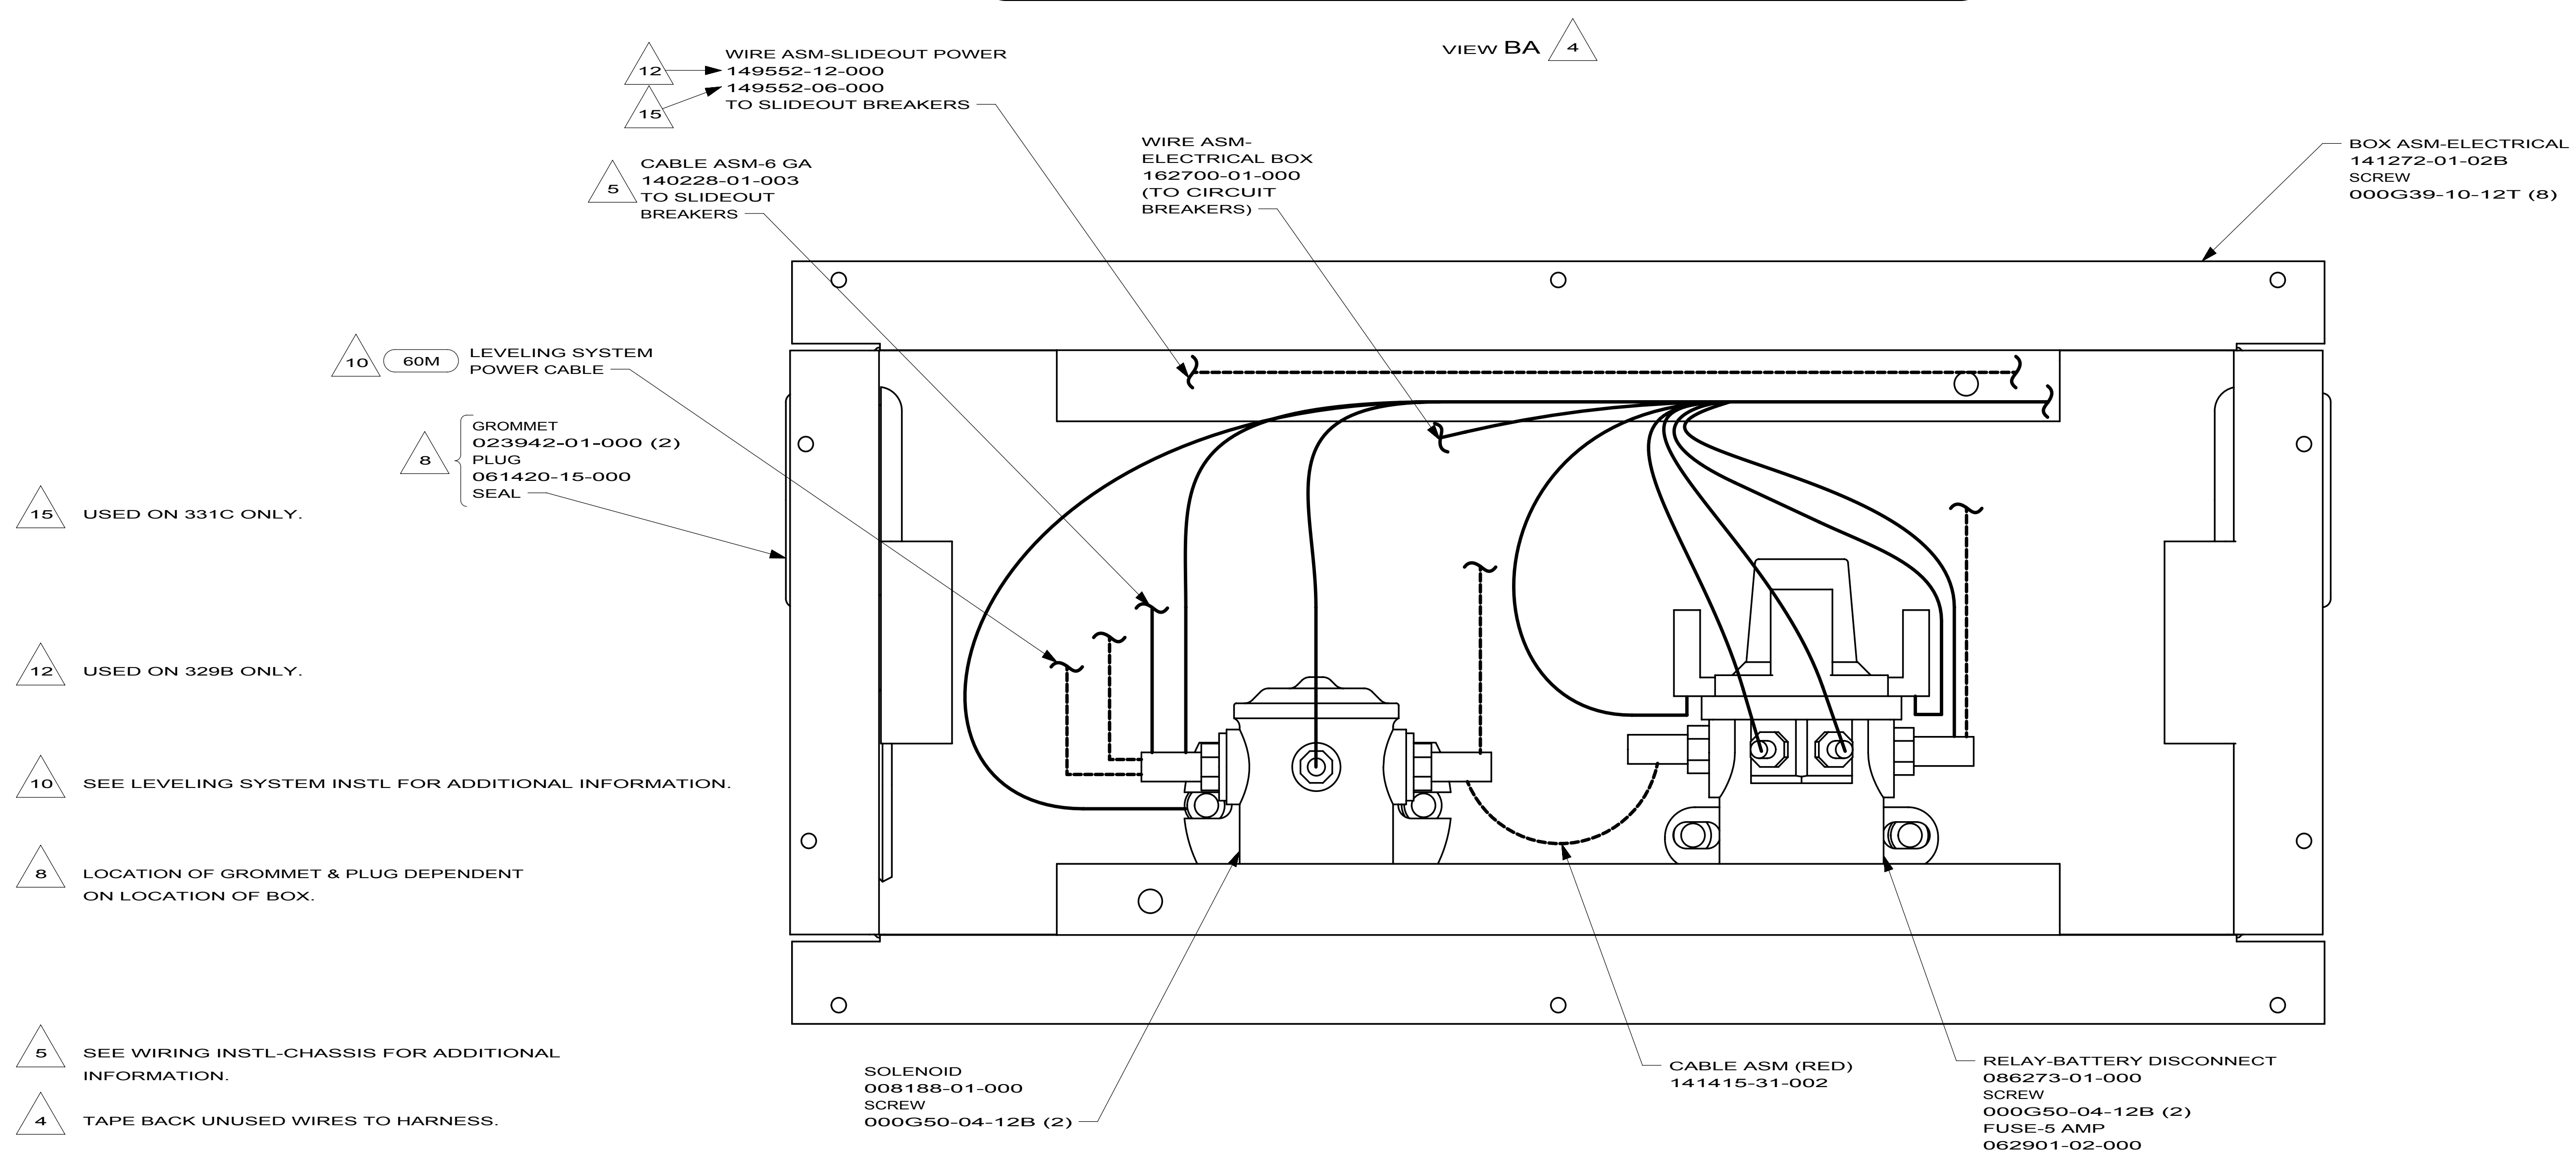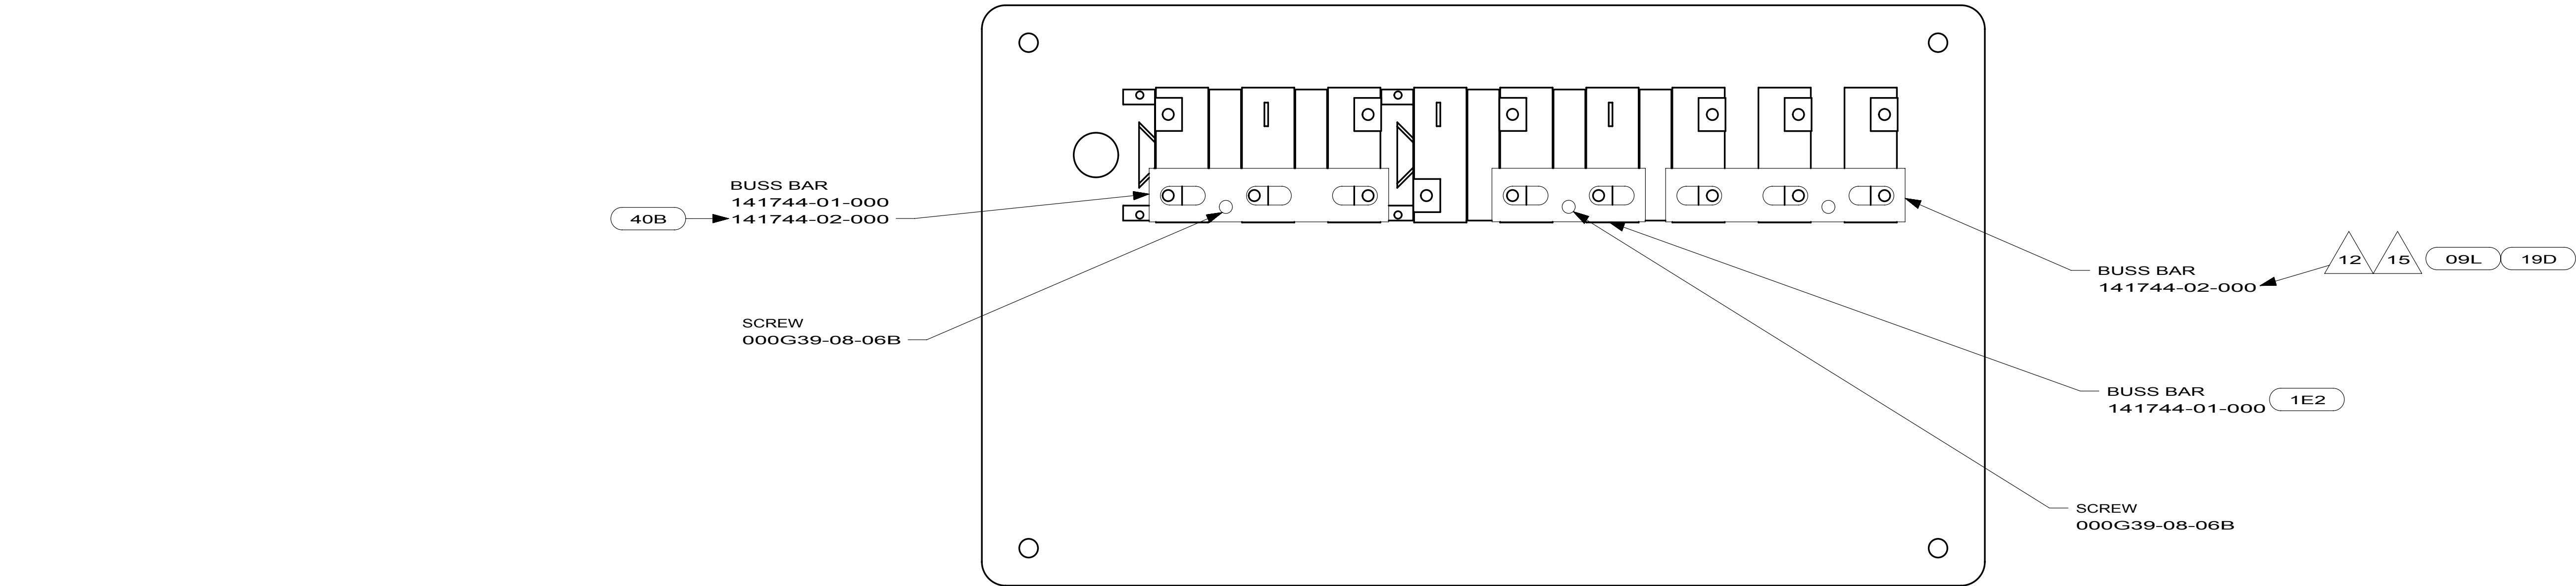

15 USED ON 331C ONLY.

12 USED ON 329B ONLY.

10 SEE LEVELING SYSTEM INSTL FOR ADDITIONAL INFORMATION.

8 LOCATION OF GROMMET & PLUG DEPENDENT ON LOCATION OF BOX.

5 SEE WIRING INSTL-CHASSIS FOR ADDITIONAL INFORMATION.

4 TAPE BACK UNUSED WIRES TO HARNESS.

60M HYDRAULIC LEVEL JACKS-AUTO

40B INVERTER-DC/AC, 300 WATT

19D SLIDEOUT ROOM REAR LEFTHAND

1E2 ENTRANCE STEP-ELEC.

09L SLIDEOUT ROOM FRONT LEFT

265 CODES/STANDARDS-CSA/CMVSS

1B1 CODES/STANDARDS USA

1B1 265

08-300 SERIES

CHASSIS ELECTRICAL BOX ASM


1. LEGEND: — WINNEBAGO; - - - - - CABLE; - - - - - CHASSIS SUPPLIED WIRING.

NOTES:


FOR ELECTRICAL
TORQUE
SPECIFICATIONS
SEE DWG NO.
128783-01-000

FOR
ELECTRICAL
CALLOUTS
SEE DWG NO.
121339-01-000

[illegible]

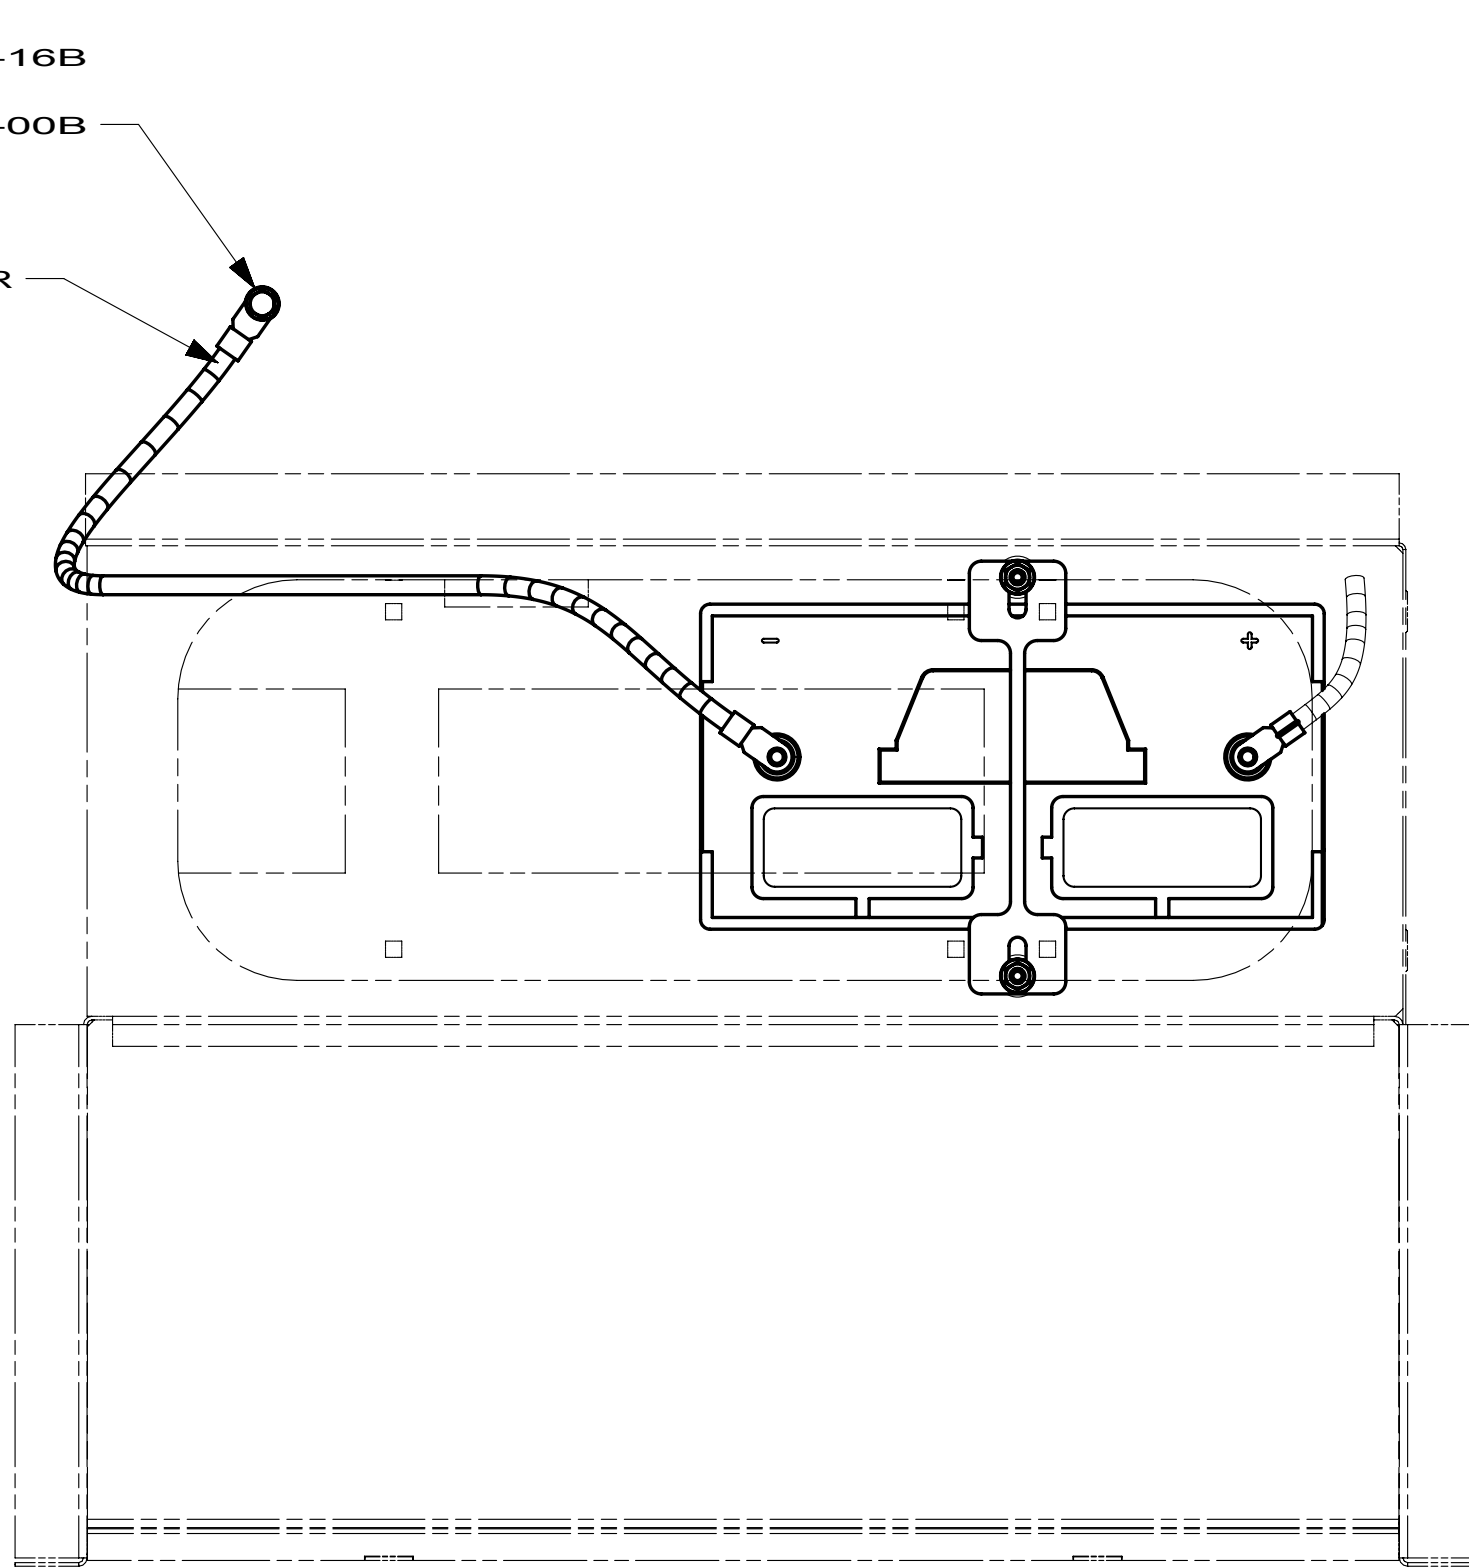

VIEW BA

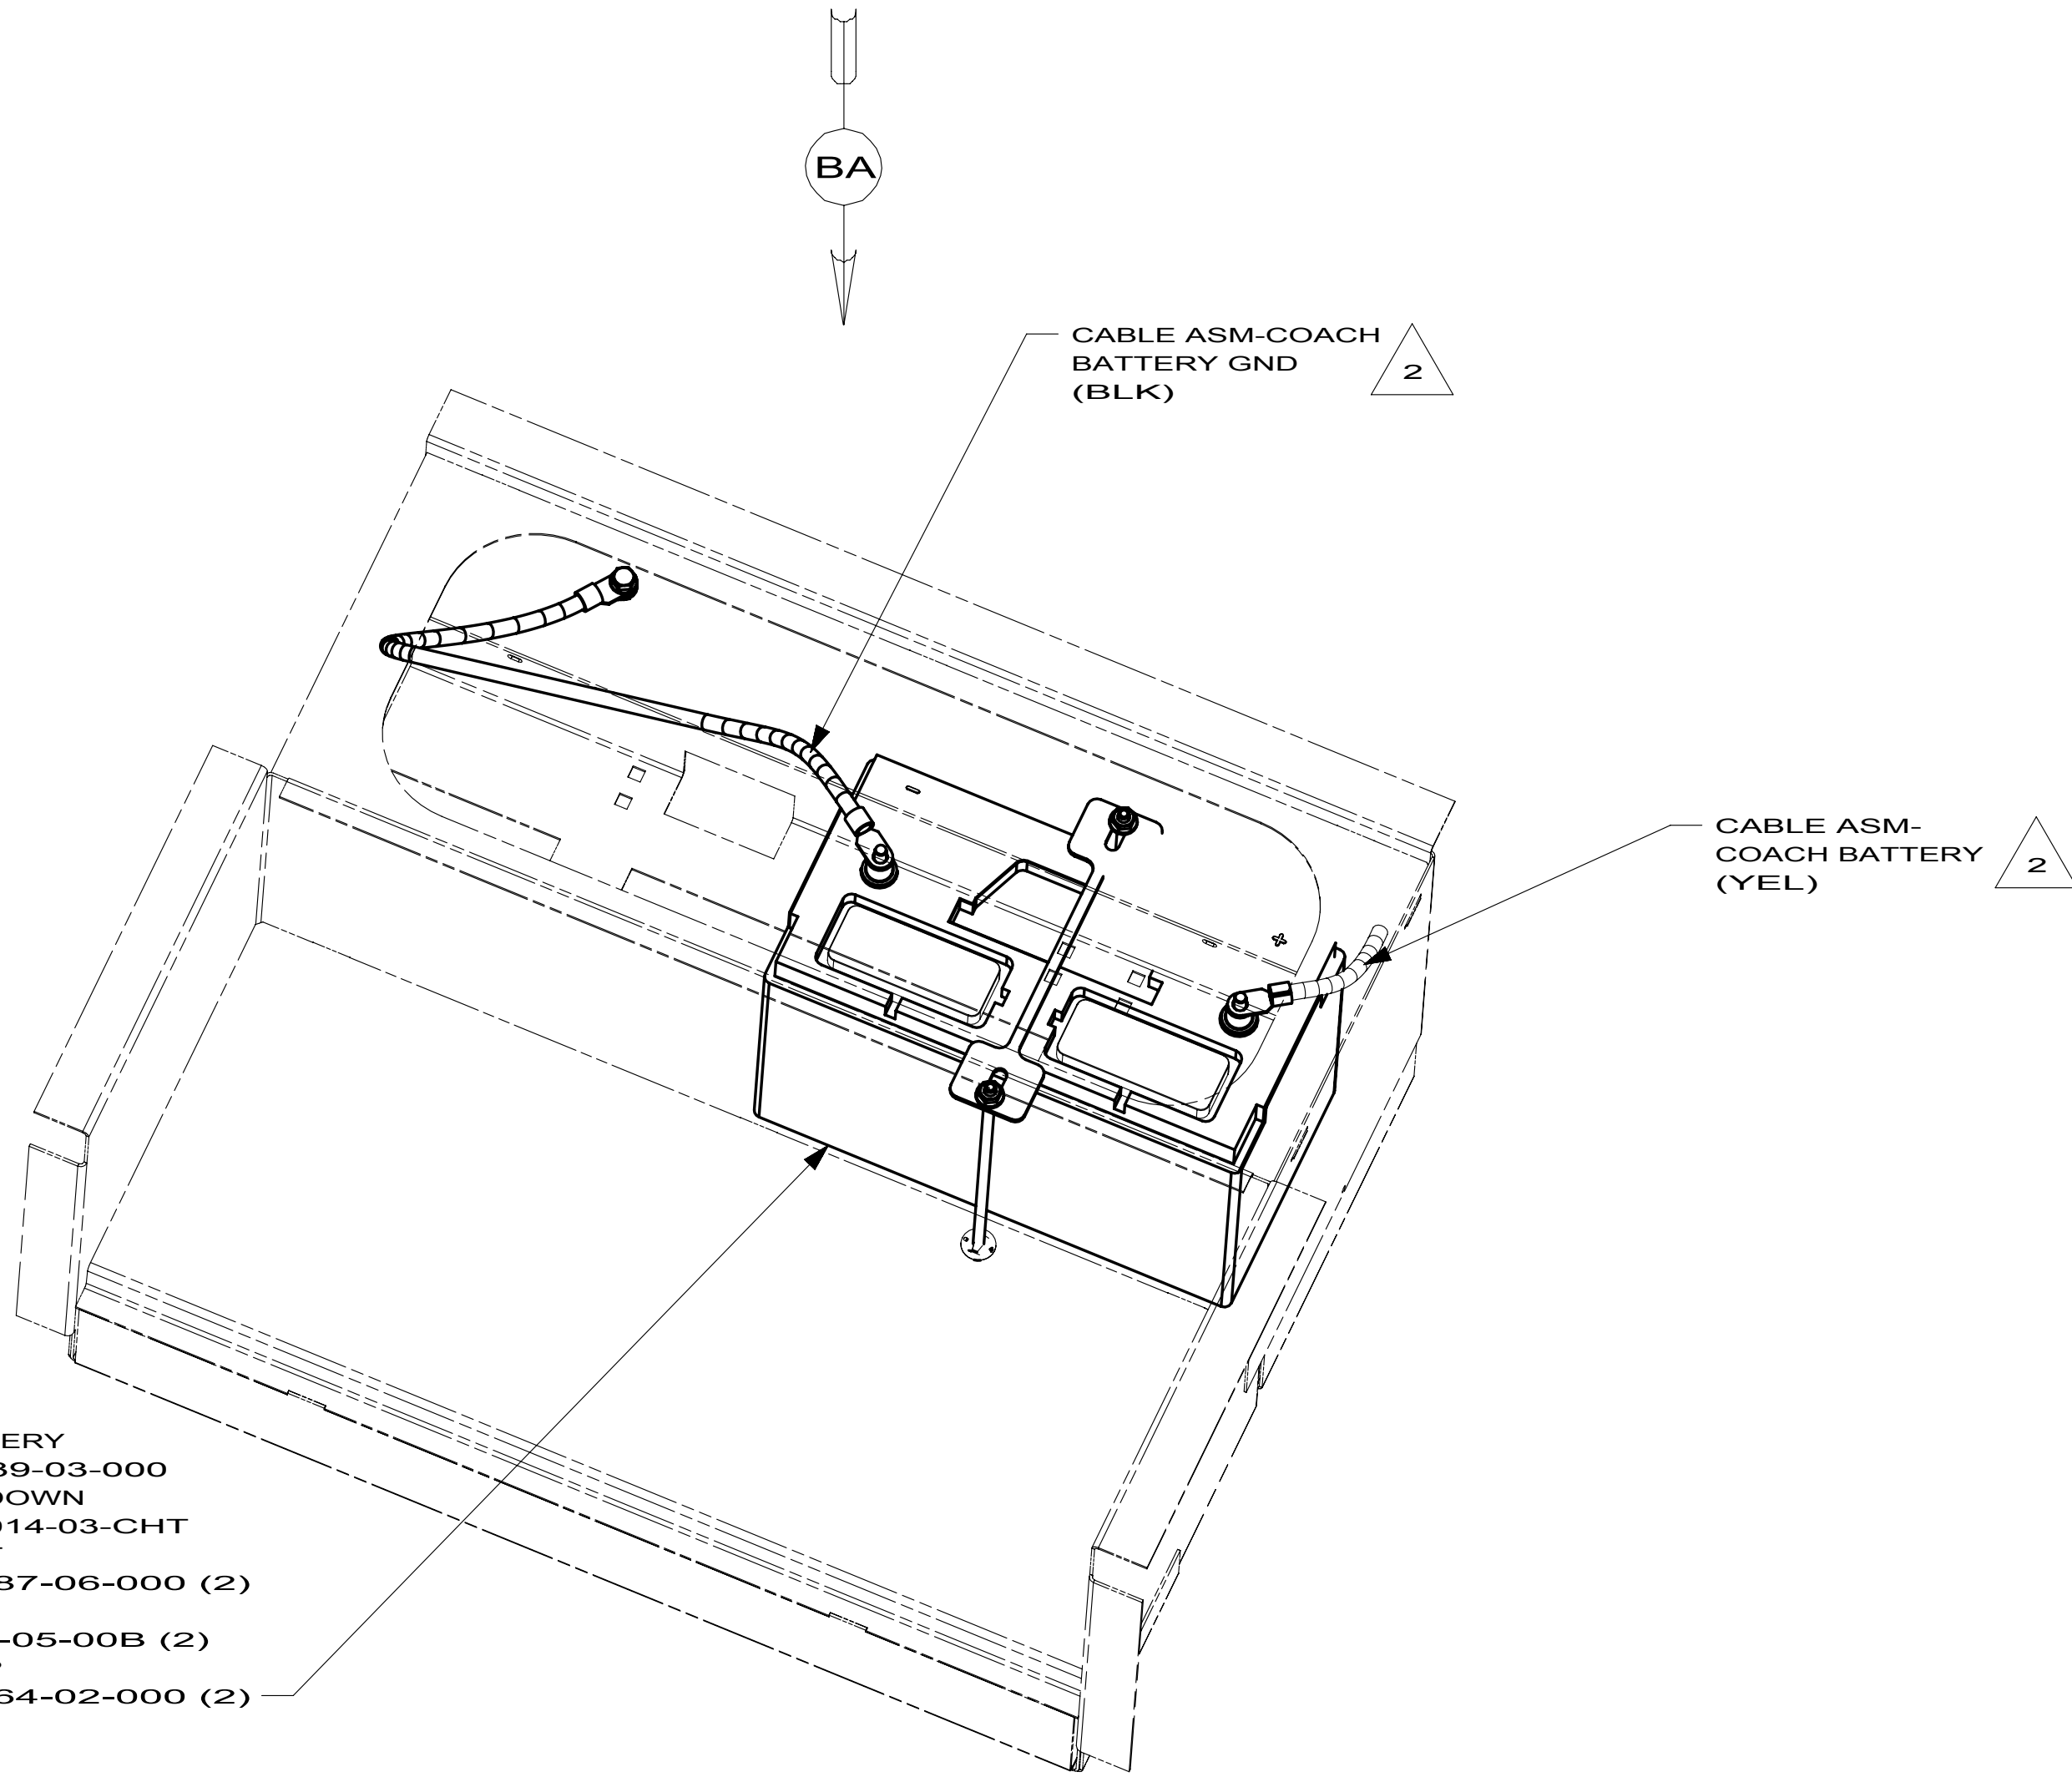

BATTERY BOX

2 BATTERY CABLES ARE NOT TO BE ROUTED OVER BATTERY FILL CAPS.

1. SEE WIRING INSTL-CHASSIS FOR ADDITIONAL INFORMATION.

NOTES:

FOR ELECTRICAL
TORQUE
SPECIFICATIONS
SEE DWG NO.
128783-01-000

FOR ELECTRICAL
CALLOUTS
SEE DWG NO.
121339-01-000

12X BATTERY-ONE

265 CODES/STANDARDS-CSA/CMVSS

1B1 CODES/STANDARDS USA


 
1B1 265 12X

FIRST USED 09 200/300/700 SER


DO NOT SCALE DRAWING

TITLE: BATTERY INSTL

SHEET 2 PART NO 165490 REV

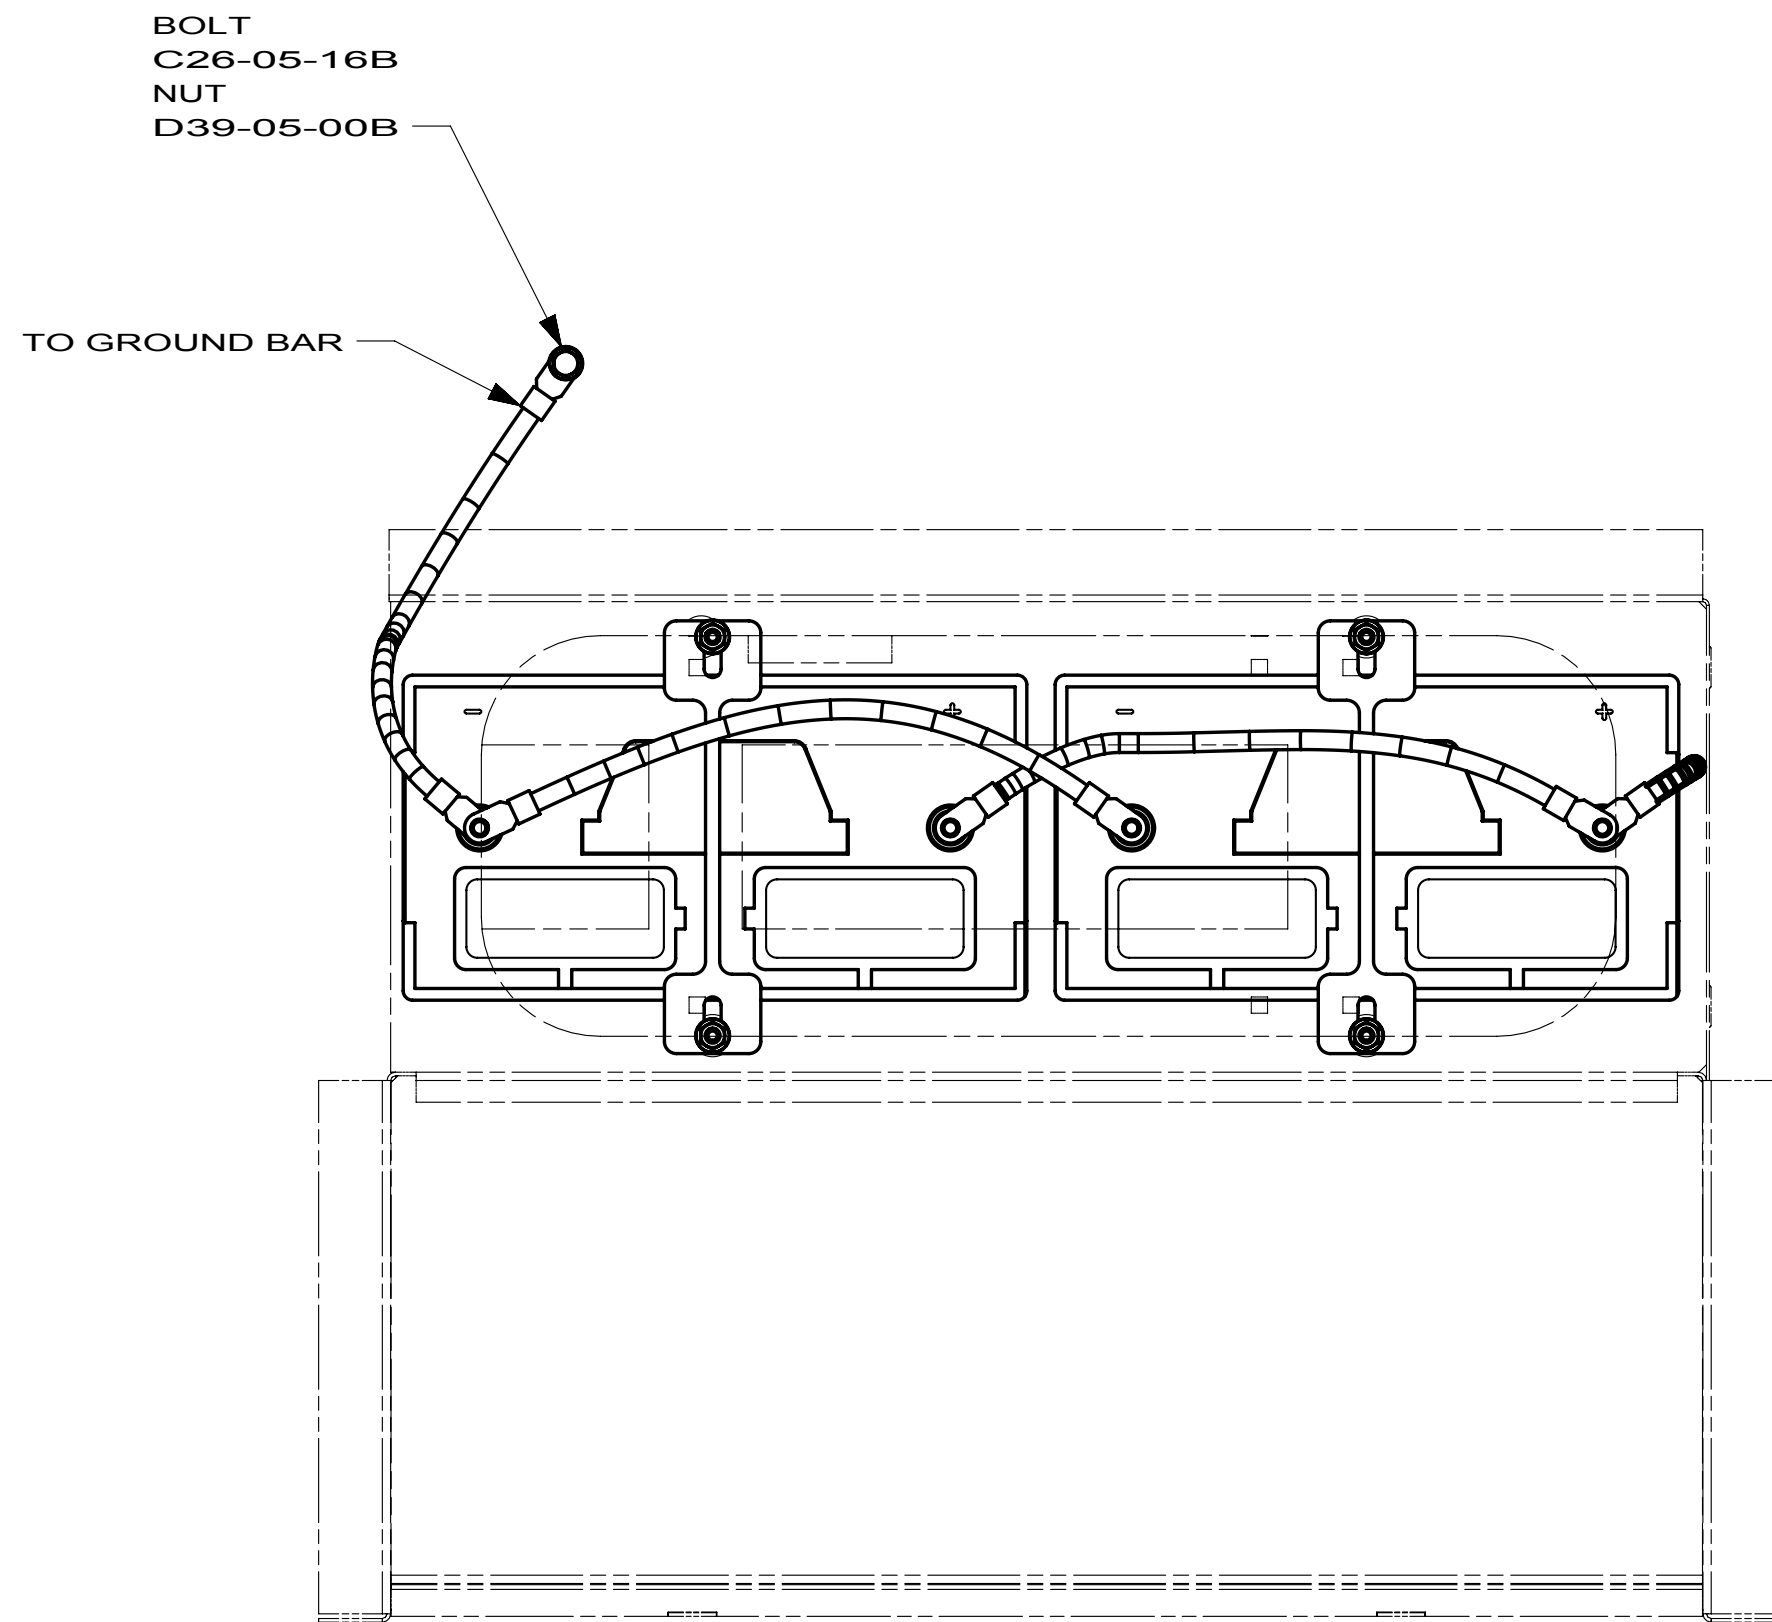

VIEW CA

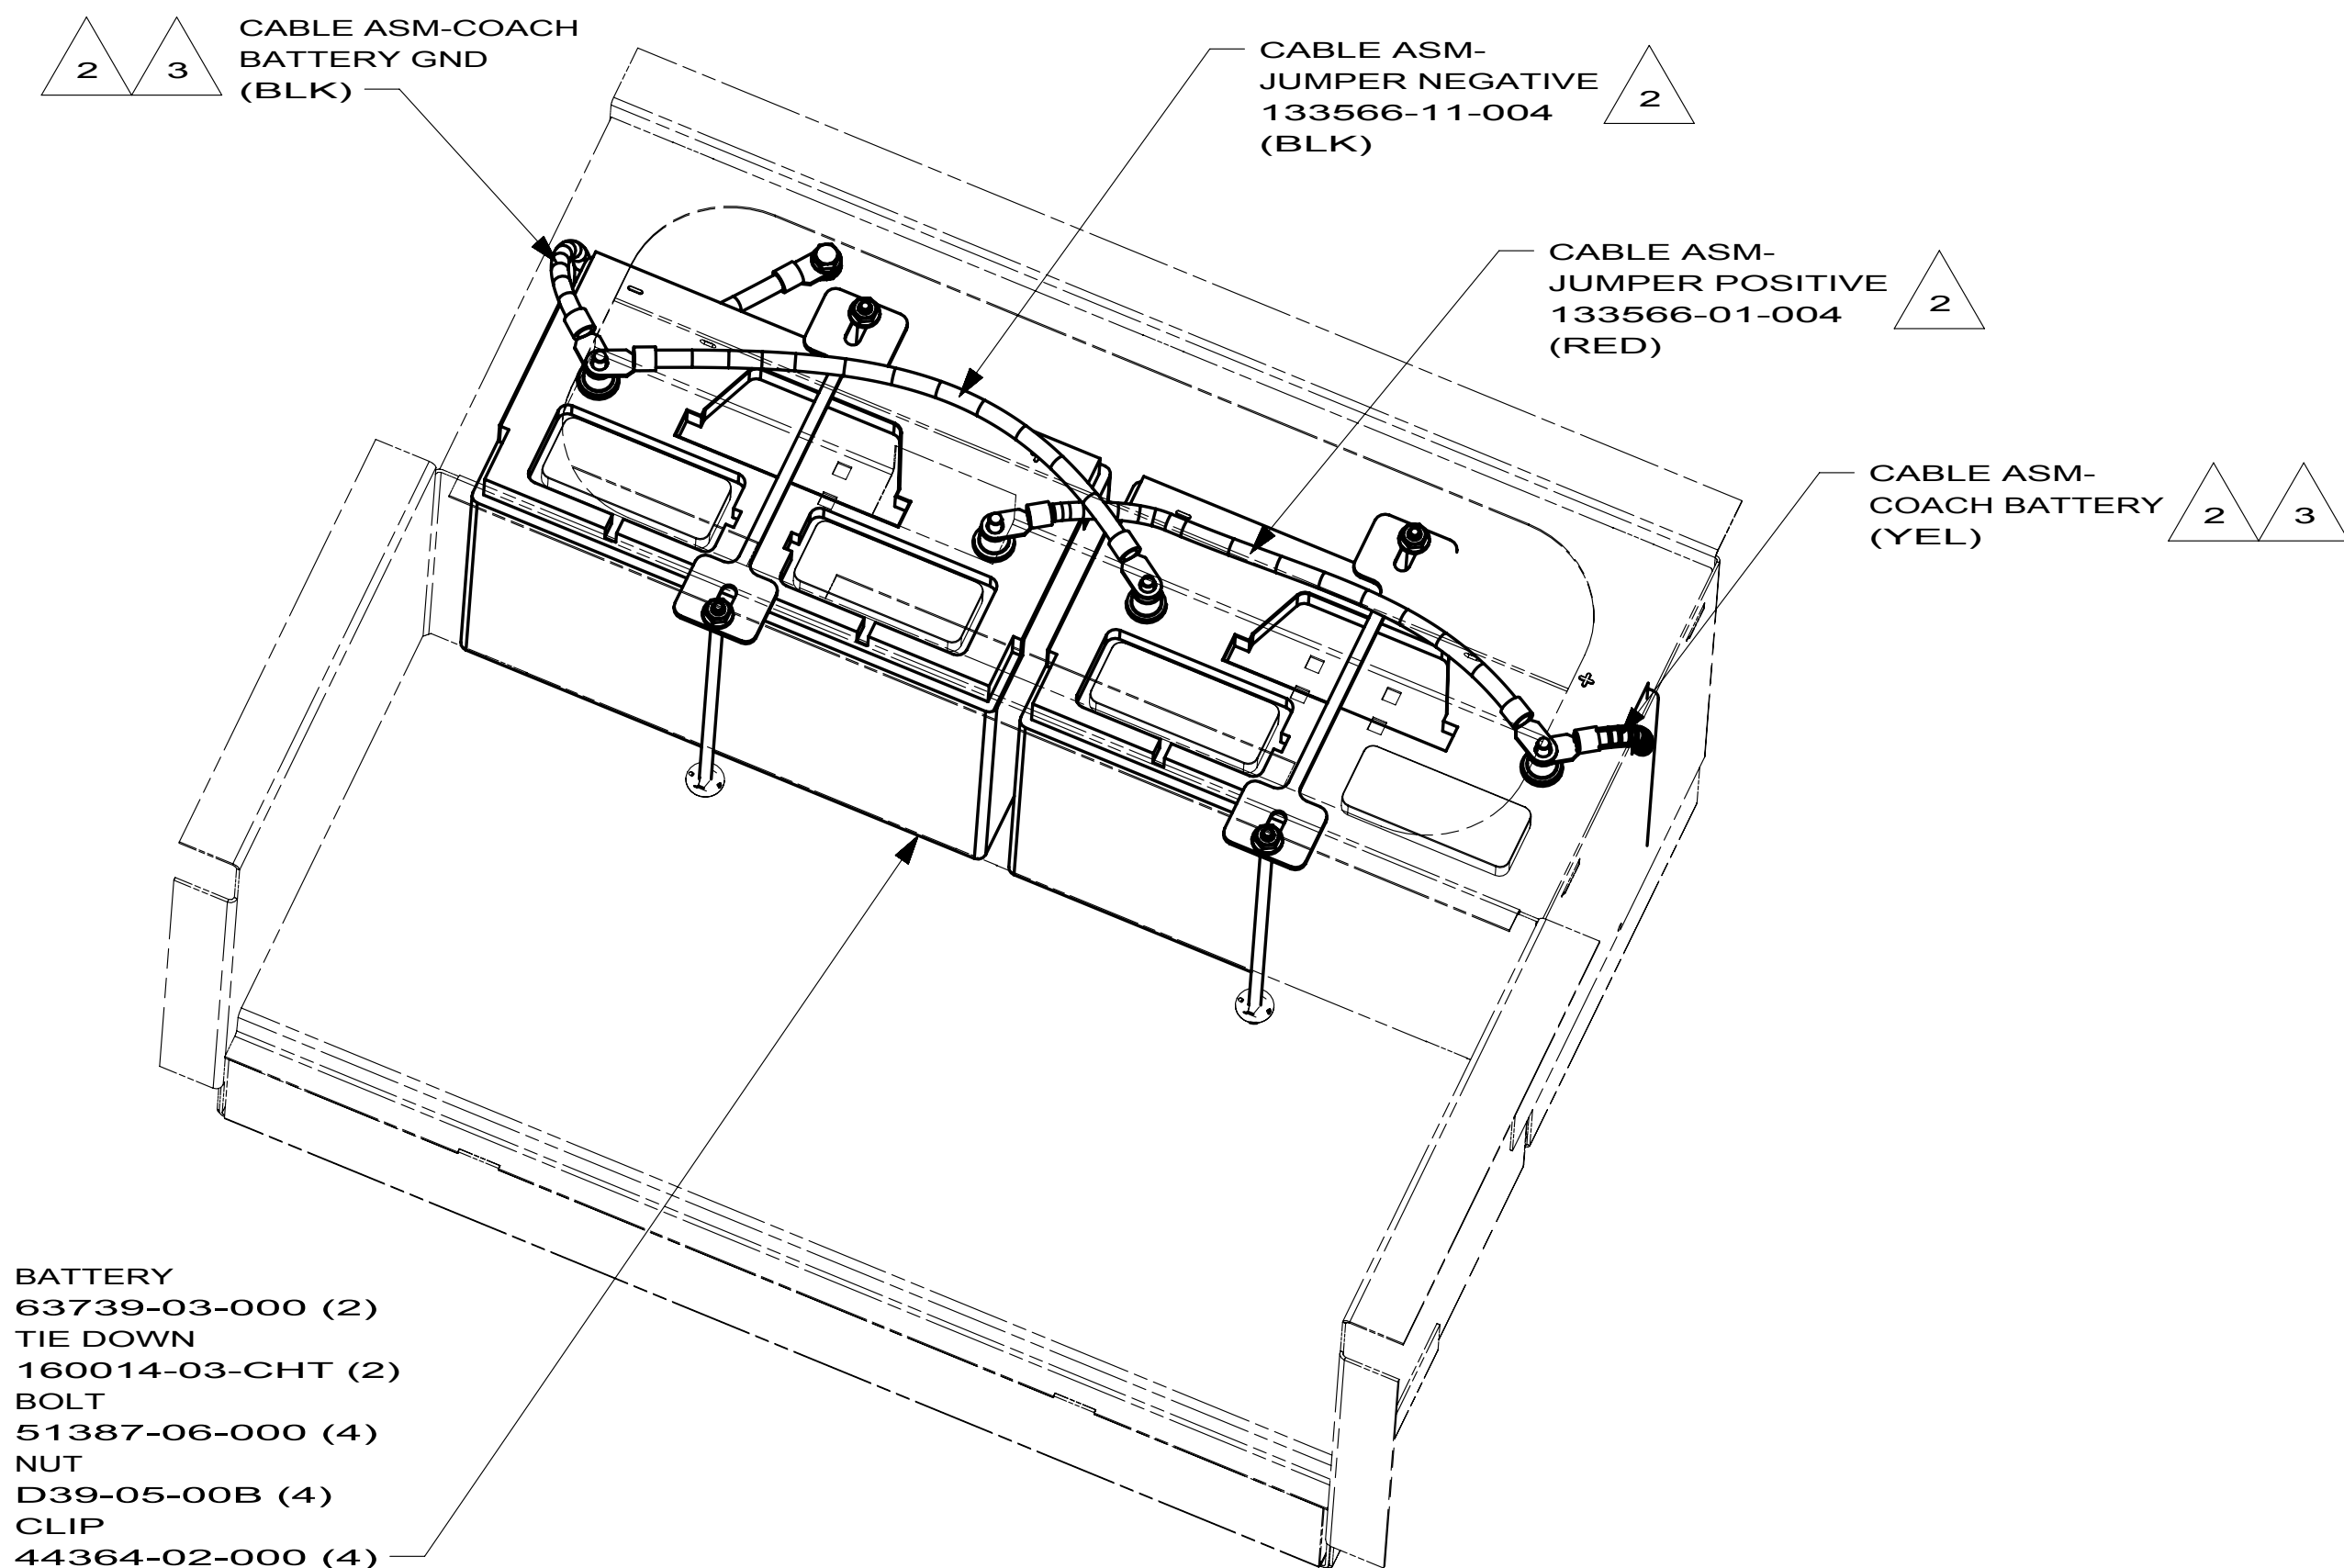

BATTERY BOX

- 3 THE POSITIVE AND NEGATIVE BATTERY CABLES ARE TO BE TERMINATED ON OPPOSITE BATTERIES.
- 2 BATTERY CABLES ARE NOT TO BE ROUTED OVER BATTERY FILL CAPS.

NOTES:

1. SEE WIRING INSTL-CHASSIS FOR ADDITIONAL INFORMATION.

22W BATTERY-SECOND

265 CODES/STANDARDS-CSA/CMVSS

1B1 CODES/STANDARDS USA

1B1 265 22W

FIRST USED		
09 200/300/700 SER		
DO NOT SCALE DRAWING		
TITLE: BATTERY INSTL		
SHEET 3	PART NO 165490	REV

FOR ELECTRICAL
TORQUE
SPECIFICATIONS
SEE DWG NO.
128783-01-000

FOR ELECTRICAL
CALLOUTS
SEE DWG NO.
121339-01-000

8			7			6			5			4			3			2			1		
DRAWING NO.		FEATURES		SHEETS																			
170020-01		12X		1,2																			
170020-02		22W		1,3																			
						224V		229T		231C		231J		231N									
CABLE ASM-STARTER (RED)				16B 16C 16Y		141415-34-048		141415-34-048		141415-34-053		141415-34-052		141415-34-068									
CABLE ASM-COACH BATTERY (YEL)				16B 16C 16Y		141415-52-012		141415-52-021		141415-52-016		141415-52-018		141415-52-024									
CABLE ASM-COACH BATTERY GND (BLK)				16B 16C 16Y		133566-12-008		133566-12-009		133566-12-008		133566-12-008		133566-12-008									
CABLE ASM-GENERATOR (GRN)				16B 16C 16Y		141415-42-032		141415-42-065		141415-42-068		141415-42-028		141415-42-050									
CABLE ASM-GENERATOR GND (BLK)				16B 16C 16Y		133566-11-008		133566-11-008		133566-11-008		133566-11-008		133566-11-008									
						329B						331C											
CABLE ASM-STARTER (RED)				16Y		141415-34-056						141415-34-052											
CABLE ASM-COACH BATTERY (YEL)				16Y		141415-52-021						141415-52-020											
CABLE ASM-COACH BATTERY GND (BLK)				16Y		133566-12-007						133566-12-006											
CABLE ASM-GENERATOR (GRN)				16Y		141415-42-044						141415-42-066											
CABLE ASM-GENERATOR GND (BLK)				16Y		133566-11-008						133566-11-008											
LEVELING SYSTEM POWER CABLE (BLU)				60M		141415-22-045						141415-22-030											
						728B		730C															
CABLE ASM-STARTER (RED)				16Y		141415-34-057		141415-34-053															
CABLE ASM-COACH BATTERY (YEL)				16Y		141415-52-020		141415-52-020															
CABLE ASM-COACH BATTERY GND (BLK)				16Y		133566-12-008		133566-12-008															
CABLE ASM-GENERATOR (GRN)				16Y		141415-42-024		141415-42-075															
CABLE ASM-GENERATOR GND (BLK)				16Y		133566-11-008		133566-11-008															
LEVELING SYSTEM POWER CABLE (BLU)				60M		141415-22-010		141415-22-011															
NOTES:																							
2 SEE LEVELING SYSTEM INSTL FOR ADDITIONAL INFORMATION.																							
1 ROUTING OF CABLES SHOWN ON WIRING INSTL-CHASSIS ONLY.																							
8			7			6			5			4			3			2			1		

RELEASE

REV

DATE

A

DWG NO

170020

REV

ZONE

REVISION RECORD

DATE

DFTR.Orig

60M

HYDRAULIC LEVEL JACKS-AUTO

644

GREAT ALASKAN RENTAL PACKAGE

22W

BATTERY-SECOND

12X

BATTERY-ONE

16Y

FORD CHASSIS - 14,500#

16C

FORD CHASSIS 11,500 LB.GVWR

16B

FORD CHASSIS 10,700 LB.GVWR

265

CODES/STANDARDS-CSA/CMVSS

1B1

CODES/STANDARDS USA

1B1

265

WINNEBAGO

INDUSTRIES

COPYRIGHT 2009

WINNEBAGO

INDUSTRIES, INC.

DFTR

CHKR

P.E.

M.E.

DSNR

ORIG. DATE

ALL DIMENSIONS ARE IN MILLIMETERS

FIRST USED

10 200/300/700 SER

UNSPECIFIED TOLERANCES ARE:

WHOLE DIM (X) ±

ONE-PLACE (X.X) ±

TWO-PLACE (X.XX) ±

ANGLE ±

MATERIAL:

THIRD ANGLE PROJECTION

DO NOT SCALE DRAWING

TITLE:

BATTERY INSTL

SHEET 1 OF 3

PART NO

170020

REV

REF:

1


FOR ELECTRICAL TORQUE SPECIFICATIONS SEE DWG NO. 128783-01-000

X-X

FOR ELECTRICAL CALLOUTS SEE DWG NO. 121339-01-000




BOLT
C26-05-16B
NUT
D39-05-00B
TO GROUND BAR

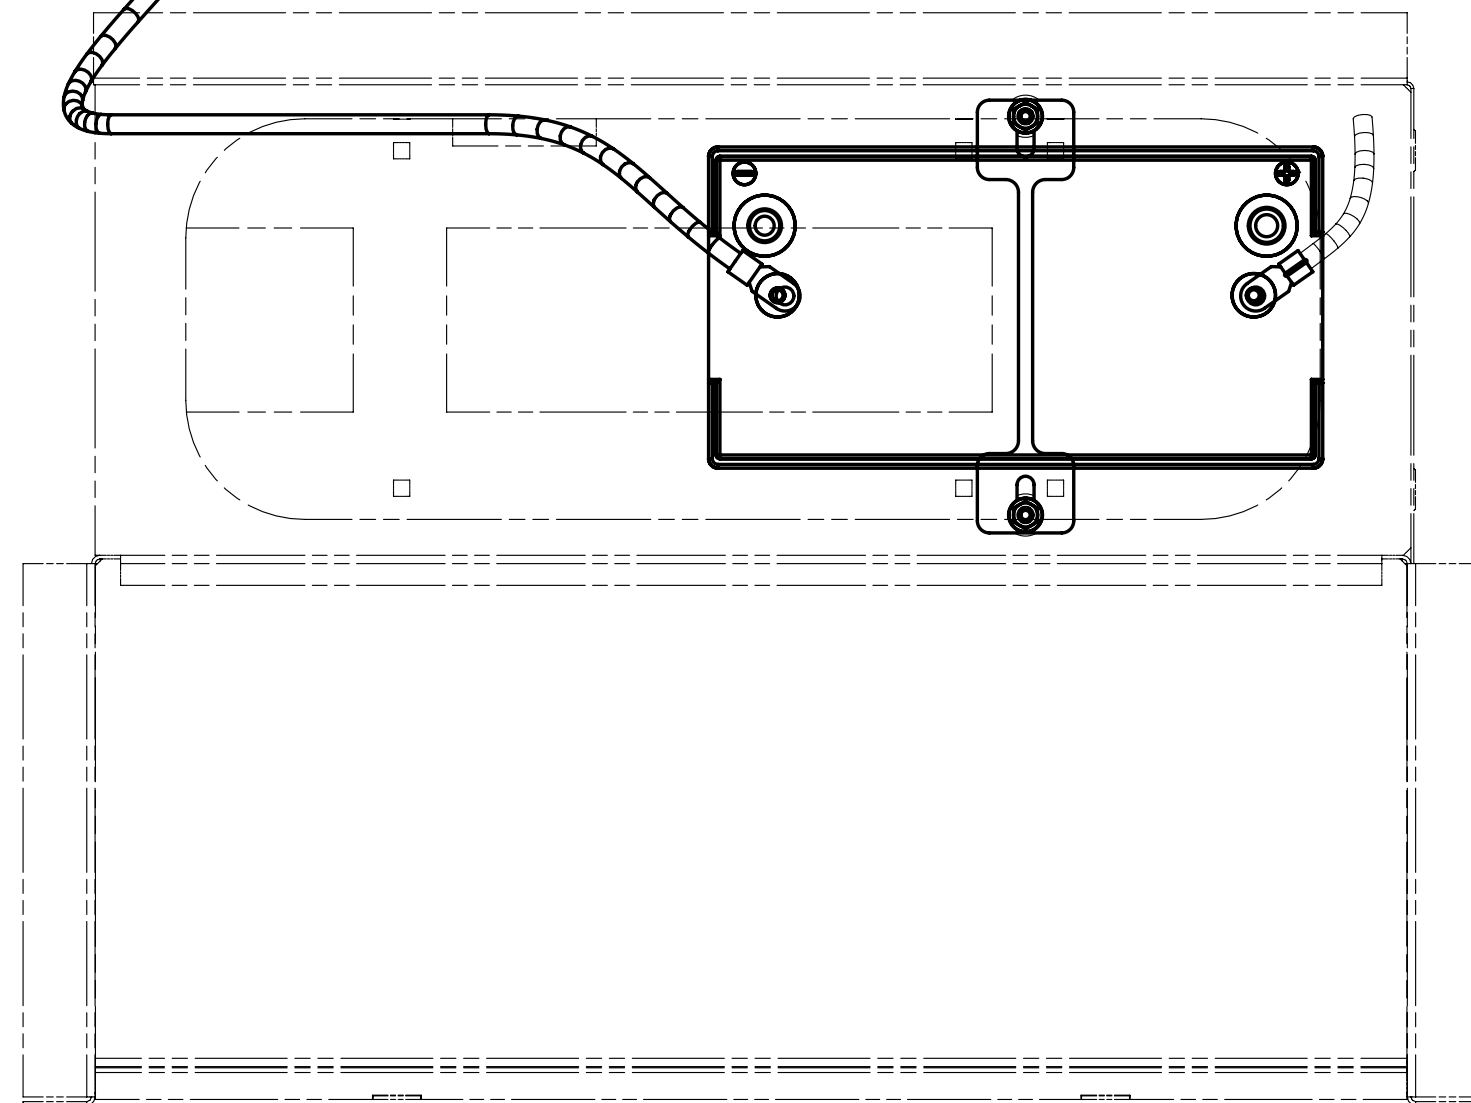

VIEW BA

BATTERY
63739-03-000
TIE DOWN
160014-03-CHT
BOLT
51387-06-000 (2)
NUT
D39-05-00B (2)
CLIP
44364-02-000 (2)

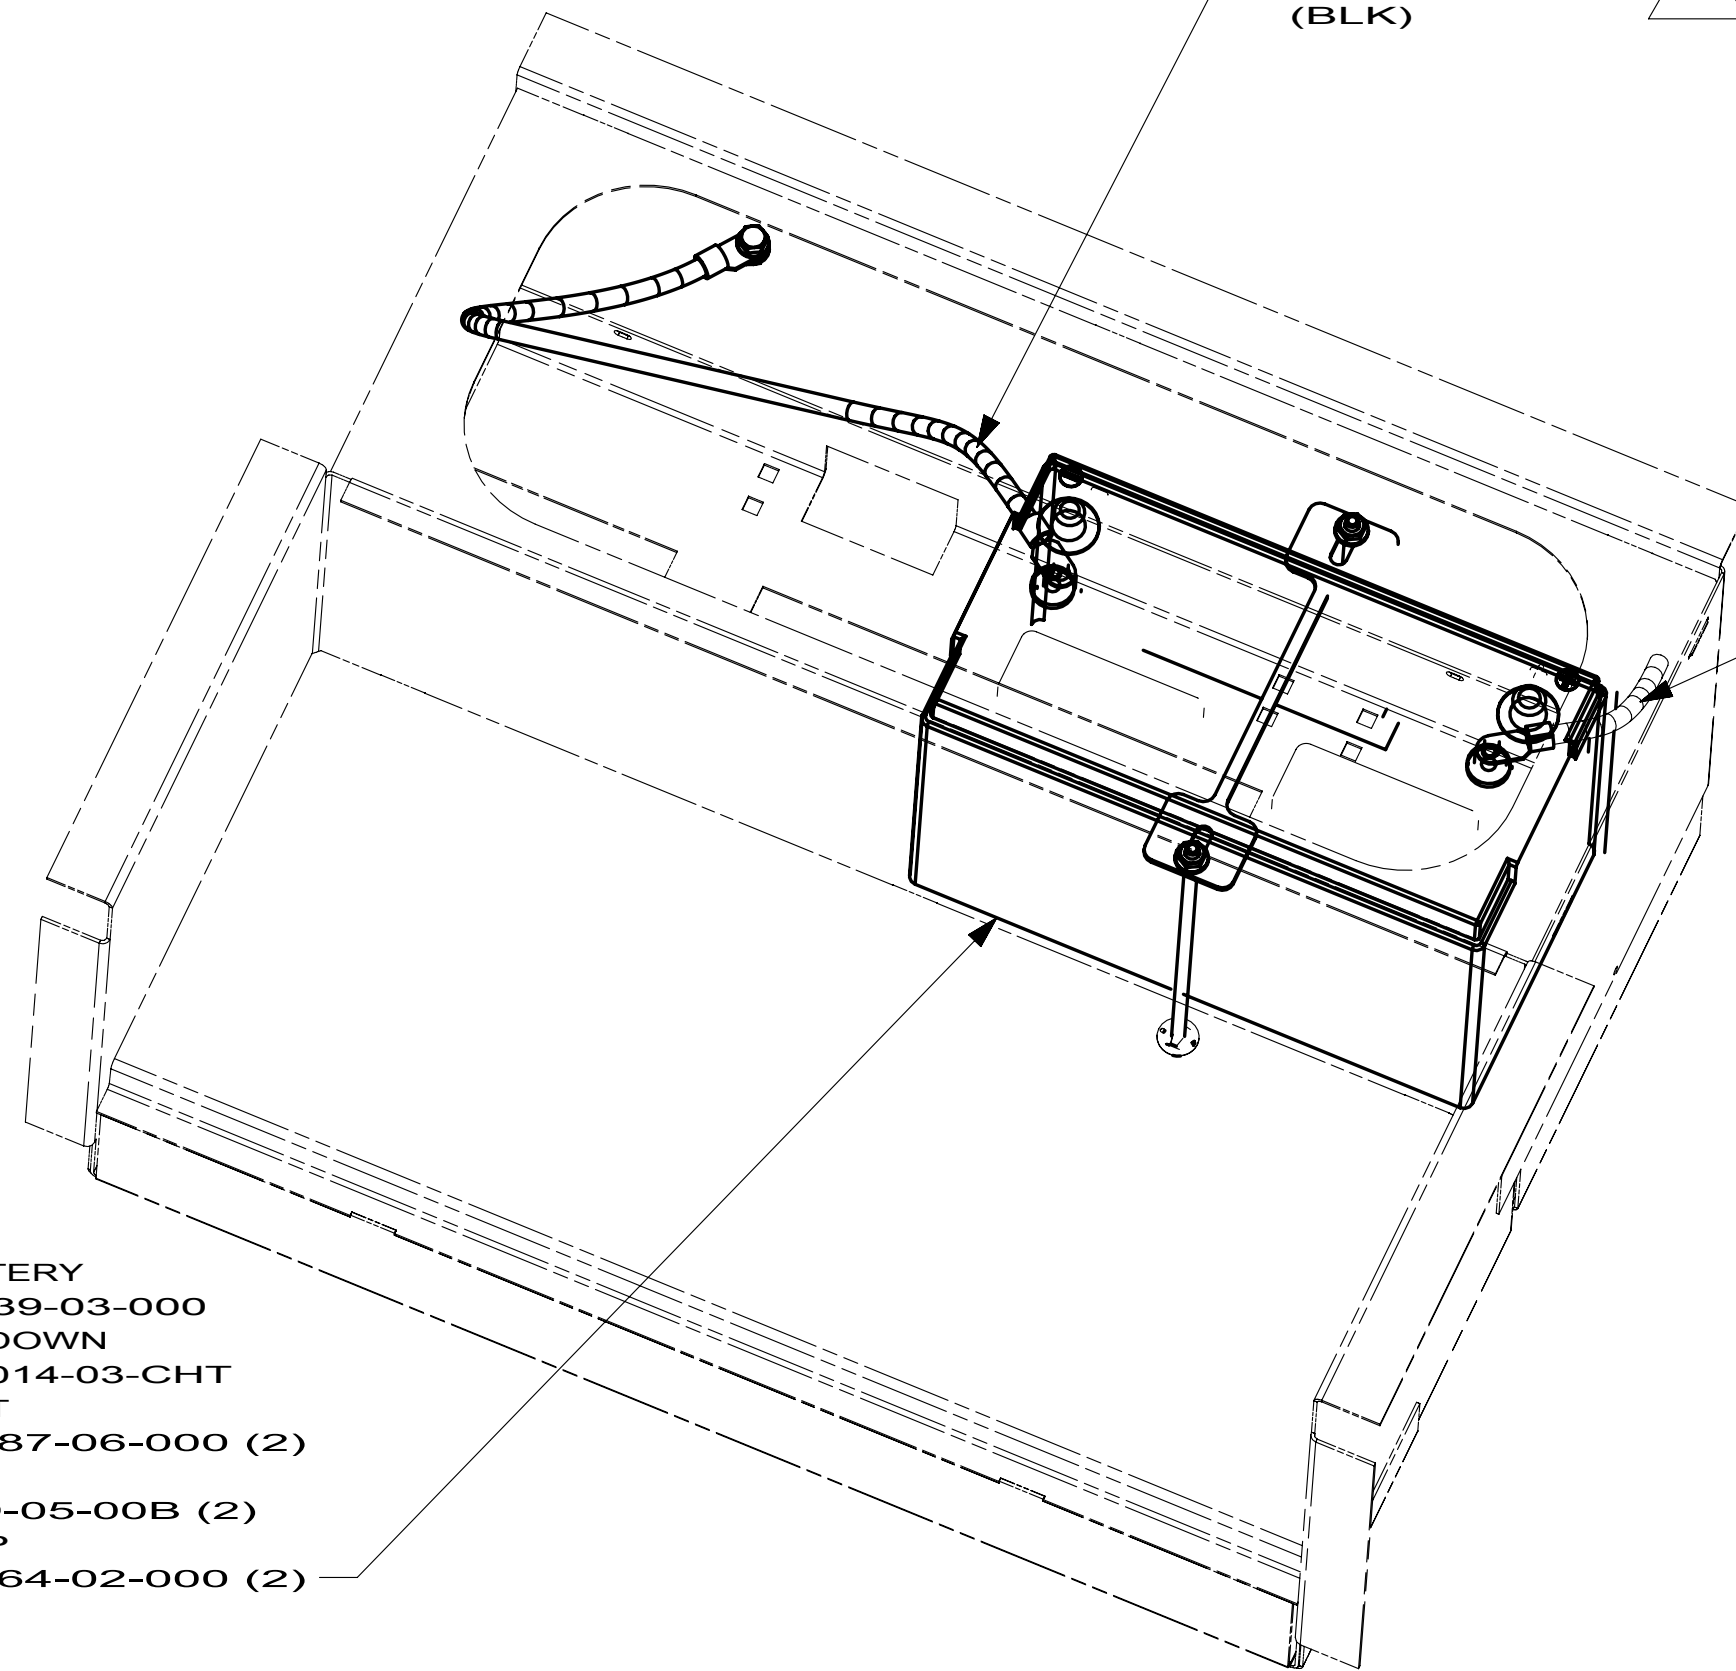

BATTERY BOX

CABLE ASM-COACH
BATTERY GND
(BLK)

CABLE ASM-
COACH BATTERY
(YEL)

2 BATTERY CABLES ARE NOT TO BE ROUTED OVER BATTERY FILL CAPS.

1. SEE WIRING INSTL-CHASSIS FOR ADDITIONAL INFORMATION.

NOTES:

FOR ELECTRICAL
TORQUE
SPECIFICATIONS
SEE DWG NO.
128783-01-000

FOR ELECTRICAL
CALLOUTS
SEE DWG NO.
121339-01-000

12X BATTERY-ONE
265 CODES/STANDARDS-CSA/CMVSS
1B1 CODES/STANDARDS USA


 
1B1 265 12X

FIRST USED
10 200/300/700 SER


DO NOT SCALE DRAWING

TITLE:
BATTERY INSTL

SHEET 2 PART NO 170020 REV

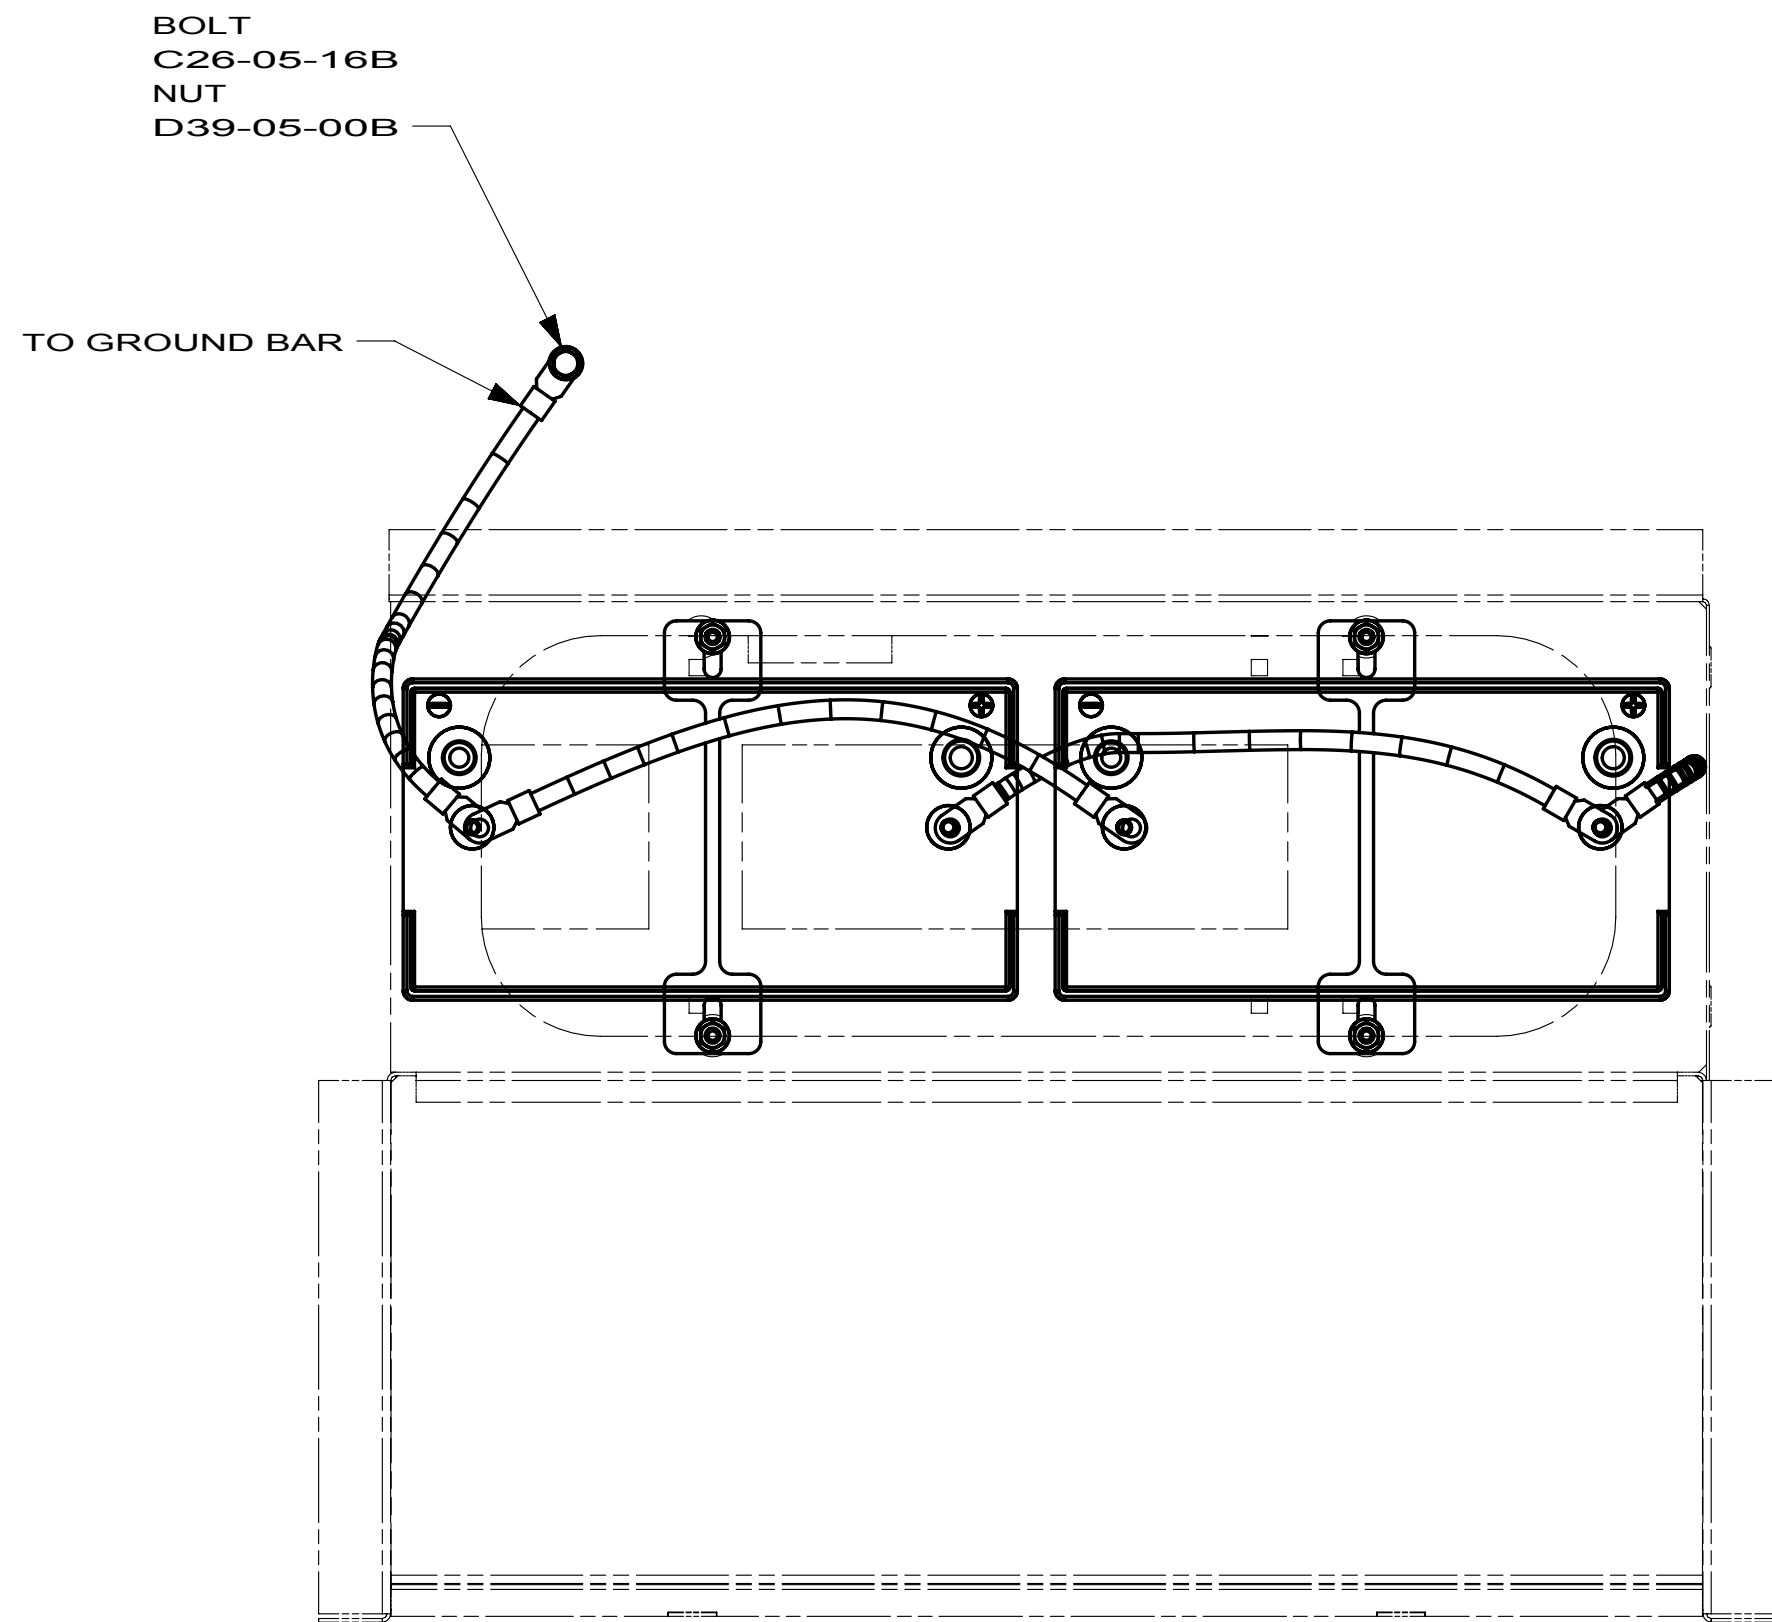

VIEW CA

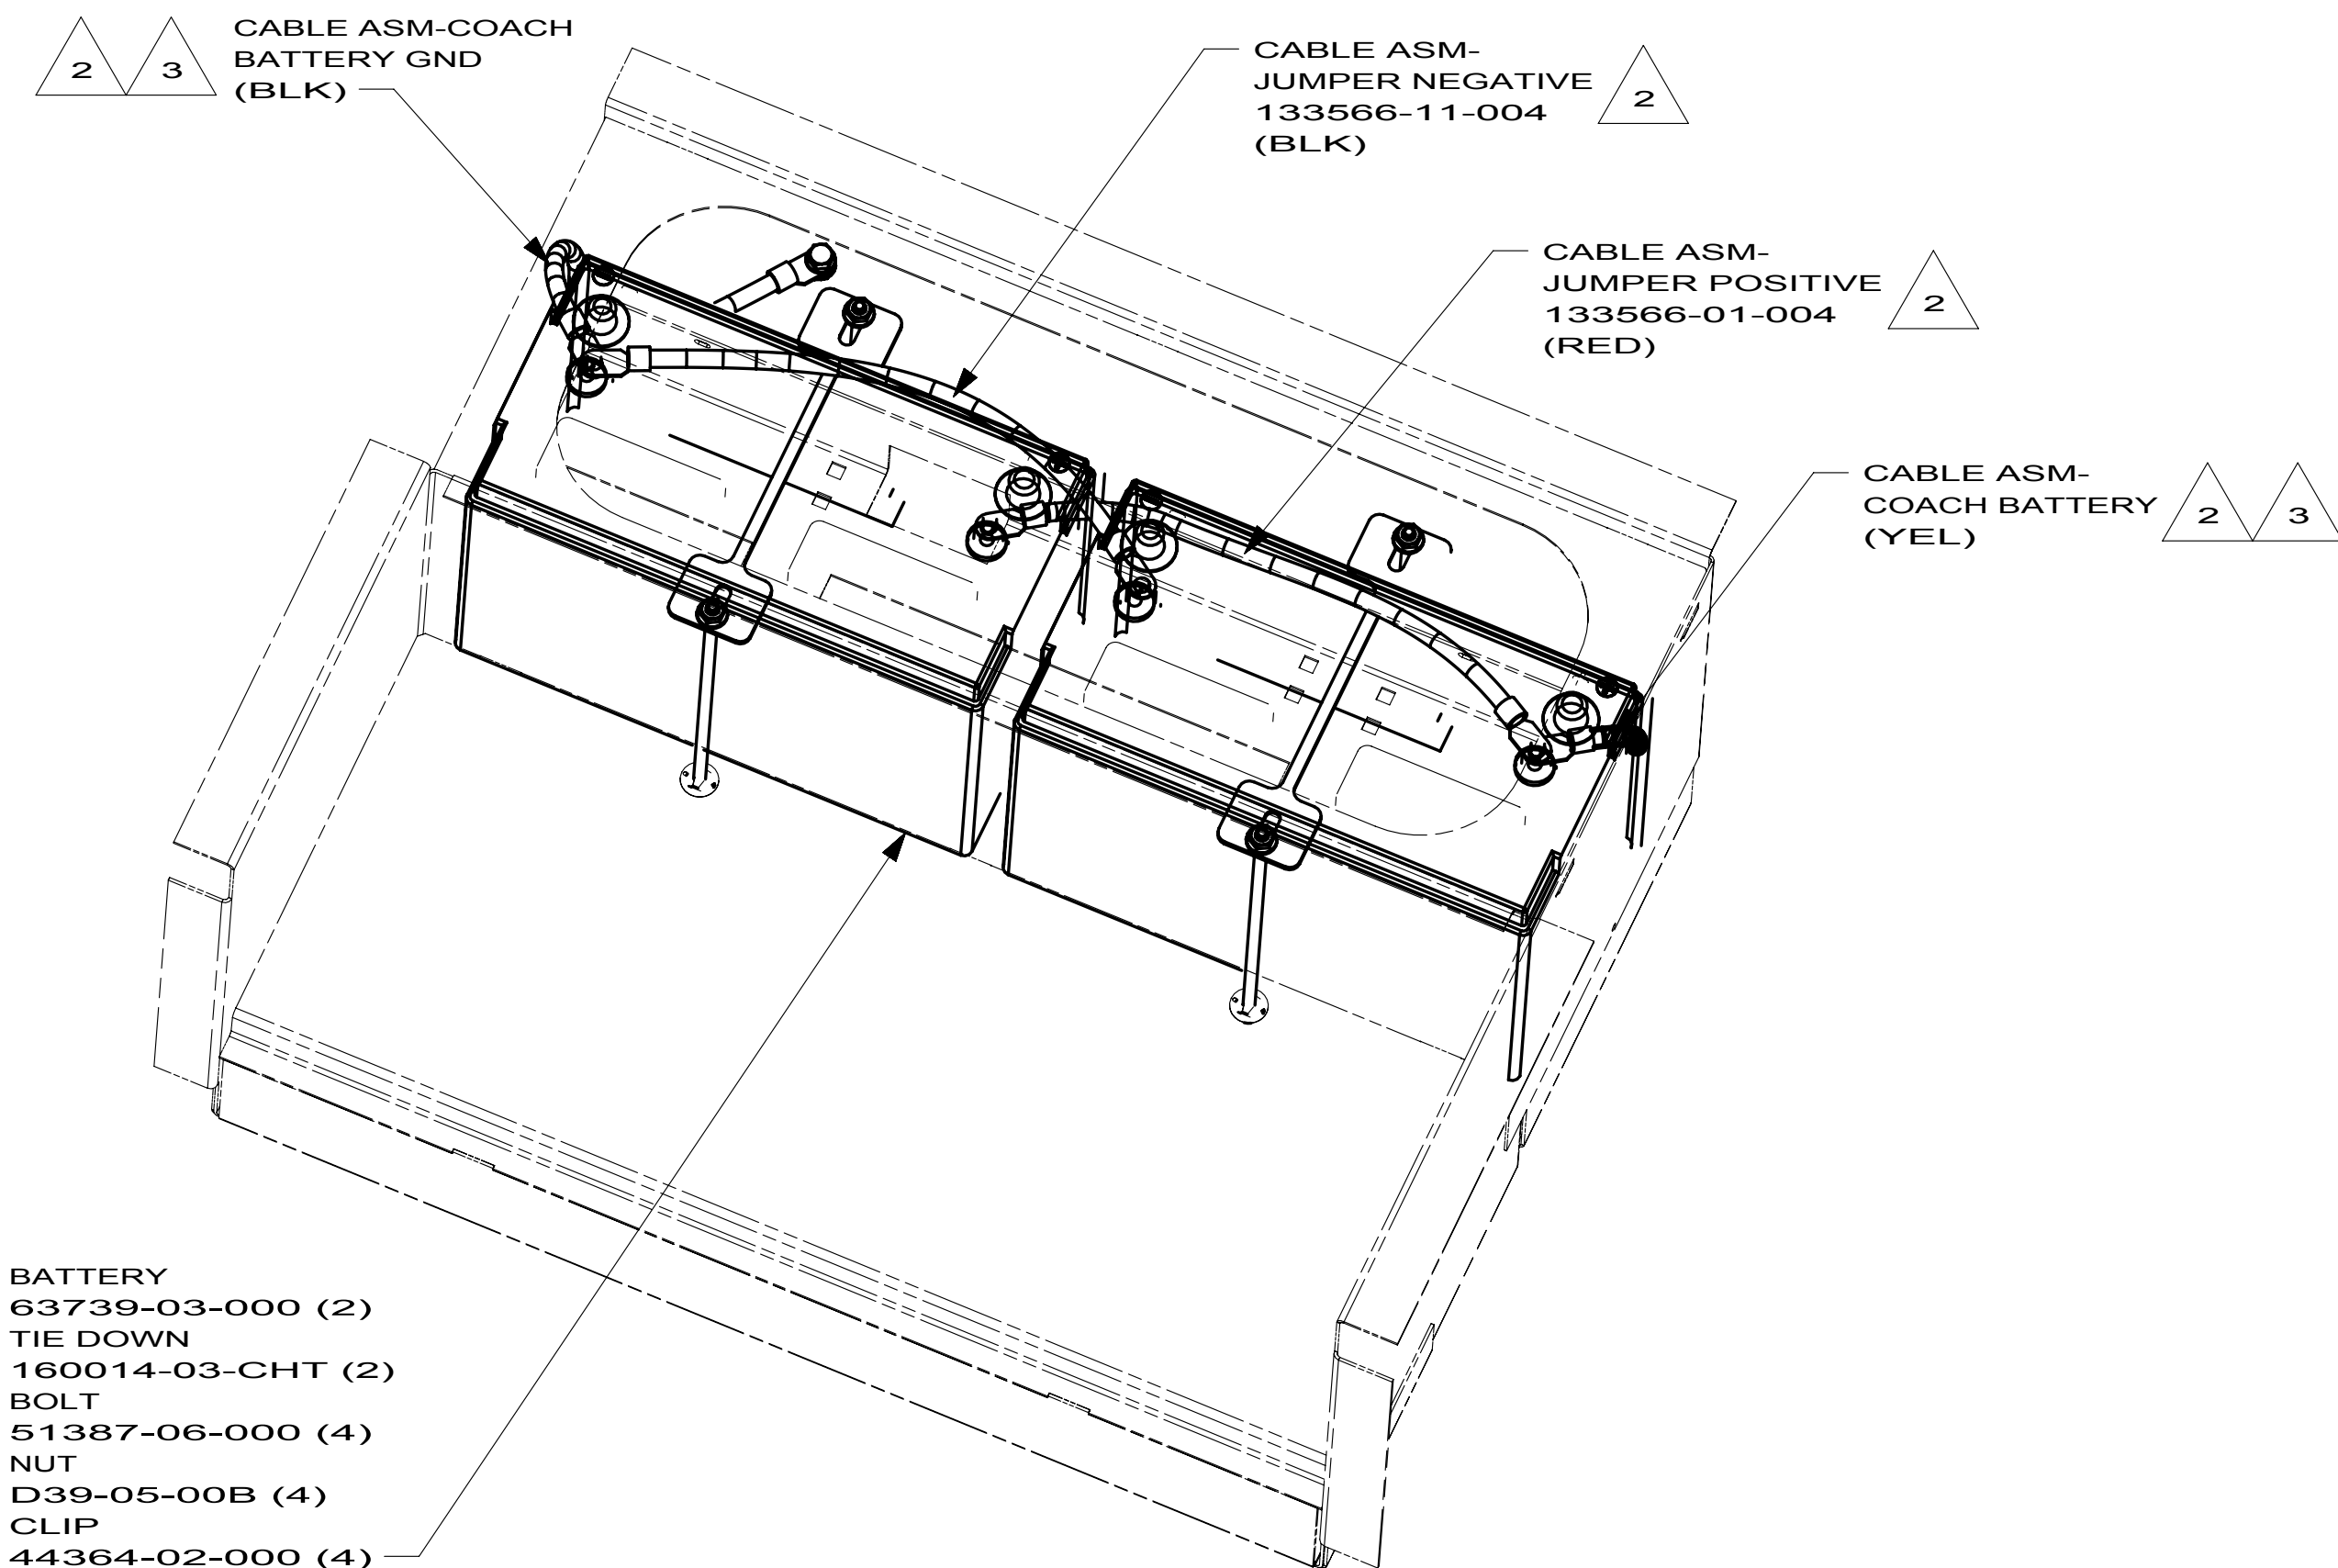

BATTERY BOX

- 3 THE POSITIVE AND NEGATIVE BATTERY CABLES ARE TO BE TERMINATED ON OPPOSITE BATTERIES.
- 2 BATTERY CABLES ARE NOT TO BE ROUTED OVER BATTERY FILL CAPS.

NOTES:

1. SEE WIRING INSTL-CHASSIS FOR ADDITIONAL INFORMATION.

22W BATTERY-SECOND

265 CODES/STANDARDS-CSA/CMVSS


1B1 CODES/STANDARDS USA


1B1 265 22W

FIRST USED		
10 200/300/700 SER		
DO NOT SCALE DRAWING		
TITLE: BATTERY INSTL		
SHEET 3	PART NO 170020	REV

FOR ELECTRICAL
TORQUE
SPECIFICATIONS
SEE DWG NO.
128783-01-000

 
FOR ELECTRICAL
CALLOUTS
SEE DWG NO.
121339-01-000



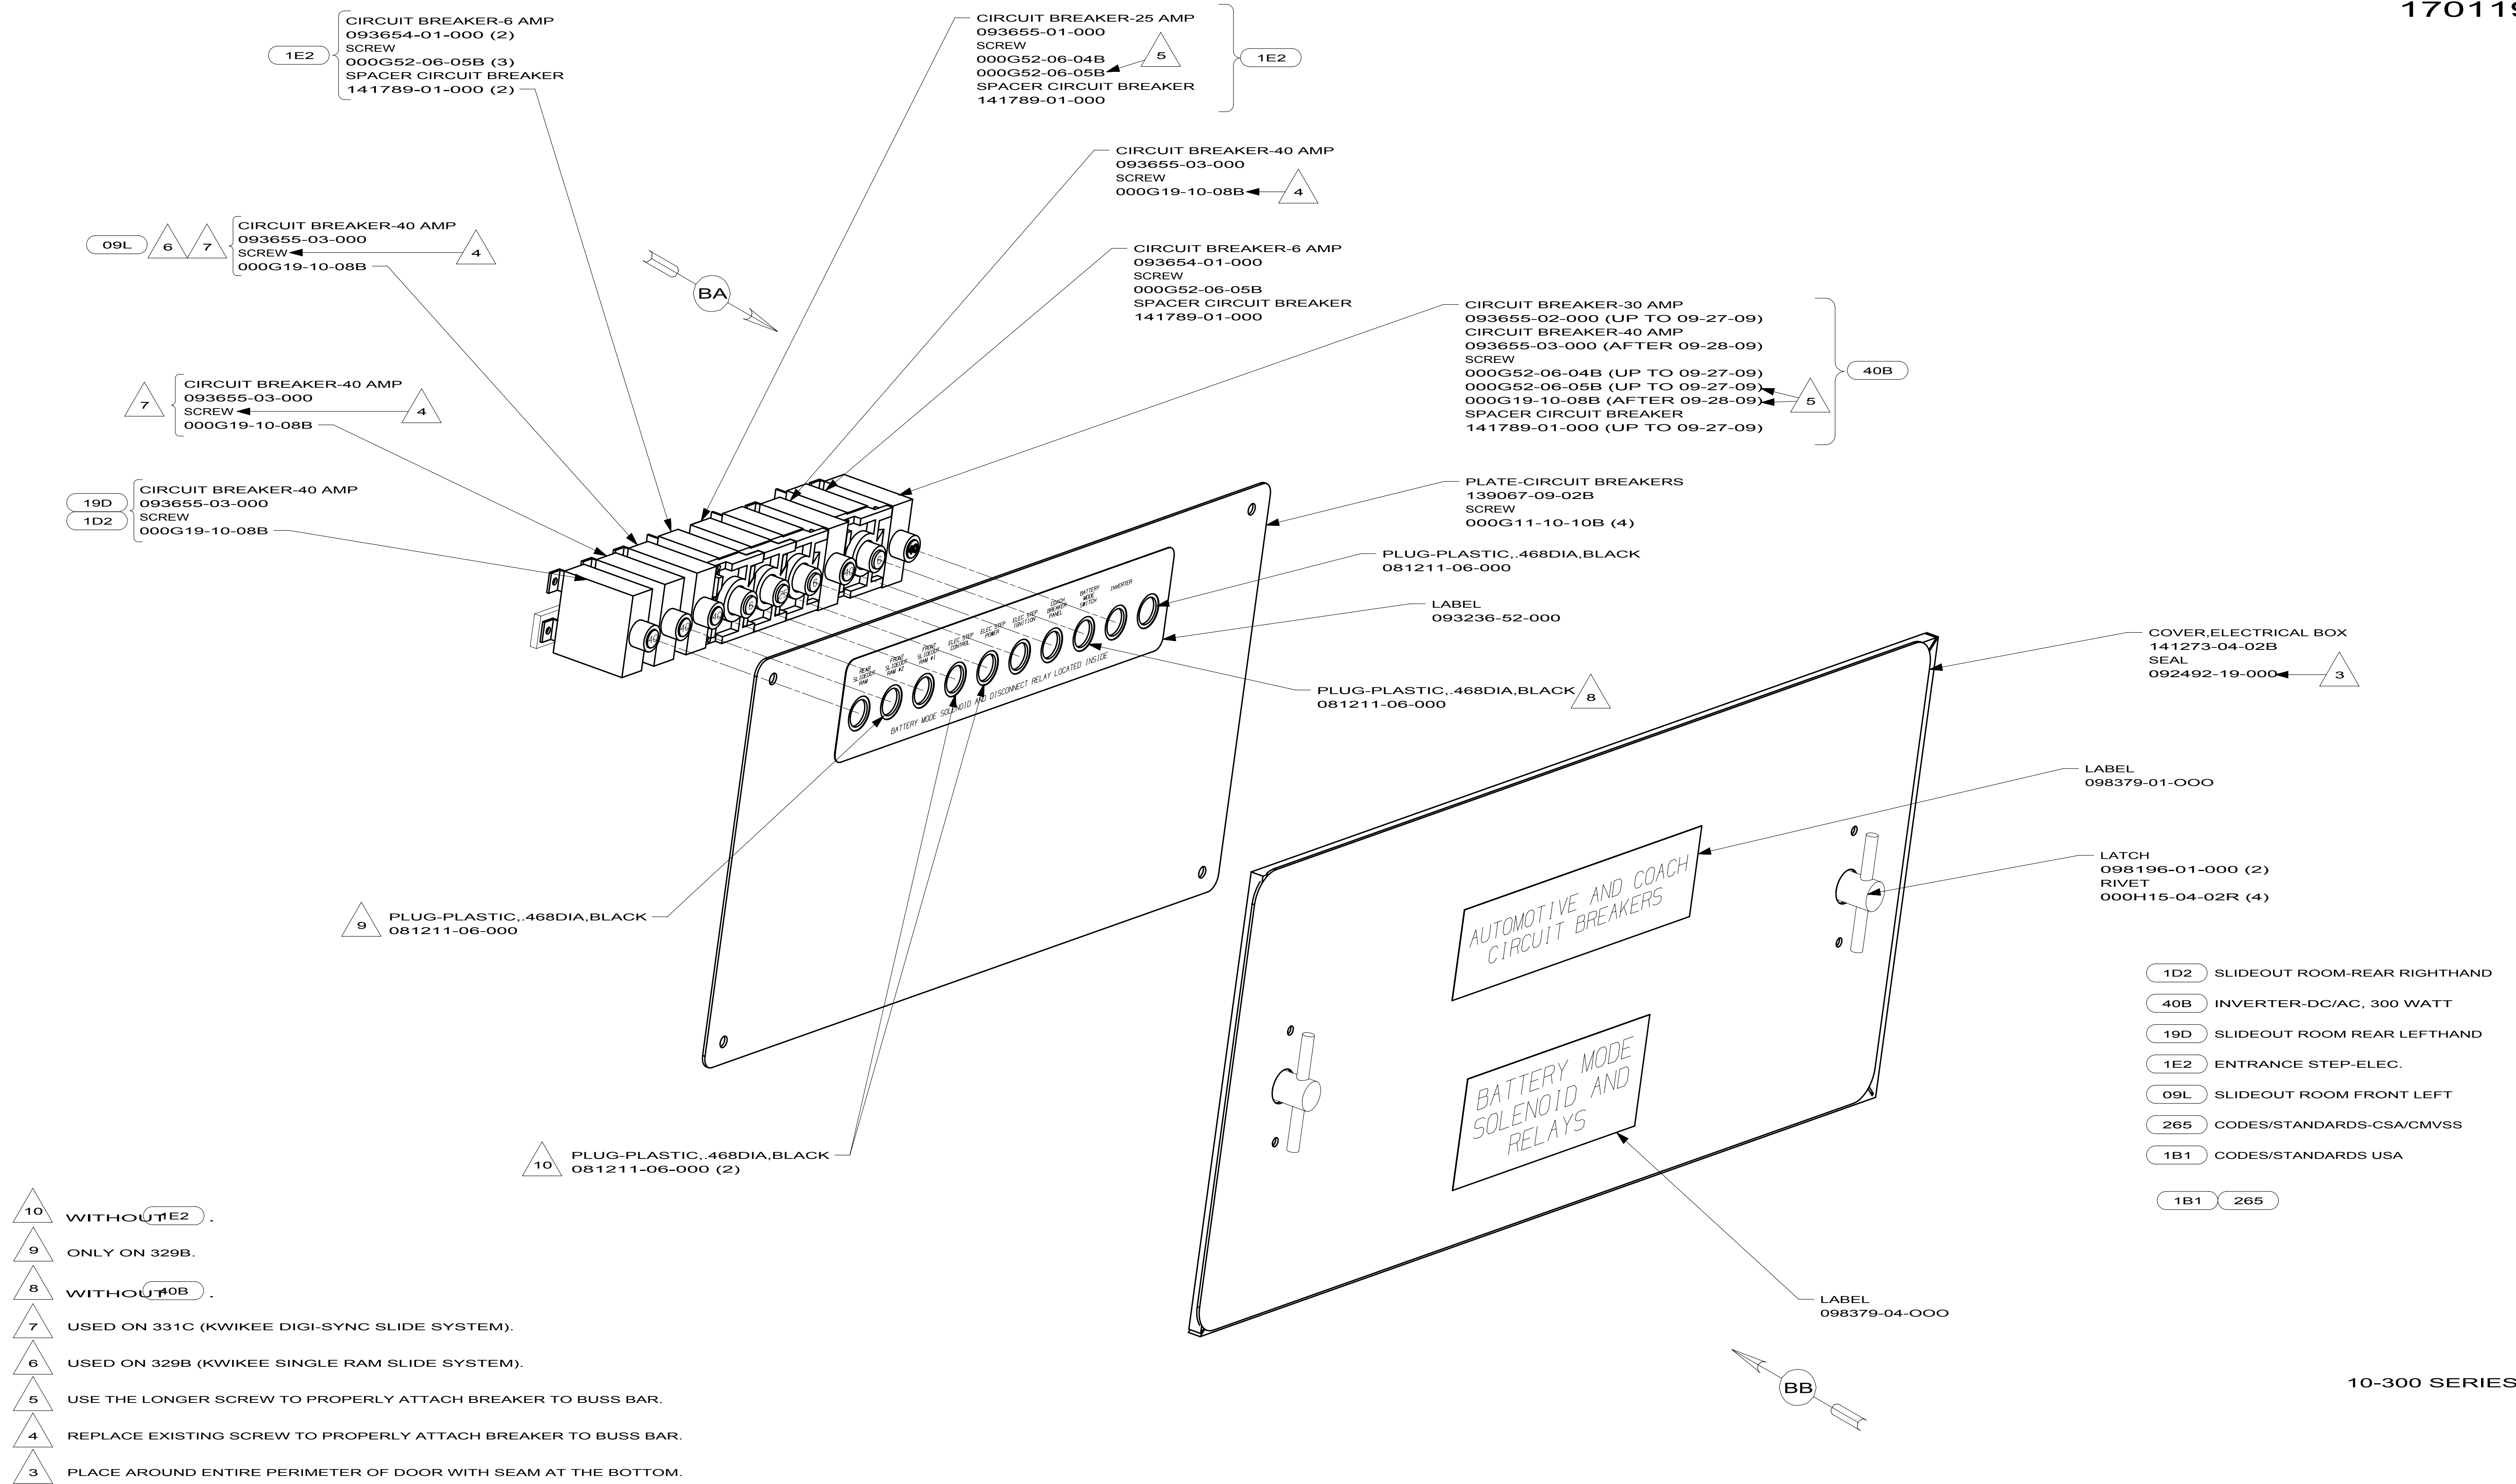

- NOTES:
1. SPACER NOT REQUIRED ON 40 AMP BREAKER.
 2. SECURE CONDUIT 041953, TAB AS REQUIRED, OVER ALL WIRES IN CONTACT WITH SHARP EDGES.

FOR ELECTRICAL TORQUE SPECIFICATIONS SEE DWG NO. 128783-01-000	X-X	FOR ELECTRICAL CALLOUTS SEE DWG NO. 121339-01-000
--	-----	---


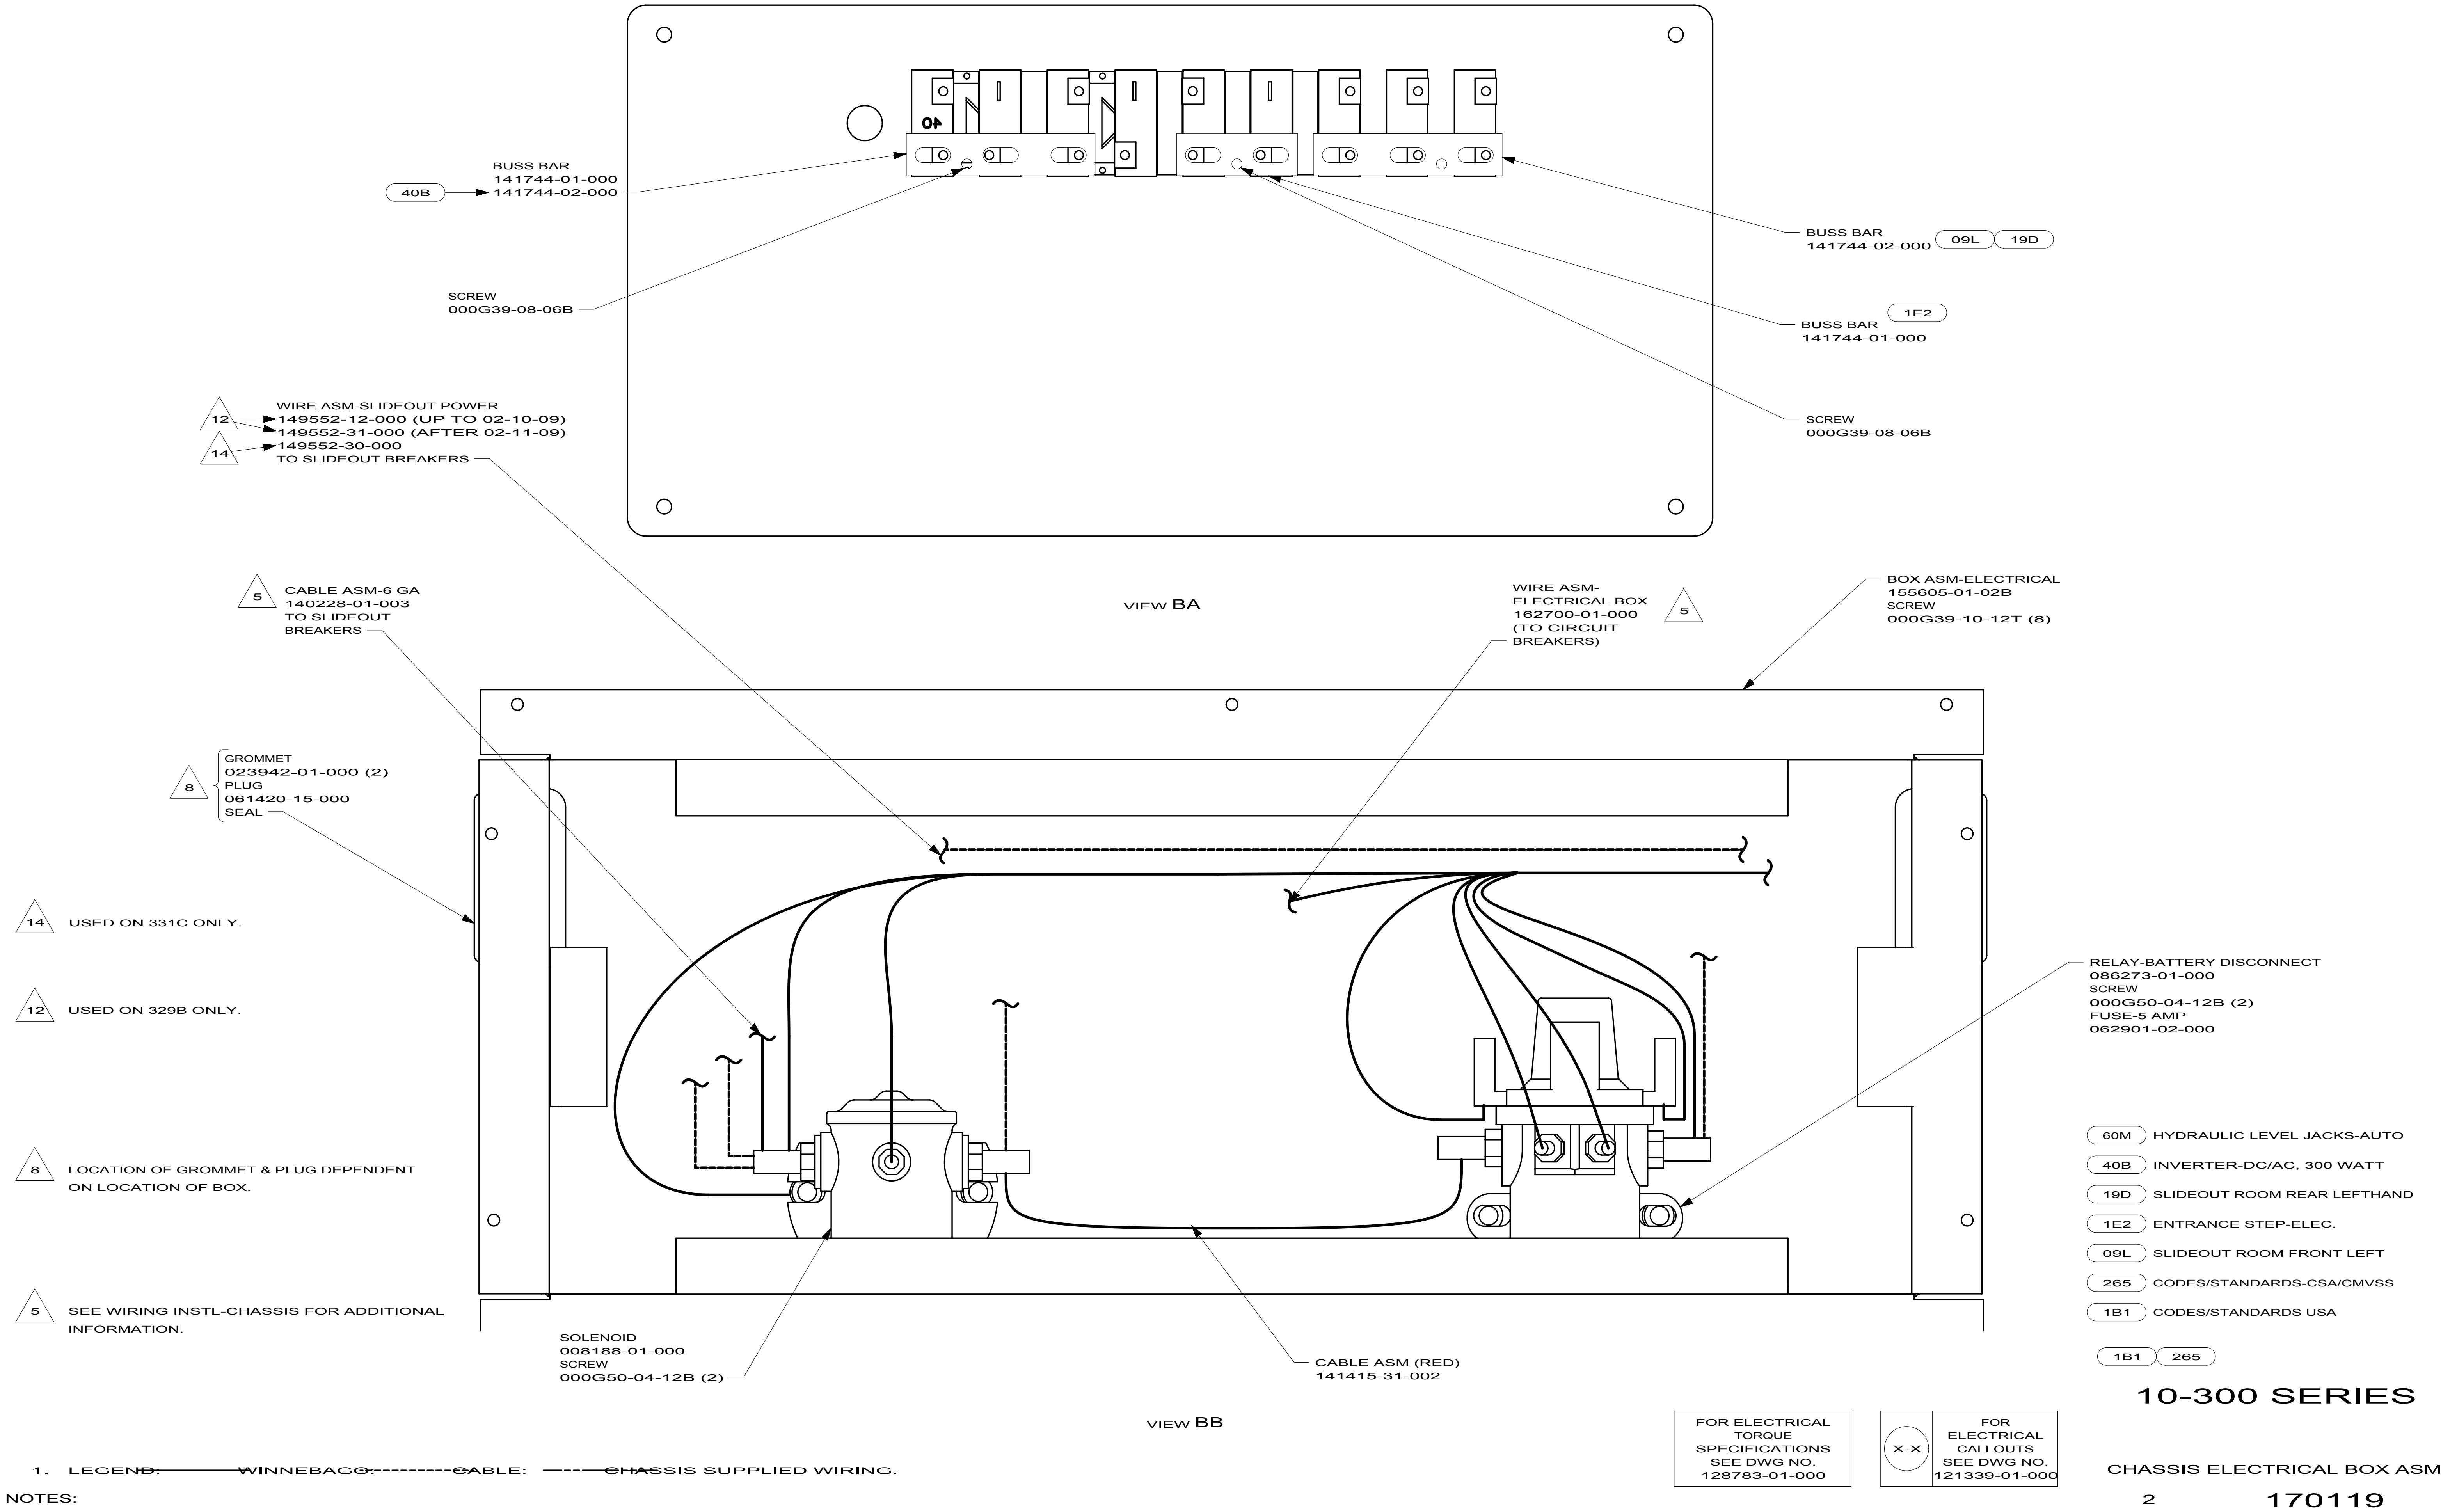


D

C

B

A

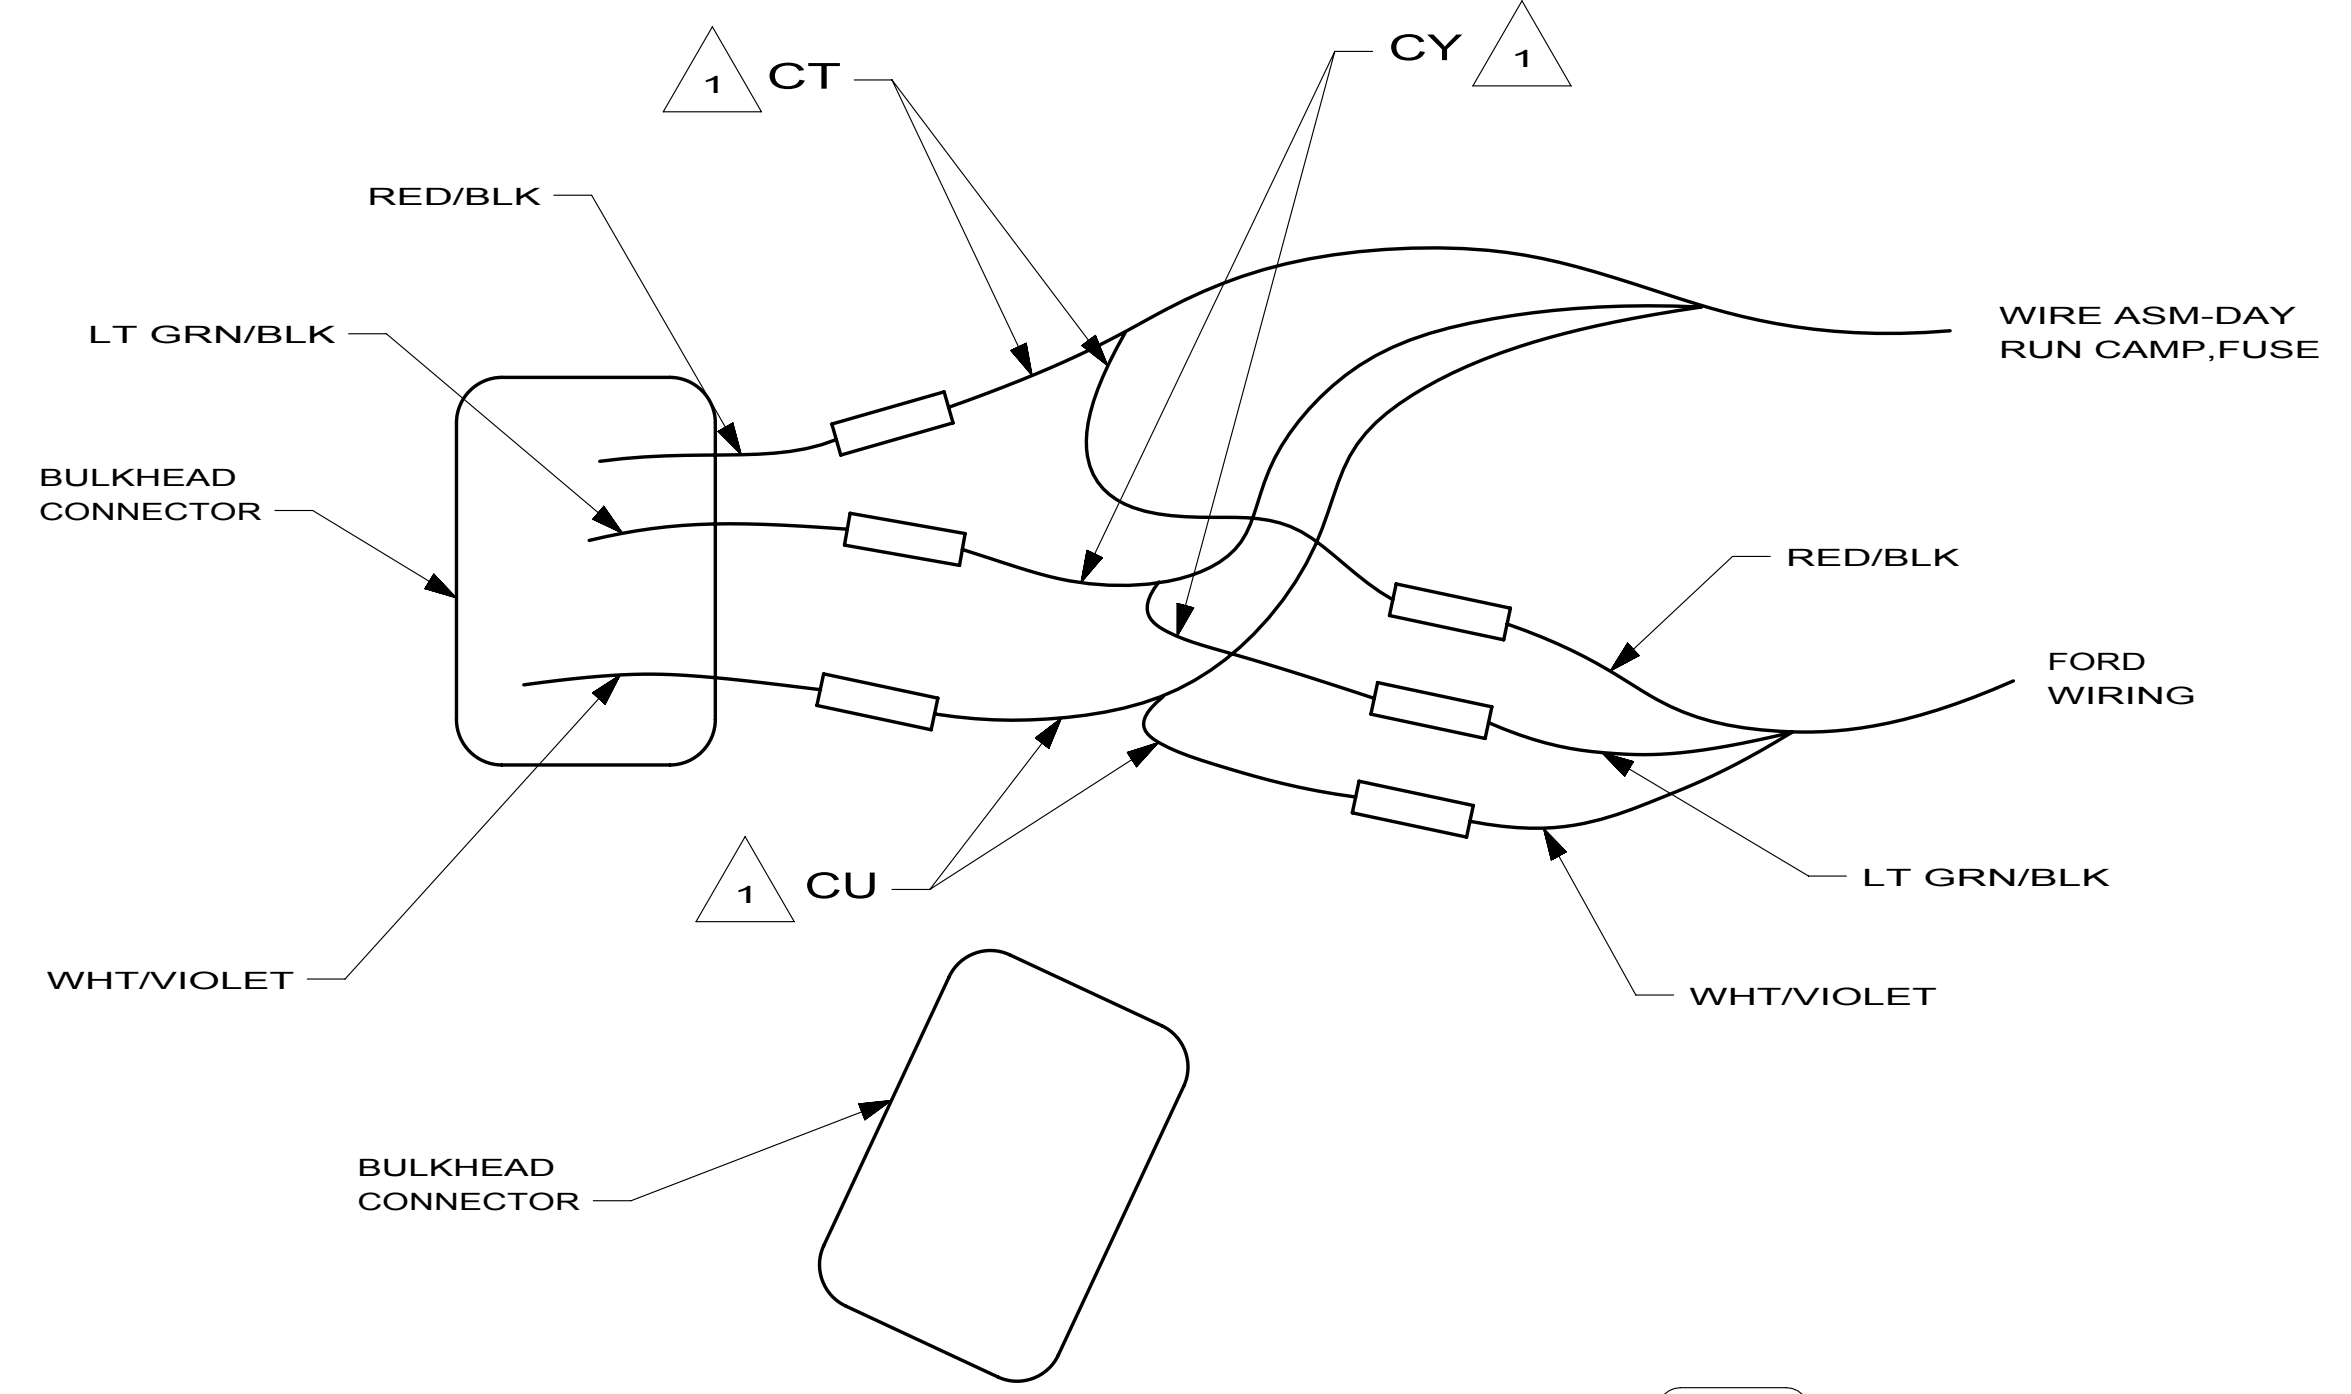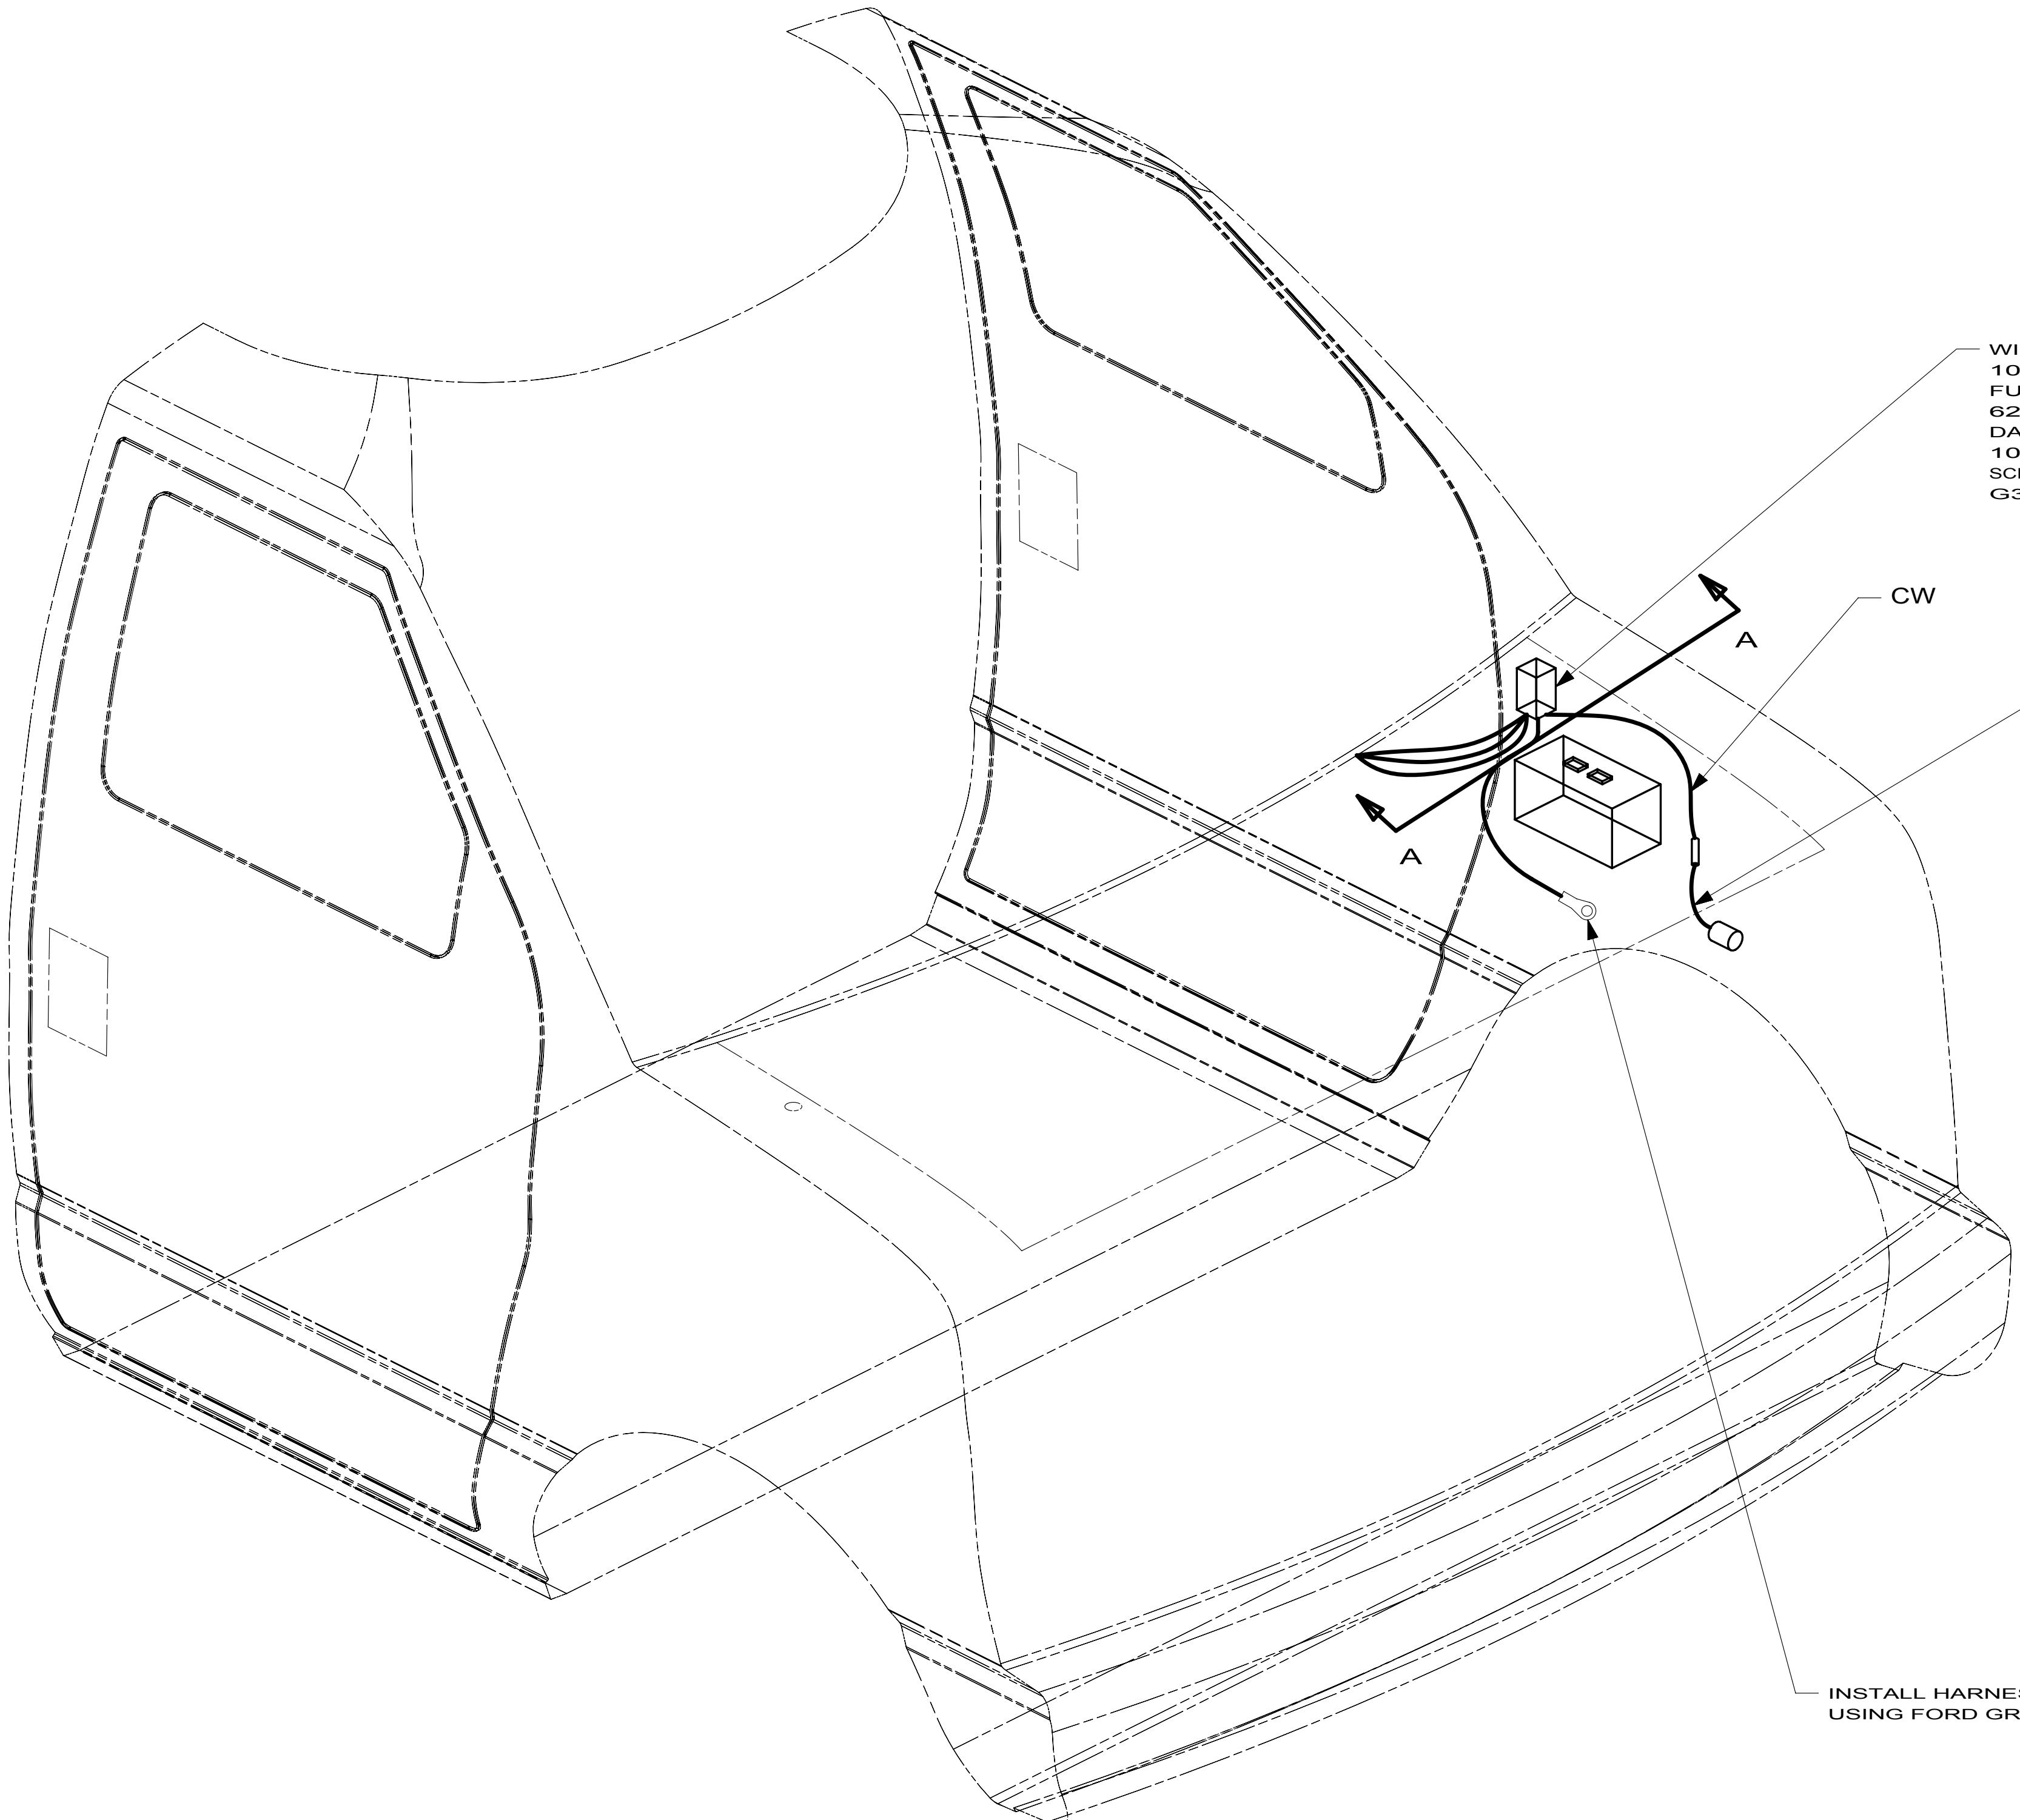

VIEW A-A

27E

27E

CODES/STANDARDS-CMVSS

WINNEBAGO INDUSTRIES

COPYRIGHT 2009 WINNEBAGO INDUSTRIES, INC.

DFT-ORIG

CHGR

P.E.

M.E.

DSNR

UNSPECIFIED TOLERANCES ARE:

WHOLE DIM (X) ±

ONE-PLACE (X.X) ±

TWO-PLACE (X.XX) ±

ANGLE ±

THIRD ANGLE PROJECTION

ORIG. DATE

ALL DIMENSIONS ARE IN MILLIMETERS

FIRST USED

MATERIAL:

09 C-BODIES

DO NOT SCALE DRAWING

TITLE: WIRING INSTL-DAY RUN LAMPS

SHEET 1 OF 1

PART NO 167529

REV

REF:

1

NOTES:

1 CUT AND RECONNECT AS SHOWN.

C-BODY
FORD CHASSIS

8

7

6

5

4

3

2

1

TERMINALS

NO.	PART NUMBER	DESCRIPTION
B-1 B-2 B-11 B-12	50003-01 50004-01 50003-02 50004-02	TERMINAL-PIN, 16-14 GA,.156 DIA TERMINAL-RECP, 16-14 GA,.156 DIA TERMINAL-PIN, 16-14 GA,.180 DIA TERMINAL-RECP, 16-14 GA,.180 DIA
WP-1 WP-2 WP-3	106950-01 106950-02 106950-03	TERMINAL-PIN, 16-14 GA TERMINAL-PIN, 10-12 GA TERMINAL-PIN, 8 GA
R-1 R-2 R-3 R-4 R-5 R-6 R-7 R-8 R-9	35416-01 35416-02 35416-03 35416-04 37018-01 102777-01 102777-02 102777-03 33787-01	TERMINAL-RING, #10 STD, 8 GA TERMINAL-RING, #10 STD, 6 GA TERMINAL-RING, #10 STD, 10-12 GA TERMINAL-RING, #10 STD, 14-16 GA TERMINAL-RING, 5/16 STD, 12-10 GA TERMINAL-RING, #6 STD, 14-16 GA TERMINAL-RING, #6 STD, 10-12 GA TERMINAL-RING, #6 STD, 8 GA TERMINAL-RING, #10 STD, 14 GA
R-60 R-61 R-62 R-63 R-64 R-65 R-66 R-67 R-68 R-69 R-70 R-71	8325-01 8326-01 8327-01 8328-01 8328-02 8329-01 8331-01 8332-01 8332-02 8350-01 99275-02 101397-01	TERMINAL-RING, 1/4 STD, 14-16 GA TERMINAL-RING, 3/8 STD, 14-16 GA TERMINAL-RING, #10 STD, 14-16 GA TERMINAL-RING, #10 STD, 10-12 GA TERMINAL-RING, 3/8 STD, 10-12 GA TERMINAL-RING, 3/8 STD, 8 GA TERMINAL-RING, 3/8 STD, 4 GA TERMINAL-RING, 1/4 STD, 6 GA TERMINAL-RING, 1/4 STD, 10 GA TERMINAL-RING, 3/8 STD, 6 GA TERMINAL-RING, 7/16 STD, 8 GA TERMINAL-RING, #10 STD, 14-16 GA
R-91 R-92 R-93 R-94	88791-01 88791-02 8348-01 99275-01	TERMINAL-RING, 3/8, 90° , 1/0 GA TERMINAL-RING, 3/8, 90° , 2 GA TERMINAL-RING, 3/8 STD, 2 GA TERMINAL-RING, 7/16 STD, 1/0 GA
RF-51 RF-52	7944-01 7945-01	TERMINAL-SPADE, 12-10 GA, #8 STUD TERMINAL-SPADE, 18-14 GA, #8 STUD
TR-1 TR-2 TR-3 TR-11 TR-12	47443-01 47443-02 47443-05 47443-03 47443-04	TERMINAL-RECP, 16-14 GA,.25, INS TERMINAL-RECP, 12-10 GA,.25, INS TERMINAL-RECP, 22-18 GA,.25, INS TERMINAL-RECP, 16-14 GA,.19, INS TERMINAL-RECP, 16-14 GA,.11, INS
TR-21	80015-01	TERMINAL-RECP, 22-18 GA,.250, 90 DEG FOR USE WITH TAB THICKNESS .032
TR-22	80015-02	TERMINAL-RECP, 16-14 GA,.187, 90 DEG FOR USE WITH TAB THICKNESS .032
TR-23	80015-03	TERMINAL-RECP, 16-14 GA,.250, 90 DEG FOR USE WITH TAB THICKNESS .032
TR-24	80015-04	TERMINAL-RECP, 16-14 GA,.187, 90 DEG FOR USE WITH TAB THICKNESS .020
TR-51 TR-52 TR-53 TR-54 TR-55	7940-01 23809-01 23809-02 49270-01 7940-02	TERMINAL-RECP, 16-12 GA,.25, UNINS TERMINAL-RECP, 16-14 GA,.19, UNINS TERMINAL-RECP, 18-20 GA,.25, UNINS TERMINAL-RECP, 18-20 GA,.19, UNINS TERMINAL-RECP, 10 GA, .25, UNINS
TT-1 TT-2 TT-11	85745-02 85745-03 85745-04	TERMINAL-TAB, 16-14 GA,.25, INS TERMINAL-TAB, 10-12 GA,.25, INS TERMINAL-TAB, 18-22 GA,.19, INS
TT-51 TT-52	7942-01 7943-01	TERMINAL-TAB, 16-14 GA,.25, UNINS TERMINAL-TAB, 14-10 GA,.25, UNINS
MF6-1	129236-01	TERMINAL-FEM, M/P, 630, 10-12
MF6-2	129236-02	TERMINAL-FEM, M/P, 630, 14-16

SPLICES

NO.	PART NUMBER	DESCRIPTION
BS-1 BS-2 BS-3 BS-SB	31876-01 31876-02 31876-03 100070-01	SPLICE-BUTT, 16-14 GA, BLUE SPLICE-BUTT, 12-10 GA, YELLOW SPLICE-BUTT, 22-18 GA, RED SPLICE-BUTT, 14-16 GA, SHRINK,BLUE
BS-RB	112823-01	SPLICE-BUTT, 14-22 GA, REDUCER
BS-RS	173854-01	SPLICE-BUTT, 14-22 GA, REDUCER, SHRINK
S-1 S-2	7946-01 23808-01	SPLICE, 1-6 MM² SPLICE, 6-9 MM²
I-2 I-5	7956-02 7956-05	SHRINK WRAP .375 DIA SHRINK WRAP .25 DIA
SH-1	58028-01	SPLICE-HAT
S-10	101173-01	SPLICE-BARREL, 26300 CMA

NO.	PART NUMBER	DESCRIPTION
SP-1	90986-02	PLUG ASM-ELECTRIC STEP
SP-2	142524-01-000 098261-01-000 098262-07-000 098261-02-000 (3) 098262-01-000 (3)	HOUSING-4 PIN SOCKET-CONNECTOR SEAL-CONNECTOR SOCKET-CONNECTOR SEAL-CONNECTOR
HR-1	63910-01	HOUSING-RELAY
MP-8 MP-10 MPP CAV-1 CON-3	125323-02 125323-01 125324-01 125325-01 98262-03	HOUSING-PIN, 8 CAVITY HOUSING-PIN, 10 CAVITY TERMINAL-MALE, M/P, 150 SEAL-CAVITY, 150-SERIES M/P SEAL-CONNECTOR
LS-8 LS-10	125323-03 125323-04	LOCK-SECONDARY 8 POSITION LOCK-SECONDARY 10 POSITION
H-8 H-12	108355-01 108355-02	HOUSING-SWITCH, 8 POSITION HOUSING-SWITCH, 12 POSITION

NO.	PART NUMBER	DESCRIPTION
GEN-1	125323-02-000 125324-01-000 (4) 098262-03-000 (4) 125325-01-000 (4) 125323-03-000	HOUSING-8 POSN, MALE ,150 SERIES TERMINAL-MALE, M/P, 150 SEAL-CONNECTOR SEAL-CAVITY, 150 SERIES M/P LOCK-SECONDARY 8 POSITION
GEN-2	125323-01-000 125324-01-000 (5) 098262-03-000 (5) 125325-01-000 (5) 125323-04-000	HOUSING-10 POSN, MALE ,150 SERIES TERMINAL-MALE, M/P, 150 SEAL-CONNECTOR SEAL-CAVITY, 150 SERIES M/P LOCK-SECONDARY 10 POSITION

HOUSINGS AND TERMINALS

NO.	PART NUMBER	DESCRIPTION
HS-2 HS-3 HS-4 HS-5 HS-6 HS-7 HS-9 HS-12 HS-15 HS-2-R	88474-10 88474-09 88474-08 88474-07 88474-06 88474-05 88474-03 88474-01 88474-02	HOUSING-SOCKET, 2 CAVITY HOUSING-SOCKET, 3 CAVITY HOUSING-SOCKET, 4 CAVITY HOUSING-SOCKET, 5 CAVITY HOUSING-SOCKET, 6 CAVITY HOUSING-SOCKET, 6 CAVITY-IN LINE HOUSING-SOCKET, 9 CAVITY HOUSING-SOCKET, 12 CAVITY HOUSING-SOCKET, 15 CAVITY HOUSING-SOCKET, 2 CAVITY-RED
HP-2 HP-3 HP-4 HP-5 HP-6 HP-7 HP-8 HP-9 HP-12 HP-15 HP-2-R HP-3-B HP-3-G HP-3-R	88473-10 88473-09 88473-08 88473-07 88473-06 88473-05 88473-04 88473-03 88473-01 88473-02 88473-15 88473-12 88473-13 88473-14	HOUSING-PIN, 2 CAVITY HOUSING-PIN, 3 CAVITY HOUSING-PIN, 4 CAVITY HOUSING-PIN, 5 CAVITY HOUSING-PIN, 6 CAVITY HOUSING-PIN, 6 CAVITY-IN LINE HOUSING-PIN, 8 CAVITY-IN LINE HOUSING-PIN, 9 CAVITY HOUSING-PIN, 12 CAVITY HOUSING-PIN, 15 CAVITY HOUSING-PIN, 2 CAVITY-RED HOUSING-PIN, 3 CAVITY-BLUE HOUSING-PIN, 3 CAVITY-GREEN HOUSING-PIN, 3 CAVITY-RED
TS-1 TS-2	88476-01 88476-02	SOCKET-CONNECTOR, 20-14 GA SOCKET-CONNECTOR, 12-10 GA
TP-1 TP-2	88475-01 88475-02	PIN-CONNECTOR, 20-14 GA PIN-CONNECTOR, 12-10 GA
HS2HA HP2HA	137208-01 137207-01	HOUSING-SOCKET, 2 CAVITY-HIGH AMP HOUSING-PIN, 2 CAVITY-HIGH AMP
TS-HA TP-HA	137210-01 137209-01	SOCKET-CONNECTOR, 10AWG HIGH AMP PIN-CONNECTOR, 10AWG HIGH AMP
H-HA	104100-01	HOUSING, 1 CAVITY 75 AMP
T-HA	104100-03	TERMINAL 10 AWG - 6 AWG 75 AMP

BALLOON CALLOUT LEGEND

110 V WIRE	TERMINALS/SPLICES	RECEPTACLES
PART NUMBER COLOR LENGTH	PART NUMBER QUANTITY	PART NUMBER CIRCUIT COLOR LOCATION
POWER CORD	CONDUIT	12 V WIRE
WIRE GAUGE LENGTH IN FEET APPROVAL/ LISTING	TYPE DIA IN 1/16" INCREMENTS LENGTH (mm)	CIRCUIT COLOR & WIRE GAUGE HOUSING POSITION/ TERMINATION

NOTES:

1

FOR RECP-BLANK, DET-X DENOTES DETAIL VIEW.

2

CONTACT WIRE PREP PRIOR TO USING FOR TOOLING PURPOSES.

RELEASE

REV DATE

DWG NO

121339

REV ZONE

REVISION RECORD

DATE

DFT-ORIG

WINNEBAGO INDUSTRIES

COPYRIGHT 2010 WINNEBAGO INDUSTRIES, INC.

DFT-OR

CHGR

P.E.

M.E.

DSNR

UNSPECIFIED TOLERANCES ARE:

WHOLE DIM (X)

ONE-PLACE (X.X)

TWO-PLACE (X.XX)

ANGLE

THIRD ANGLE PROJECTION

ORIG. DATE

ALL DIMENSIONS ARE IN MILLIMETERS

FIRST USED

96 MH'S

MATERIAL:

DO NOT SCALE DRAWING

TITLE:

PART LISTING-ELECTRICAL

SHEET 1 OF 7

PART NO


121339

REV

REF:

1

2/17/2010

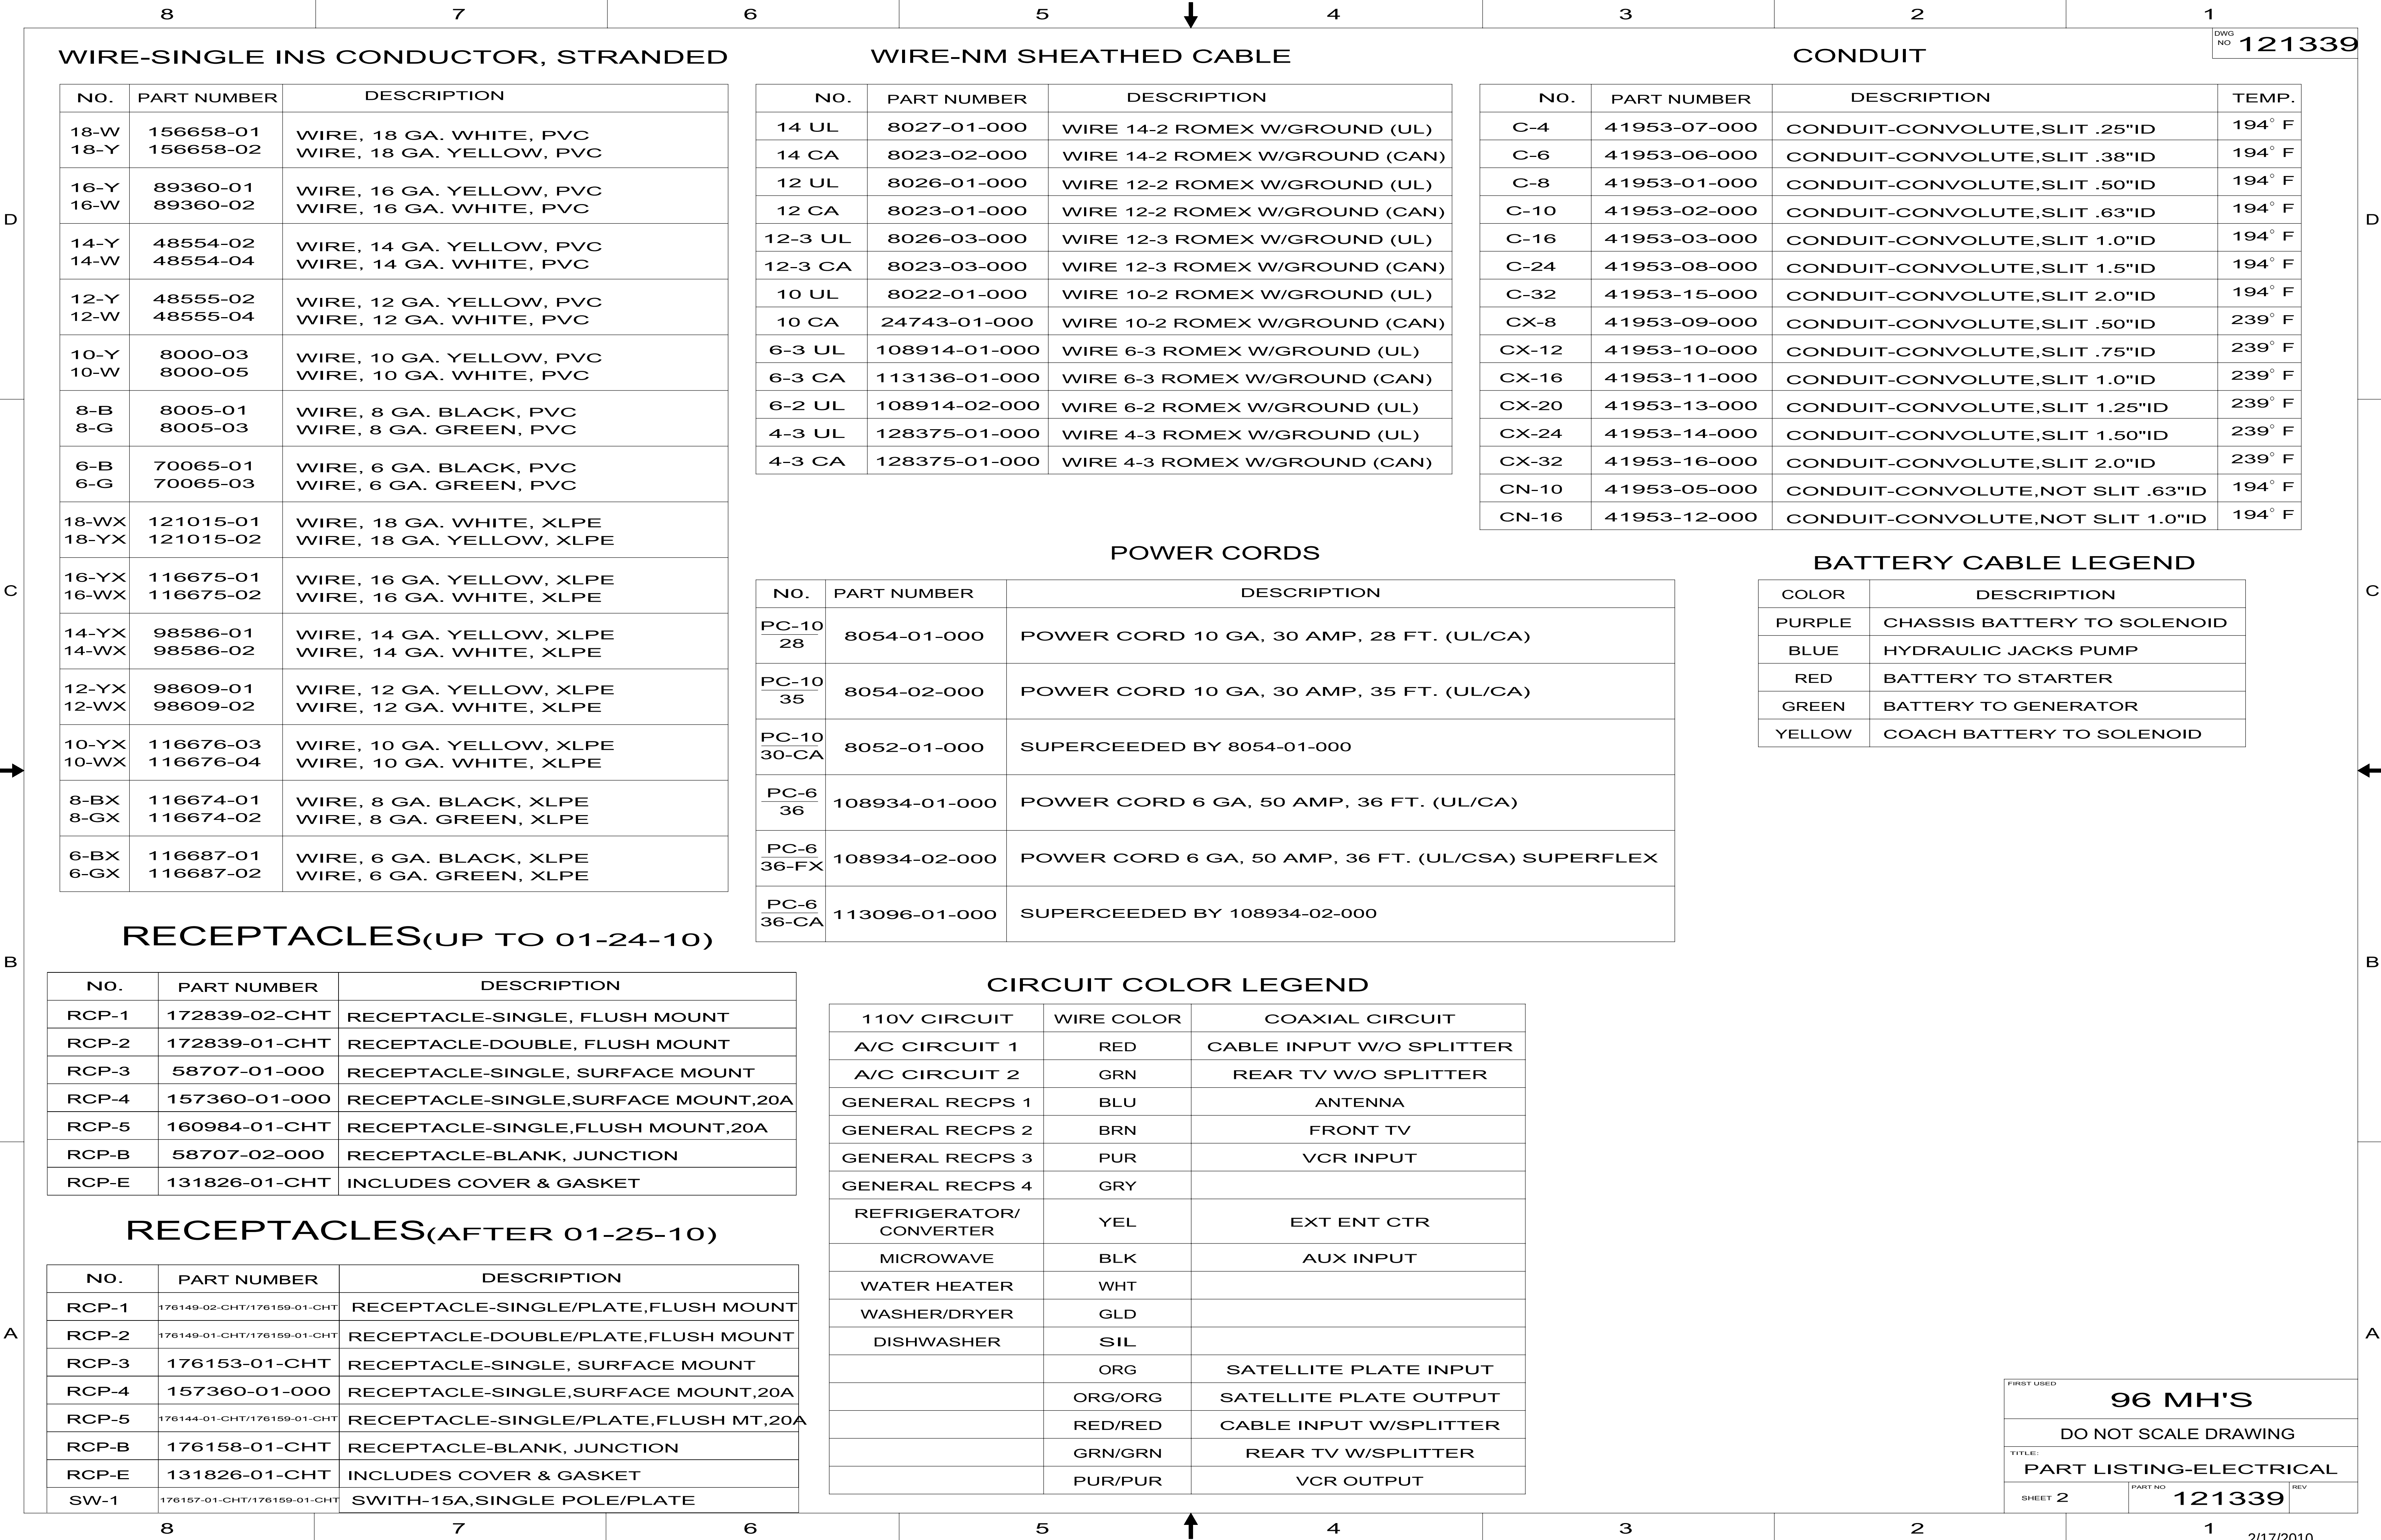

8

7

6

5








4

3


2

1

LAMP ASM-PACKAGE,PANCAKE

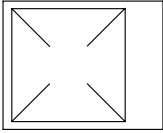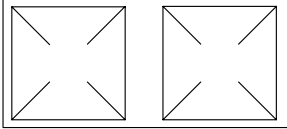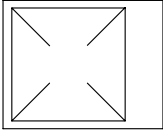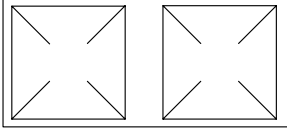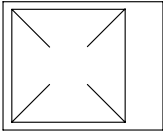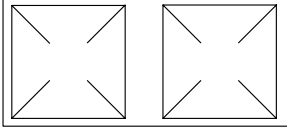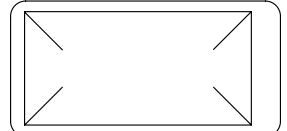NO	PART NUMBER	DESCRIPTION
LF1-1	LAMP 98024-01-CHT SCREW G11-08-16U (4) CONNECTOR 58028-01-000 (2)	LAMP ASM, FROSTED LENS, 1 BULB W/SWITCH PROGRESSIVE DYNAMICS INC. 
LF2-1	LAMP 98024-03-CHT SCREW G11-08-16U (6) CONNECTOR 58028-01-000 (2)	LAMP ASM, FROSTED LENS, 2 BULB W/SWITCH PROGRESSIVE DYNAMICS INC. 
LO1-1	LAMP 98024-05-CHT SCREW G11-08-16U (4) CONNECTOR 58028-01-000 (2)	LAMP ASM, OPTI CLEAR LENS, 1 BULB W/SWITCH PROGRESSIVE DYNAMICS INC. 
LO2-1	LAMP 98024-06-CHT SCREW G11-08-16U (6) CONNECTOR 58028-01-000 (2)	LAMP ASM, OPTI CLEAR LENS, 2 BULB W/SWITCH PROGRESSIVE DYNAMICS INC. 
LF1N1	LAMP 98024-07-CHT SCREW G11-08-16U (4) CONNECTOR 58028-01-000 (2)	LAMP ASM, FROSTED LENS, 1 BULB W/O SWITCH PROGRESSIVE DYNAMICS INC. 
LF2N1	LAMP 98024-08-CHT SCREW G11-08-16U (6) CONNECTOR 58028-01-000 (2)	LAMP ASM, FROSTED LENS, 2 BULB W/O SWITCH PROGRESSIVE DYNAMICS INC. 
LFSN1	LAMP 98024-09-CHT SCREW G11-08-16U (6) CONNECTOR 58028-01-000 (2)	LAMP ASM, SINGLE FROSTED LENS, 2 BULB W/O SWITCH PROGRESSIVE DYNAMICS INC. 

LAMP ASM-PACKAGE,PORCH

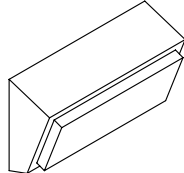NO	PART NUMBER	DESCRIPTION
LEXT-1	LAMP 97917-01-CHT SCREW G67-10-129 (4) CONNECTOR 58028-01-000 (2)	LAMP ASM-PORCH, SURFACE MOUNT BARGMAN 
LEXT-2UL	LAMP 8089-01-000 SCREW G68-06-10E (2) CONNECTOR 58028-01-000 (2)	LAMP ASM-PORCH, RECESSED UL LIST JRV PROD 
LEXT-2CA	LAMP 8089-02-000 SCREW G68-06-10E (2) CONNECTOR 58028-01-000 (2)	LAMP ASM-PORCH, RECESSED CAN LIST JRV PROD 
LEXT-3	LAMP 171513-01-CHT SCREW G67-10-129 (2) CONNECTOR 58028-01-000 (2)	LAMP ASM-PORCH SURFACE MOUNT OPTRONICS

87.0

22.2 R

96

CUT OUT IN PANEL

HALOGEN LAMP

LINE SPRING CLIPS UP WITH RELIEF IN CUT OUT

DETAIL CA

LEGEND

PART NUMBER

QUANTITY

XXXX

XX

PART NUMBER

QUANTITY

XXXXXX

XX

FIRST USED

96 MH'S

DO NOT SCALE DRAWING

TITLE:

PART LISTING-ELECTRICAL

SHEET 3





PART NO121339

REV





DWG NO121339

2/17/2010

LAMP ASM-PACKAGE,PANCAKE

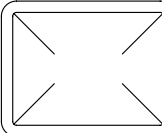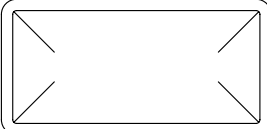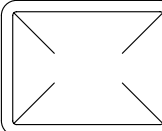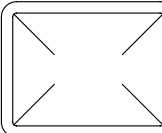NO	PART NUMBER	DESCRIPTION
LF1-2	LAMP 137417-01-CHT SCREW G11-08-16U (4) CONNECTOR 58028-01-000 (2)	LAMP ASM, FROSTED LENS, 1 BULB W/SWITCH PROGRESSIVE DYNAMICS INC. 
LF2-2	LAMP 137417-04-CHT SCREW G11-08-16U (6) CONNECTOR 58028-01-000 (2)	LAMP ASM, FROSTED LENS, 2 BULB W/SWITCH PROGRESSIVE DYNAMICS INC. 
LO1-2	LAMP 137417-02-CHT SCREW G11-08-16U (4) CONNECTOR 58028-01-000 (2)	LAMP ASM, OPTI CLEAR LENS, 1 BULB W/SWITCH PROGRESSIVE DYNAMICS INC. 
LO2-2	LAMP 137417-05-CHT SCREW G11-08-16U (6) CONNECTOR 58028-01-000 (2)	LAMP ASM, OPTI CLEAR LENS, 2 BULB W/SWITCH PROGRESSIVE DYNAMICS INC. 
LF1N2	LAMP 137417-03-CHT SCREW G11-08-16U (4) CONNECTOR 58028-01-000 (2)	LAMP ASM, FROSTED LENS, 1 BULB W/O SWITCH PROGRESSIVE DYNAMICS INC. 
LFSN2	LAMP 137417-06-CHT SCREW G11-08-16U (6) CONNECTOR 58028-01-000 (2)	LAMP ASM, SINGLE FROSTED LENS, 2 BULB W/O SWITCH PROGRESSIVE DYNAMICS INC. 

 LAMP ASM-PACKAGE,HALOGEN

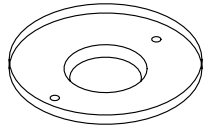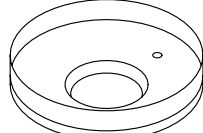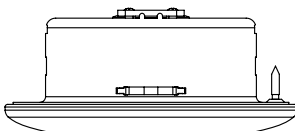NO	PART NUMBER	DESCRIPTION
HAL	LAMP 123775-01-CHT SCREW (SUPPLIED) CONNECTOR 58028-01-000 (2)	LAMP ASM-HALOGEN, READING 1 BULB 
HAL-S	LAMP 123775-01-CHT SPACER 123775-02-CHT SCREW G13-06-16U (3) CONNECTOR 58028-01-000 (2)	LAMP ASM-HALOGEN, READING WITH 3/4" SPACER 1 BULB 
HAL-2	LIGHT-HAL,ROUND 165170-01-CHT SCREW G13-06-12B (2) CONNECTOR 58028-01-000 (2)	LIGHT-HALOGEN, ROUND 3" 
HAL-4	LIGHT-HAL,ROUND 165643-01-CHT SCREW G13-05-16B (3) CONNECTOR 58028-01-000 (2) (SEE DETAIL CA)	LIGHT-HALOGEN, ROUND 4.5" 

8

7

6

 
 
 
 
 
 
 
 
 
 
 

 
 
 

 
 
 
 
 
 
 
5

4

3

2

1

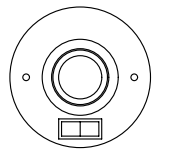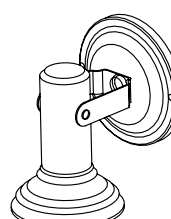8			7			6			5			4			3			2			1																																									
LAMP ASM-PACKAGE,FLUORESCENT															LAMP ASM-PACKAGE,MAKEUP LAMP															LAMP ASM-PACKAGE,OTHER															LAMP ASM-PACKAGE,PANCAKE															DWG NO 121339		
NO			PART NUMBER						DESCRIPTION						NO			PART NUMBER						DESCRIPTION						NO			PART NUMBER						DESCRIPTION																							
FLU-1			LAMP 91936-02-CHT SCREW G11-08-12U (4) CONNECTOR 58028-01-000 (2)						LAMP ASM-FLUORESCENT 12" 2 BULB W/SWITCH THIN-LITE 						LMU3-1			LAMP 110235-01-CHT SCREW W/SPACER (SUPPLIED) CONNECTOR 58028-01-000 (2)						LAMP ASM-MAKEUP (W/O MIRROR) 3 BULB (SUPPLIED) PROGRESSIVE DYNAMICS 						LSH-1			LAMP 121935-01-CHT SCREW G11-08-16U (4) CONNECTOR 58028-01-000 (2)						LAMP ASM-SHOWER PROGRESSIVE DYNAMICS INC. 						LF1-3			LAMP 170693-01-CHT SCREW G11-08-16U (4) CONNECTOR 58028-01-000 (2)						LAMP ASM, FROSTED LENS, 1 BULB W/SWITCH GUSTAFSON 								
FLU-2			LAMP 91936-01-CHT SCREW G11-08-12U (4) CONNECTOR 58028-01-000 (2)						LAMP ASM-FLUORESCENT 18" 2 BULB W/SWITCH THIN-LITE 						LMM3-2			LAMP 123774-03-CHT SCREW (SUPPLIED) BULB 123918-01-000 (3) CONNECTOR 58028-01-000 (2)						LAMP ASM-MAKEUP (W/MIRROR) 3 BULB GUSTOFSON 						LSH-2			LAMP 164039-01-CHT SCREW G11-08-16U (3) CONNECTOR 58028-01-000 (2)						LIGHT-DOME,SHOWER 						LF2-3			LAMP 170693-04-CHT SCREW G11-08-24U (4) CONNECTOR 58028-01-000 (2)						LAMP ASM, FROSTED LENS, 2 BULB W/SWITCH GUSTAFSON 								
FLU-3			LAMP 127327-01-CHT SCREW G11-08-12U (2) CONNECTOR 58028-01-000 (2)						LAMP ASM-FLUORESCENT 18" 1-12" BULB W/SWITCH THIN-LITE 						LMU3-2			LAMP 138116-01-CHT SCREW (SUPPLIED) BULB 123918-01-000 (3) CONNECTOR 58028-01-000 (2)						LAMP ASM-MAKEUP (W/O MIRROR) 3 BULB GUSTOFSON 						LSH-3			LAMP 164040-01-CHT SCREW G13-07-12U (3) CONNECTOR 58028-01-000 (2)						LIGHT-DOME,SHOWER GLASS 						LO1-3			LAMP 170693-02-CHT SCREW G11-08-16U (4) CONNECTOR 58028-01-000 (2)						LAMP ASM, OPTI CLEAR LENS, 1 BULB W/SWITCH GUSTAFSON 								
FLU-4			LAMP 130338-01-CHT SCREW G11-08-12U (4) CONNECTOR 58028-01-000 (2)						LAMP ASM-FLUORESCENT 18" 2 BULB SURFACE MOUNT W/SWITCH THIN-LITE 						LMU3-3			LAMP 162446-01-CHT SCREW (SUPPLIED) BULB 123918-01-000 (3) CONNECTOR 58028-01-000 (2)						LAMP ASM-MAKEUP (W/O MIRROR) 3 BULB GUSTOFSON 						LCR-1			LAMP 61424-01-000 SCREW G11-08-12U (4) CONNECTOR 58028-01-000 (2)						LAMP ASM-COURTESY,AISLE RAMCO (RECTANGULAR) 						L02-3			LAMP 170693-05-CHT SCREW G11-08-24U (4) CONNECTOR 58028-01-000 (2)						LAMP ASM, OPTI CLEAR LENS, 2 BULB W/SWITCH GUSTAFSON 								
FLU-5			LAMP 153464-02-CHT SCREW G11-08-12U (4) CONNECTOR 58028-01-000 (2)						LAMP ASM-FLUORESCENT 12" 2 BULB W/SWITCH COOL WHITE BULB THIN-LITE  CUTOUT-122 X 336						LMU4-1			LAMP 110235-02-CHT SCREW G11-08-16U (2) CONNECTOR 58028-01-000 (2)						LAMP ASM-MAKEUP (W/O MIRROR) 4 BULB PROGRESSIVE DYNAMICS 						LCS-1			LAMP 108354-01-CHT SCREW G11-08-12U (4) CONNECTOR 58028-01-000 (2)						LAMP ASM-COURTESY,AISLE ITC MARINE (SQUARE) 						LF1N3			LAMP 170693-03-CHT SCREW G11-08-16U (4) CONNECTOR 58028-01-000 (2)						LAMP ASM, FROSTED LENS, 1 BULB W/O SWITCH GUSTAFSON 								
FLU-6			LAMP 130338-02-CHT SCREW G11-08-12U (4) CONNECTOR 58028-01-000 (2)						LAMP ASM-FLUORESCENT 18" 2 BULB SURFACE MOUNT WARM WHITE BULB W/SWITCH THIN-LITE 						LMU4-2			LAMP 138116-02-CHT SCREW (SUPPLIED) BULB 123918-01-000 (4) CONNECTOR 58028-01-000 (2)						LAMP ASM-MAKEUP (W/O MIRROR) 4 BULB GUSTOFSON 						READ-1			LIGHT-READING 132427-01-CHT SCREW SUPPLIED W/ LIGHT CLIP-U 141395-02-CHT (2) CONNECTOR 58028-01-000 (2)						LIGHT-READING,SWIVEL,ROUND 1 BULB 						LFSN3			LAMP 170693-06-CHT SCREW G11-08-24U (4) CONNECTOR 58028-01-000 (2)						LAMP ASM, SINGLE FROSTED LENS, 2 BULB W/O SWITCH GUSTAFSON 								
FLU-7			LAMP 153464-05-CHT SCREW G11-08-12U (4) CONNECTOR 58028-01-000 (2)						LAMP ASM-FLUORESCENT 12" 2 BULB W/SWITCH WARM WHITE BULB THIN-LITE  CUTOUT-122 X 336						LMU4-3			LAMP 162446-02-CHT SCREW (SUPPLIED) BULB 123918-01-000 (4) CONNECTOR 58028-01-000 (2)						LAMP ASM-MAKEUP (W/O MIRROR) 4 BULB GUSTOFSON 						READ-2			LIGHT-READING 128786-02-CHT SCREW G11-08-16J (2) BULB 123917-01-000 CONNECTOR 58028-01-000 (2)						LIGHT,READING,SWIVEL 						LOS N3			LAMP 170693-07-CHT SCREW G11-08-24U (4) CONNECTOR 58028-01-000 (2)						LAMP ASM, OPTICLEAR LENS, 2 BULB W/O SWITCH GUSTAFSON 								
FLU-8			LAMP 173072-01-CHT SCREW G11-08-12U (2) CONNECTOR 58028-01-000 (2)						LAMP ASM-FLUORESCENT 18" ONE 8 WATT BULB W/SWITCH OPTRONICS 						LMM4-2			LAMP 123774-01-CHT SCREW G11-08-16U (2) BULB 123918-01-000 (4) CONNECTOR 58028-01-000 (2)						LAMP ASM-MAKEUP (W/MIRROR) 4 BULB GUSTOFSON 						READ-3			LIGHT-READING 170833-01-CHT SCREW SUPPLIED W/LIGHT CONNECTOR 58028-01-000 (2)						LIGHT,READING,HAL						LO1N3			LAMP 170693-08-CHT SCREW G11-08-16U (4) CONNECTOR 58028-01-000 (2)						LAMP ASM, OPTICLEAR LENS, 1 BULB W/O SWITCH GUSTAFSON 								
FLUN1			LAMP 91936-04-CHT SCREW G11-08-12U (4) CONNECTOR 58028-01-000 (2)						LAMP ASM-FLUORESCENT 12" 2 BULB W/O SWITCH THIN-LITE 																																																					
FLUN2			LAMP 91936-03-CHT SCREW G11-08-12U (4) CONNECTOR 58028-01-000 (2)						LAMP ASM-FLUORESCENT 18" 2 BULB W/O SWITCH THIN-LITE 																																																					
FLUN3			LAMP 153464-01-CHT SCREW G11-08-12U (4) CONNECTOR 58028-01-000 (2)						LAMP ASM-FLUORESCENT 12" 2 BULB W/O SWITCH COOL WHITE BULB THIN-LITE  CUTOUT-122 X 336																																																					
FLUN4			LAMP 153464-03-CHT SCREW G11-08-12U (6) CONNECTOR 58028-01-000 (2)						LAMP ASM-FLUORESCENT 18" 2 BULB W/O SWITCH COOL WHITE BULB THIN-LITE  CUTOUT-122 X 480																																																					
FLUN5			LAMP 153464-06-CHT SCREW G11-08-12U (6) CONNECTOR 58028-01-000 (2)						LAMP ASM-FLUORESCENT 18" 2 BULB W/O SWITCH WARM WHITE BULB THIN-LITE  CUTOUT-122 X 480																																																					
FLUN6			LAMP 153464-04-CHT SCREW G11-08-12U (6) CONNECTOR 58028-01-000 (2)						LAMP ASM-FLUORESCENT 12" 2 BULB W/O SWITCH WARM WHITE BULB THIN-LITE  CUTOUT-122 X 336																																																					

87654321

DWG NO121339

ANTENNA ASM-PACKAGE

NO	PART NUMBER	DESCRIPTION
ANT-1	ANTENNA 76319-24-000 HARDWARE-INTERIOR 76319-25-000 BUMPER 69726-02-000 (2) CLIP 80734-02-000	ROOF MOUNT TV ANTENNA ASM 25.5" MAST 600 MAX COAX LENGTH
ANT-2	ANTENNA 076319-23-000(UP TO 05-31-09) 173519-01-CHT(AFTER 06-01-09) HARDWARE-INTERIOR 76319-25-000 BUMPER 69726-02-000 (2) ADAPTER SUPPLIED W/ANTENNA	ROOF MOUNT TV ANTENNA ASM 44.5" MAST 600 MAX COAX LENGTH
ANT-2W	ANTENNA 076319-23-000(UP TO 05-31-09) 173519-01-CHT(AFTER 06-01-09) HARDWARE-INTERIOR 76319-25-000 BUMPER 69726-02-000 (2) ADAPTER SUPPLIED W/ANTENNA WEDGE 76319-26-000	ROOF MOUNT TV ANTENNA ASM 44.5" MAST 600 MAX COAX LENGTH
ANTA-1	ANTENNA 158270-01-CHT BUMPER 69726-02-000 (2) ADAPTER SUPPLIED W/ANTENNA ANTENNA-WINGMAN, ACCESSORY 173519-03-CHT	ROOF MOUNT TV ANTENNA ASM AUTOMATIC 600 MAX COAX LENGTH
ANT-3	ANTENNA-TV ROOF MNT.ROUND 167632-01-CHT PLATE-ROOF, CABLE ENTRY 146488-01-000 SCREW G67-10-129 (10) CABLE ASM-COAX 87105-01-006 ADAPTER 82134-01-000	ROOF MOUNT OMNI- DIRECTIONAL ANTENNA MOUNTING SCREWS SUPPLIED WITH ANTENNA 600 MAX COAX LENGTH
ANT-4	ANTENNA 173519-01-CHT HARDWARE-INTERIOR 76319-25-000 BUMPER 69726-02-000 (2) ADAPTER SUPPLIED W/ANTENNA ANTENNA-HANDLE EXTENSION 173519-02-CHT	ROOF MOUNT TV ANTENNA ASM 44.5" MAST 600 MAX COAX LENGTH

ANTENNA ASM-PACKAGE

ANTEXT-1	CABLE ASM-EXTENS 77069-02-000	RADIO ANTENNA CABLE EXTENSION 2400MM USABLE LENGTH
ANTKIT-1	ADAPTER-PLATE 76319-06-000 SCREW G11-08-08T (6) CLIP-WIRE 80734-02-000 SCREW G11-08-08T	PLATE ASM-ADAPTERS CABLE ROOF MOUNTING PLATE W/ CABLE-CABLE ADAPTER, FITTINGS, AND CABLE RETAINING CLIP
ANT-R	ANTENNA-RADIO 90944-01-000 EXTENDER-SHAFT ANTENNA 109889-04-000 BRACKET-ANTENNA GROUND 147741-01-CHT	ROOF MOUNT RADIO ANTENNA
ANTEXT-2	CABLE ASM-EXTENS 77069-03-000	RADIO ANTENNA CABLE EXTENSION 6600 MM USABLE LENGTH
ANT-A	ANTENNA-RADIO 90944-01-000 EXTENDER-SHAFT 76 MM 171825-01-000 (2) BRACKET-GROUND 147741-01-CHT NUT OMD01K-06-000 (2)	ROOF MOUNT RADIO ANTENNA THICK ROOF

SATELLITE DISH INSTL

DM-1	SATELLITE DISH 137135-02-000 SCREW G67-10-12B (8) PLATE & BRACKET (SUPPLIED) SCREW G67-10-12B (10)	SATELLITE DISH ANTENNA ASM MANUAL SETUP
DA-1	SATELLITE DISH 163598-01-CHT PLATE-ROOF,CABLE ENTRY QUAD 146488-03-000 SCREW G67-10-12U (8) (FOR PLATE) SCREW G39-10-12U (12) (FOR SATELLITE DISH)	SATELLITE DISH ANTENNA ASM AUTOMATIC SETUP
DI-1	SATELLITE DISH 154474-04-CHT SCREW G39-10-12B (12) PLATE 146488-01-000 SCREW G67-10-12B (10)	SATELLITE DISH ANTENNA ASM IN MOTION SETUP

SATELLITE DISH INSTL

DA-2	SATELLITE DISH 163598-01-CHT PLATE-ROOF,CABLE ENTRY QUAD 146488-03-000 CABLE ASM-COAX 9" 163598-04-000 ADAPTOR-CABLE TO CABLE 82134-01-000 SCREW G67-10-12U (8) (FOR PLATE) SCREW G39-10-12U (12) (FOR SATELLITE DISH)	SATELLITE DISH ANTENNA ASM AUTOMATIC SETUP
DI-2	SATELLITE DISH 154474-04-CHT PLATE-ROOF,CABLE ENTRY QUAD 146488-03-000 CABLE ASM-COAX 9" 163598-04-000 ADAPTOR-CABLE TO CABLE 82134-01-000 SCREW G67-10-12U (8) (FOR PLATE) SCREW G39-10-12U (12) (FOR SATELLITE DISH)	SATELLITE DISH ANTENNA ASM AUTOMATIC SETUP
DM-2	SATELLITE DISH 137135-05-000 PLATE-ROOF,ENTRY (SUPPLIED WITH SATELLITE DISH) SCREW G67-10-12U (8) (FOR ROOF PLATE) SCREW G67-10-12U (10) (FOR SATELLITE DISH)	SATELLITE DISH ANTENNA ASM MANUAL SETUP

SENSORS

LPGD	LP GAS DETECTOR 150138-03-CHT SCREW G68-06-10U (2)	DETECTOR-LP GAS
------	---	---------------------

PANELS

SOLAR	PANEL-SOLAR 10 WATT 151647-01-000 (UP TO 03-14-10) 176161-01-000 (AFTER 03-15-10) SCREW G11-08-12U (4)	SOLAR PANEL
-------	--	-----------------

LEGEND

PART NUMBER

QUANTITY

PART NUMBER

QUANTITY

1

ADD BUMPER TO BOTTOM SIDE OF ANTENNA WINGS TO PREVENT DAMAGE TO ROOF.

FIRST USED

96 MH'S

DO NOT SCALE DRAWING

TITLE:

PART LISTING-ELECTRICAL

SHEET 5

PART NO121339



REV

2/17/2010



87654321

DWG NO121339






RECEPTACLE PACKAGE-GFI

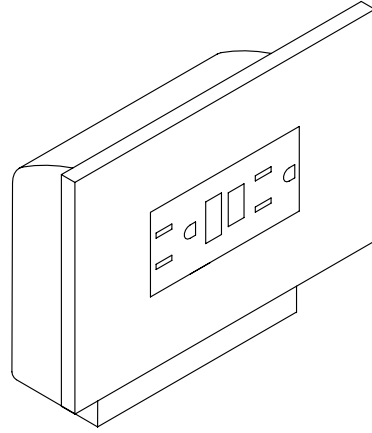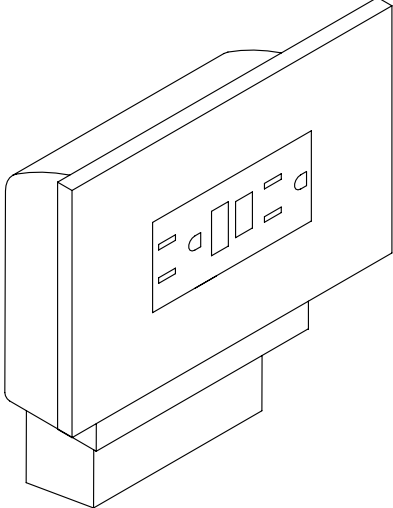NO	PART NUMBER	DESCRIPTION
<u>GFI</u> US	RECEPTACLE 163319-01-CHT BOX 91910-02-000 WIRE-BONDING 133678-03-000 SCREW G13-07-12B (4) CONNECTOR 8313-01-000 TUBING-VINYL 8041-02-000 (300MM) ¹	GFI RECEPTACLE WITH COVER AND BOX FOR US APPLICATION 
<u>GFI</u> CAN	RECEPTACLE 163319-01-CHT BOX 91910-01-000 WIRE-BONDING 133678-03-000 SCREW G13-07-12B (4) CONNECTOR 8313-01-000 TUBING-VINYL 8041-02-000 (300MM) ¹	GFI RECEPTACLE WITH COVER AND BOX FOR CANADA APPLICATION 

RECEPTACLE PACKAGE-GFI

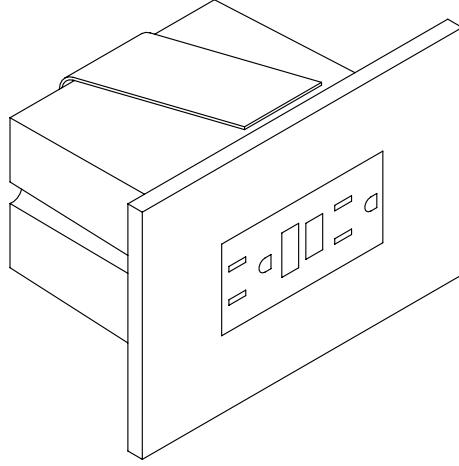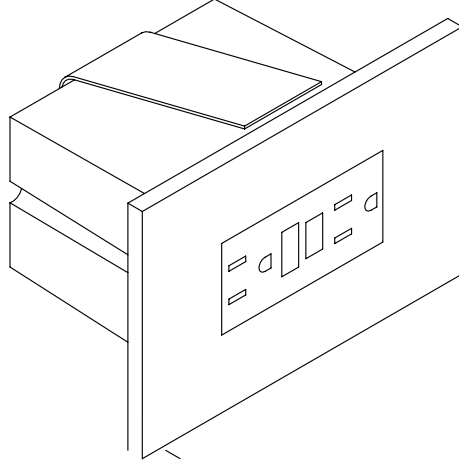
NO	PART NUMBER	DESCRIPTION
<u>GFI-1</u> US	RECEPTACLE 163319-01-CHT BOX 133070-01-000 WIRE-BONDING 133678-03-000 SCREW G13-07-12B (4) CONNECTOR 8313-01-000 TUBING-VINYL 8041-02-000 (300MM) ¹	GFI RECEPTACLE WITH COVER AND BOX FOR US APPLICATION 
<u>GFI-1</u> CAN	RECEPTACLE 163319-01-CHT BOX 133070-02-000 WIRE-BONDING 133678-03-000 SCREW G13-07-12B (4) CONNECTOR 8313-01-000 TUBING-VINYL 8041-02-000 (300MM) ¹	GFI RECEPTACLE WITH COVER AND BOX FOR CANADA APPLICATION 

SPACERS

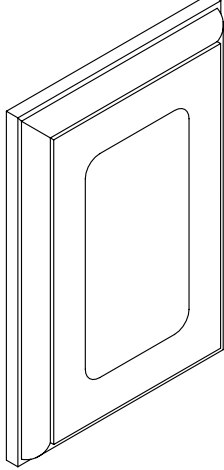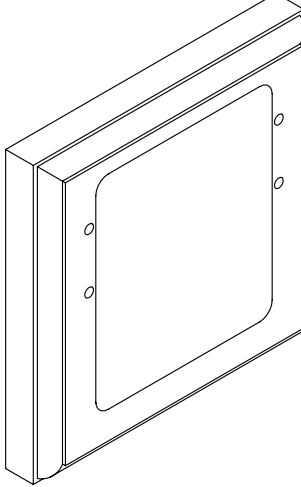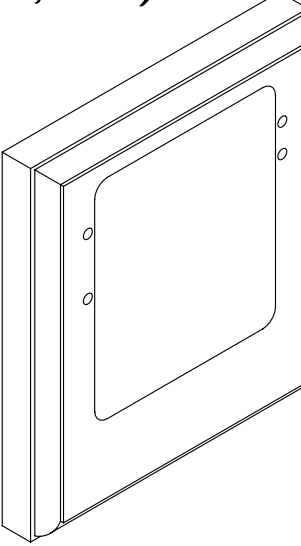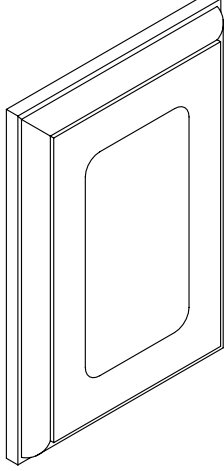
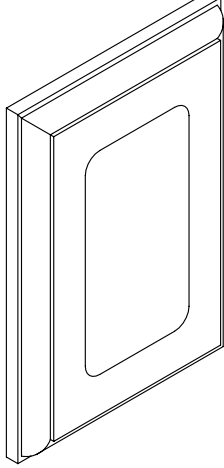
NO	PART NUMBER	DESCRIPTION
SP-01	SPACER 102568-01-XXX	STANDARD 110V RECEPTACLE SPACER (WOOD,VYL RAP,OG) 
SP-02	SPACER 102568-02-XXX	WOOD SPACER FOR CEILING MOUNTED A/C PREP BOX (US) (WOOD,VYL RAP,OG) 
SP-03	SPACER 102568-03-XXX	WOOD SPACER FOR CEILING MOUNTED A/C PREP BOX (CANADA) (WOOD,VYL RAP,OG) 
SP-04	SPACER 133713-01-CHT	STANDARD 110V RECEPTACLE SPACER (WOOD,VYL RAP,BEV) 
SP-05	SPACER 133713-20-XXX	STANDARD 110V RECEPTACLE SPACER (WOOD,BEV) 

SP-21

SPACER
126052-01-XXX

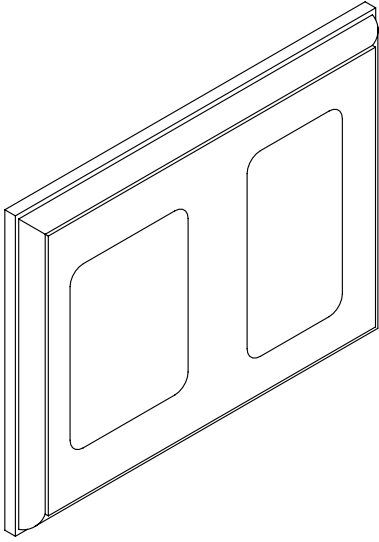WOOD SPACER FOR 1 - 110V
RECEPTACLE AND 1 - REAR TV
(12V) JACK
(WOOD,BEV)


LEGEND

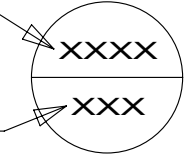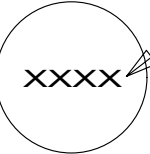MISC.	SPACER
PART NUMBER LISTING 	 PART NUMBER

NOTES:

1

APPLY TUBING TO BARE GROUND WIRES.

FIRST USED

96 MH'S

DO NOT SCALE DRAWING

TITLE:

PART LISTING-ELECTRICAL

SHEET 6

PART NO121339

REV

2/17/2010

87654321

D

C



B

A


1

DWG NO121339


PREP-A/C, RECESSED (W/OUT FACTORY A/C)

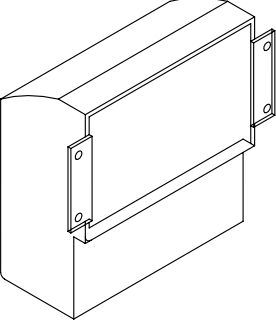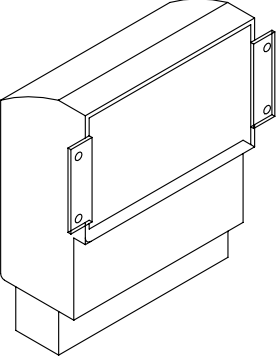NO	PART NUMBER	DESCRIPTION
PREP A/C-US	BOX 91910-02-000 COVER 84099-02-CHT LABEL 91243-01-000 SCREW G13-07-12B (4) CONNECTOR 8313-01-000 (3)	BOX AND EQUIPMENT USED FOR A/C PREP (W/OUT FACTORY A/C). US APPLICATION (RECESSED IN ROOF) 
PREP A/C-CAN	BOX 91910-01-000 COVER 84099-02-CHT LABEL 91243-01-000 SCREW G13-07-12B (4) CONNECTOR 8313-01-000 (3)	BOX AND EQUIPMENT USED FOR A/C PREP (W/OUT FACTORY A/C). CANADA APPLICATION (RECESSED IN ROOF) 


CONNECTION BOX-POWER CORD

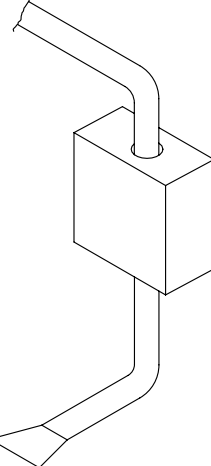NO	PART NUMBER	DESCRIPTION
J-PC 30	BOX 8289-01-000 COVER 8294-01-000 SCREW G67-10-10B (2) WIRE ASM-GROUND 133678-02-000 CONNECTOR 8314-01-000 (3) CONNECTOR 8356-02-000 CONNECTOR (PC) 8355-01-000	CONNECTION BOX IN POWER CORD COMPT FOR POWER CORD (US & CA APPLICATION) 
J-PC 30-US		
J-PC 30-CA		


CONNECTION BOX-GENERATOR RECEPTACLE

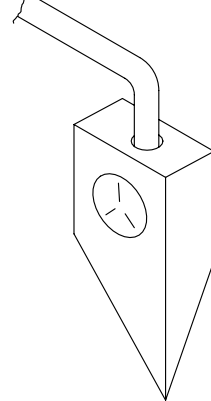NO	PART NUMBER	DESCRIPTION
J-RCP 30	BOX 8289-01-000 RECEPTACLE 24924-02-000 COVER 69238-01-000 SCREW G67-10-10B (2) WIRE ASM-GROUND 133678-02-000 133678-04-000 CONNECTOR 8314-01-000 TUBING-VINYL 8041-02-000 (150MM)	CONNECTION BOX IN POWER CORD COMPT FOR THE GENERATOR RECEPTACLE (US & CA APPLICATION) 
J-RCP 30-US		
J-RCP 30-CA		

CONNECTION BOX, GENERATOR SERVICE FEED

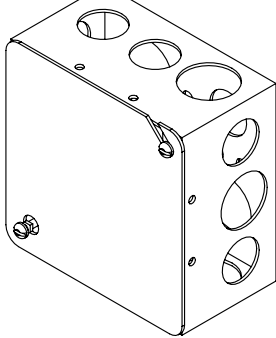NO	PART NUMBER	DESCRIPTION
J-GEN 30	BOX 8289-01-000 COVER 8294-01-000 SCREW G67-10-10B (2) WIRE ASM-GROUND 133678-02-000 WIRE NUT-GREY 8314-01-000 (3) CONNECTOR-WIRE 8356-01-000	BOX AND EQUIPMENT USED FOR CONNECTING THE GENERATOR LEADS TO THE SERVICE ENTRANCE WIRES (US & CA APPLICATION) 
J-GEN 30-US		
J-GEN 30-CA		

PREP-A/C, SURFACE (W/OUT FACTORY A/C)

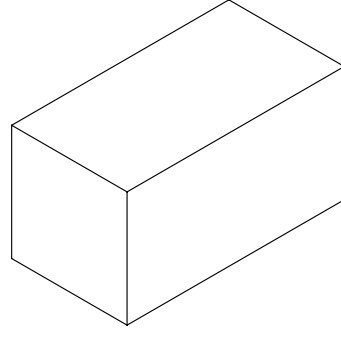NO	PART NUMBER	DESCRIPTION
PREP SURF	BOX 93603-01-000 COVER 53337-01-000 LABEL 91243-01-000 WIRE-BONDING 8019-01-000 SCREW G11-08-12B (2) TERMINAL 8328-01-000 CONNECTOR 8313-01-000 (2) CONNECTOR 8311-01-000	SURFACE MOUNT, US AND CANADA, BOX AND EQUIPMENT FOR A/C PREP (W/OUT FACTORY A/C). TYPICALLY LOCATED ON OVERHEAD CABINET INNER WALL OR ON CEILING. 

LEGEND

PART NUMBER

LISTING

XXXX

XX

NOTES:

1 APPLY TUBING TO BARE GROUND WIRES.

FIRST USED

96 MH'S

DO NOT SCALE DRAWING

TITLE: PART LISTING-ELECTRICAL

SHEET 7


PART NO 121339

REV

87654321

1

2/17/2010

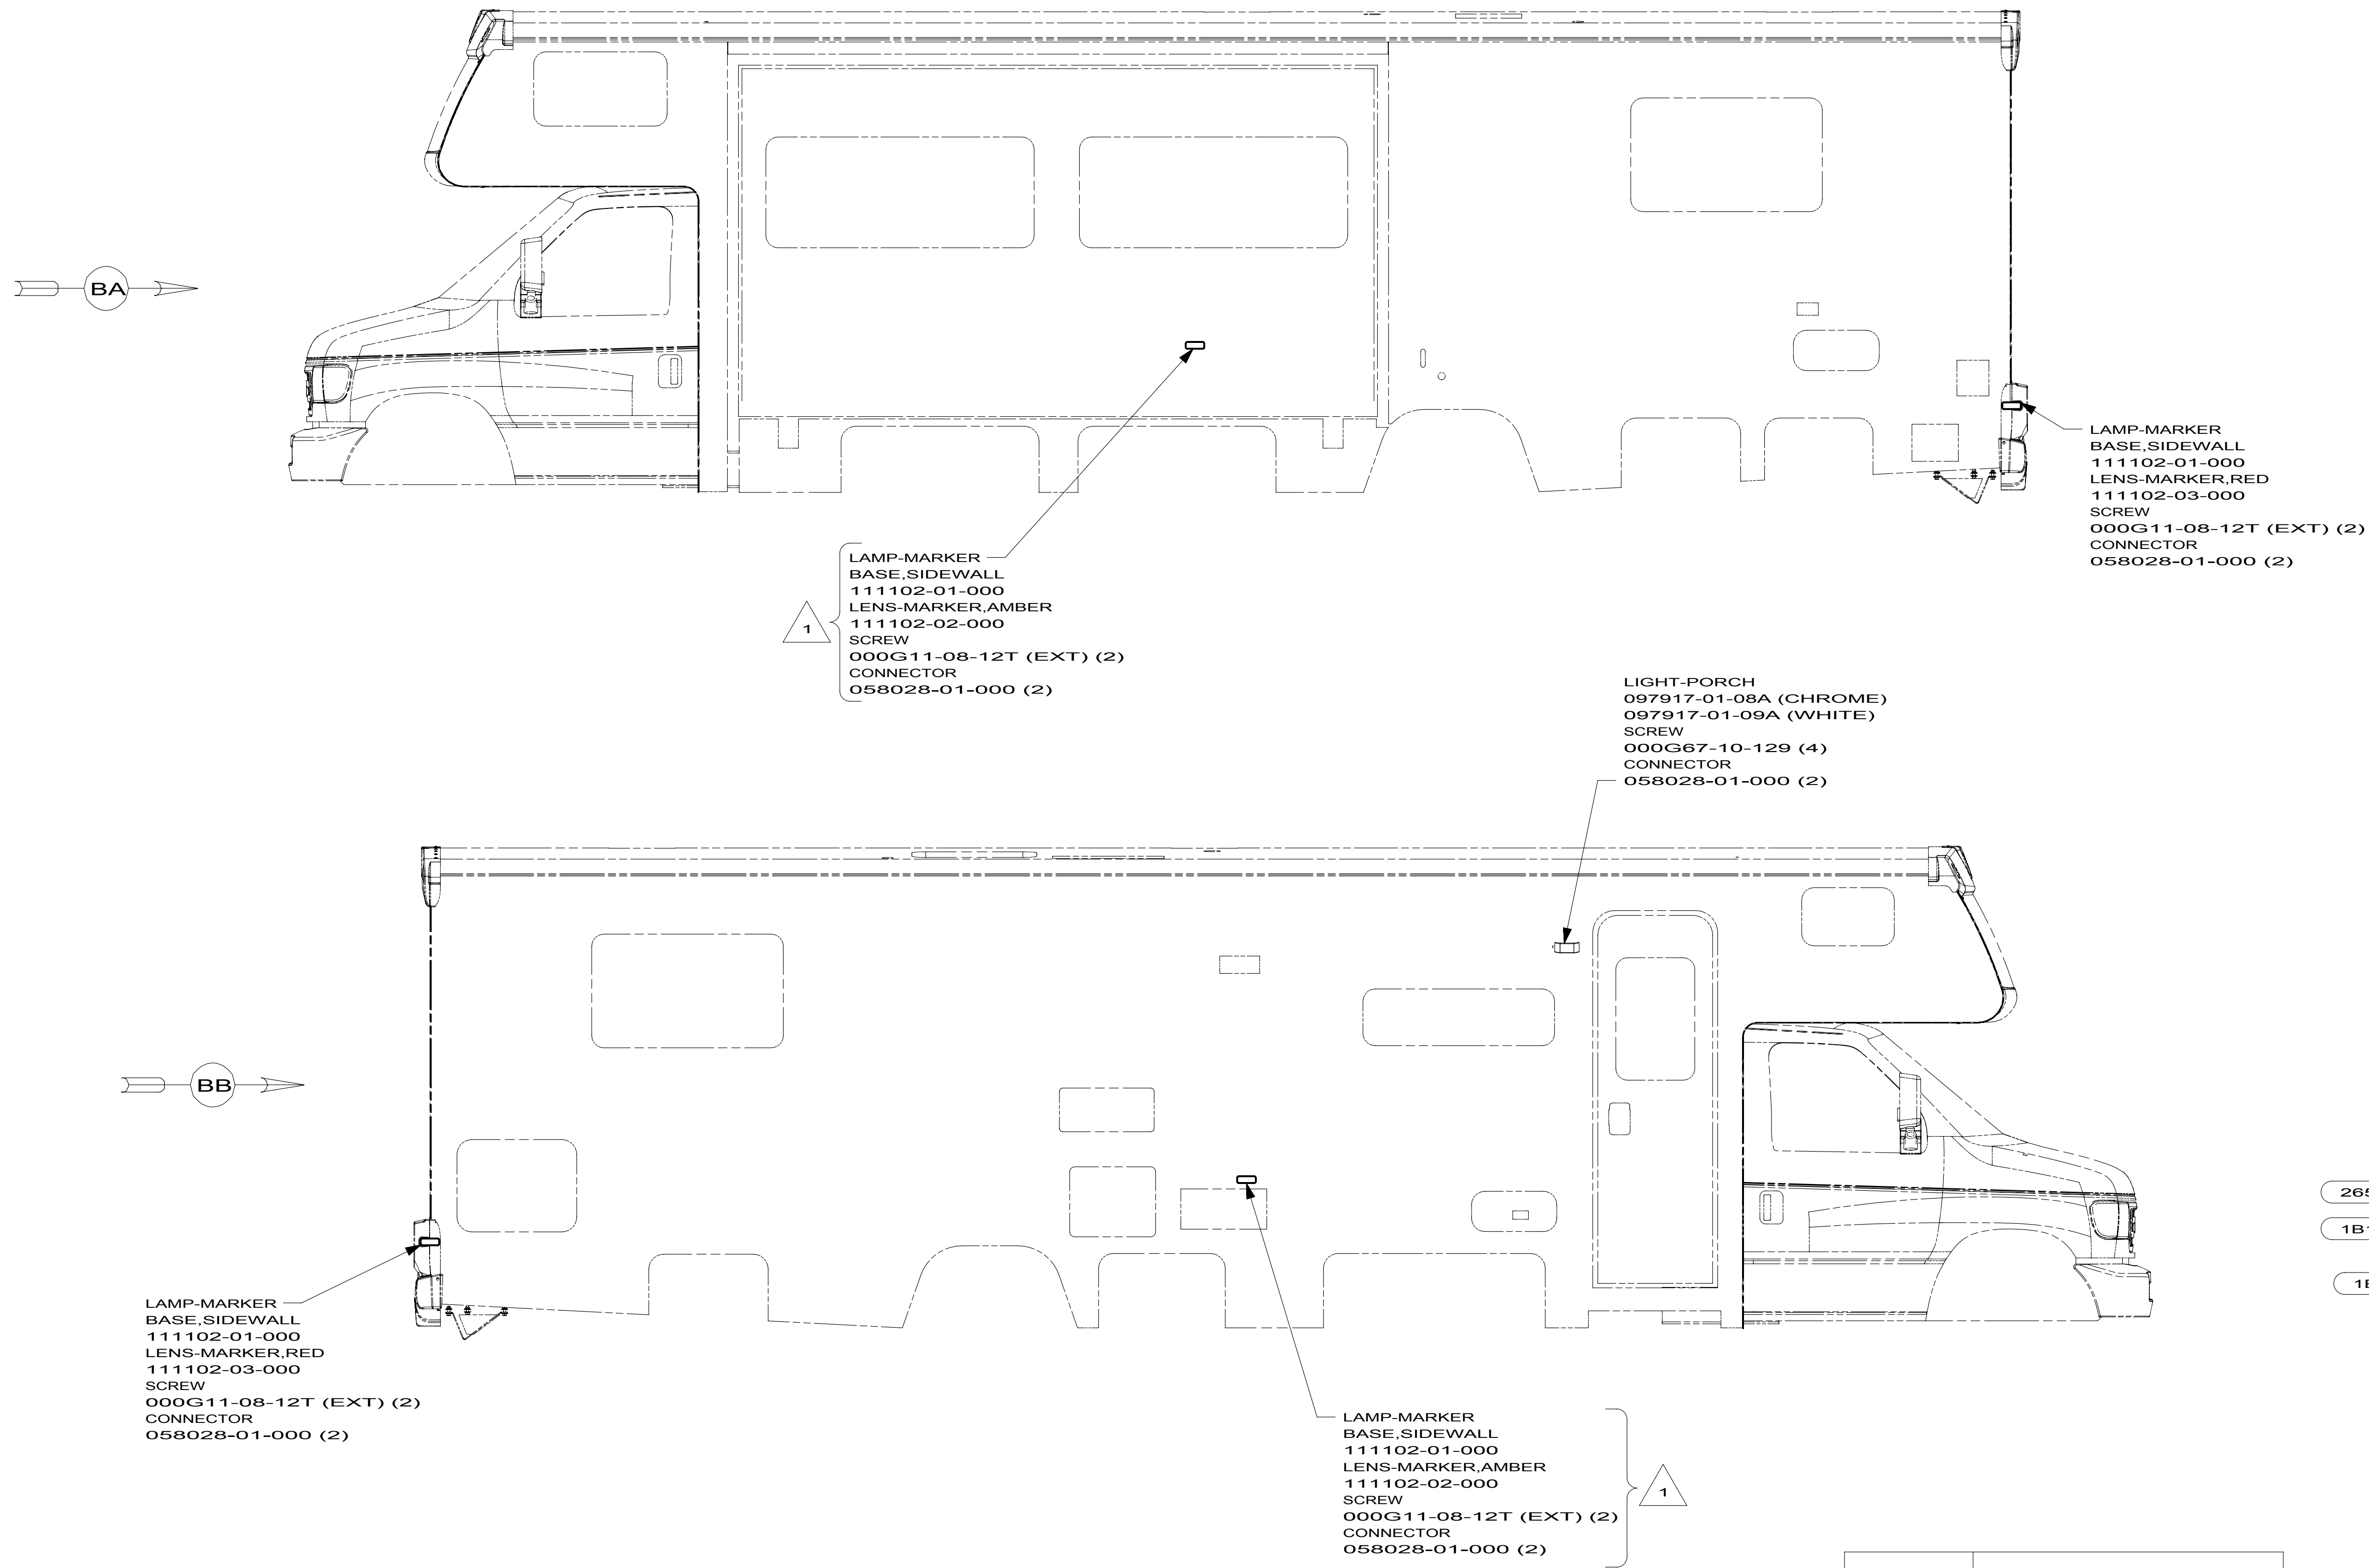

265 CODES/STANDARDS-CSA/CMVSS

1B1 CODES/STANDARDS USA

1B1 265

10 300-SERIES

FOR ELECTRICAL
TORQUE
SPECIFICATIONS
SEE DWG NO.
128783-01-000

X-X


FOR
ELECTRICAL
CALLOUTS
SEE DWG NO.
121339-01-000

WIRING INSTL-EXTERIOR LAMPS


1 2 170531

1 USED ONLY WITH 329B, 331C, 330D.

NOTES:

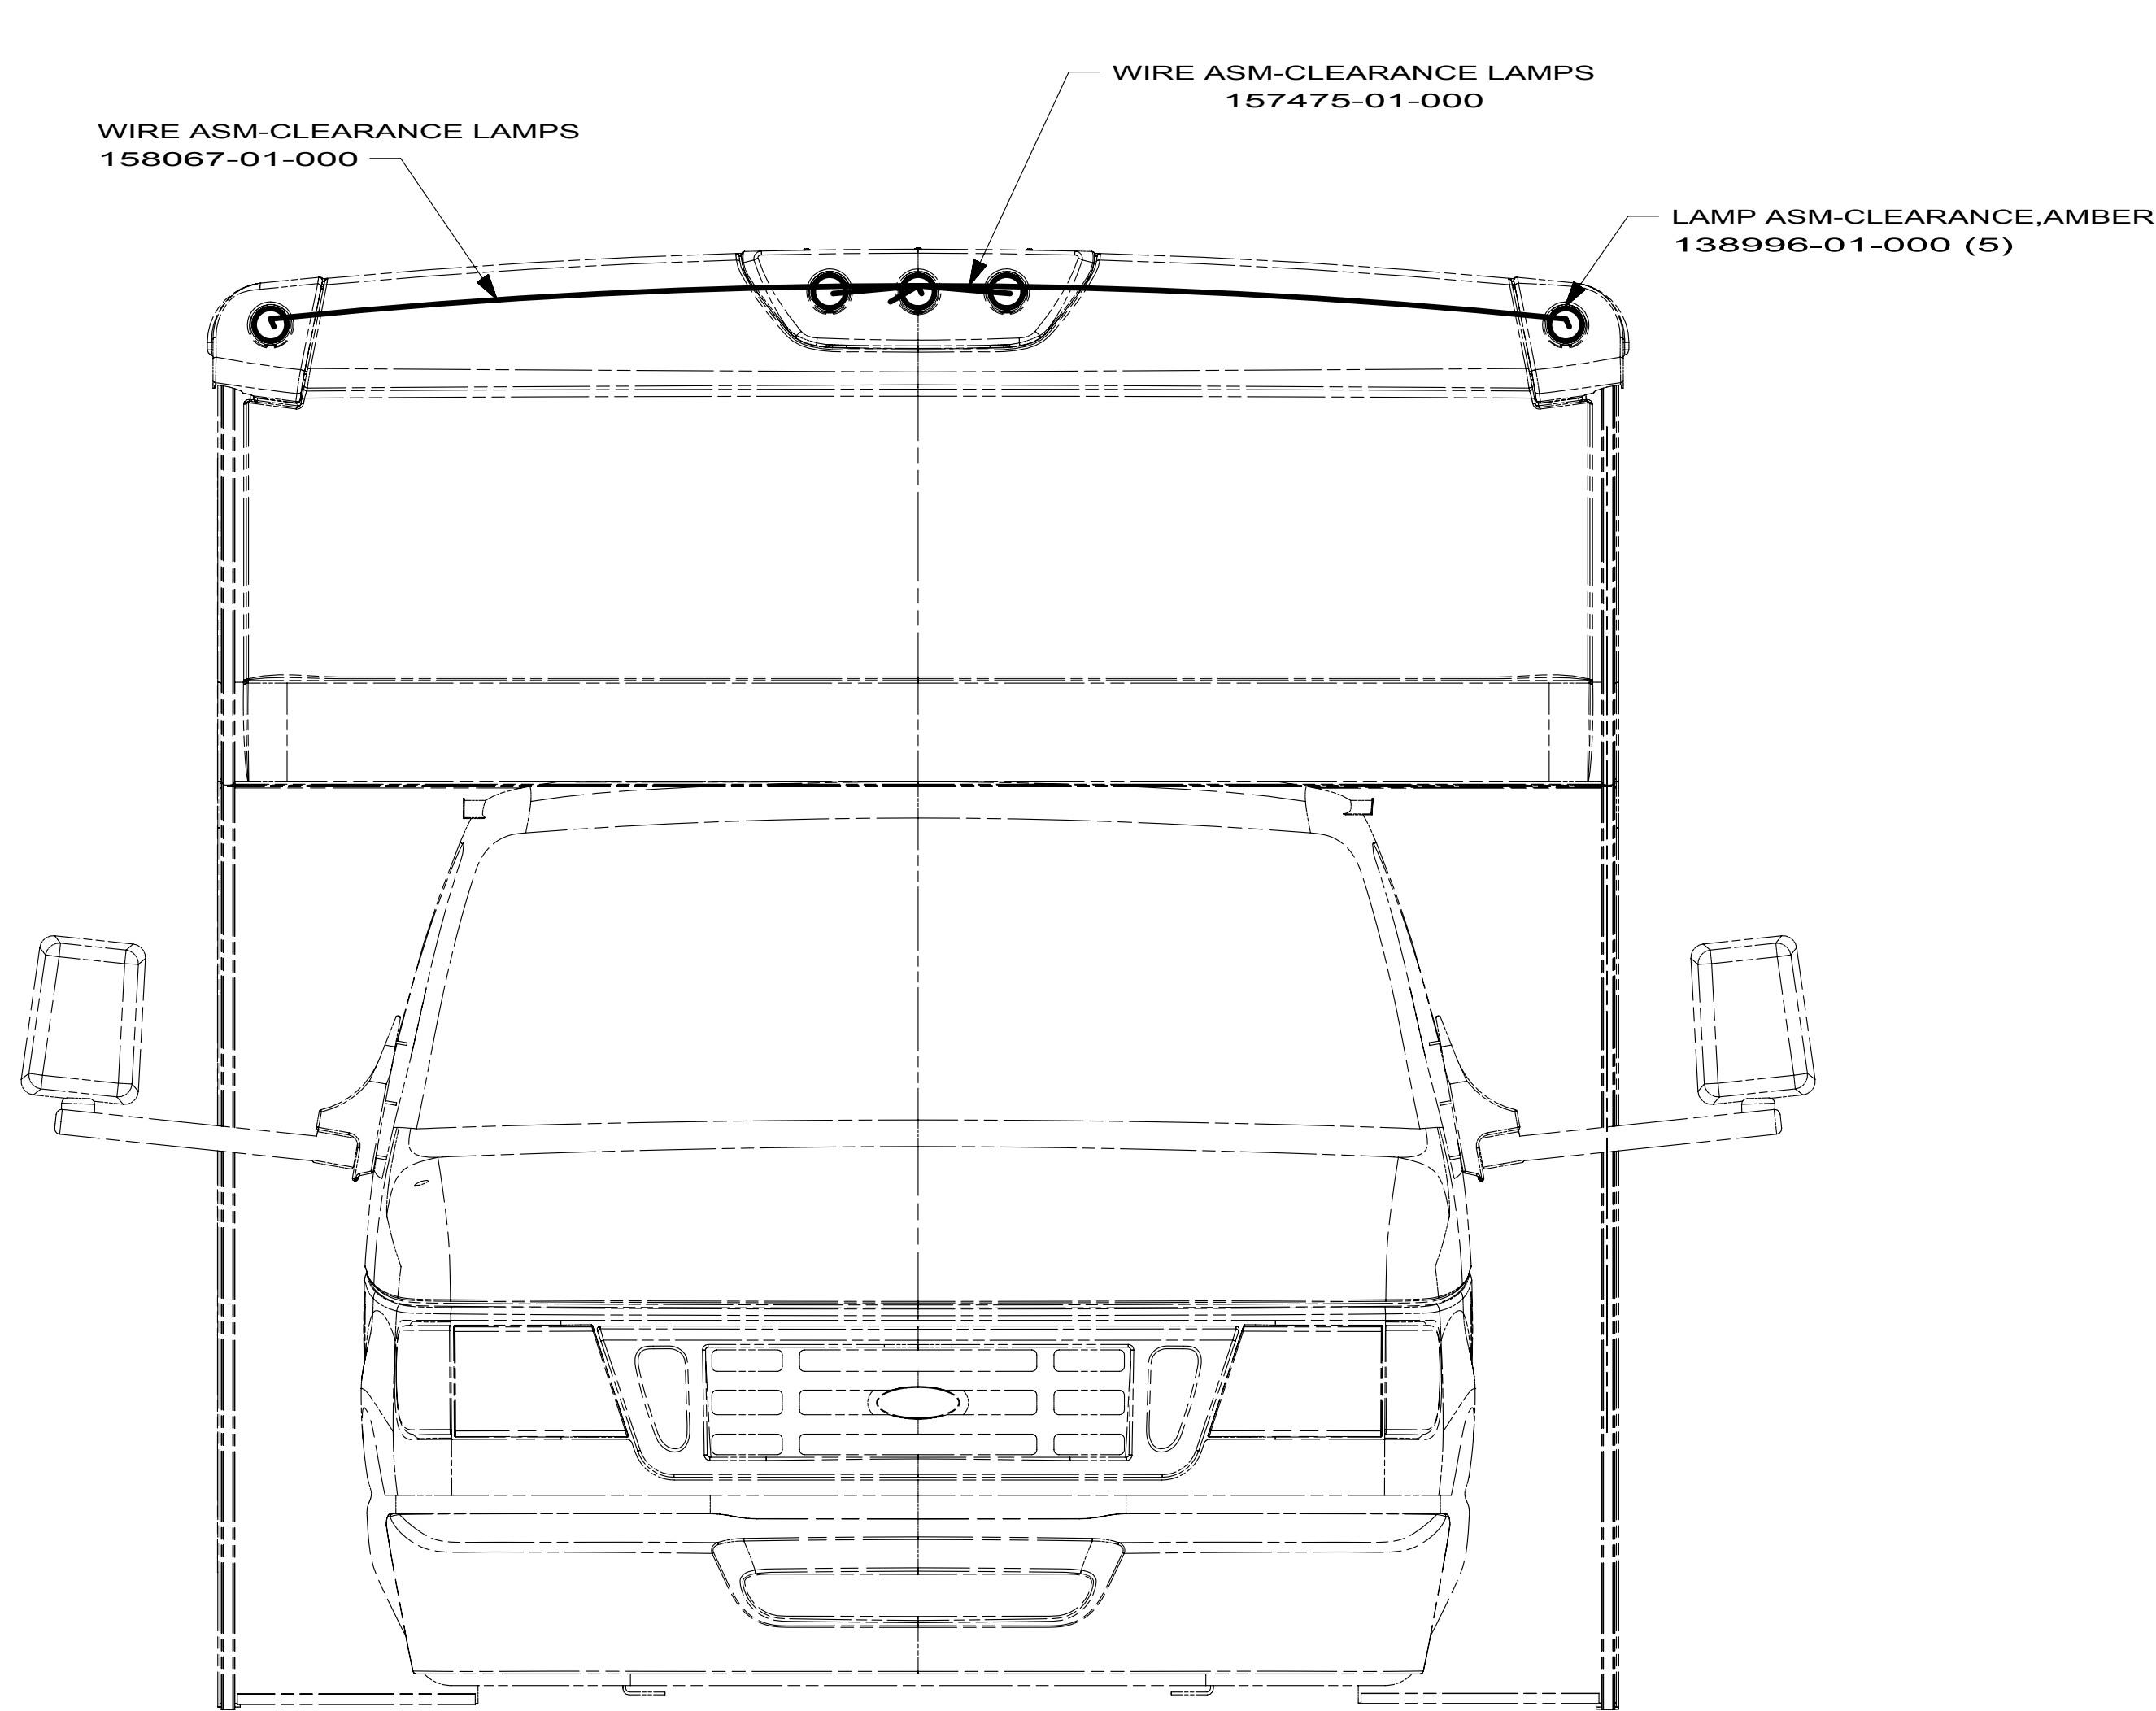

VIEW BA

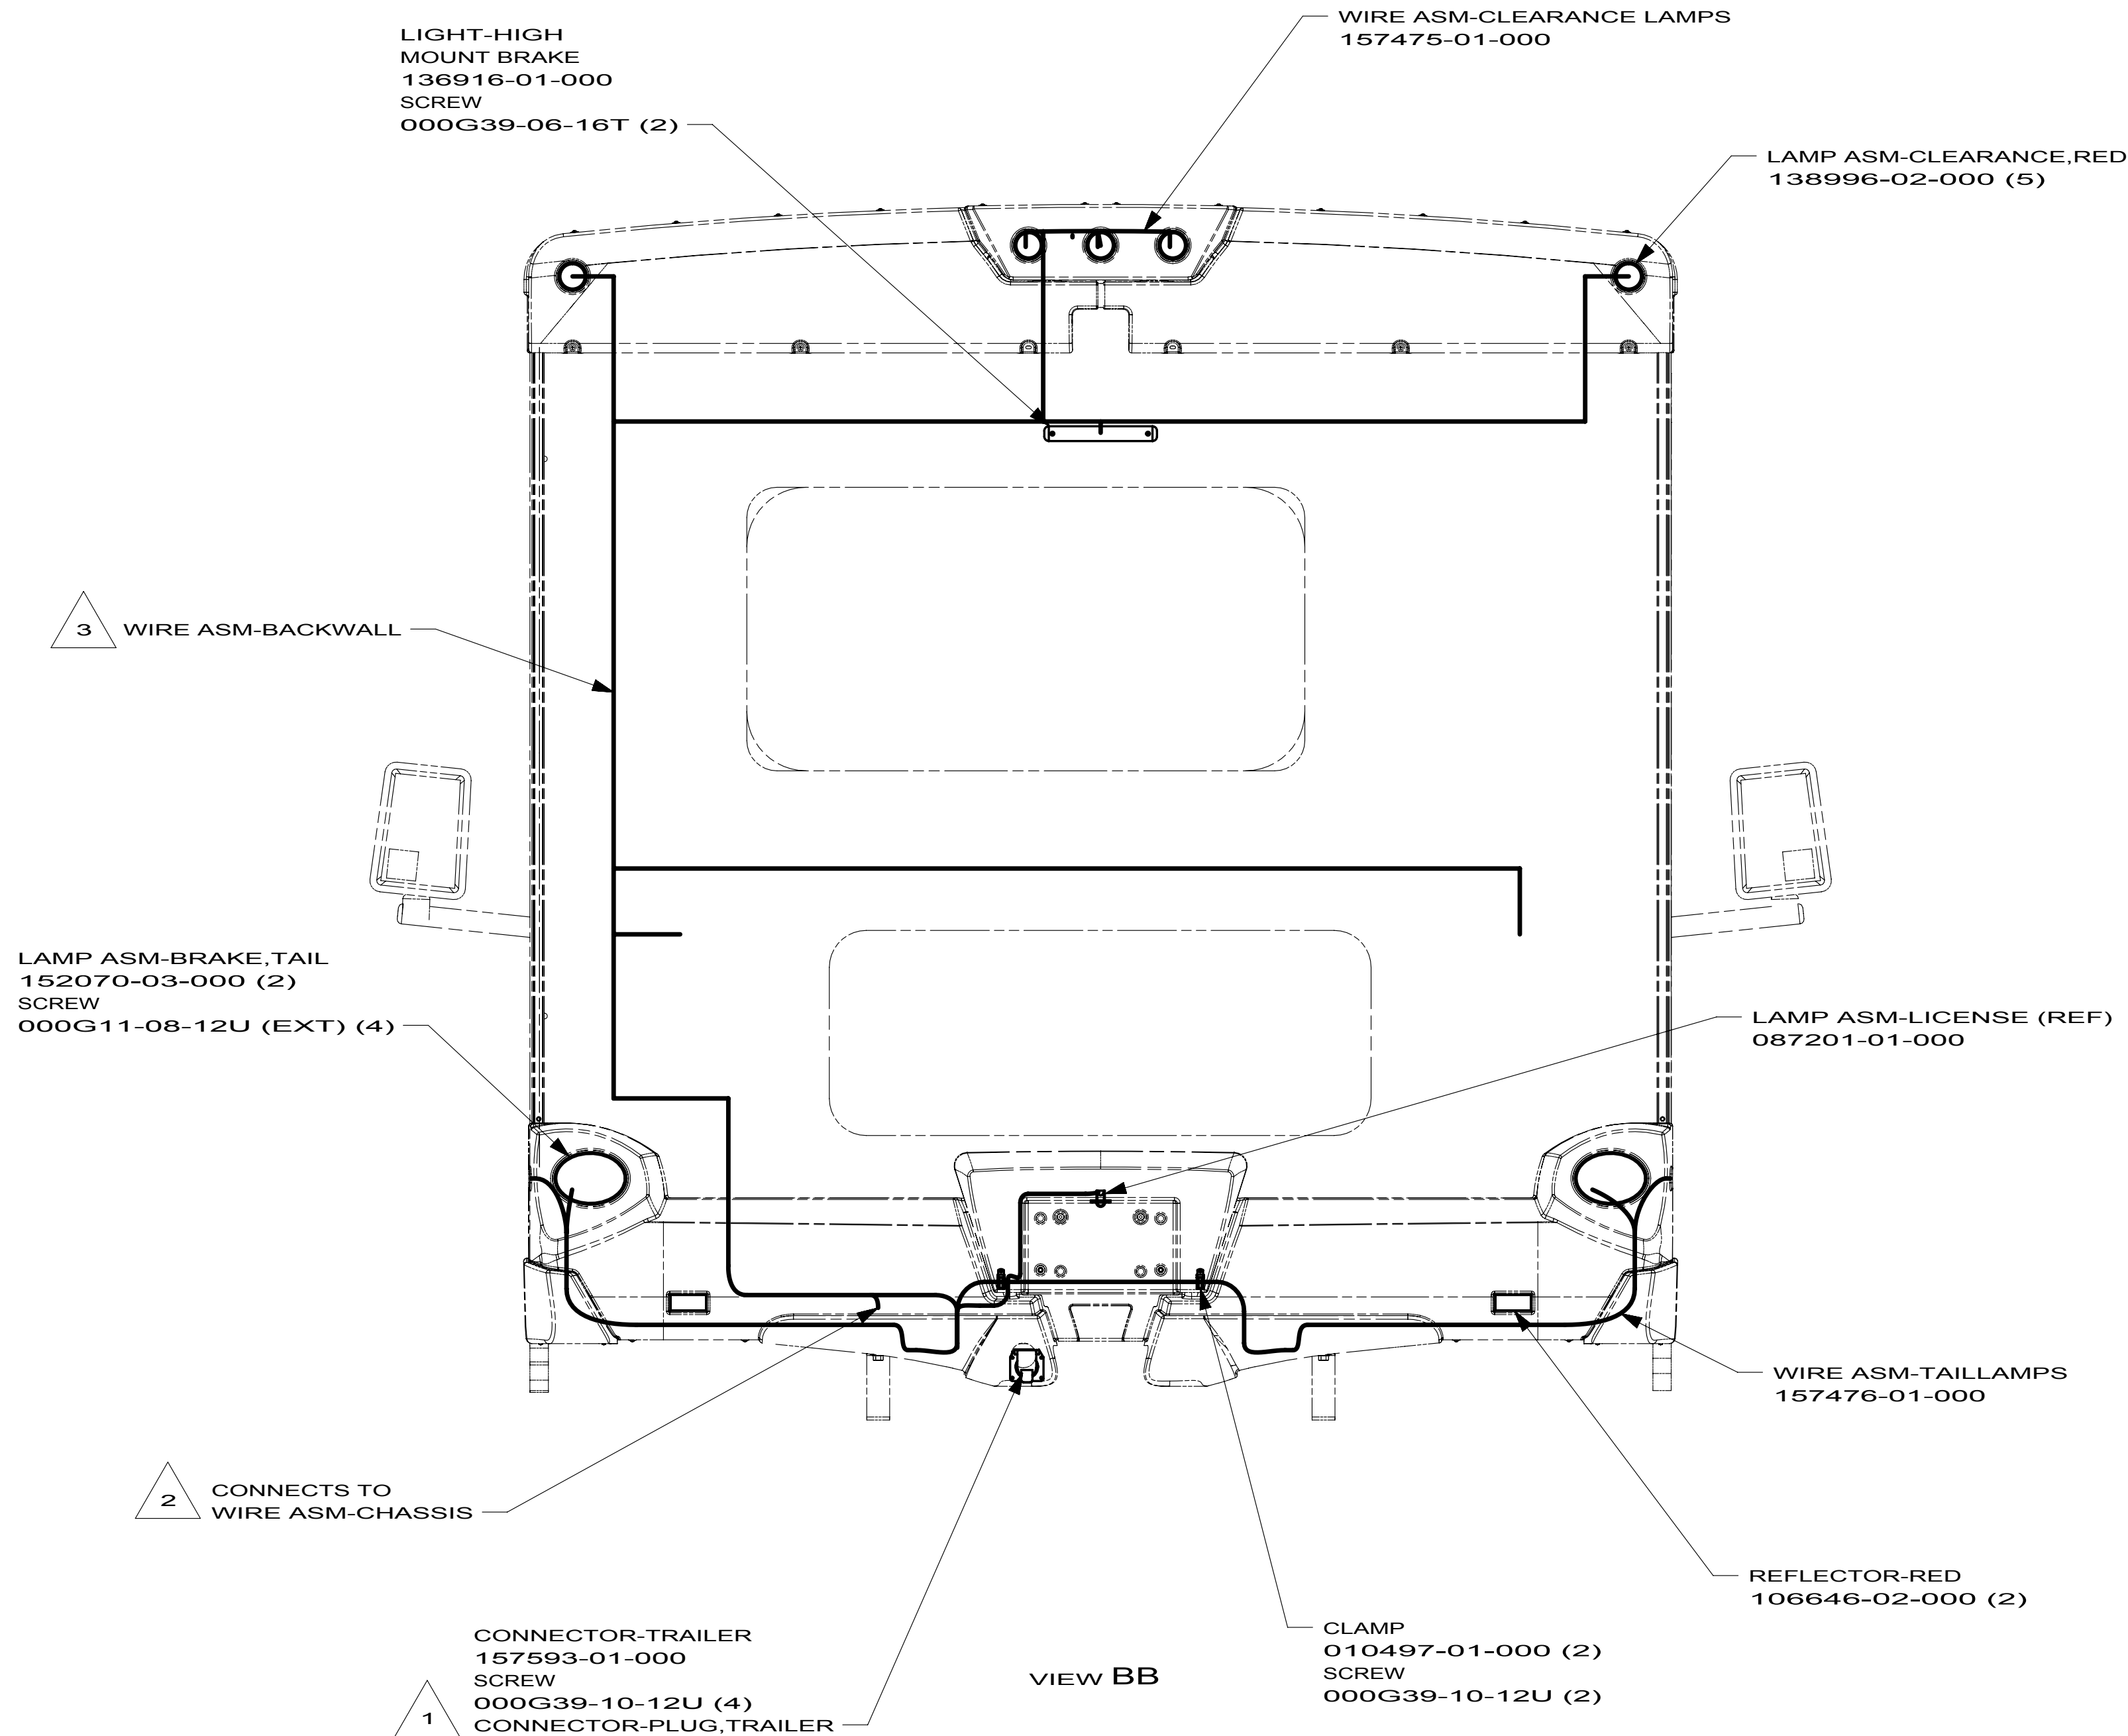

VIEW BB

- 3 LOCATED IN BACKWALL ASM.
- 2 SECURE WIRE ASM-CHASSIS BELOW COACH WITH CLAMP
010495-01-000 AND SCREW 000G67-10-12B AS NEEDED.
- 1 CONNECTOR-PLUG, TRAILER 146246-01-000 TO BE SUPPLIED
LOOSE IN COACH WITH TRAILER TOW PACKAGE.

NOTES:

- 265 CODES/STANDARDS-CSA/CMVSS
- 1B1 CODES/STANDARDS USA
- 1B1 265

10 300-SERIES


WIRING INSTL-EXTERIOR LAMPS

FOR ELECTRICAL TORQUE SPECIFICATIONS SEE DWG NO. 128783-01-000	X-X	FOR ELECTRICAL CALLOUTS SEE DWG NO. 121339-01-000
--	-----	--

KEY	PART NUMBER	U/M	DESCRIPTION
	097917-01-700	EA	LENS-LIGHT, CLEAR

097917-01-08A/09A
VENDOR NO.
30-78-021

300-Series
700-Series
169847-02

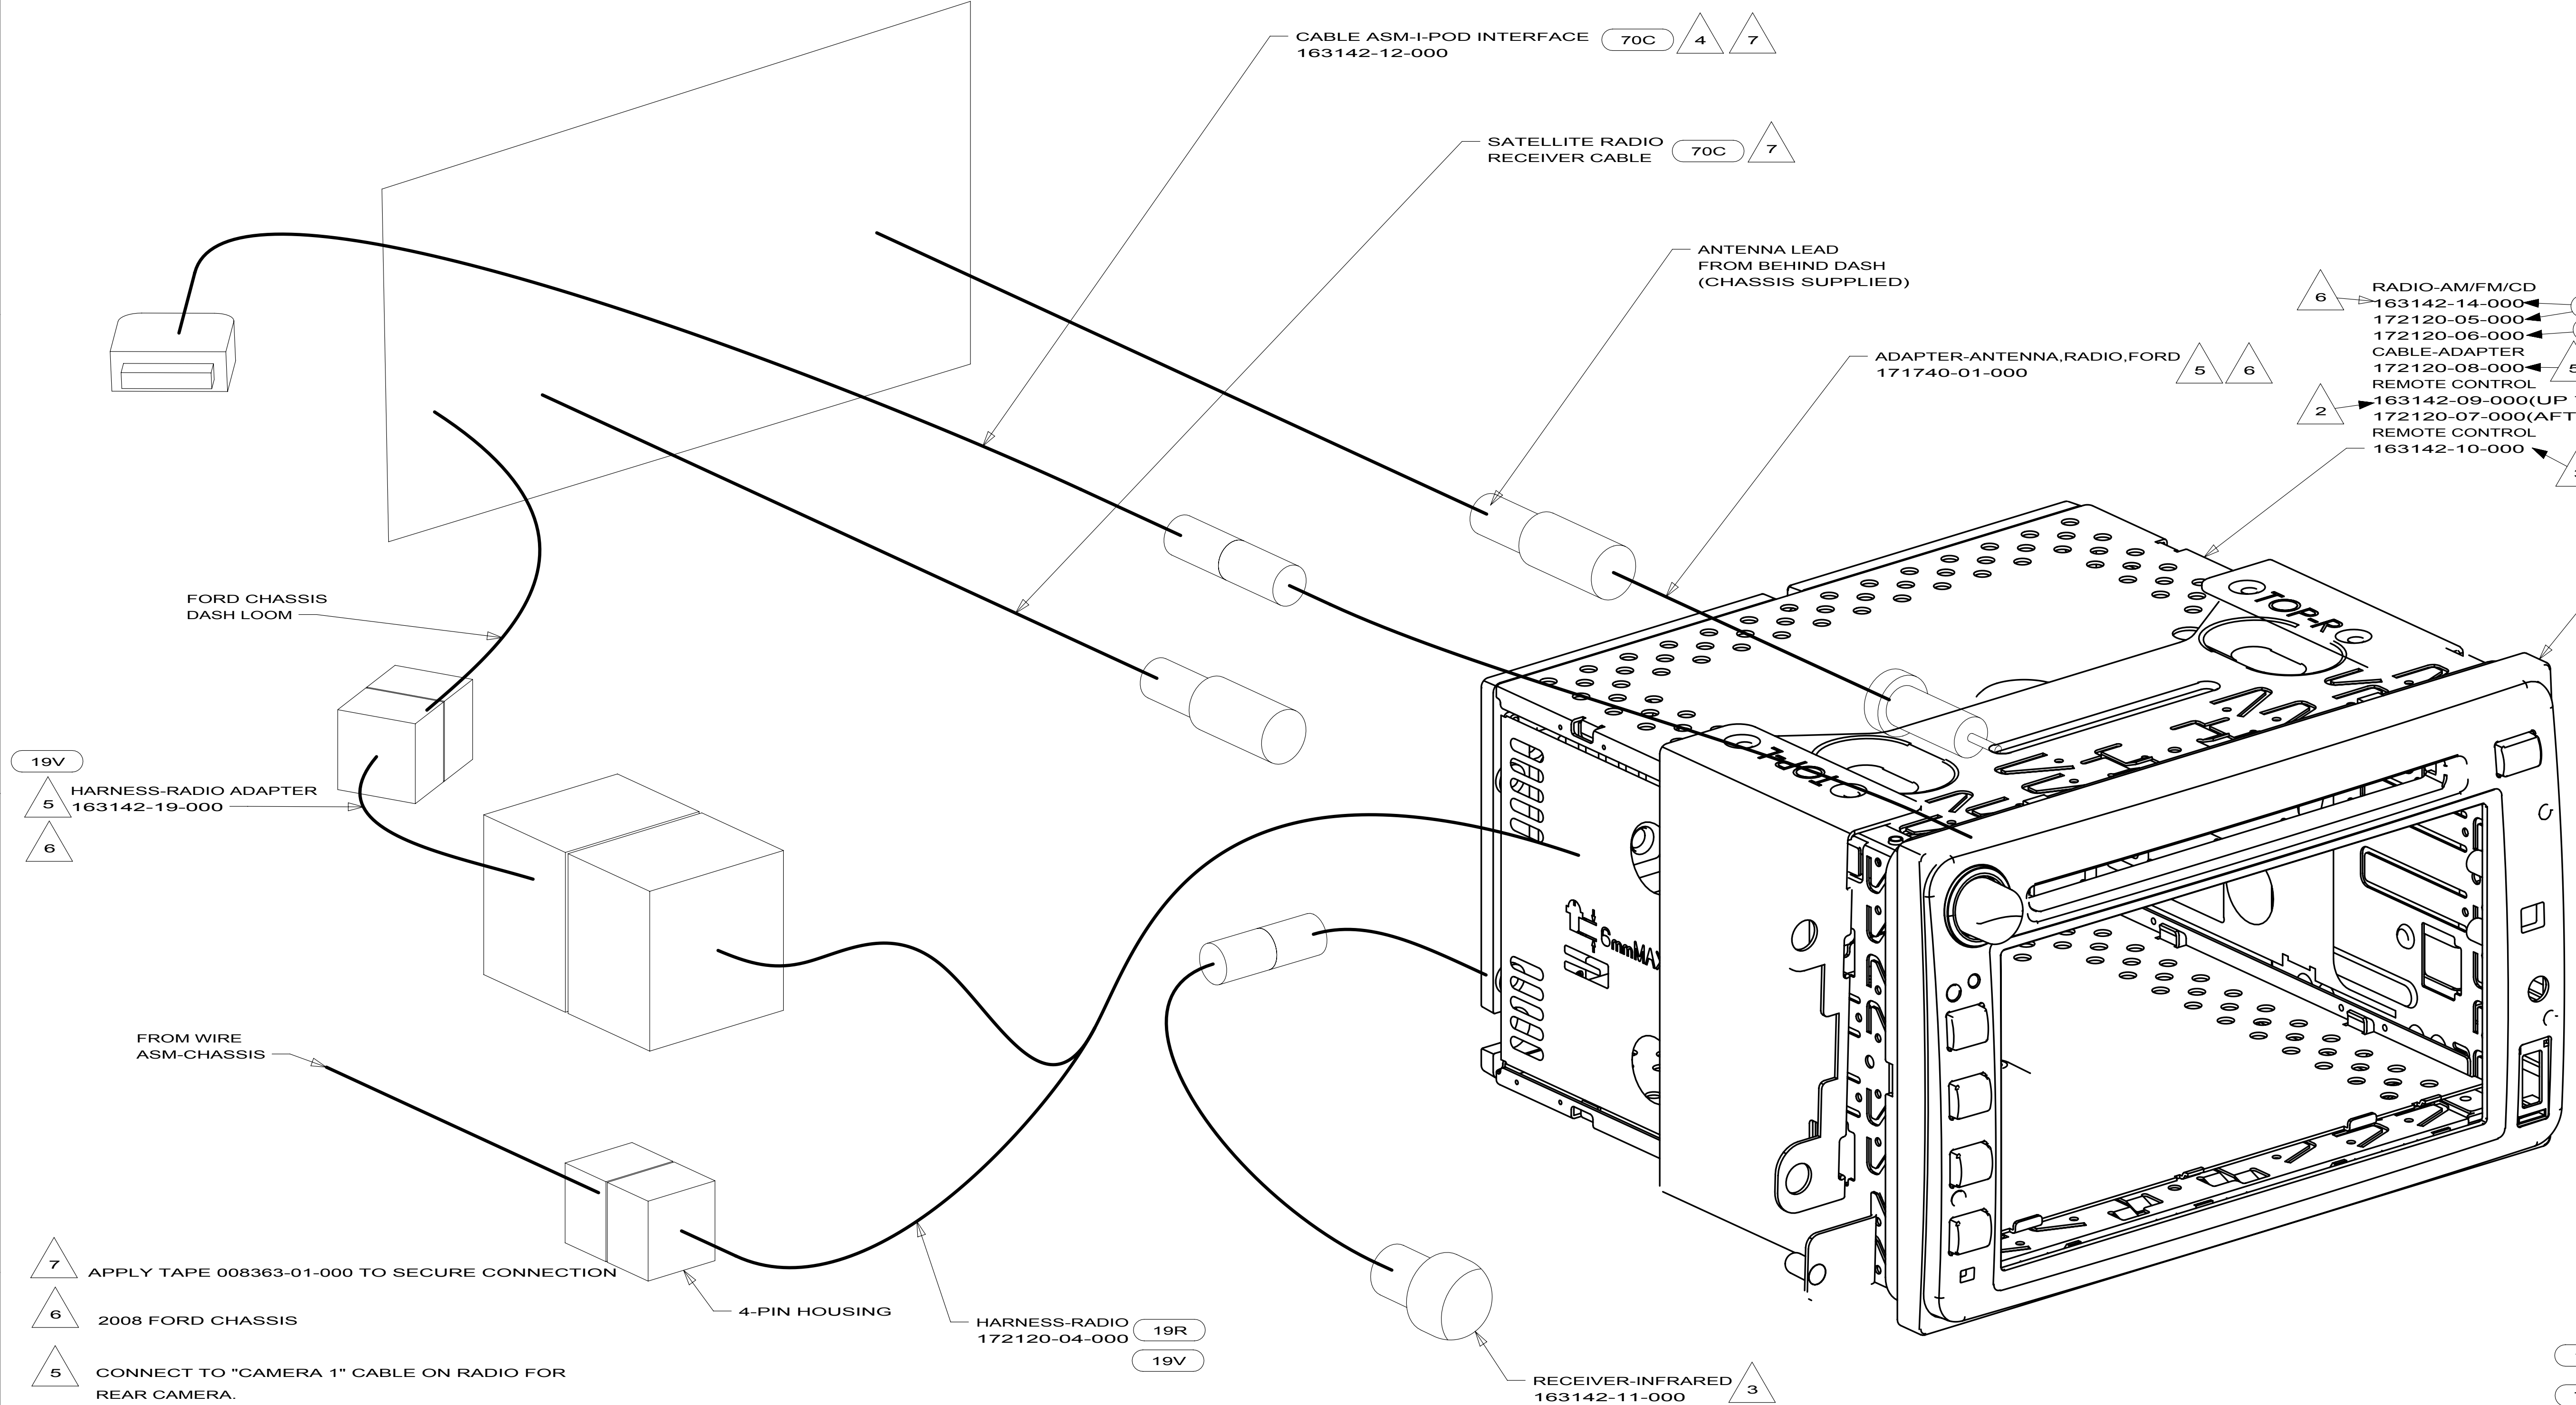

- 7 APPLY TAPE 008363-01-000 TO SECURE CONNECTION
- 6 2008 FORD CHASSIS
- 5 CONNECT TO "CAMERA 1" CABLE ON RADIO FOR REAR CAMERA.
- 4 PLUG I-POD CABLE INTO LEAD ON BACK OF RADIO MARKED 'I-POD'. ROUTE CABLE TO THE LEFT OF RADIO. WIRE TIE EXCESS CABLE UNDER DASH IN THE AREA LEFT OF THE RADIO. LEAVE 200 MM OF CABLE IN THE MOTOR COVER BEVERAGE TRAY. MAKE SURE CABLE DOES NOT GET PINCHED BY MOTOR COVER.
- 3 INSTALL PER DRAWING 170205.
- 2 TO BE SUPPLIED LOOSE IN WINNEBAGO OWNERS CASE.
- 1 ENGAGE T-RAIL ON BOTTOM OF RADIO UNTIL LOCKED IN PLACE.

NOTES:


- 19R RADIO/REARVIEW MONITOR SYS
- 70C RADIO - SATELLITE
- 19V RADIO-AM/FM STEREO CD PLAYER
- 265 CODES/STANDARDS-CSA/CMVSS
- 1B1 CODES/STANDARDS USA

FIRST USED		
300,700-SERIES		
DO NOT SCALE DRAWING		
TITLE:		
RADIO INSTL		
SHEET 2	PART NO 169847	REV



FOR ELECTRICAL
TORQUE
SPECIFICATIONS
SEE DWG NO.
128783-01-000

FOR
ELECTRICAL
CALL-OUTS
SEE DWG NO.
121339-01-000

1L9 300-SERIES
(UP TO 05-31-09)

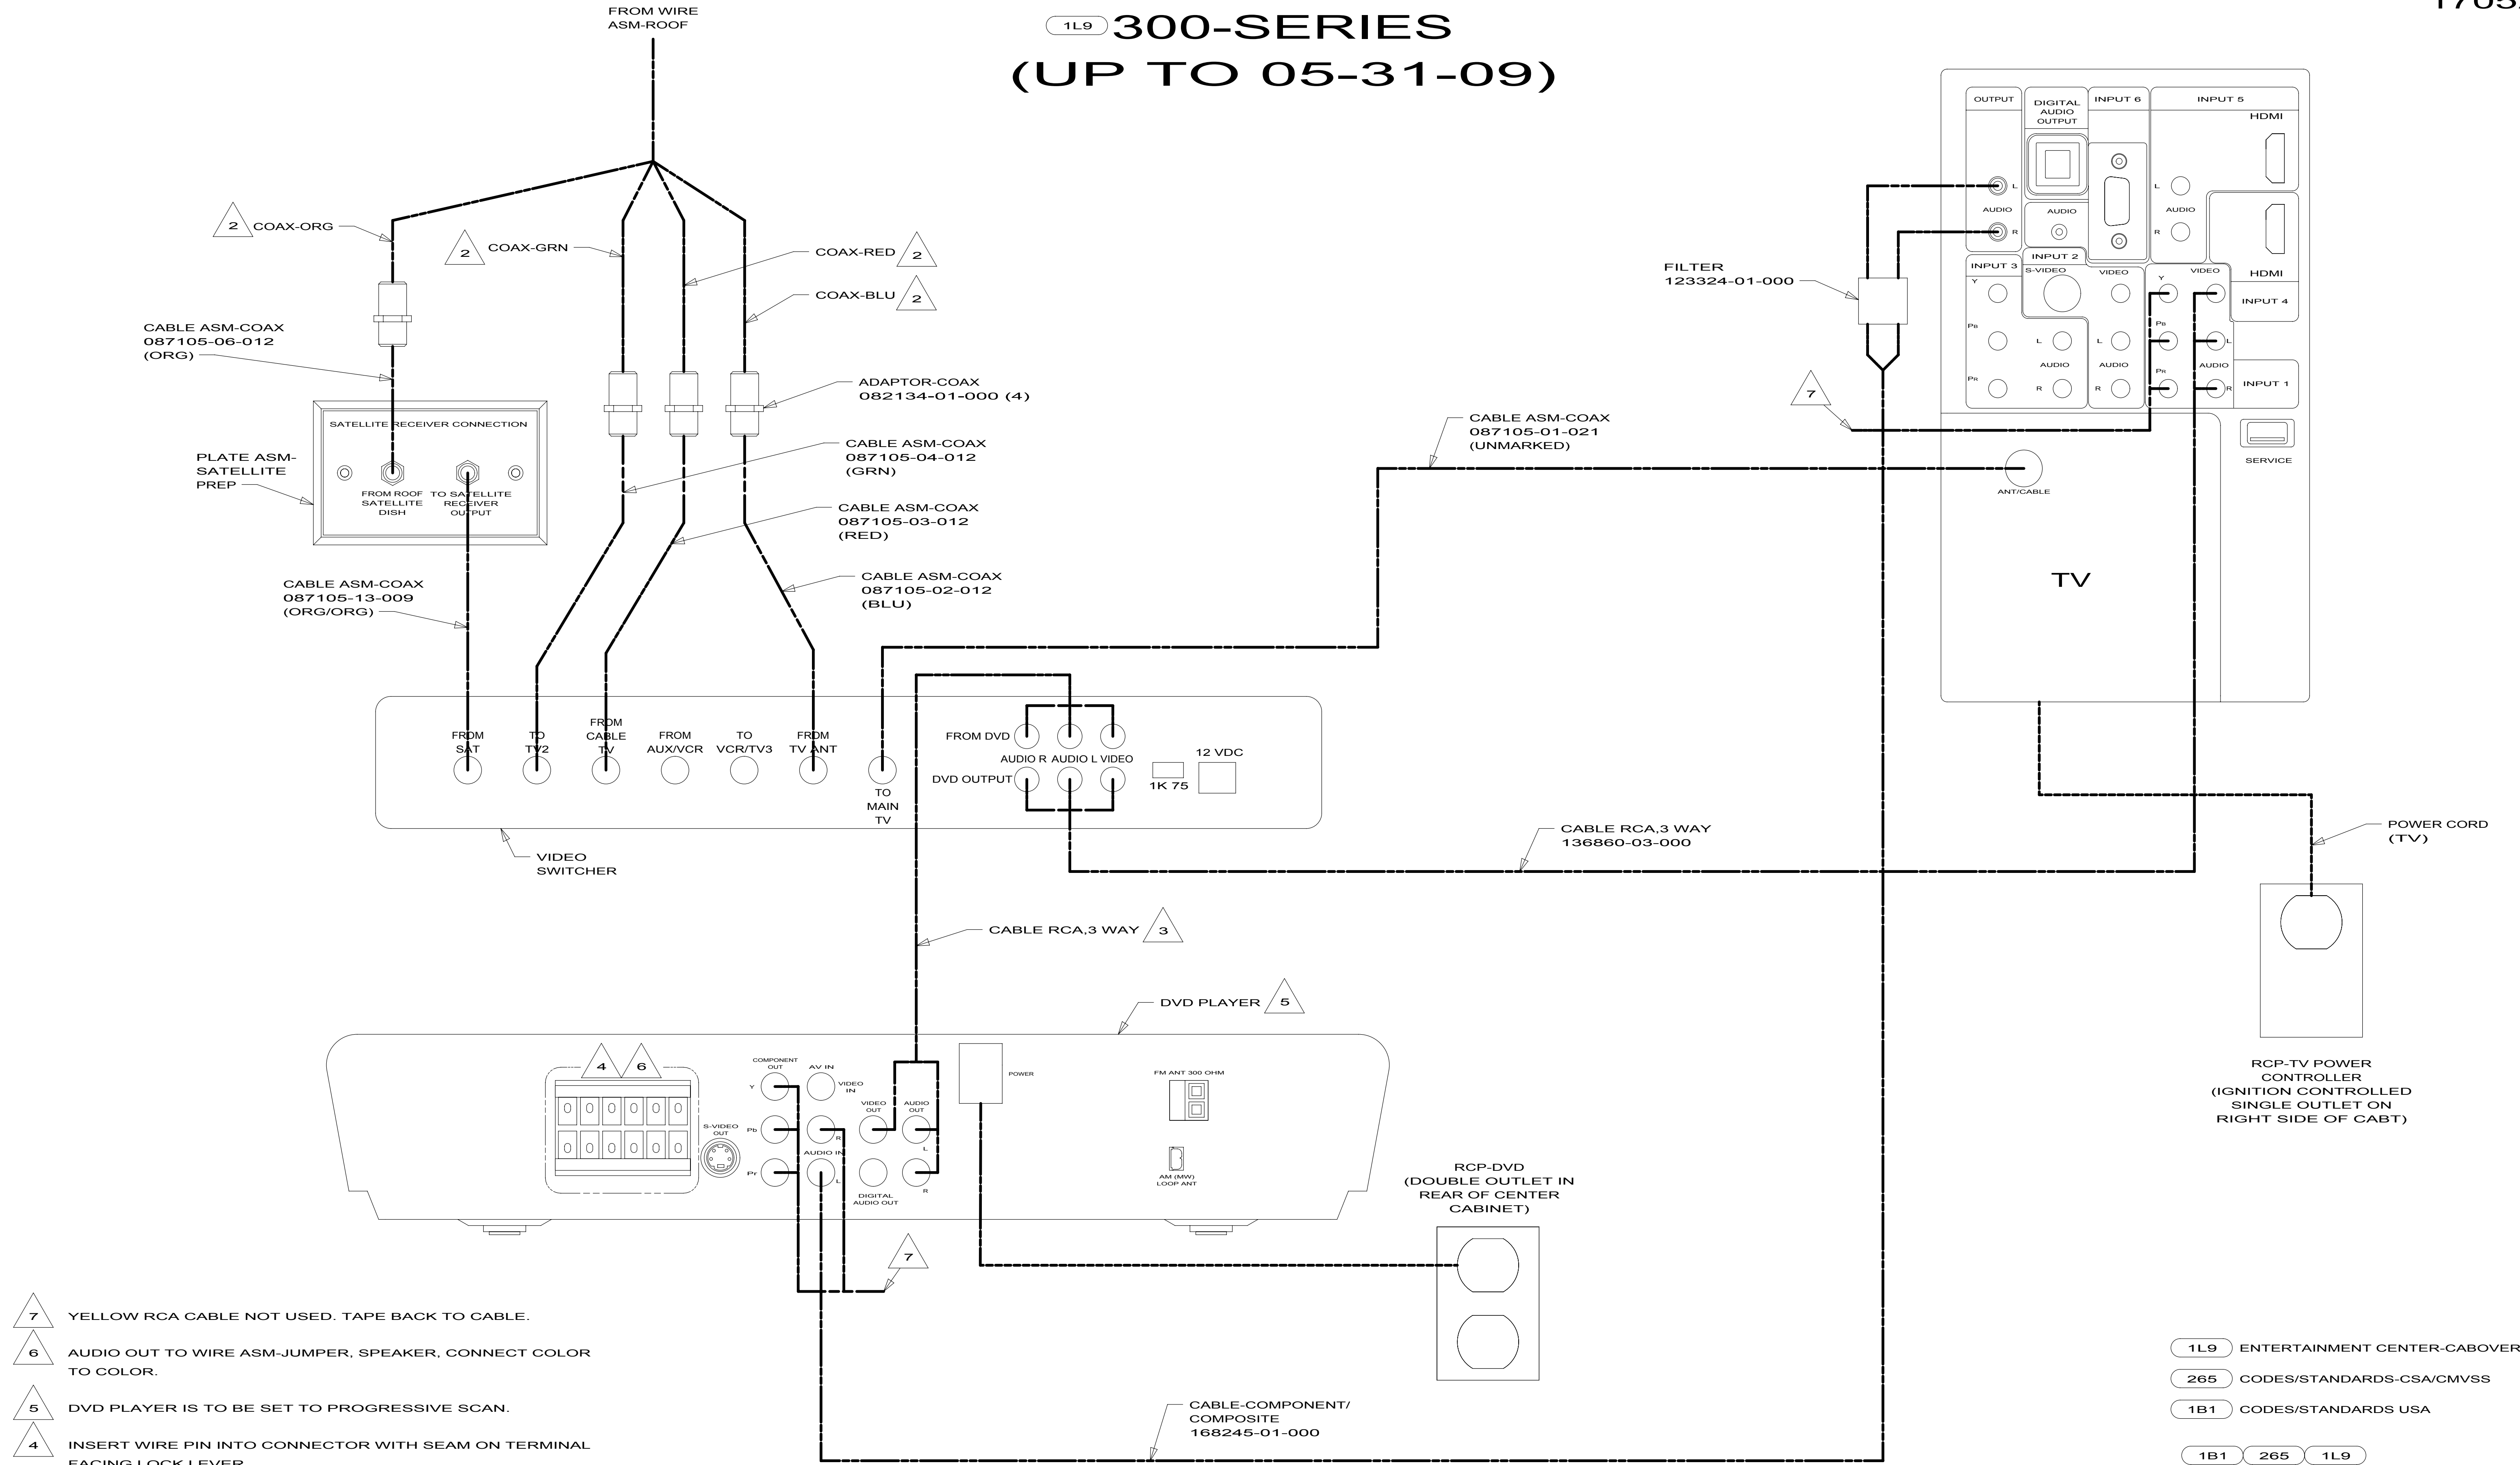

1MK 300-SERIES

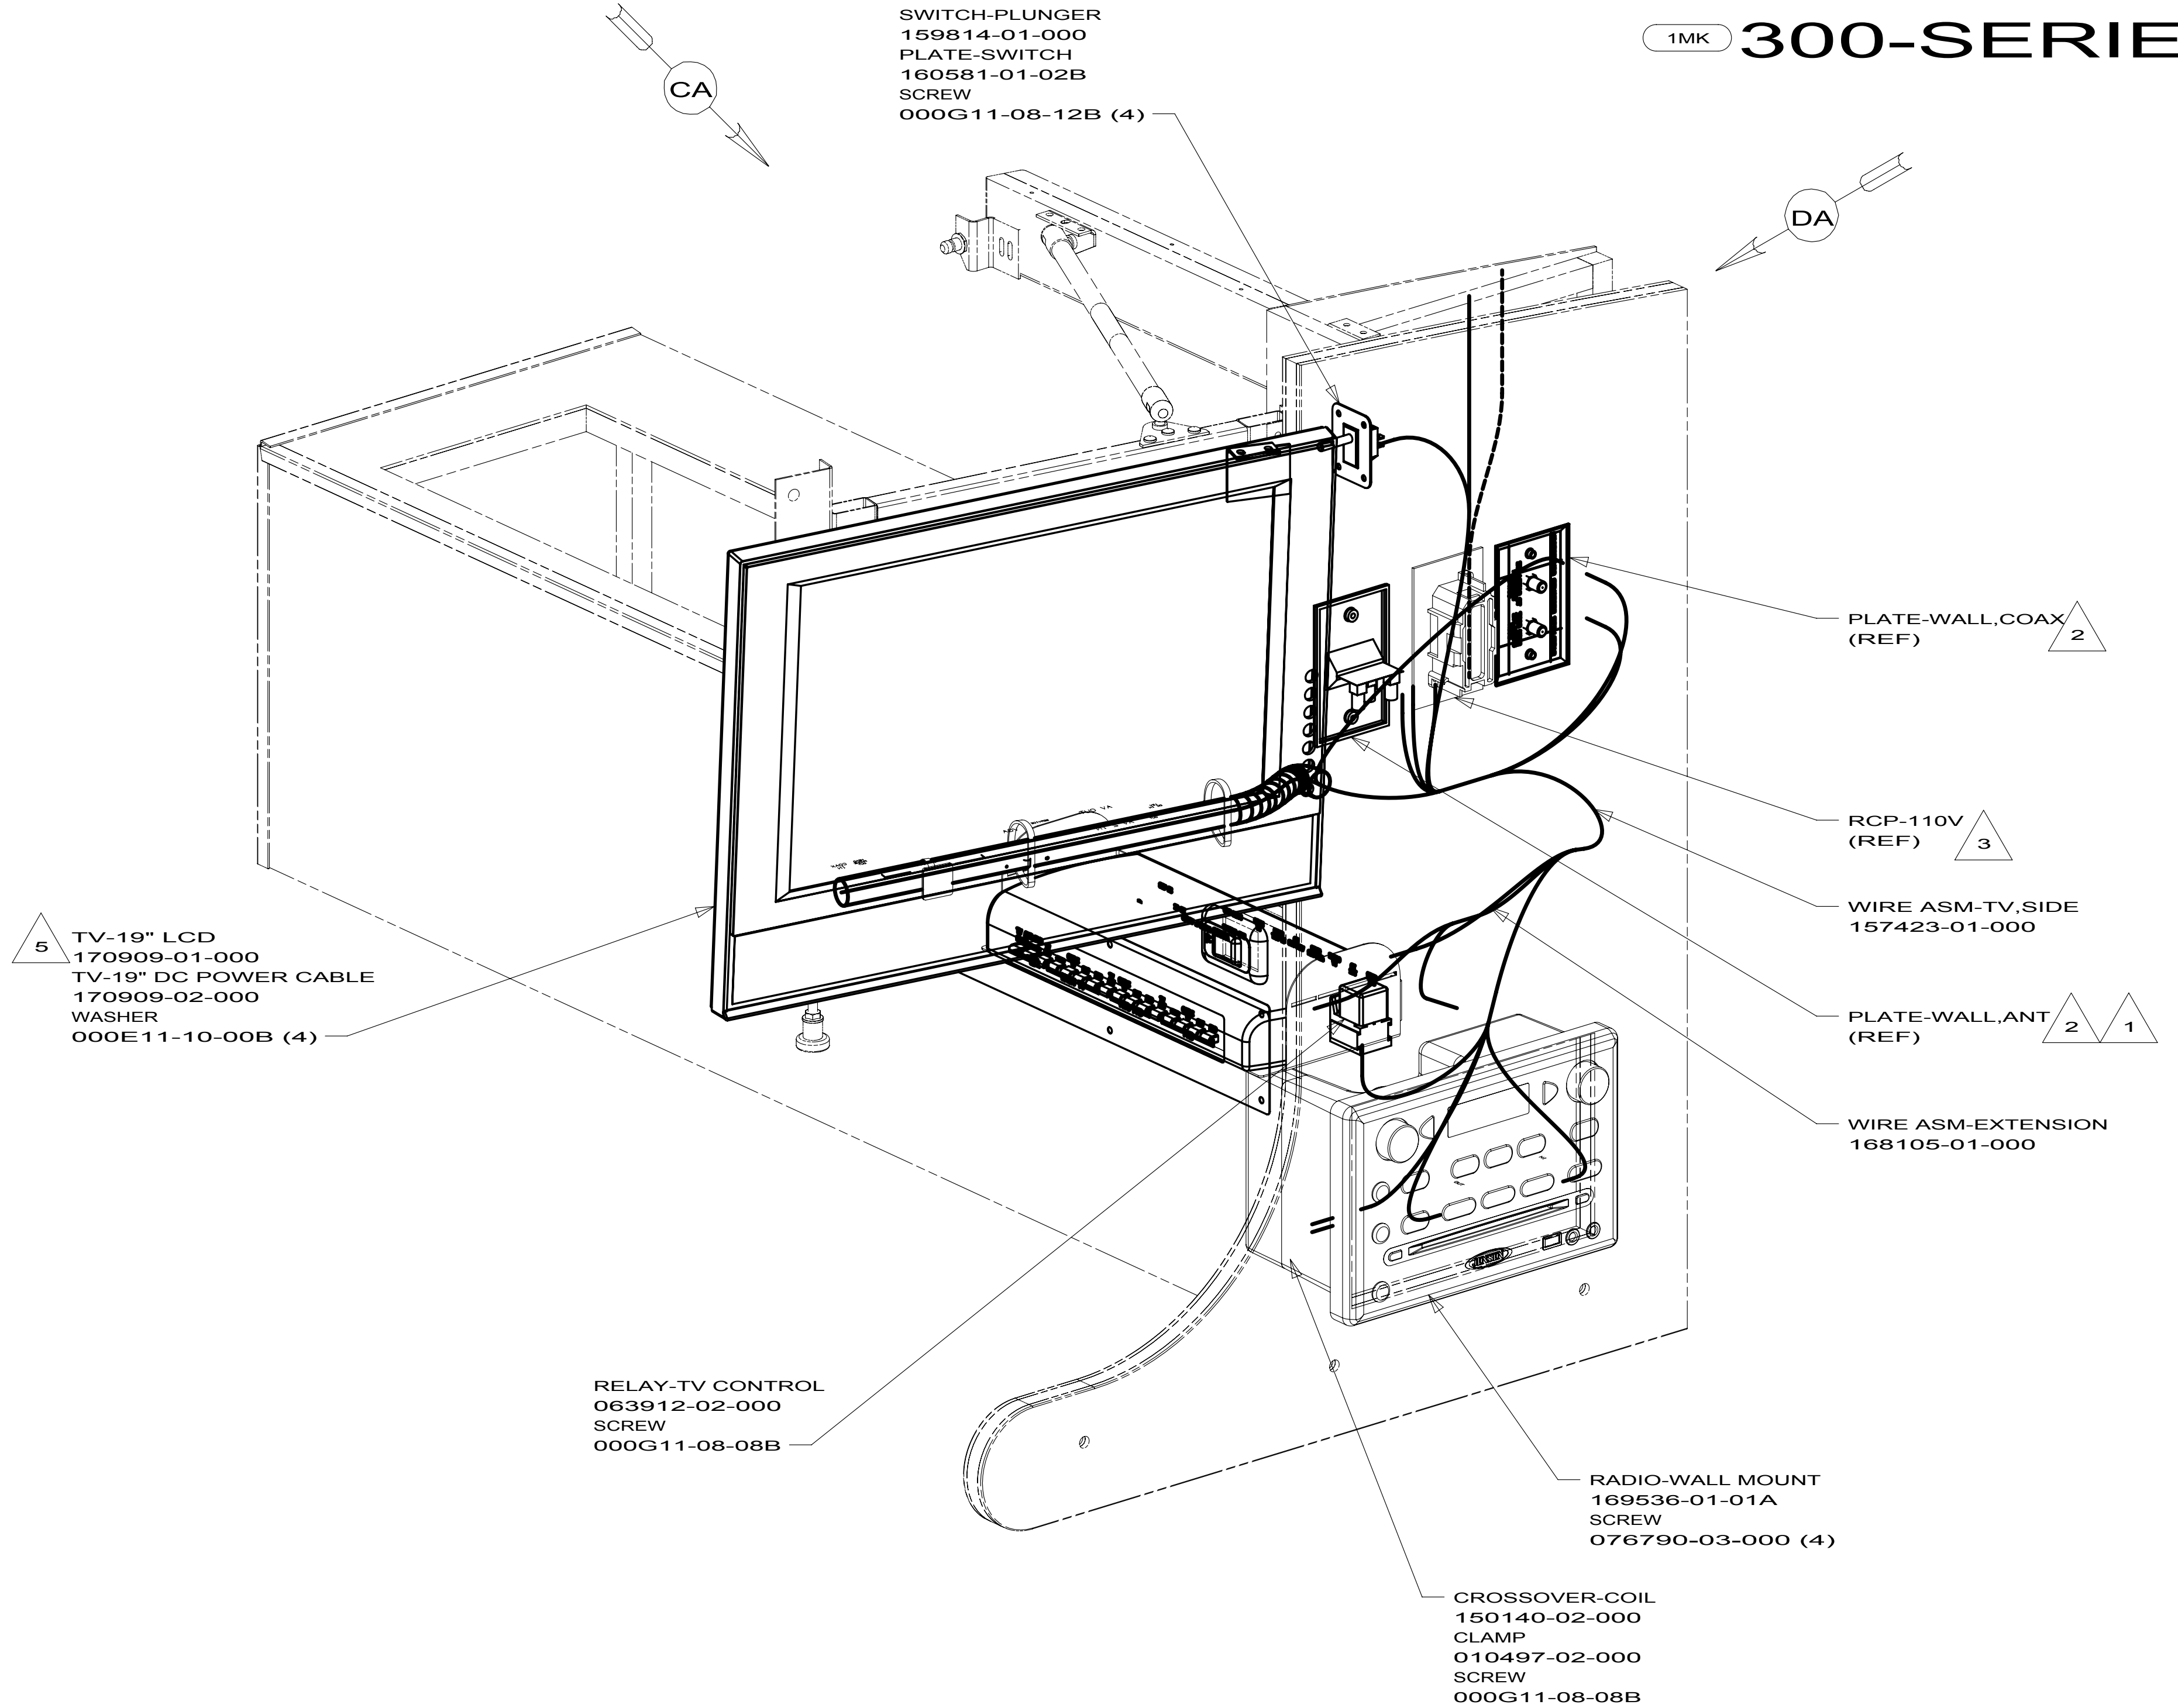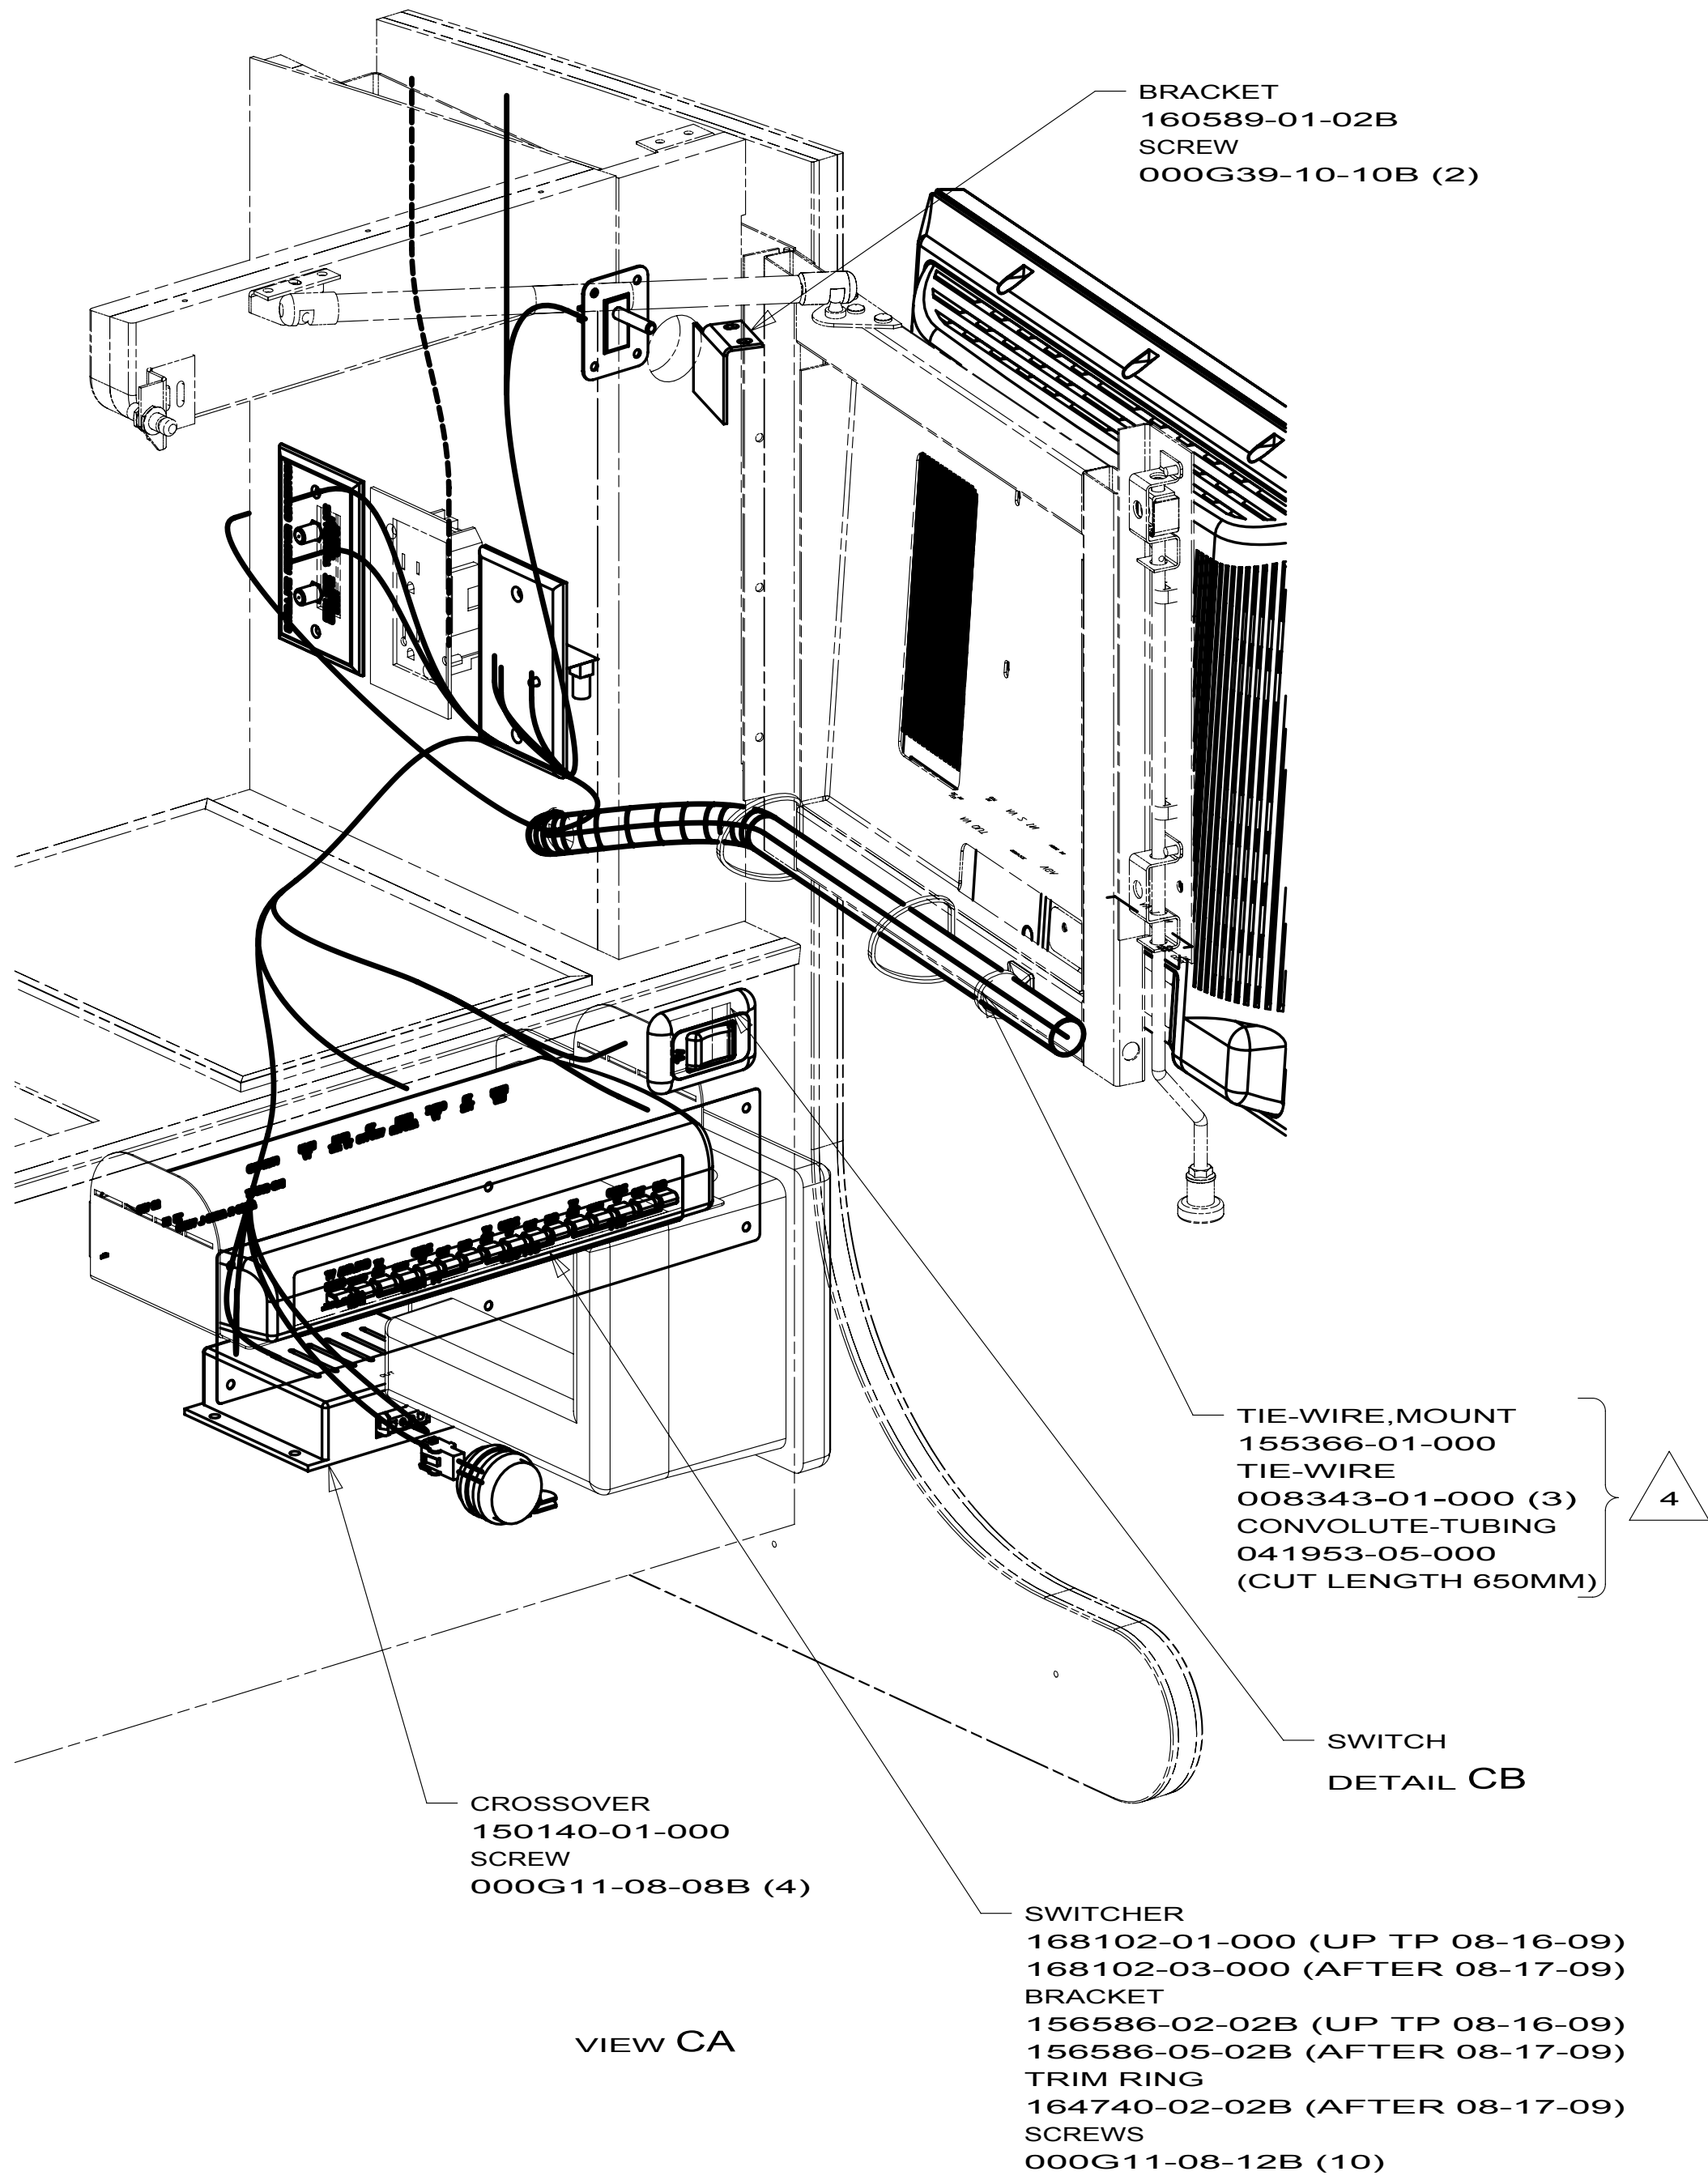


5 USE SCREWS SUPPLIED WITH TV.

4 COVER WIRES, COAX, AND RCA-CABLES THAT ARE ROUTED TO THE TV WITH CONVOLUTE-TUBING AND SECURE TO TV-SUPPORT WITH TIE-WIRE.
3 SEE WIRING INSTL-BODY, 110V FOR ADDITIONAL INFORMATION.

2 SEE WIRING INSTL-BODY, 12V FOR ADDITIONAL INFORMATION.

1 NOT USED WITH 1MK

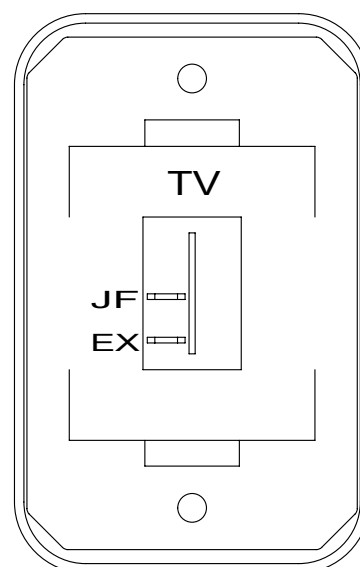

DETAIL CB

SWITCH-ROCKER
135740-01-01A
SWITCH-BASE
135741-01-01A
SWITCH-BEZEL
135742-45-02A
SCREW
000G11-08-08B (2)

FOR ELECTRICAL
TORQUE
SPECIFICATIONS
SEE DWG NO.
128783-01-000

FOR ELECTRICAL
CALLOUTS
SEE DWG NO.
121339-01-000

1MK TV-19"DC, STEREO SYS, VDEO SEL

265 CODES/STANDARDS-CSA/CMVSS


1B1 CODES/STANDARDS USA

1B1 265 1MK

10 300-SERIES



WIRING INSTL-TV/DVD

1MK 300-SERIES

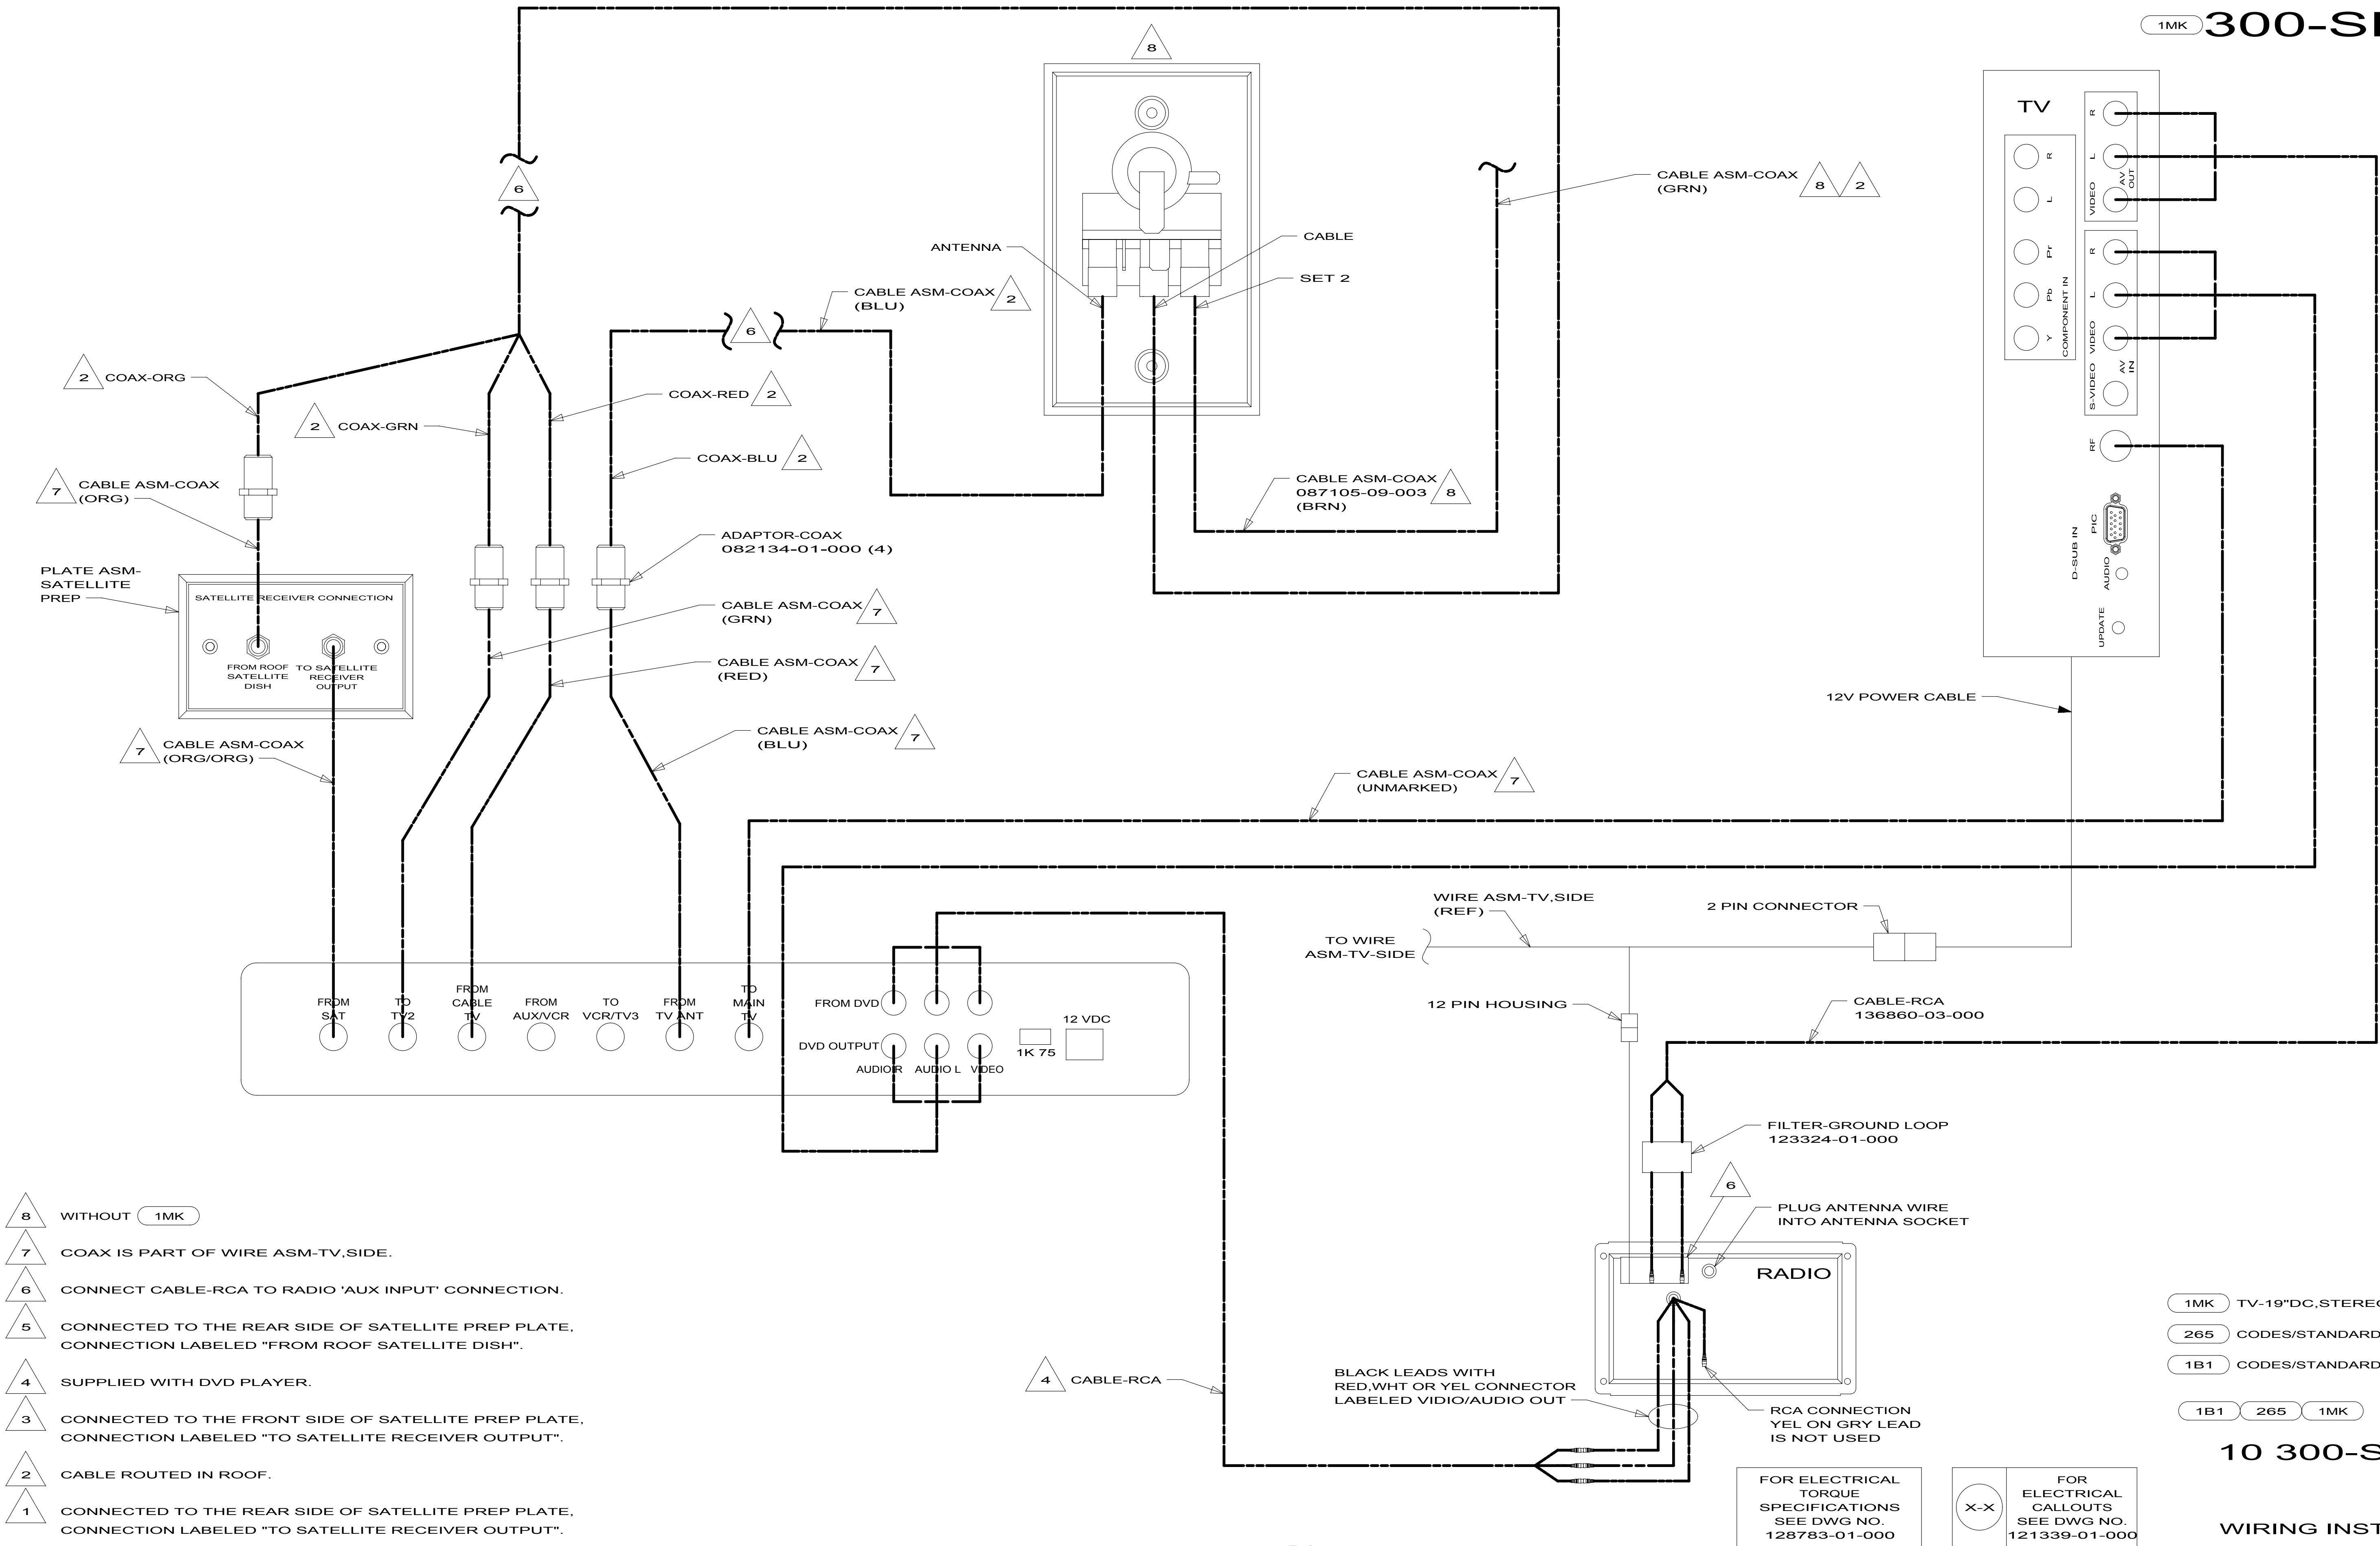

NOTES:

DETAIL DA

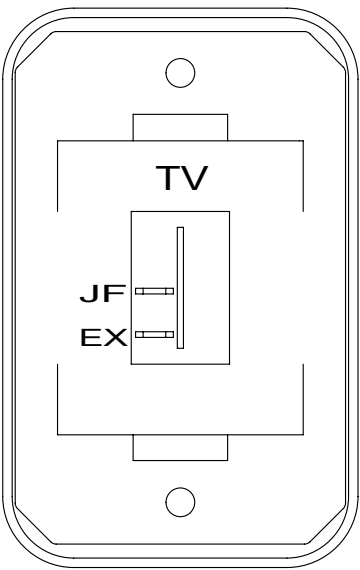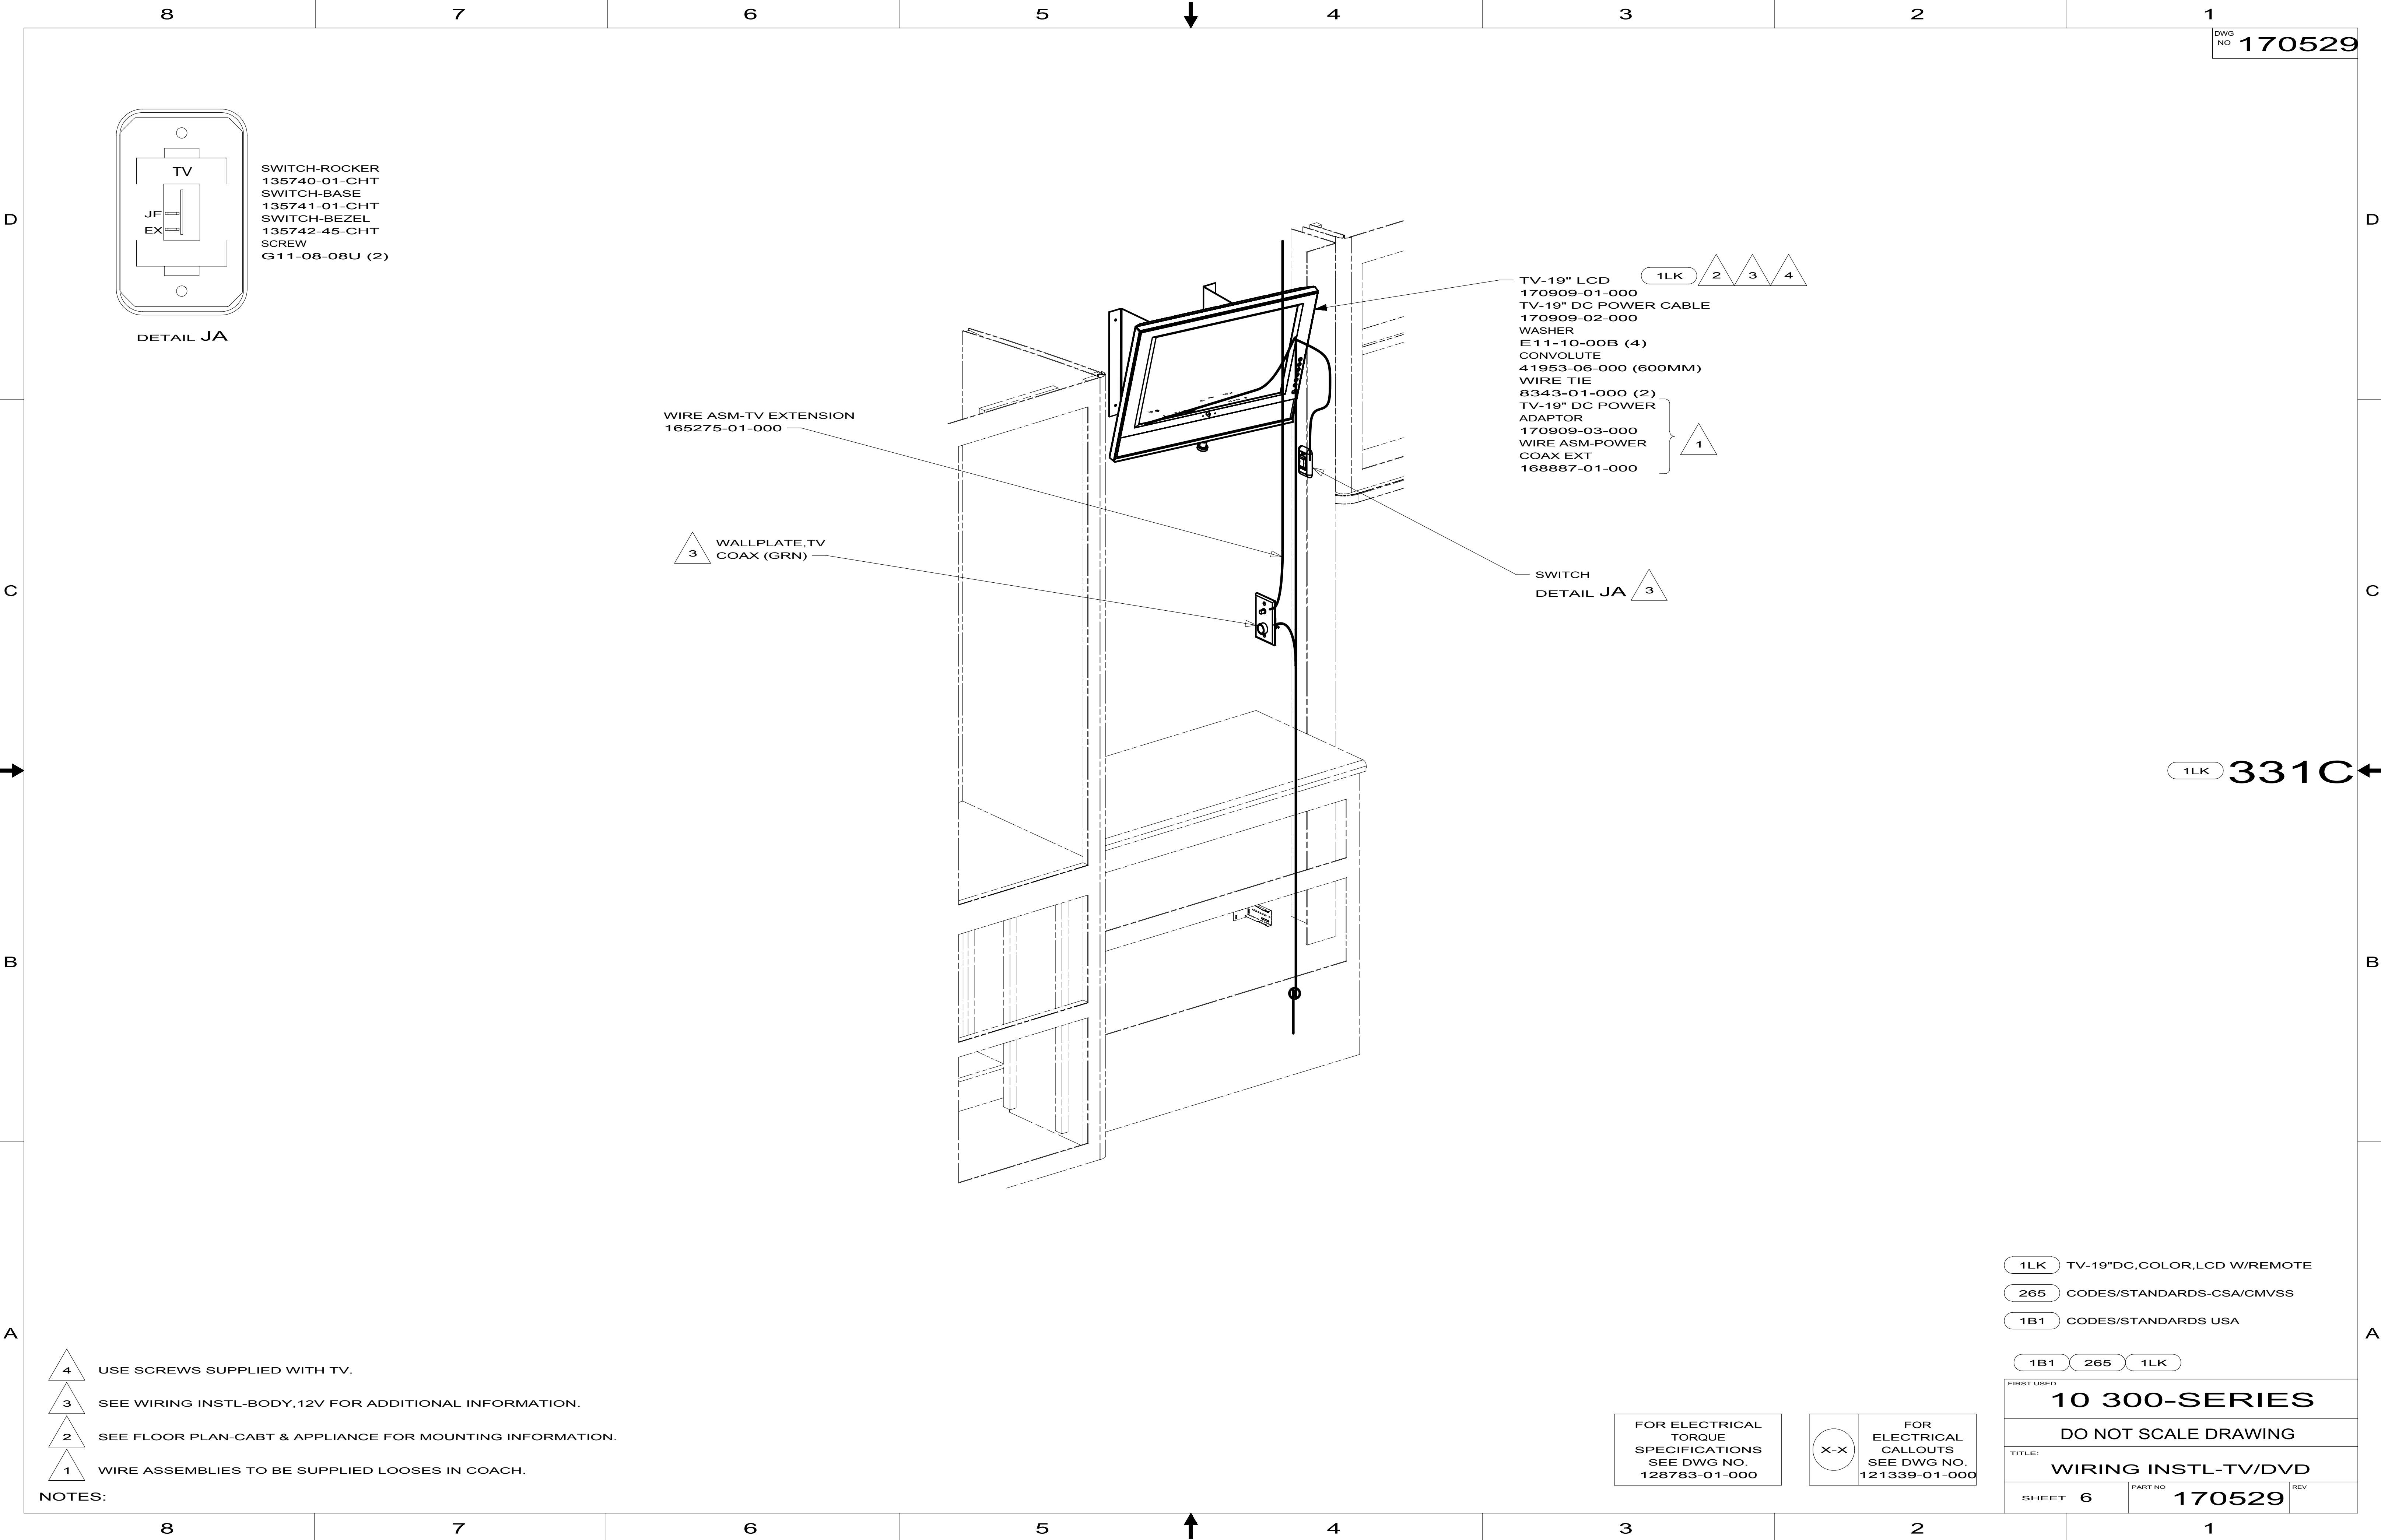

DETAIL JA

- SWITCH-ROCKER
- 135740-01-CHT
- SWITCH-BASE
- 135741-01-CHT
- SWITCH-BEZEL
- 135742-45-CHT
- SCREW
- G11-08-08U (2)

WIRE ASM-TV EXTENSION
165275-01-000

3 WALLPLATE,TV
COAX (GRN)

- TV-19" LCD
- 170909-01-000
- TV-19" DC POWER CABLE
- 170909-02-000
- WASHER
- E11-10-00B (4)
- CONVOLUTE
- 41953-06-000 (600MM)
- WIRE TIE
- 8343-01-000 (2)
- TV-19" DC POWER
- ADAPTOR
- 170909-03-000
- WIRE ASM-POWER
- COAX EXT
- 168887-01-000

SWITCH
DETAIL JA

- 4 USE SCREWS SUPPLIED WITH TV.
- 3 SEE WIRING INSTL-BODY,12V FOR ADDITIONAL INFORMATION.
- 2 SEE FLOOR PLAN-CABT & APPLIANCE FOR MOUNTING INFORMATION.
- 1 WIRE ASSEMBLIES TO BE SUPPLIED LOOSES IN COACH.

NOTES:

FOR ELECTRICAL
TORQUE
SPECIFICATIONS
SEE DWG NO.
128783-01-000

FOR
ELECTRICAL
CALLOUTS
SEE DWG NO.
121339-01-000

- 1LK TV-19"DC,COLOR,LCD W/REMOTE
- 265 CODES/STANDARDS-CSA/CMVSS
- 1B1 CODES/STANDARDS USA

1B1 265 1LK

FIRST USED
10 300-SERIES

DO NOT SCALE DRAWING

TITLE:
WIRING INSTL-TV/DVD

SHEET **6** PART NO **170529** REV

KEY	PART NUMBER	U/M	DESCRIPTION
	164270-01-700	EA	REMOTE

164270-01-000
VENDOR NO.
STS2891REM

KEY	PART NUMBER	U/M	DESCRIPTION
	169154-01-700	EA	REMOTE - TV

169151-01-000, 169151-02-000
VENDOR NO.
RRMCGA667WJSA

KEY	PART NUMBER	U/M	DESCRIPTION	VENDOR NO.
	169536-01-700	EA	REMOTE - SERVICE PACK	PSVCAWM970

KEY	PART NUMBER	U/M DESCRIPTION	VENDOR NO.
	170909-01-700	EA REMOTE - SERVICE PACK	PSVCJE1909

KEY	PART NUMBER	U/M DESCRIPTION	173514-01-000, 173514-02-000
	173514-01-700	EA REMOTE	VENDOR NO. 272041

KEY	PART NUMBER	U/M DESCRIPTION	VENDOR NO.
	173556-01-700	EA REMOTE - SERVICE PACK	PSVCJE3208